


three inches = one foot
one and one half inches = one foot
one inch = one foot
three quarters inch = one foot
one half inch = one foot
three eighths inch = one foot
one quarter inch = one foot
one eighth inch = one foot

- NOTES**
- REFER TO SPECIFICATION SECTION 010000 FOR REQUIREMENTS REGARDING PRE-CONSTRUCTION INVESTIGATION PRIOR TO COMMENCEMENT OF WORK. CONTRACTOR TO CONDUCT A COMPLETE SURVEY OF EVERY FIRE PROTECTION SPRINKLER HEAD TO ASSESS EACH HEAD'S CONDITION AND VIABILITY.
 - UPON COMPLETION OF THE ABOVE SURVEY, THE VAMC COR SHALL DESIGNATE UP TO 240 HEADS TO BE REPLACED/REWORKED BY THE CONTRACTOR UNDER THIS CONTRACT.
 - THE 240 HEADS DESIGNATED BY THE VAMC COR LISTED ABOVE ARE IN ADDITION TO ANY SPECIFIC ITEMS INDICATED ON THIS SHEET.

- KEYED NOTES**
- REWORK EXISTING SPRINKLER HEADS AND PIPING PER CODE IN ROOMS GA08B, GB05B, GB05D, AND GC14C.
 - CORRECT SPRINKLER HEAD SPACING/PLACEMENT TO COMPLY WITH CODE. ADD AND/OR RESPACE AND RELOCATE HEADS AS REQUIRED. INSTALL ADDITIONAL HEADS UNDER ALL DUCTWORK AND OBSTRUCTIONS OVER 48" A.F.F. PER NFPA13 IN ROOMS GA03, GA11, AND GA18.


LEGEND

AREA APPLIED TO THIS PORTION OF PROJECT

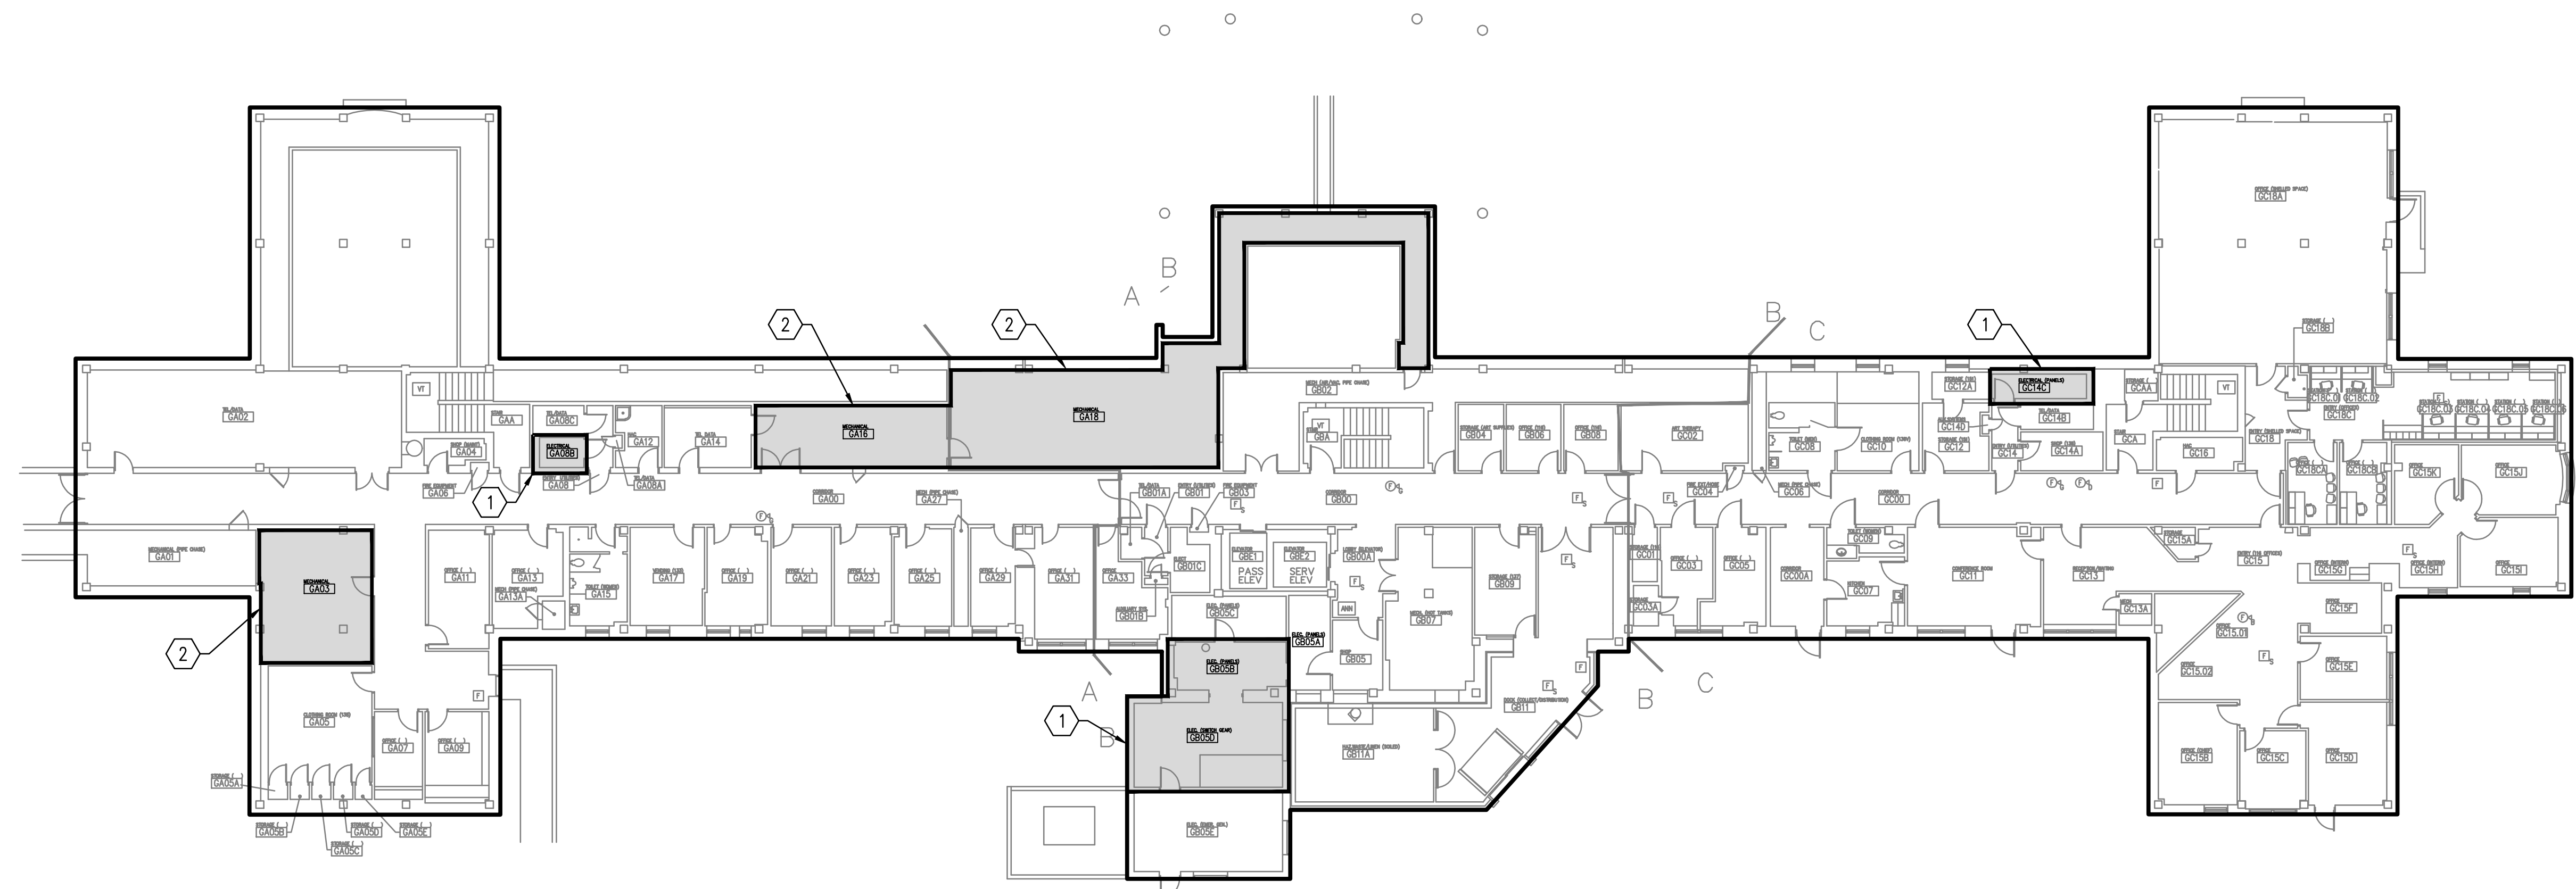

E1 FLOOR PLAN
1/16" = 1'-0"

GENERAL NOTE:
ALL EXISTING PIPING, DUCTWORK, SPRINKLERS, CONDUIT, LIGHTING OR OTHER CONSTRUCTION SHALL BE RELOCATED AS NECESSARY FOR ALL DEMOLITION AND INSTALLATION WORK.

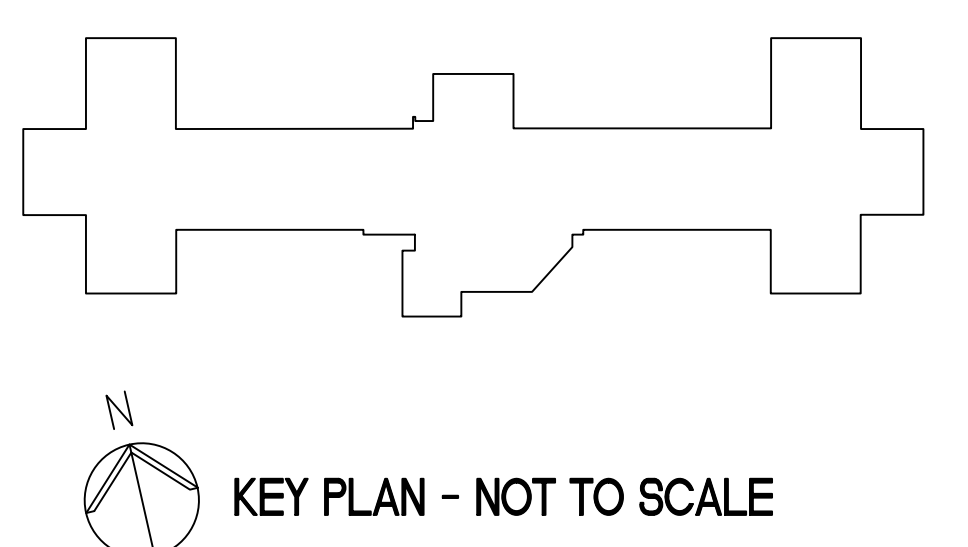

FULLY SPRINKLERED
BID DOCUMENTS
FOR CONSTRUCTION

AMENDMENT #3 Revisions		5/20/14 Date		ARCHITECT/ENGINEERS: PARADIGM ENGINEERS AND CONSTRUCTORS 200 Envoy Circle #201, Louisville KY 40299 - PH: 502.339.8511 - www.paradigmusa.com		Drawing Title: FIRE PROTECTION PLAN - GROUND FLOOR BUILDING 3		Project Title: FIRE SAFETY UPGRADES		Project Number: 660-14-104 Building Number: 3		Office of Construction and Facilities Management Department of Veterans Affairs	
Approved Project Director		Date: 12-19-2013		Checked: KLP		Drawn: JDM		Location: GEORGE E WAHLEN VAMC 500 FOOTHILL DR. SALT LAKE CITY, UT		Drawing Number: 3.FX100			