


three inches = one foot  
one and one half inches = one foot  
one inch = one foot  
three quarters inch = one foot  
one half inch = one foot  
one quarter inch = one foot  
three eighths inch = one foot  
one eighth inch = one foot

- NOTES**
1. REFER TO SPECIFICATION SECTION 010000 FOR REQUIREMENTS REGARDING PRE-CONSTRUCTION INVESTIGATION PRIOR TO COMMENCEMENT OF WORK. CONTRACTOR TO CONDUCT A COMPLETE SURVEY OF EVERY FIRE PROTECTION SPRINKLER HEAD TO ASSESS EACH HEAD'S CONDITION AND VIABILITY.
  2. UPON COMPLETION OF THE ABOVE SURVEY, THE VAMC COR SHALL DESIGNATE UP TO 240 HEADS TO BE REPLACED/REWORKED BY THE CONTRACTOR UNDER THIS CONTRACT.
  3. THE 240 HEADS DESIGNATED BY THE VAMC COR LISTED ABOVE ARE IN ADDITION TO ANY SPECIFIC ITEMS INDICATED ON THIS SHEET.


- KEYED NOTES**
- ① REWORK EXISTING SPRINKLER HEADS AND PIPING PER CODE IN ROOMS 1A17D, 1B01C, AND 1C18B.

- LEGEND**
- AREA APPLIED TO THIS PORTION OF PROJECT
- THIS AREA IS WITHIN AN ONGOING PROJECT THAT INCLUDES FIRE PROTECTION UPGRADE.

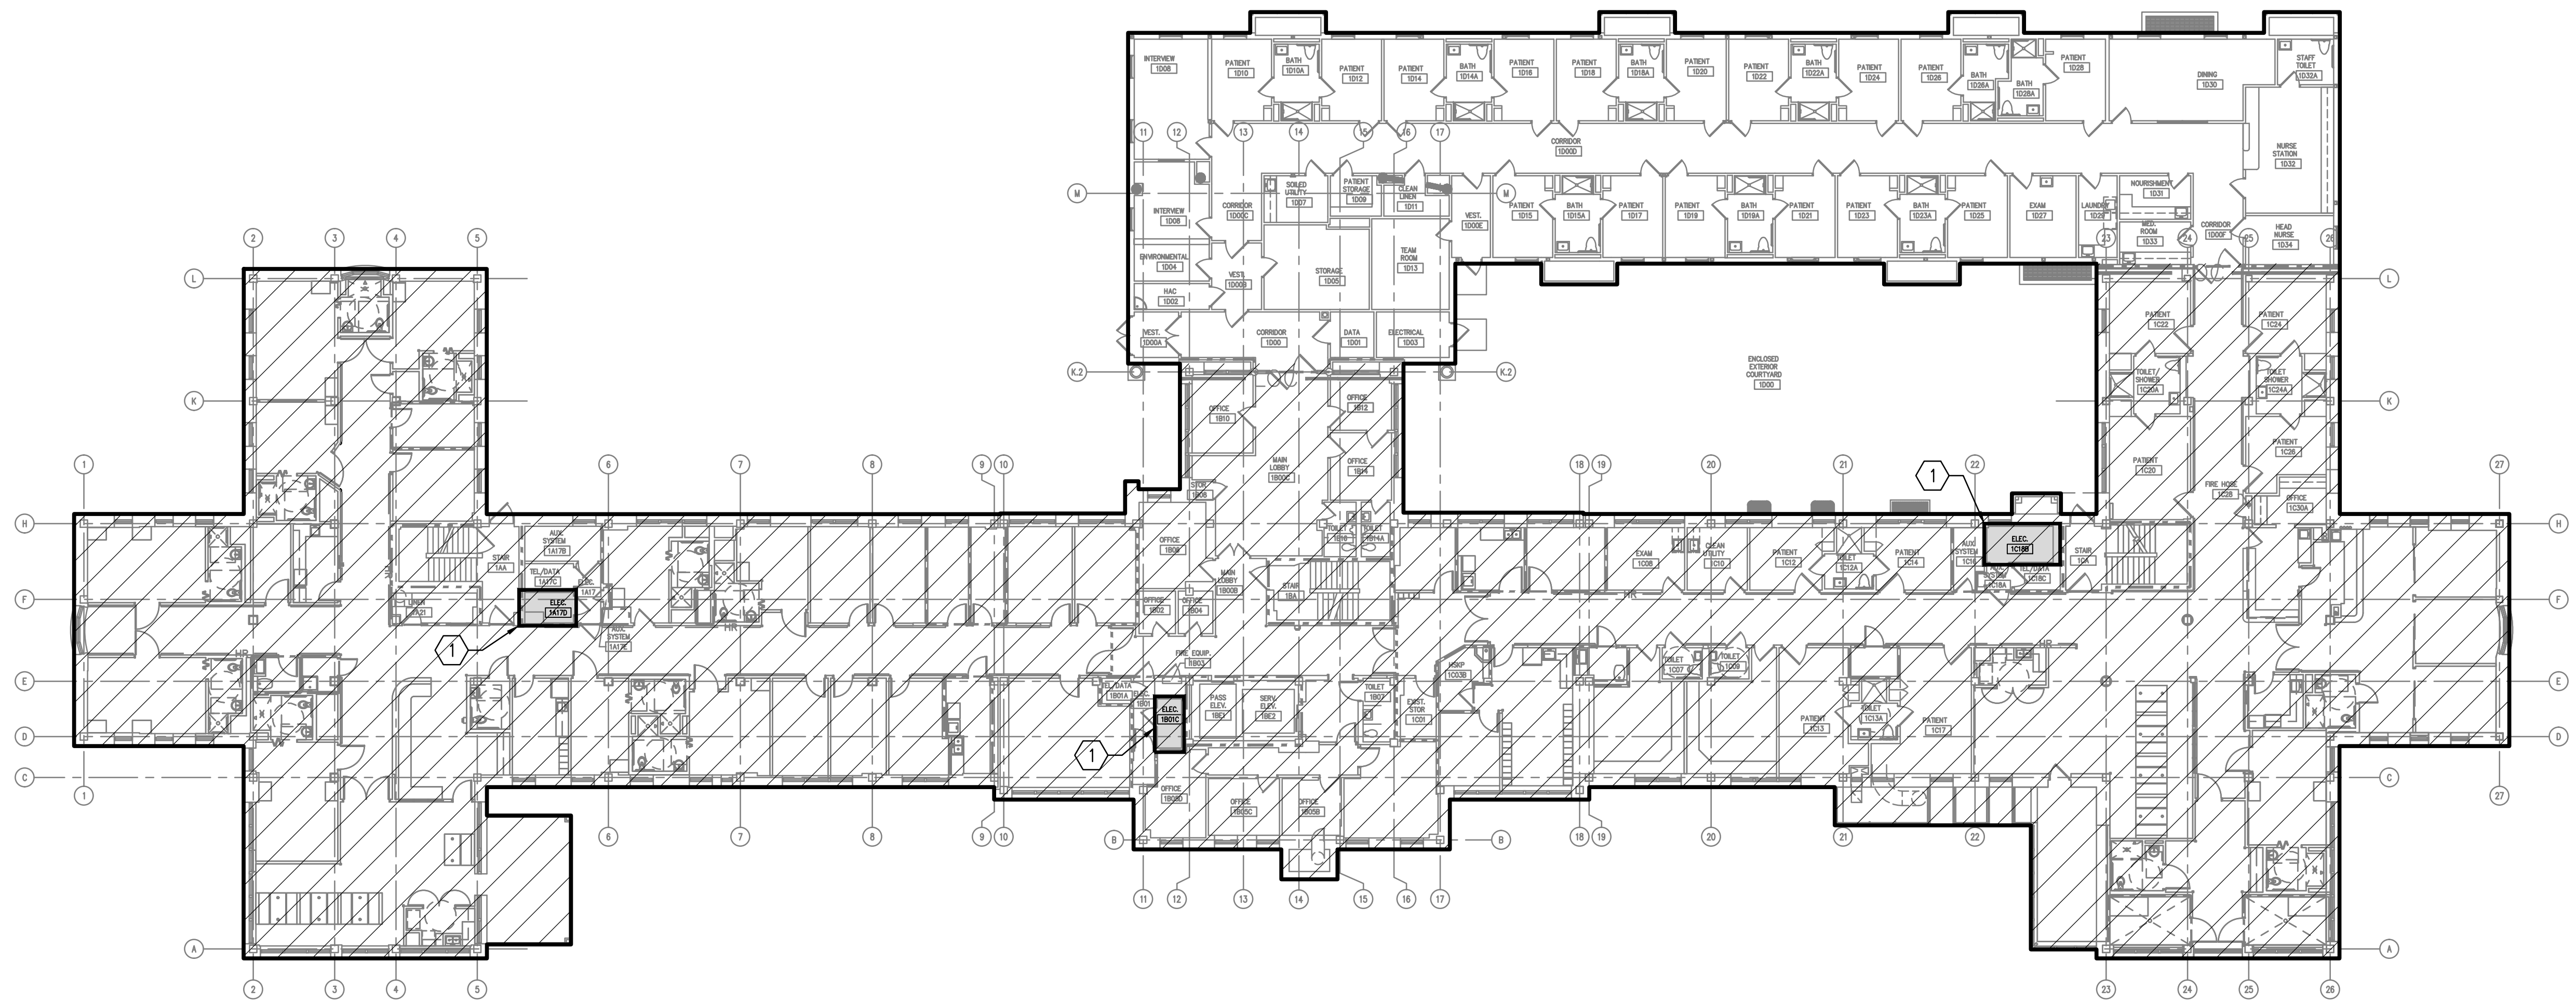

E1 FLOOR PLAN  
1/16" = 1'-0"

**GENERAL NOTE:**  
ALL EXISTING PIPING, DUCTWORK, SPRINKLERS, CONDUIT, LIGHTING OR OTHER CONSTRUCTION SHALL BE RELOCATED AS NECESSARY FOR ALL DEMOLITION AND INSTALLATION WORK.

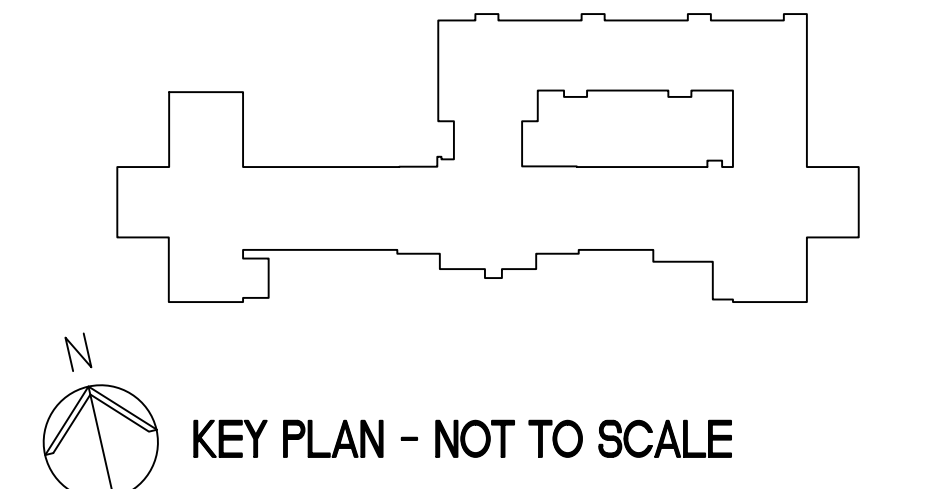

FULLY SPRINKLERED  
BID DOCUMENTS  
FOR CONSTRUCTION

AMENDMENT #3 Revisions		5/20/14 Date		ARCHITECT/ENGINEERS: <b>PARADIGM</b> ENGINEERS AND CONSTRUCTORS 200 Envoy Circle #201, Louisville KY 40299 - PH: 502.339.8511 - www.paradigmusa.com		Drawing Title: FIRE PROTECTION PLAN - FIRST FLOOR BUILDING 3		Project Title: FIRE SAFETY UPGRADES		Project Number: 660-14-104 Building Number: 3		Office of Construction and Facilities Management Department of Veterans Affairs	
Approved Project Director		Date: 12-19-2013		Checked: KLP		Drawn: JDM		Location: GEORGE E WAHLEN VAMC 500 Foothill Dr. SALT LAKE CITY, UT		Drawing Number: 3.FX101			