



Department of Veterans Affairs

GEORGE E. WHALEN VAMC

500 FOOTHILL DRIVE, SALT LAKE CITY, UT 84148

PROJECT 660-14-104

FIRE SAFETY UPGRADES




200 Envoy Circle Suite #201, Louisville, KY 40299 – PH: 502.339.8511 – www.paradigmusa.com

INDEX OF DRAWINGS

GENERAL	
GI001	COVER SHEET
GI100	ICRA AND SAFETY ASSESSMENT – BUILDINGS 1, 3, 6, AND 14
GS101	OVERALL SITE PLAN
BUILDING 1:	
1.AE100	FIRE BARRIER PLAN – GROUND FLOOR – BUILDING 1
1.AE101A	FIRE BARRIER PLAN – FIRST FLOOR – BUILDING 1 WEST
1.AE101B	FIRE BARRIER PLAN – FIRST FLOOR – BUILDING 1 EAST
1.AE102	FIRE BARRIER PLAN – SECOND FLOOR – BUILDING 1
1.AE103	FIRE BARRIER PLAN – THIRD FLOOR – BUILDING 1
1.AE104	FIRE BARRIER PLAN – FOURTH FLOOR – BUILDING 1
1.AE601	EXISTING SITE PHOTOS – BUILDING 1
1.FA100	FIRE ALARM PLAN – GROUND FLOOR – BUILDING 1 EAST
1.FA101	FIRE ALARM PLAN – FIRST FLOOR – BUILDING 1 WEST
1.FX100A	FIRE PROTECTION PLAN – GROUND FLOOR – BUILDING 1 WEST
1.FX100B	FIRE PROTECTION PLAN – GROUND FLOOR – BUILDING 1 EAST
1.FX101A	FIRE PROTECTION PLAN – FIRST FLOOR – BUILDING 1 WEST
1.FX101B	FIRE PROTECTION PLAN – FIRST FLOOR – BUILDING 1 EAST
1.FX102	FIRE PROTECTION PLAN – SECOND FLOOR – BUILDING 1
1.FX103	FIRE PROTECTION PLAN – THIRD FLOOR – BUILDING 1
1.FX104	FIRE PROTECTION PLAN – FOURTH FLOOR – BUILDING 1
1.FX105	FIRE PROTECTION PLAN – FIFTH FLOOR – BUILDING 1
1.FX601	FIRE PROTECTION EXISTING SITE PHOTOS – BUILDING 1
BUILDING 14:	
14.FA100G	FIRE ALARM PLAN – GROUND FLOOR – BUILDING 14
14.FX100B	FIRE PROTECTION PLAN – BASEMENT – BUILDING 14
14.FX100G	FIRE PROTECTION PLAN – GROUND FLOOR – BUILDING 14
14.FX101	FIRE PROTECTION PLAN – FIRST FLOOR – BUILDING 14
14.FX102	FIRE PROTECTION PLAN – SECOND FLOOR – BUILDING 14
14.FX103	FIRE PROTECTION PLAN – THIRD FLOOR – BUILDING 14
14.FX104	FIRE PROTECTION PLAN – PENTHOUSE/ROOF – BUILDING 14
BUILDING 3:	
3.FA100	FIRE ALARM PLAN – GROUND FLOOR – BUILDING 3
3.FA101	FIRE ALARM PLAN – FIRST FLOOR – BUILDING 3
3.FX100	FIRE PROTECTION PLAN – GROUND FLOOR – BUILDING 3
3.FX101	FIRE PROTECTION PLAN – FIRST FLOOR – BUILDING 3
3.FX102	FIRE PROTECTION PLAN – SECOND FLOOR – BUILDING 3
BUILDING 6:	
6.FA100	FIRE ALARM PLAN – BASEMENT – BUILDING 6
6.FA101	FIRE ALARM PLAN – FIRST FLOOR – BUILDING 6

PROJECT LOCATION MAP

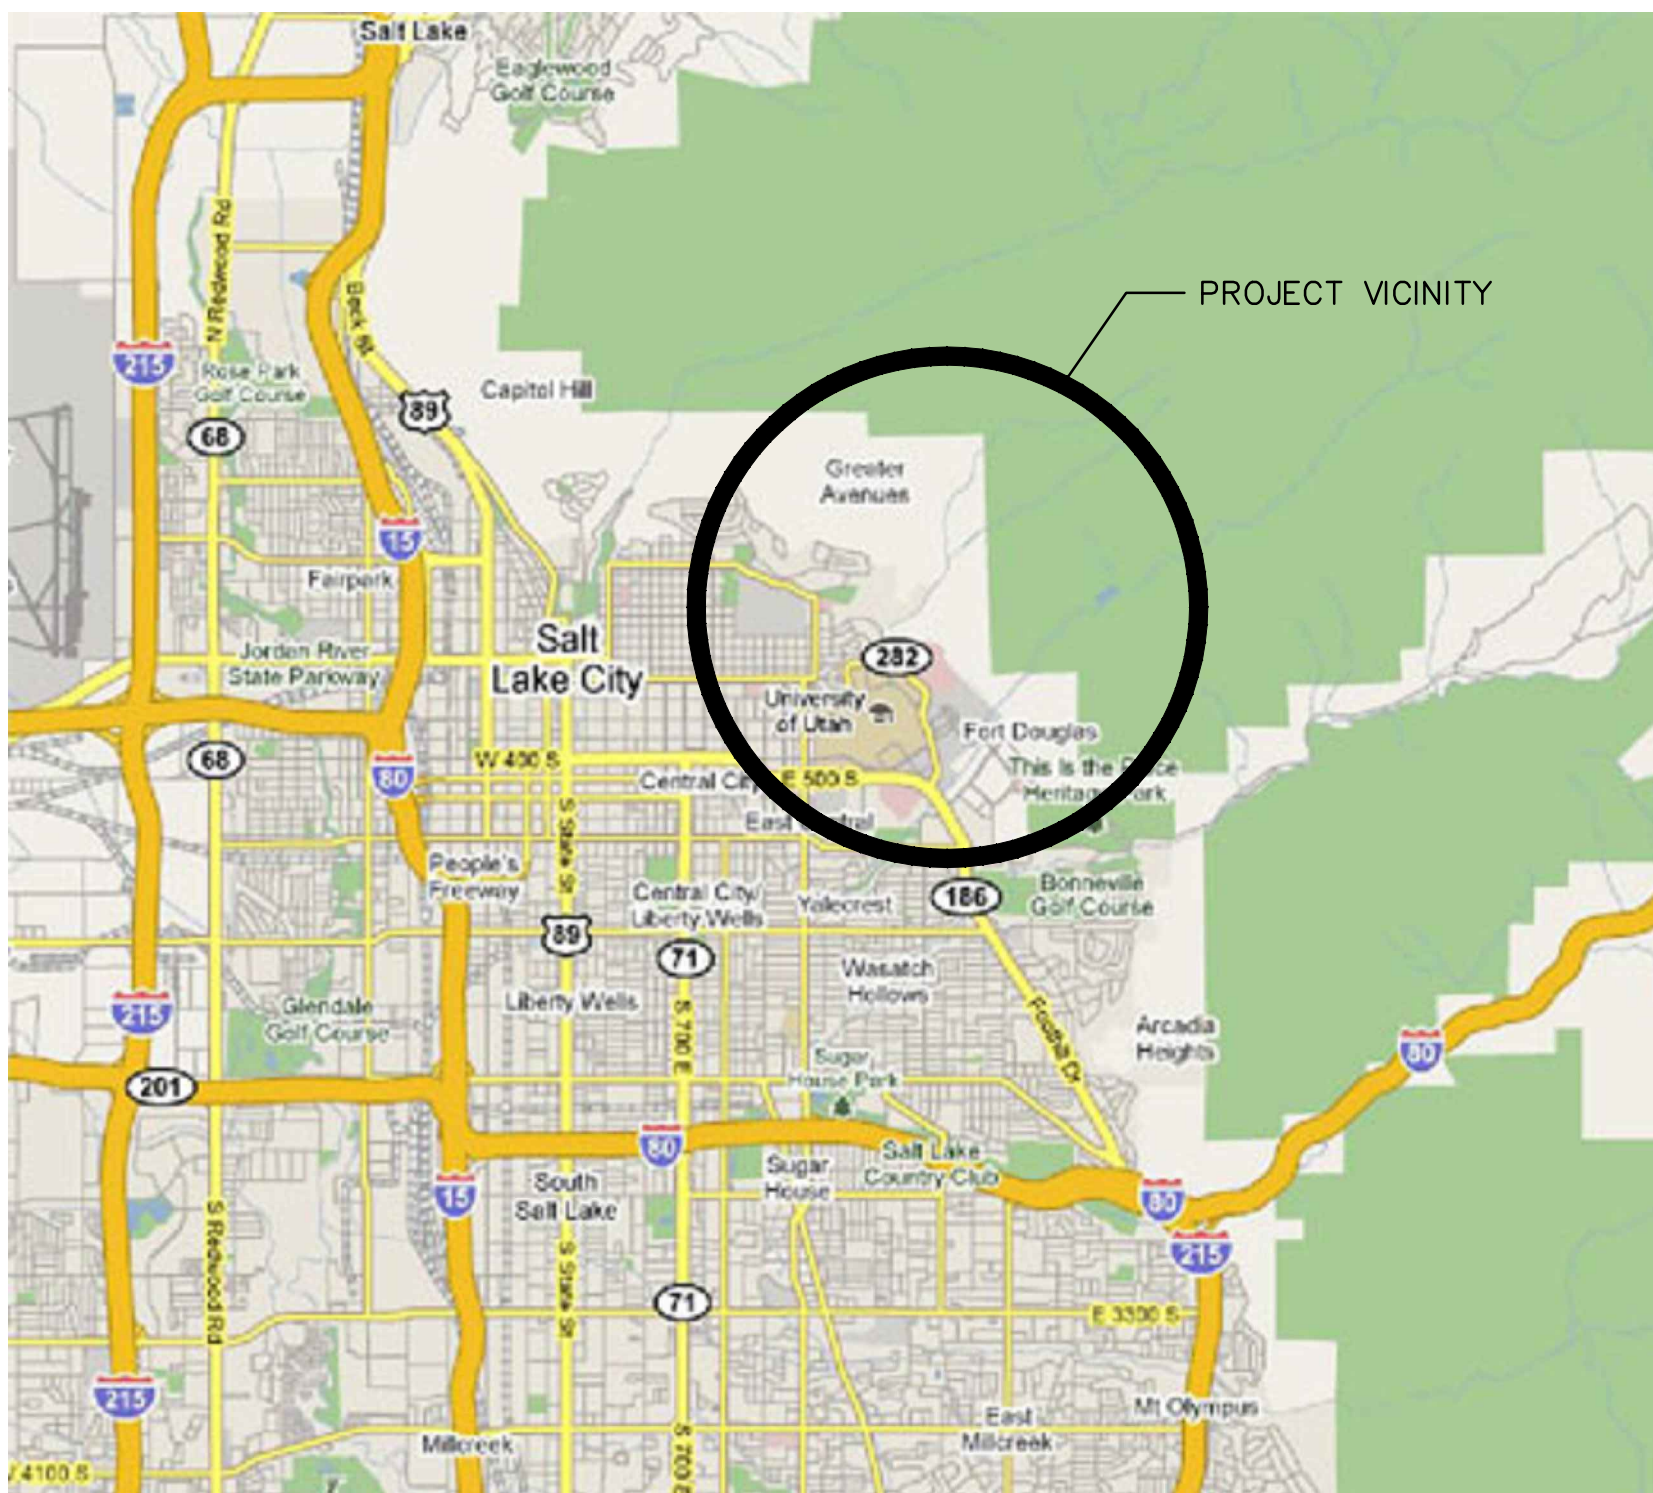

PROJECT SITE MAP



SIGNATURE BLOCK

DIRECTOR	DATE
ASSOCIATE DIRECTOR/ADMINISTRATIVE OPERATIONS	DATE
CHIEF OF STAFF	DATE
ASSOCIATE DIRECTOR/PATIENT SERVICES	DATE
ASSOCIATE DIRECTOR/CLINICAL OPERATIONS	DATE
FINANCIAL MANAGEMENT SERVICES	DATE
ENGINEERING SERVICES	DATE

FULLY SPRINKLERED
BID DOCUMENTS
FOR CONSTRUCTION

ARCHITECT/ENGINEERS:



200 Envoy Circle Suite #201, Louisville, KY 40299 – PH: 502.339.8511 – www.paradigmusa.com

Drawing Title:

COVER SHEET

Approved Project Director

Project Title:

FIRE SAFETY UPGRADES

Location: GEORGE E WHALEN VAMC
500 FOOTHILL DR. SALT LAKE CITY, UT

Date:
12-19-2013

Checked:
KLP

Drawn:
JDM

Project Number:
660-14-104

Building Number:
1, 3, 6, AND 14

Drawing Number:
GI001

Office of
Construction
and Facilities
Management

