



three inches = one foot  
one and one half inches = one foot  
one inch = one foot  
three quarters inch = one foot  
one half inch = one foot  
one quarter inch = one foot  
three eighths inch = one foot  
one eighth inch = one foot

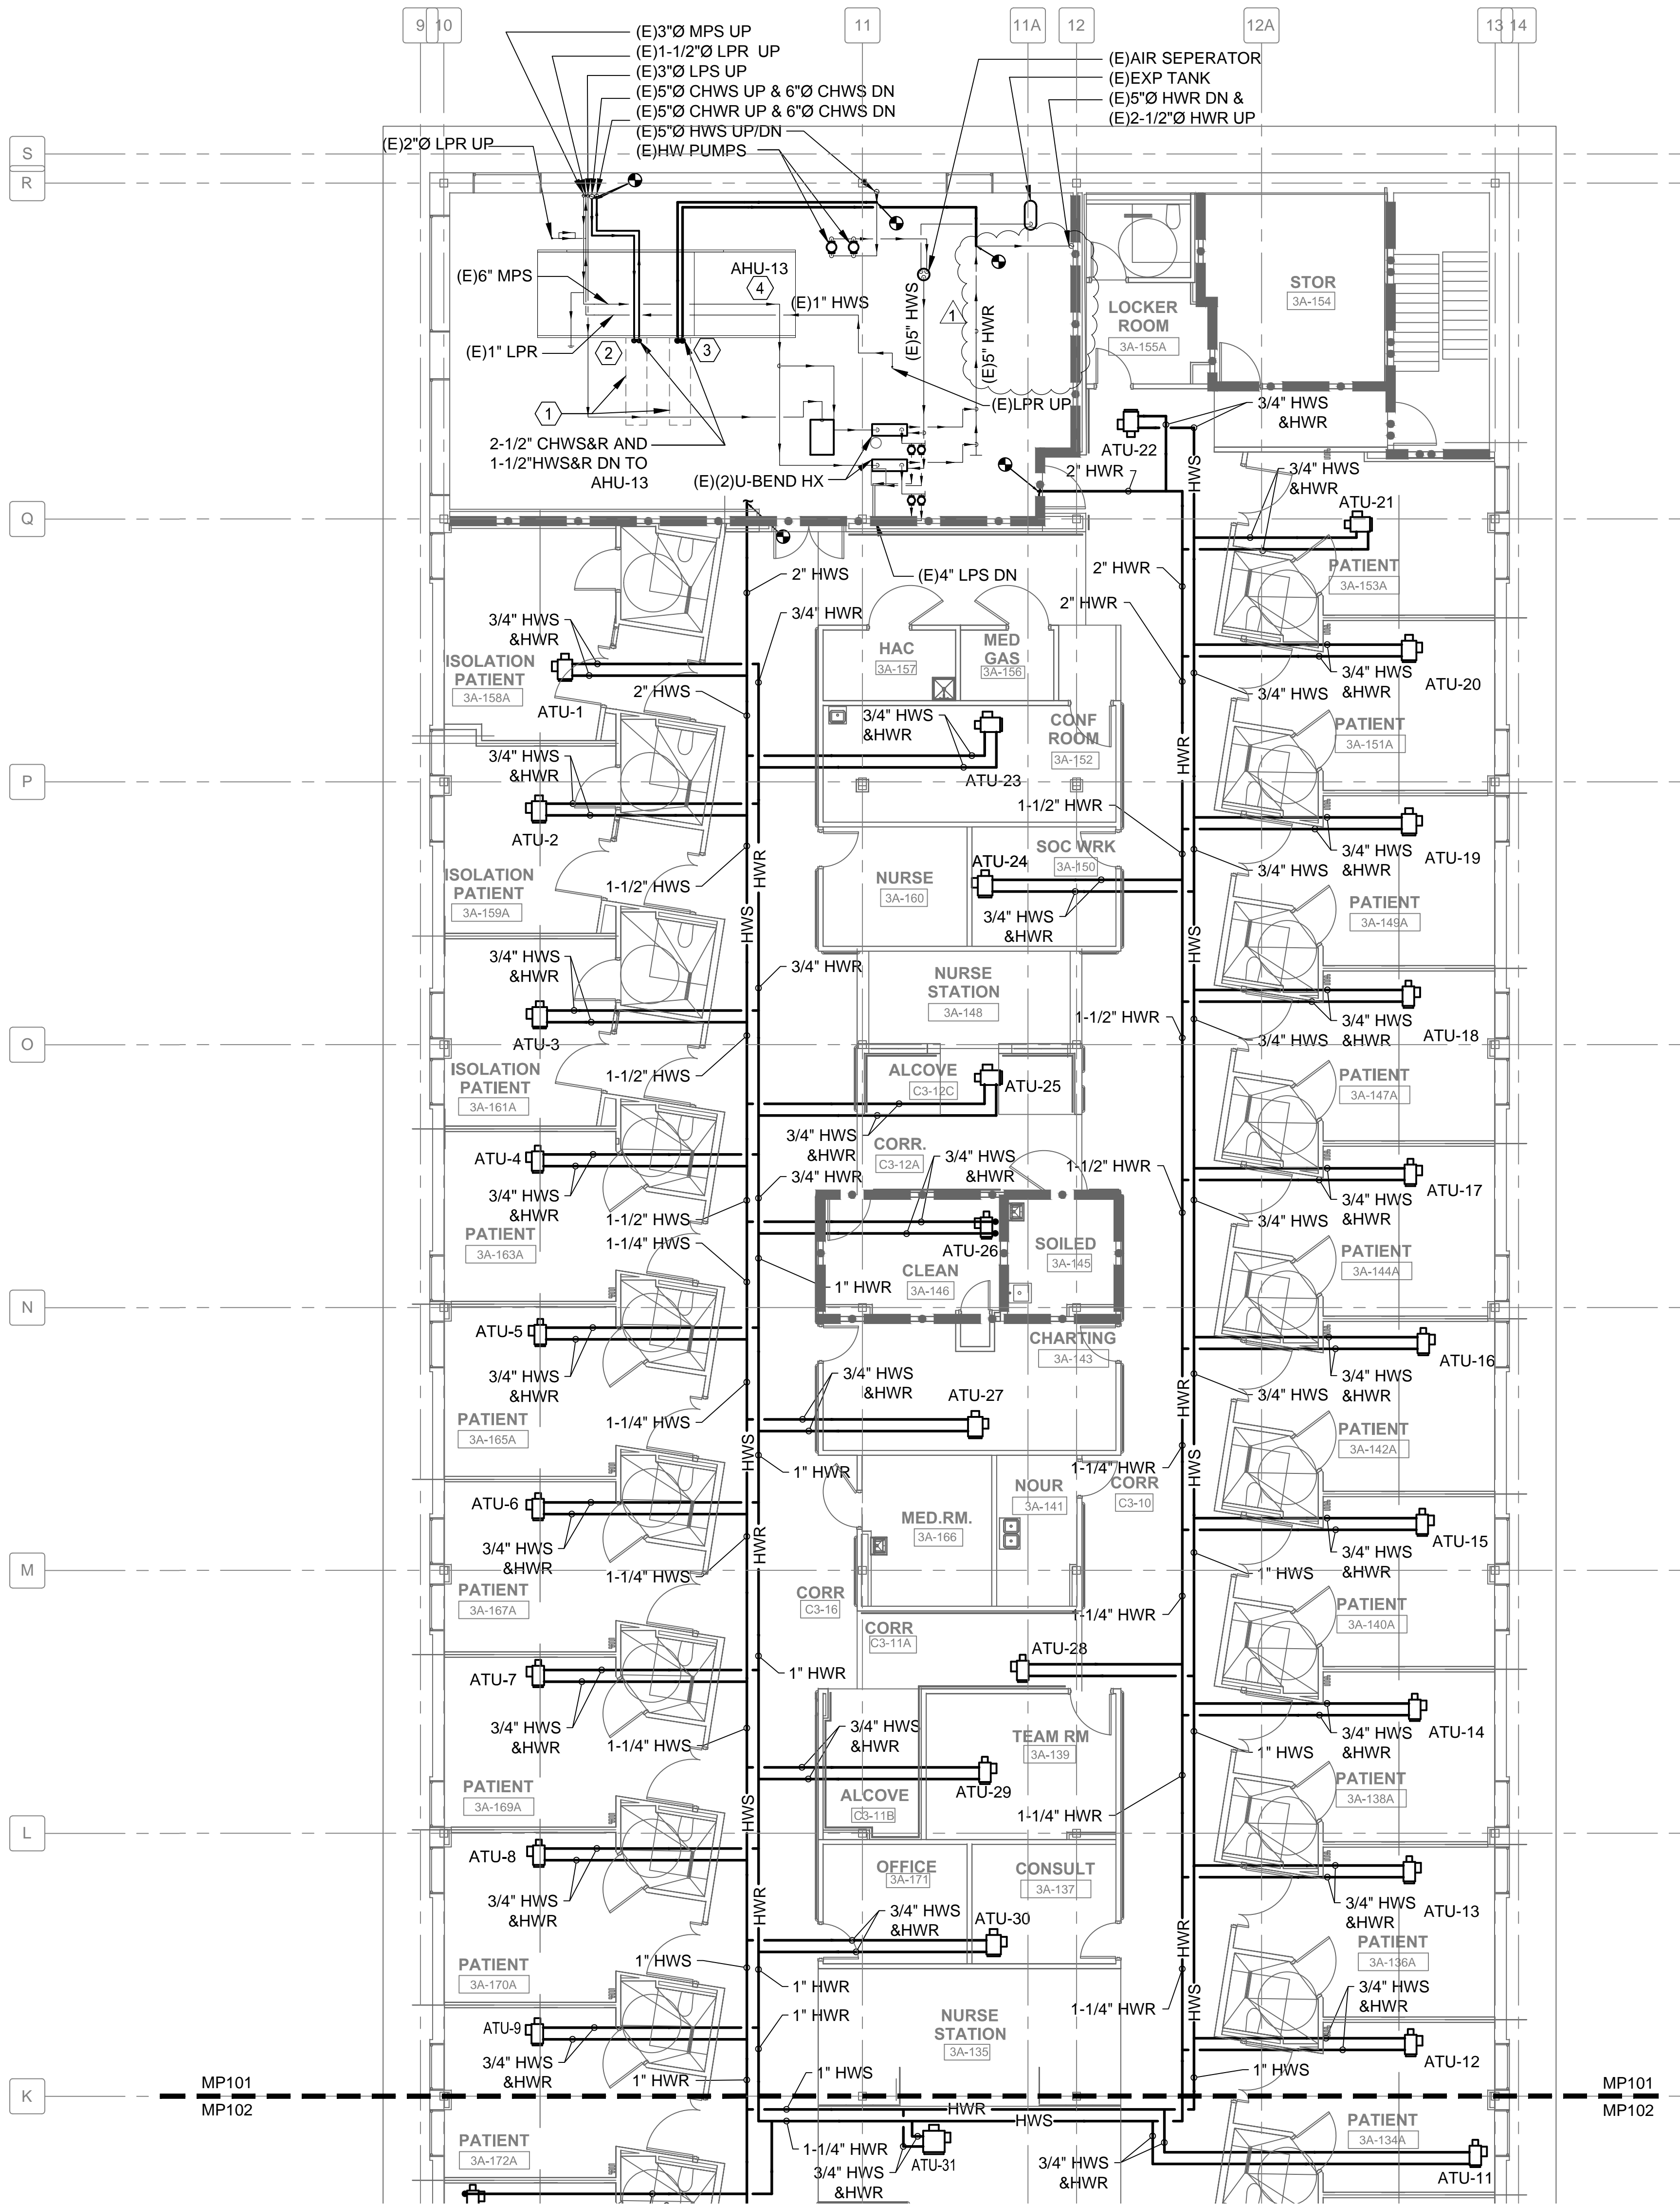

SHEET KEY NOTES	
①	AIR HANDLING UNIT SERVICE CLEARANCE FOR COIL PULL SHOWN AS DASHED LINE FOR REFERENCE.
②	CHILLED WATER SUPPLY AND RETURN LINES DOWN TO AIR HANDLER COIL CONNECTION. REFER PIPING INSTALLATION DETAIL ON SHEET MH502.
③	HOT WATER SUPPLY AND RETURN LINES DOWN TO AIR HANDLER COIL CONNECTION. REFER PIPING INSTALLATION DETAIL ON SHEET MH502.
④	ROUTE CONDENSATE TO FLOOR DRAINS. FIELD VERIFY EXACT LOCATION OF NEAREST DRAIN. REFER TO CONDENSATE TRAP DETAIL ON SHEET MH501.

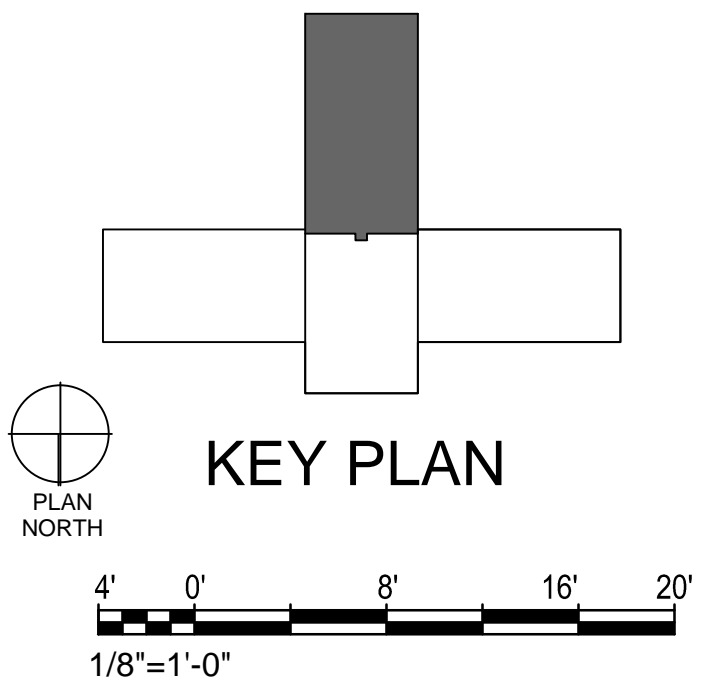

1	ADDENDUM #1	6/4/2014
Revisions:		Date

CONSULTANTS:



ARCHITECT/ENGINEERS:

**BES**  
DESIGN/BUILD

BES DESIGN/BUILD, LLC  
766 Middle St, Fairhope, AL 36532  
Phone: 251.990.5778 Fax: 251.990.3716

Drawing Title  
**MECHANICAL PIPING PLAN  
SOUTH WING**

Approved: Project Director

Project Title  
**RENOVATE MEDICAL SURGICAL  
UNIT**

Location  
**W.J. BRYAN DORN VAMC; COLUMBIA, SC**

Date  
**05-16-2014**

Checked  
**CD**

Drawn  
**CD**

Project Number  
**544-13-102**

Building Number  
**100**

Drawing Number  
**MP101**

Dwg. 55 of 78

OFFICE OF  
CONSTRUCTION  
AND  
FACILITIES  
MANAGEMENT

Department of  
Veterans Affairs