


 



 
 


one eighth inch = one foot
 0 4 8 16
 one quarter inch = one foot
 0 4 8
 three eighths inch = one foot
 0 4
 one half inch = one foot
 0
 three quarters inch = one foot
 0
 one inch = one foot
 0 6" 12" 18" 996" 1000"
 one and one half inches = one foot
 0 6" 12" 18" 996" 1000"
 three inches = one foot
 0 6" 12" 18" 996" 1000"

ELECTRICAL SYMBOL LEGEND	
	SOLID LINE DENOTES CONDUIT RUN CONCEALED IN WALL, ABOVE CEILINGS, EXPOSED IN UNFINISHED AREAS, RUN PARALLEL OR PERPENDICULAR TO STRUCTURE OR WALL. DASHED LINE DENOTES CONDUIT RUN BELOW GRADE OR BELOW FINISHED FLOOR.
	HOMERUN TO PANELBOARD. QUANTITY OF ARROWS INDICATES NUMBER OF CIRCUITS.
	SURFACE, RECESSED, OR WALL MOUNTED LIGHTING FIXTURE CONNECTED TO NORMAL BRANCH CIRCUIT. SEE LIGHTING FIXTURE SCHEDULE FOR EXACT REQUIREMENTS.
	SINGLE-POLE, 20 AMP, 120/277 VOLT, TOGGLE SWITCH IN FLUSH, (FINISHED SPACES) OR SURFACE (UNFINISHED SPACES) OUTLET BOX, MOUNT 46" A.F.F., UNLESS OTHERWISE INDICATED.
	FUSED SAFETY SWITCH, SIZE AND NUMBER OF POLES AS INDICATED BY SUBSCRIPTS, PROVIDE FUSES PER NAMEPLATE OF EQUIPMENT SERVED UNLESS OTHERWISE INDICATED. SUBSCRIPT WP INDICATES IN NEMA 3R ENCLOSURE. HEAVY DUTY, UNLESS OTHERWISE NOTED.
	480/277 VOLT PANELBOARD, FLUSH AND SURFACE MOUNTED RESPECTIVELY. SEE PANEL SCHEDULE FOR DESIGN INFORMATION. DESIGNATION AS INDICATED.
	SPECIAL EQUIPMENT CONNECTION. SUBSCRIPT INDICATES DESIGNATION. SEE EQUIPMENT CONNECTION SCHEDULE FOR EXACT REQUIREMENTS.
	PLAN NOTE ON SAME SHEET. NOTE NUMBERS AS INDICATED.
	20 AMP, 125 VOLT, 3 WIRE GROUND FAULT TYPE RECEPTACLE(S) WITH WET WHILE IN USE WEATHERPROOF COVER. MOUNTING AS INDICATED.

LIGHTING FIXTURE NOTES:

- REPLACE EXISTING SWITCHBOARD WITH NEW DISTRIBUTION PANEL. EXISTING FEEDER TO REMAIN. CONNECT EXISTING FEEDER TO NEW DISTRIBUTION PANEL. —



1/16" THICK PLASTIC WITH COLORED FACE PER SPECIFICATIONS

1/2" HIGH LETTERING FOR EQUIPMENT NAME

FASTEN WITH SELF TAPPING STAINLESS STEEL SCREWS, EA SIDE

1/4" HIGH LETTERING FOR REMAINING TEXT

TYPICAL 120/208V PANELBOARD


PANELBOARD NAME

FASTEN WITH SELF TAPPING STAINLESS STEEL SCREWS, EA SIDE


 

PANELBOARD VOLTAGE

PANELBOARD SOURCE

TYPICAL 277/480V PANELBOARD

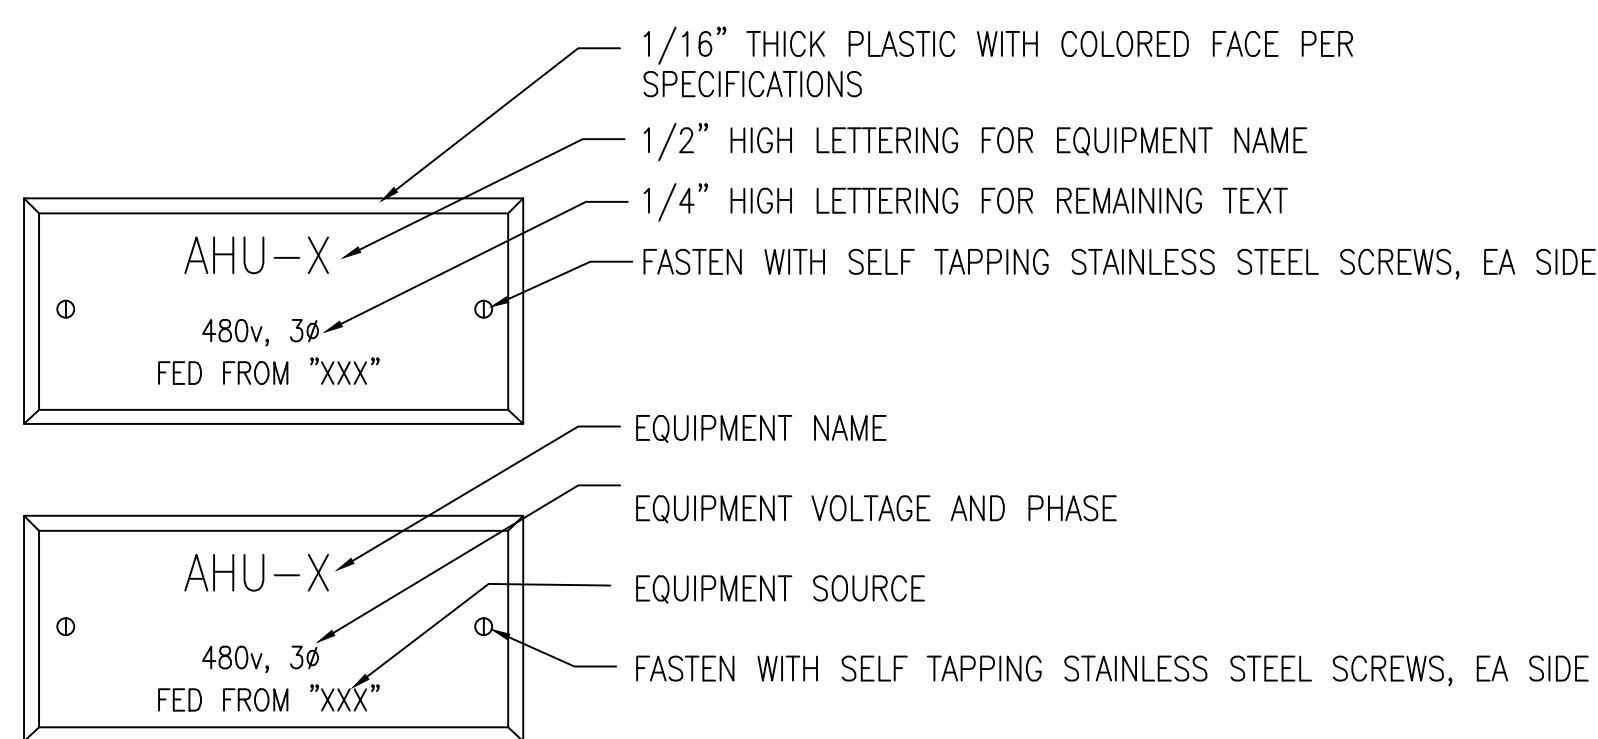

F8 EQUIPMENT NAMEPLATES
SCALE: NONE

 <div>Department of Veterans Affairs</div> <div>VA Medical Center</div> <div>700 South 19th Street</div> <div>Birmingham, AL 35233</div>	<div>Architect/Engineer Address</div> <div><div>Design & Management Solutions for the Built Environment</div><div>801 TOWER POINT DRIVE P 704.843.1320 CHARLOTTE, NC 28227 F 704.321.0833</div><div>COPYRIGHT © 2013 HARRELL, SALTROCK & HOPPER, PC HSH PROJECT # 13015</div></div>	Recommended Approvals:		Drawing Title	Project Title		Date	 <div>Veterans Affairs</div>
		1. MEDICAL DIRECTOR	6. OPERATIONS SERVICE LINE MANAGER	ELECTRICAL LEGEND, NOTES, SCHEDULES, & DETAILS	REPLACE ELEVATORS P11 & P12		6/13/2014	
		2. ASSOCIATE DIRECTOR	7. INFECTION CONTROL MANAGER				Project Number	
		3. CHIEF OF STAFF	8. SAFETY MANAGER				521-14-112	
		4. ASSOC. DIRECTOR	9. GENERAL ENGINEER					
5. SERVICE LINE MGERS.	10. COR	FINAL BID DOCUMENTS	Drawn DBW	Building Number	AutoCAD File Name	DRAWING No. E001		
		FULLY SPRINKLERED	Checked	Reviewed	Const. Contract No.			

