


Revisions	Date

Professional Seal

Professional Seal


**Indus Systems, Inc.**  
 2352, Main Street, Concord MA 01742  
 Tel: 978-461-0555  
 www.indus-systems.com

Drawing Title  
**FIRST FLOOR  
 ARCHITECTURAL PLAN**

Approved: \_\_\_\_\_  
 Approved: \_\_\_\_\_

Project Title  
**AS-BUILT Drawings**


Building Number  
**106**

Location  
**VAMC, LEBANON  
 PA.**


Date  
**04-26-2012**

Project No. \_\_\_\_\_

Drawing No. \_\_\_\_\_

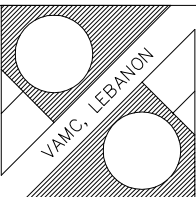



Department of  
 Veterans Affairs  
**VA**

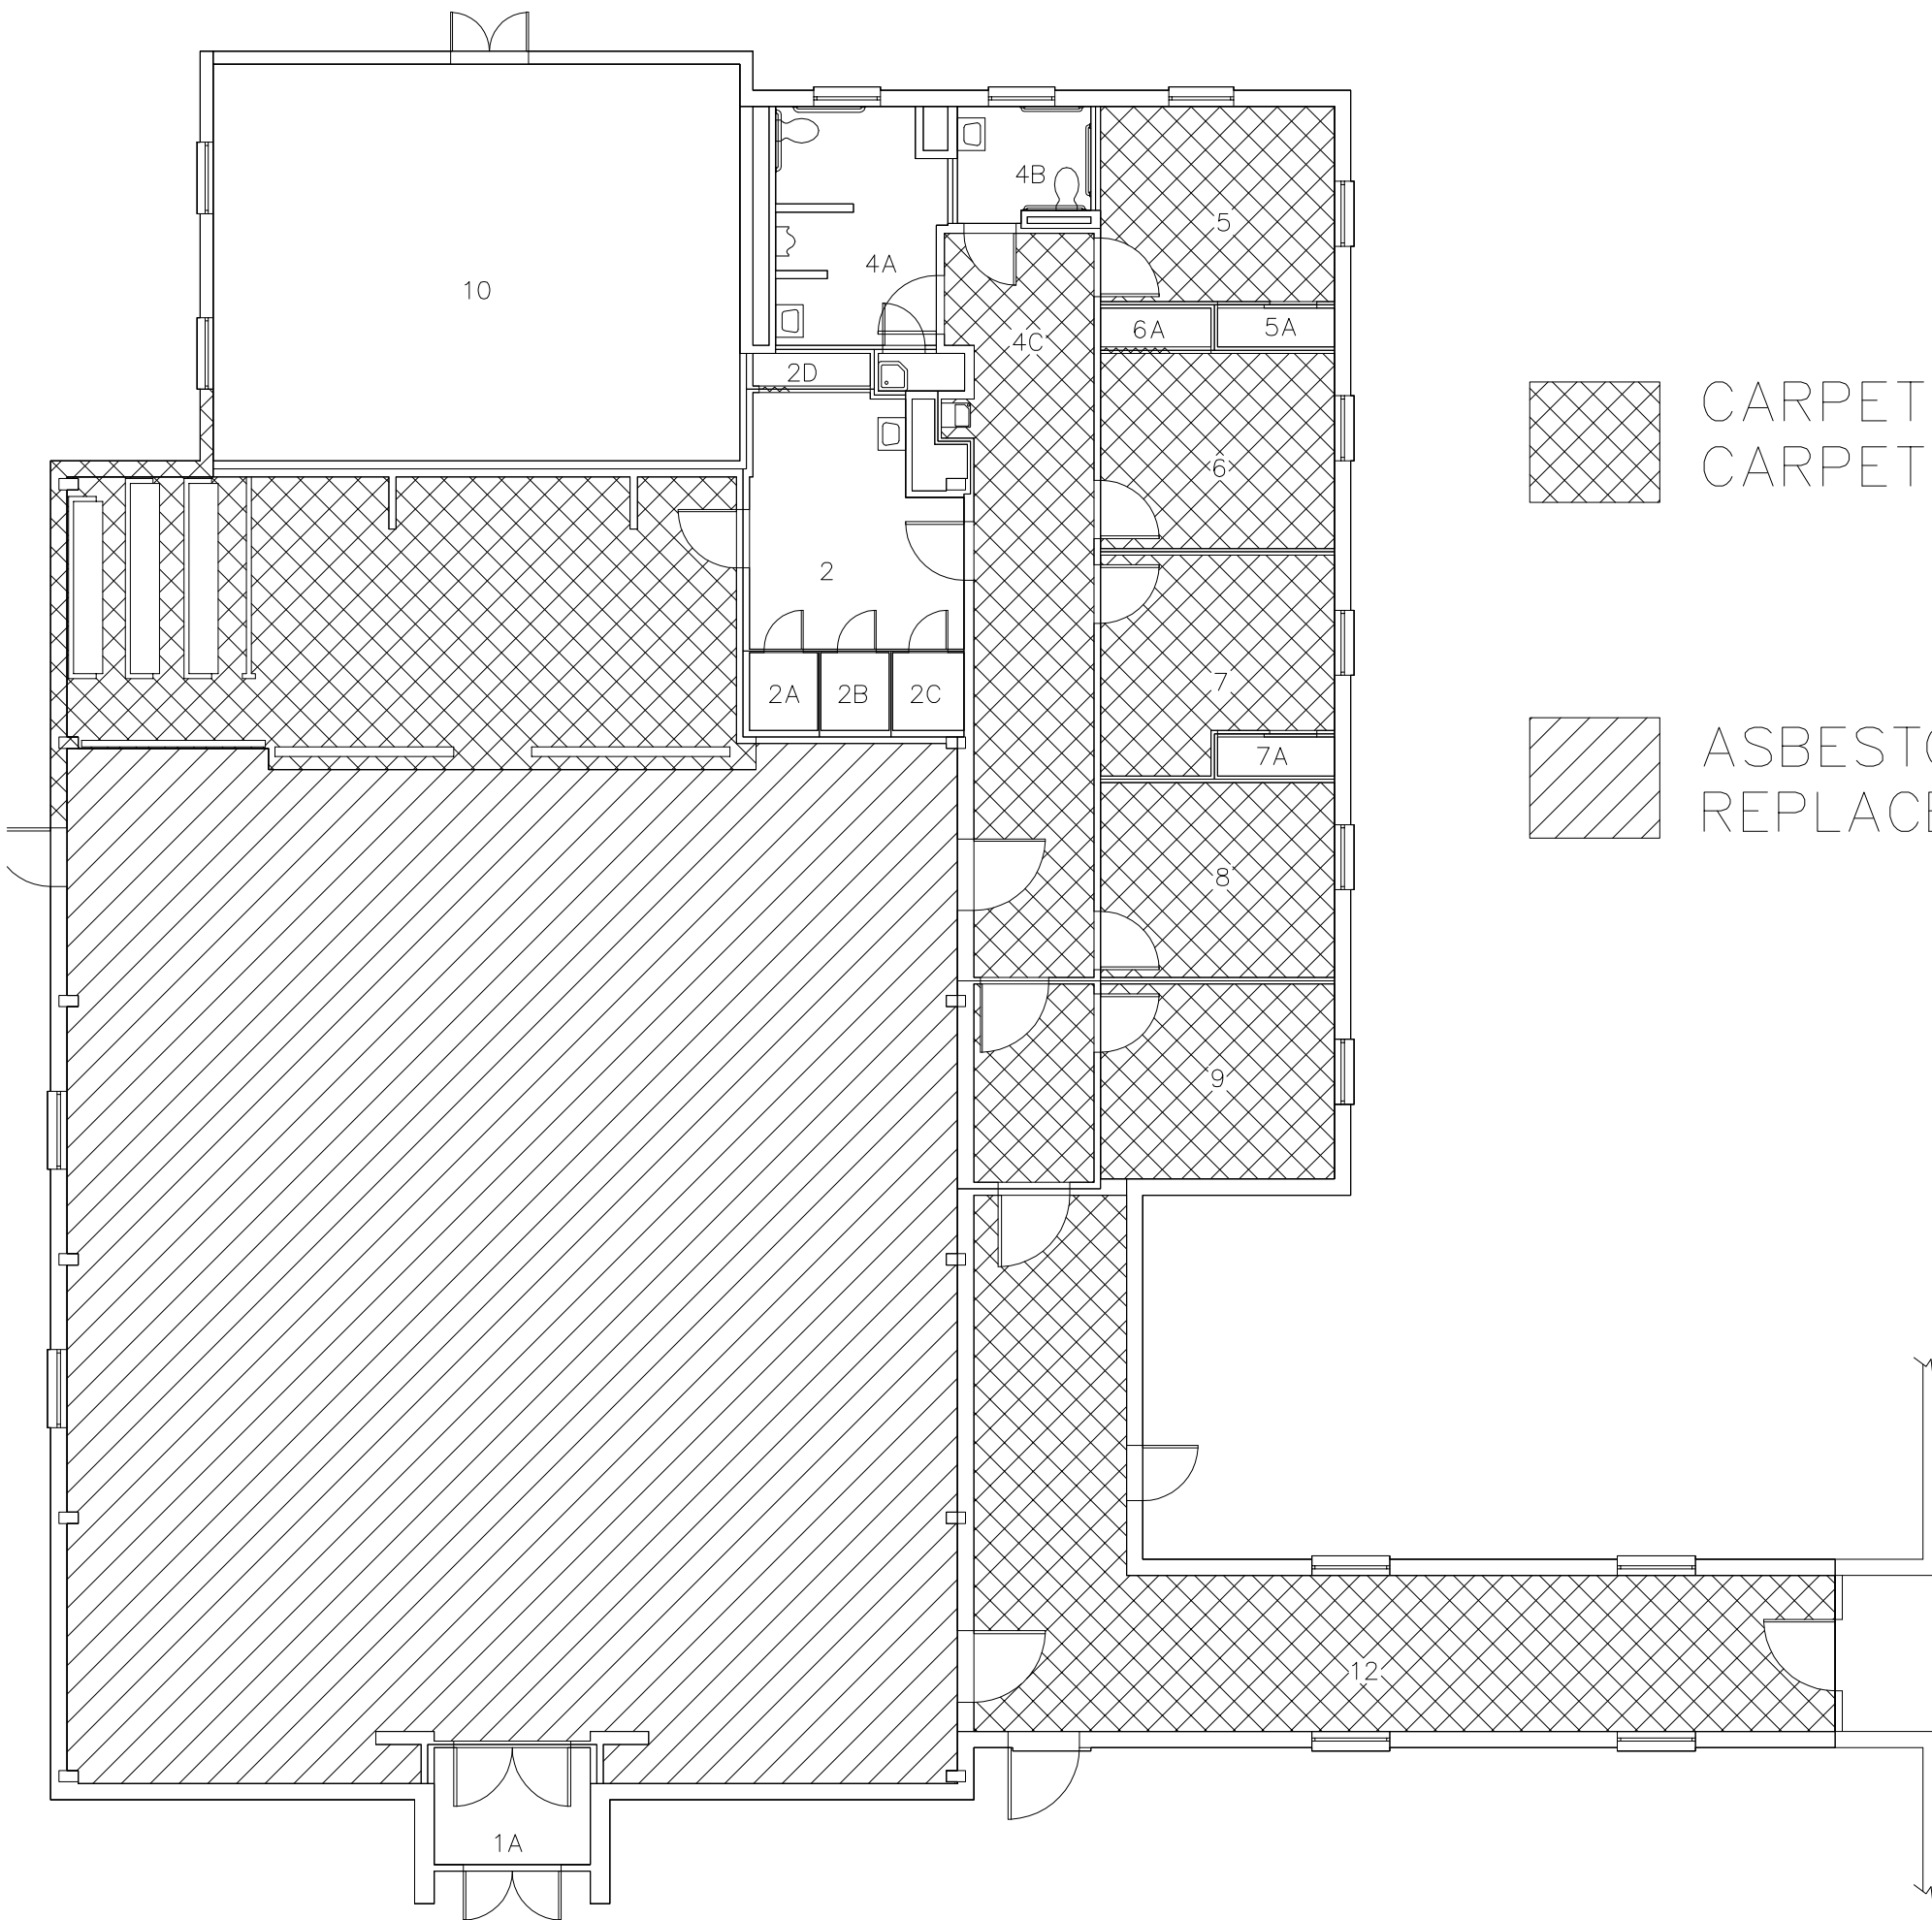


 CARPET EXISTING, REPLACE WITH  
 CARPET APPROVED BY VA


 ASBESTOS FLOOR TILE EXISTING,  
 REPLACE WITH FINISH APPROVED BY VA

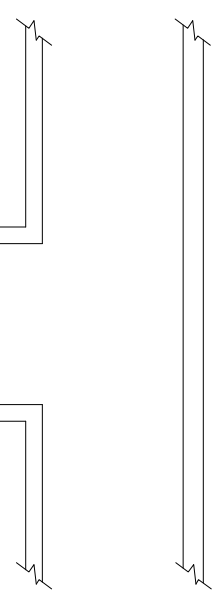
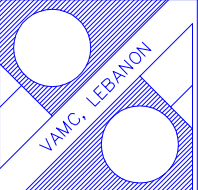


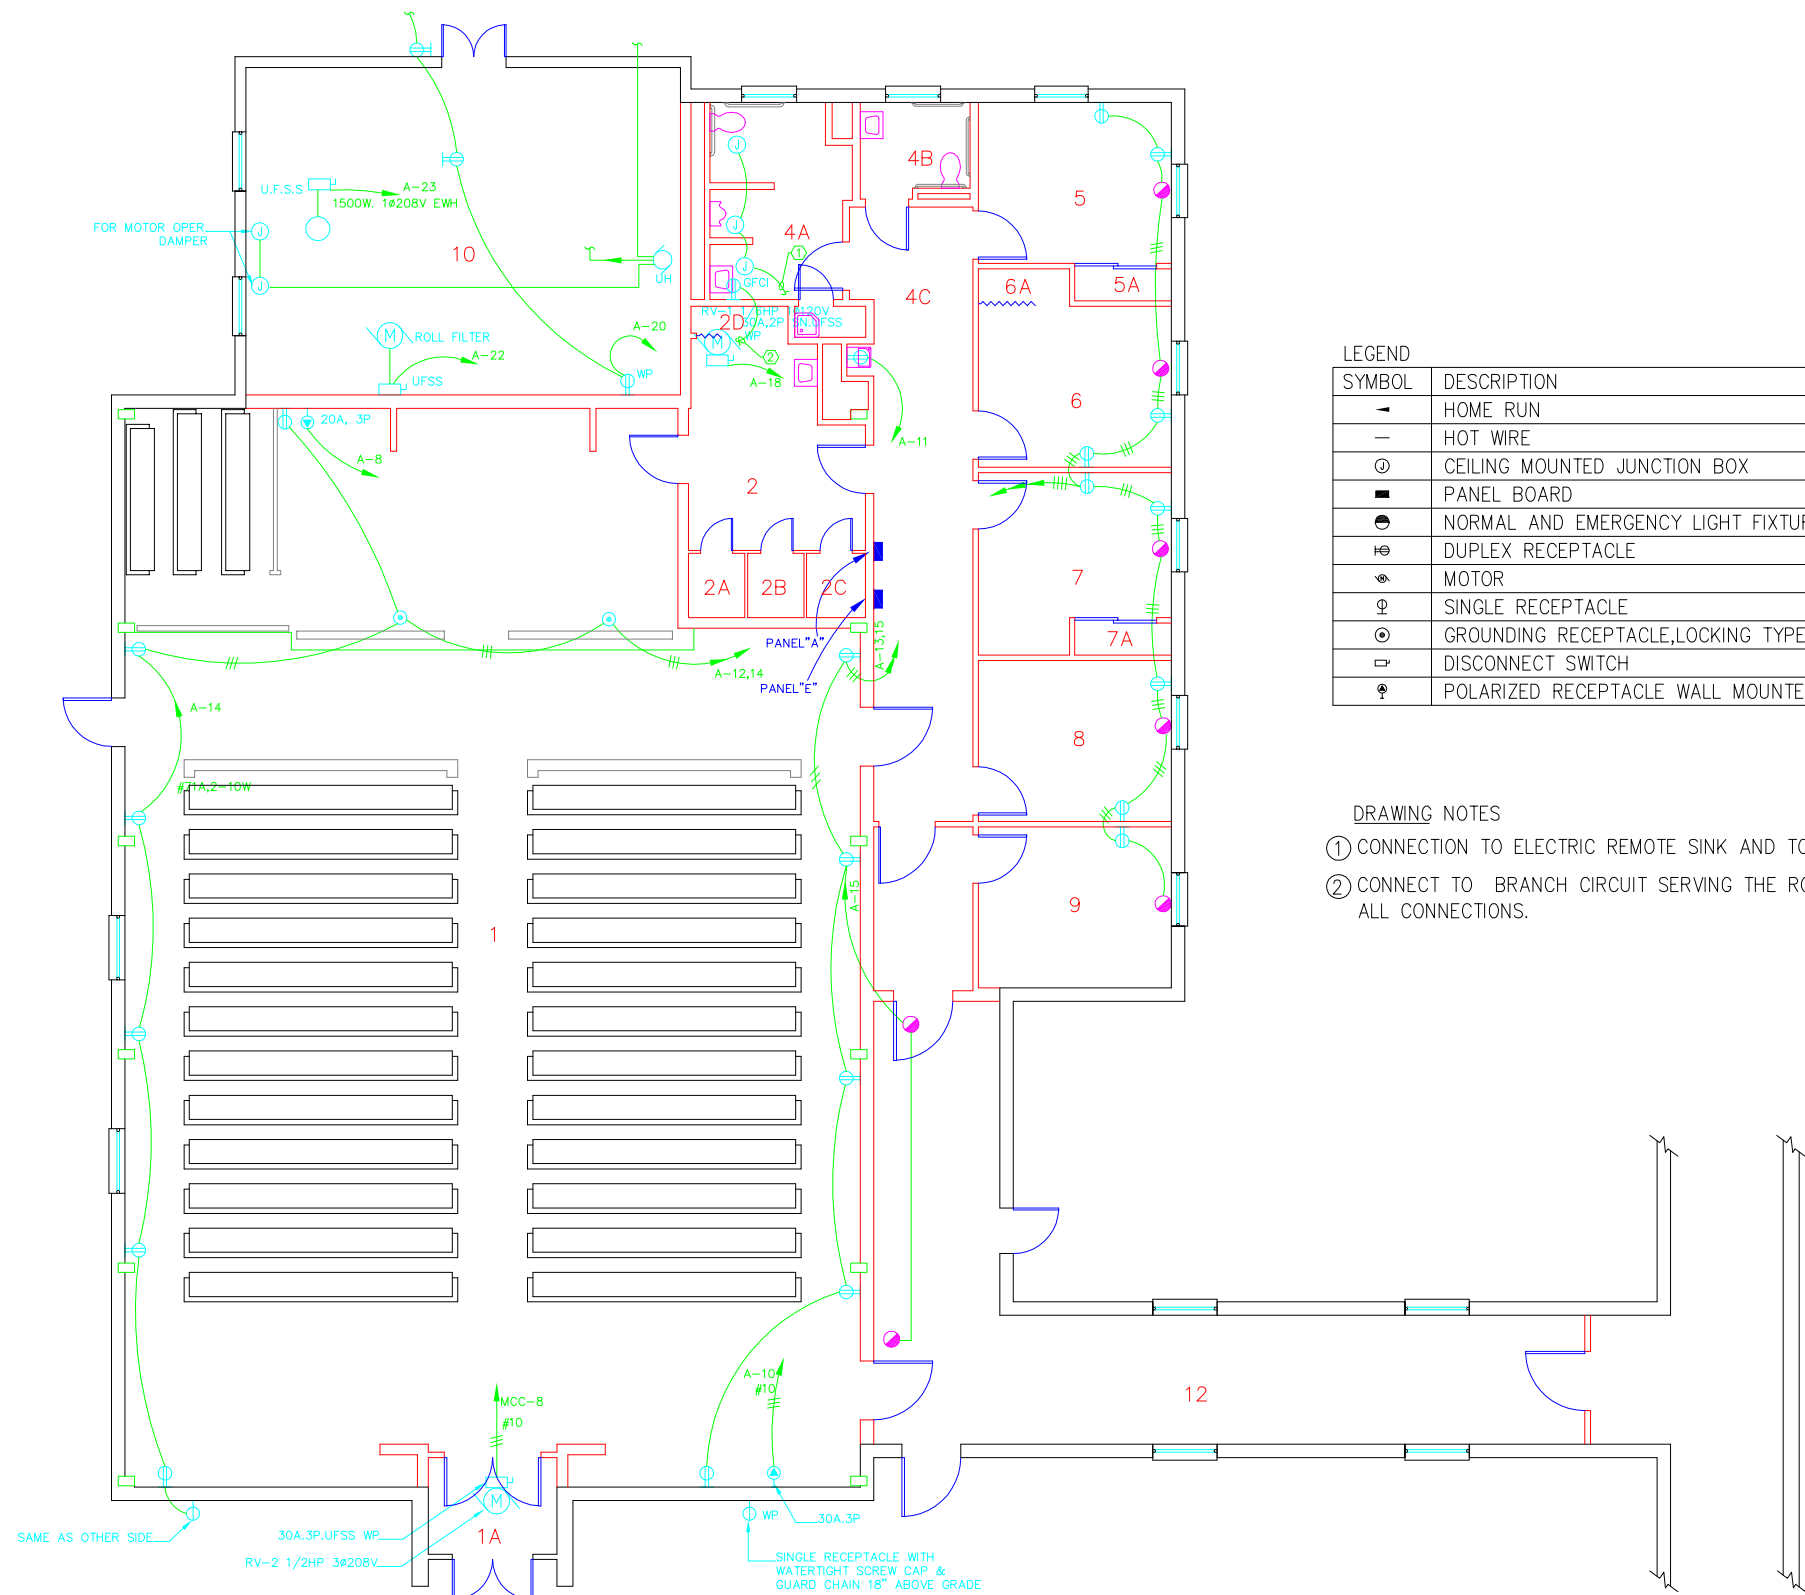


**LEGEND**

SYMBOL	DESCRIPTION
—	HOME RUN
- - -	HOT WIRE
⊙	CEILING MOUNTED JUNCTION BOX
■	PANEL BOARD
⊙	NORMAL AND EMERGENCY LIGHT FIXTURE
⊞	DUPLEX RECEPTACLE
⊙	MOTOR
⊙	SINGLE RECEPTACLE
⊙	GROUNDING RECEPTACLE, LOCKING TYPE
⊞	DISCONNECT SWITCH
⊙	POLARIZED RECEPTACLE WALL MOUNTED

- DRAWING NOTES**
- ① CONNECTION TO ELECTRIC REMOTE SINK AND TOILET.
  - ② CONNECT TO BRANCH CIRCUIT SERVING THE ROOM AND PROVIDE ALL CONNECTIONS.

Revisions _____ Date	Professional Seal _____ _____	 <b>Indus Systems, Inc.</b> 2352, Main Street, Concord MA 01742 Tel: 978-461-0555 www.indus-systems.com	Drawing Title <b>FIRST FLOOR POWER</b>	Project Title <b>AS-BUILT Drawings</b>	Date <b>04-19-2012</b>		Project No. _____
		Approved: _____	Building Number <b>106</b>	Checked _____	Drawn _____		Drawing No. _____
		Approved: _____	Location <b>VAMC, LEBANON PA.</b>				

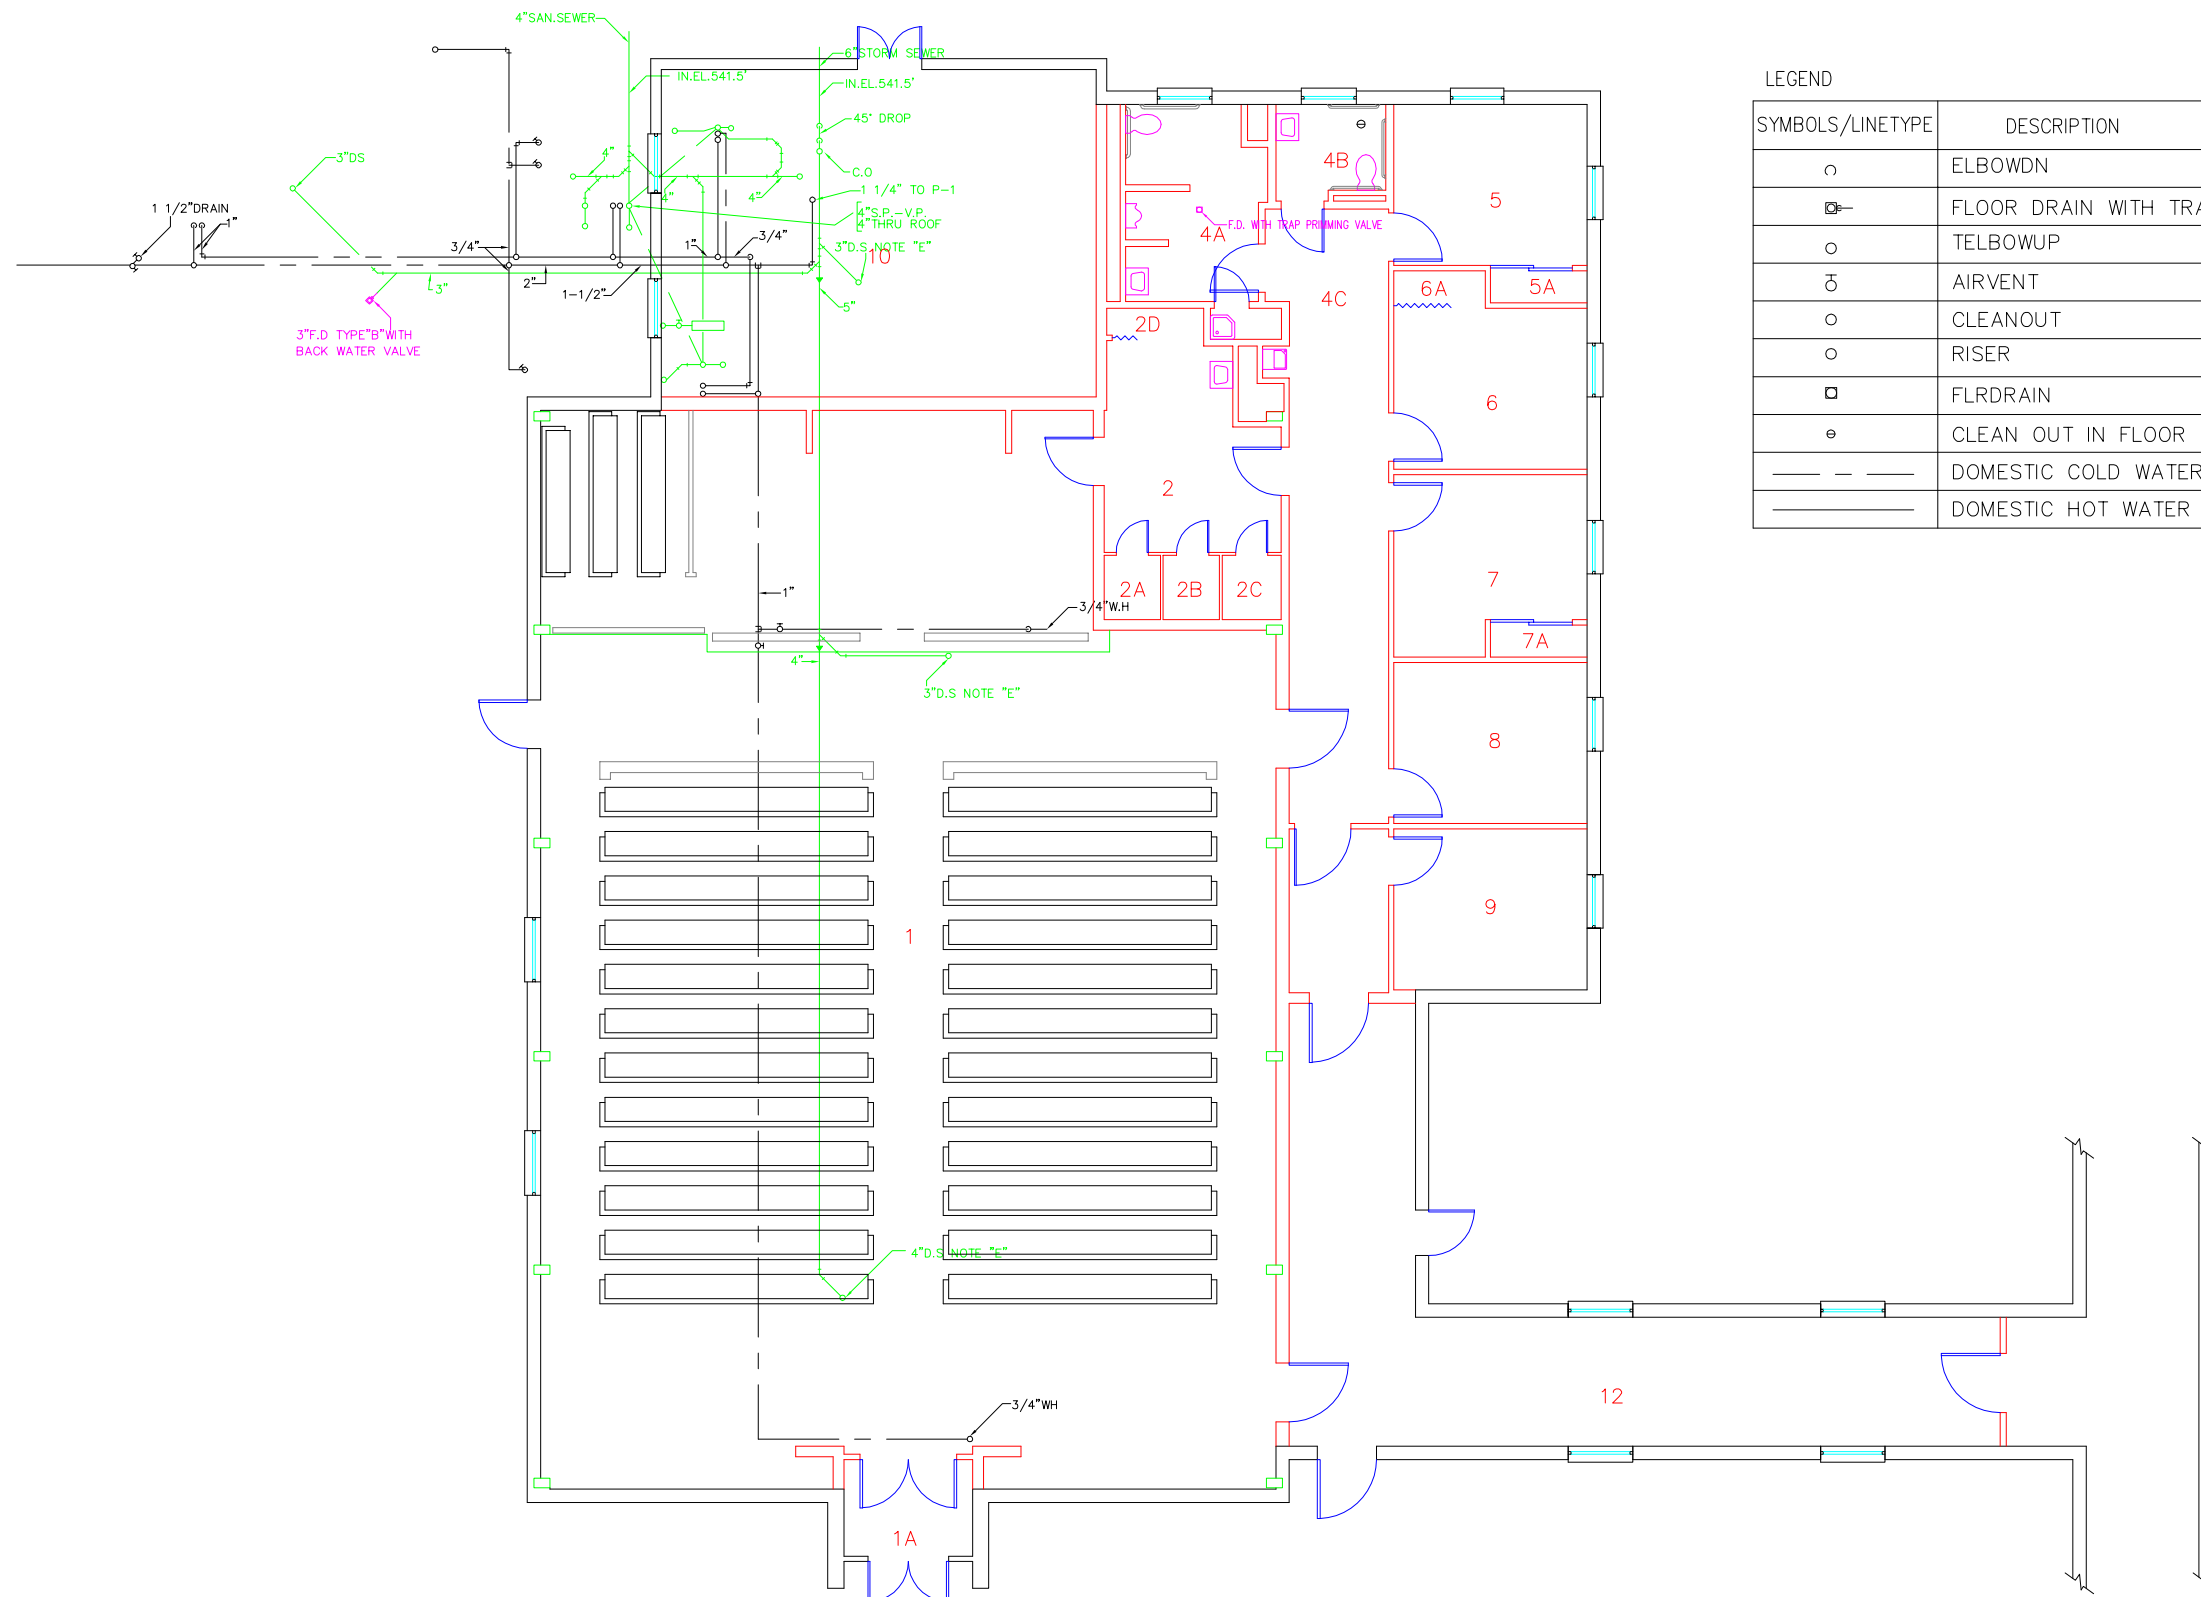


LEGEND

SYMBOLS/LINETYPE	DESCRIPTION
○	ELBOWDN
⊠	FLOOR DRAIN WITH TRAP
○	TELBOWUP
⊖	AIRVENT
○	CLEANOUT
○	RISER
⊠	FLRDRAIN
e	CLEAN OUT IN FLOOR
---	DOMESTIC COLD WATER
---	DOMESTIC HOT WATER

Revisions	Date

--	--


Professional Seal


**Indus Systems, Inc.**  
 2352, Main Street, Concord MA 01742  
 Tel: 978-461-0555  
 www.indus-systems.com


Drawing Title <b>FIRST FLOOR PLAN          PLUMBING</b>
Approved: _____ Approved: _____

Project Title <b>AS-BUILT Drawings</b>
Building Number <b>106</b>
Location <b>VAMC LEBANON          PA.</b>


Date <b>04-19-2012</b>
Project No. _____
Drawing No. _____

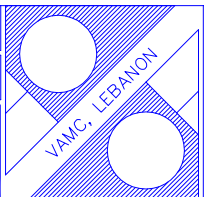


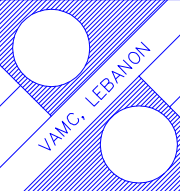
Department of Veterans Affairs

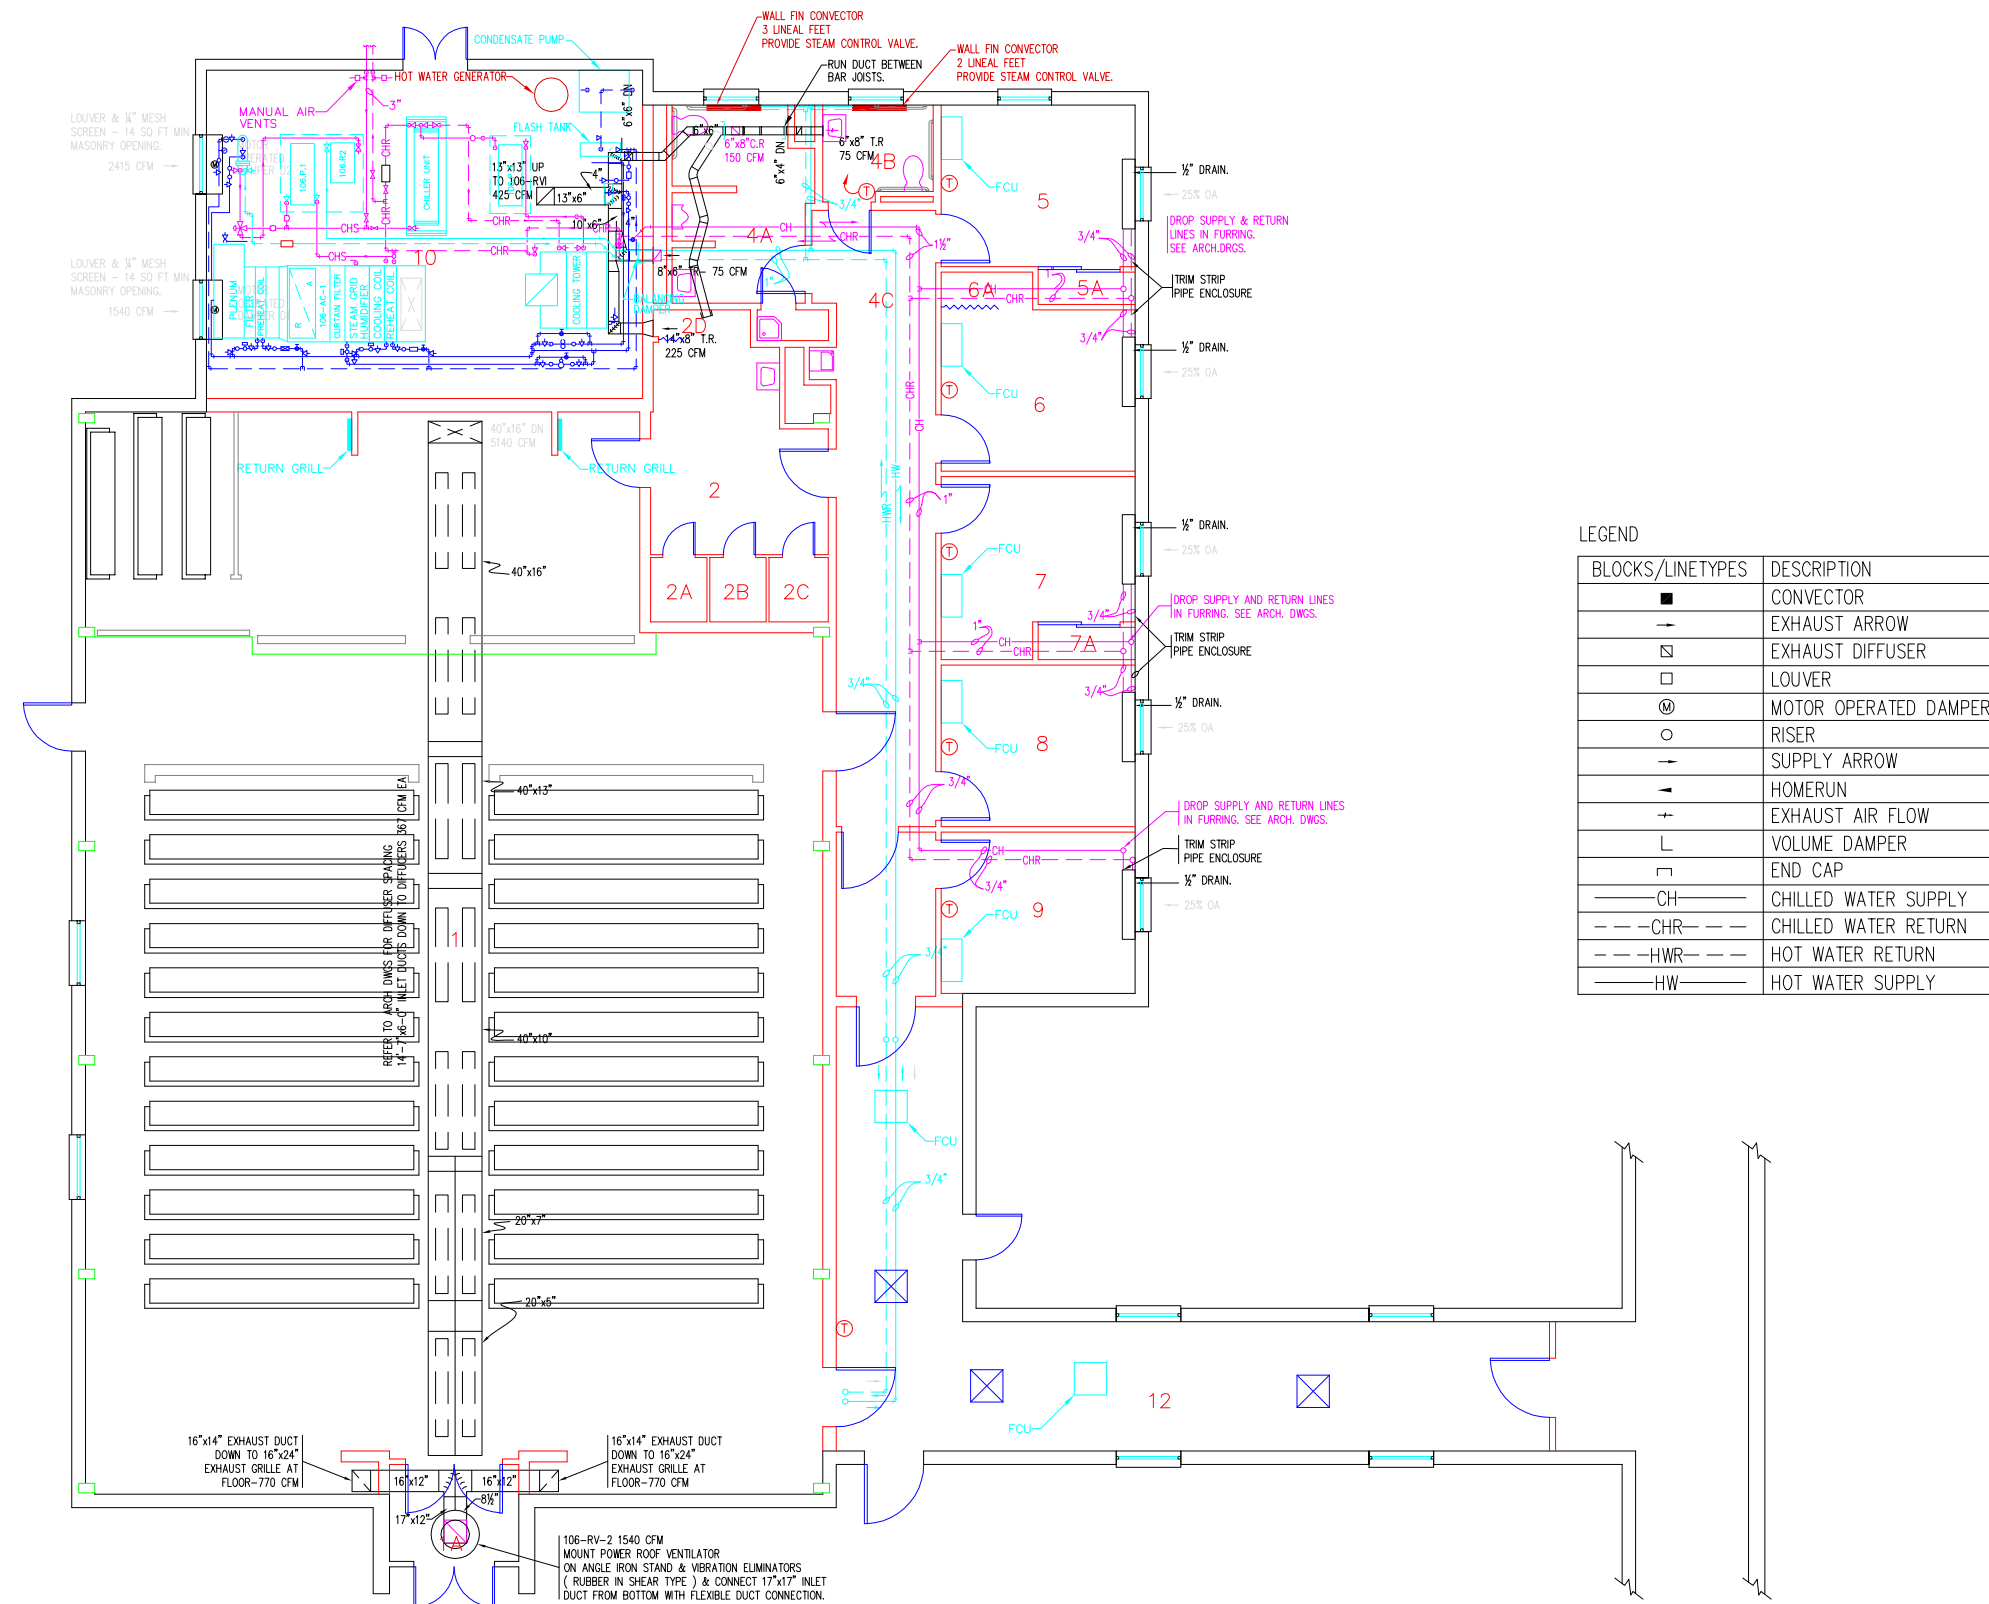

Revisions	Date	Professional Seal	<b>Indus Systems, Inc.</b> 2352, Main Street, Concord MA 01742 Tel: 978-461-0555 www.indus-systems.com	Drawing Title <b>FIRST FLOOR PLAN          MECHANICAL</b>	Project Title <b>AS-BUILT Drawings</b>	Date <b>04-19-2012</b>		Department of <b>Veterans Affairs</b>
				Approved: _____ Approved: _____	Building Number <b>106</b>	Checked _____ Drawn _____		

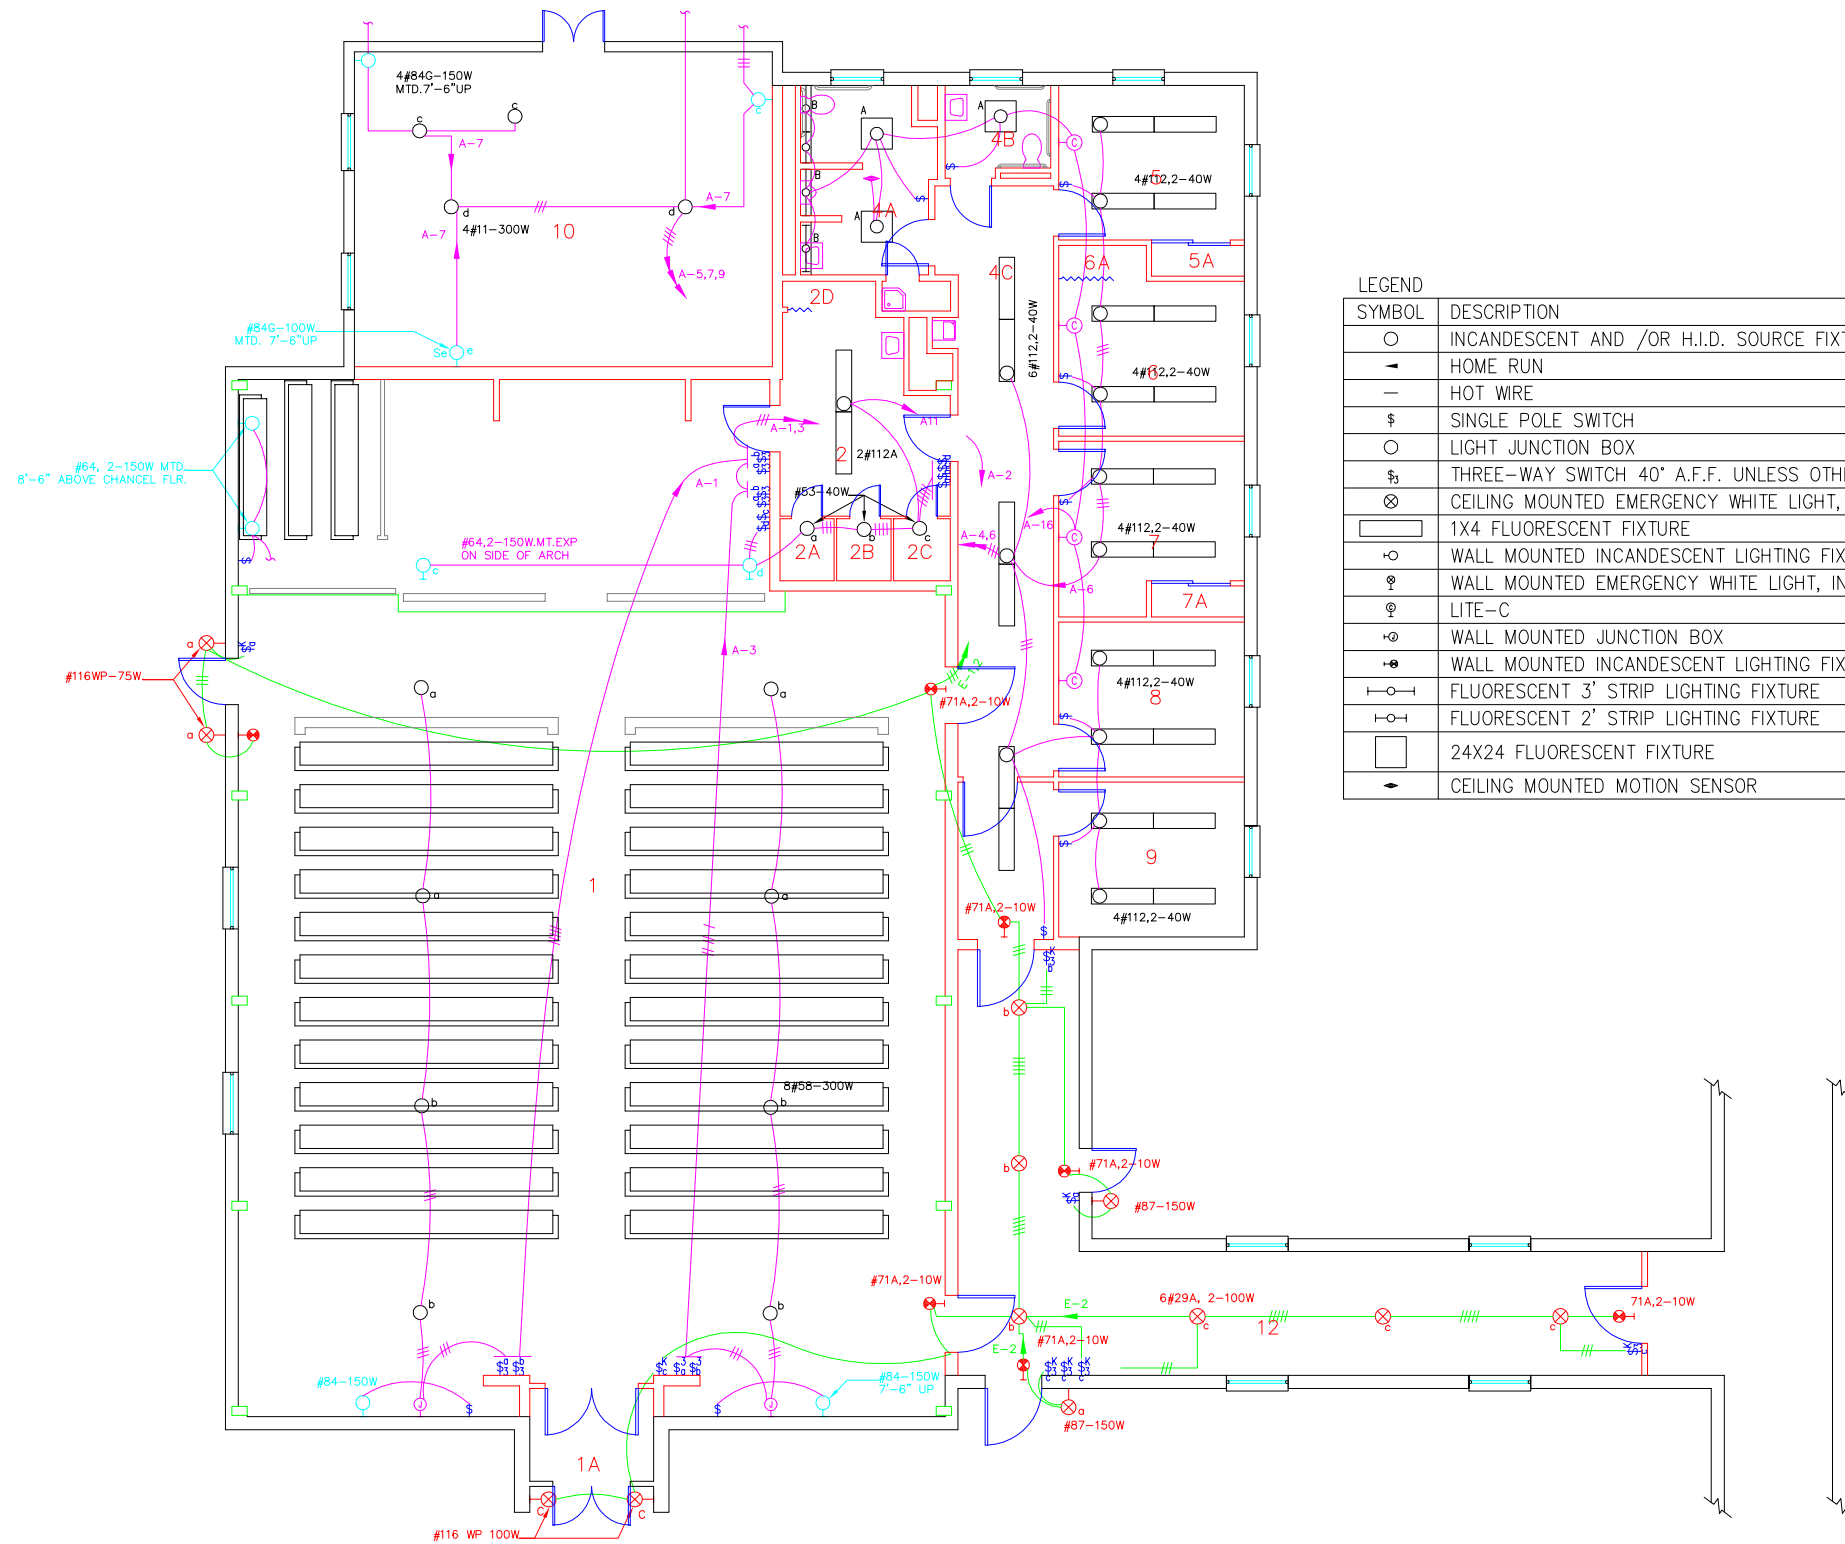


LEGEND	
SYMBOL	DESCRIPTION
○	INCANDESCENT AND /OR H.I.D. SOURCE FIXTURE
—	HOME RUN
—	HOT WIRE
⊞	SINGLE POLE SWITCH
○	LIGHT JUNCTION BOX
⊞	THREE-WAY SWITCH 40" A.F.F. UNLESS OTHERWISE NOTED
⊞	CEILING MOUNTED EMERGENCY WHITE LIGHT, INCANDESCENT
□	1X4 FLUORESCENT FIXTURE
○	WALL MOUNTED INCANDESCENT LIGHTING FIXTURE
⊞	WALL MOUNTED EMERGENCY WHITE LIGHT, INCANDESCENT
⊞	LITE-C
○	WALL MOUNTED JUNCTION BOX
⊞	WALL MOUNTED INCANDESCENT LIGHTING FIXTURE (DOUBLE FACE)
—	FLUORESCENT 3' STRIP LIGHTING FIXTURE
—	FLUORESCENT 2' STRIP LIGHTING FIXTURE
□	24X24 FLUORESCENT FIXTURE
⊞	CEILING MOUNTED MOTION SENSOR

Revisions _____ Date	Professional Seal _____ _____	 <b>Indus Systems, Inc.</b> 2352, Main Street, Concord MA 01742 Tel: 978-461-0555 www.indus-systems.com	Drawing Title <b>FIRST FLOOR LIGHTING</b>	Project Title <b>AS-BUILT Drawings</b>	Date <b>04-19-2012</b>		Project No. _____
		Approved: _____	Building Number <b>106</b>	Checked _____	Drawn _____		Drawing No. _____
		Approved: _____	Location <b>VAMC, LEBANON PA.</b>				

Department of Veterans Affairs  
 V/A




NORTH

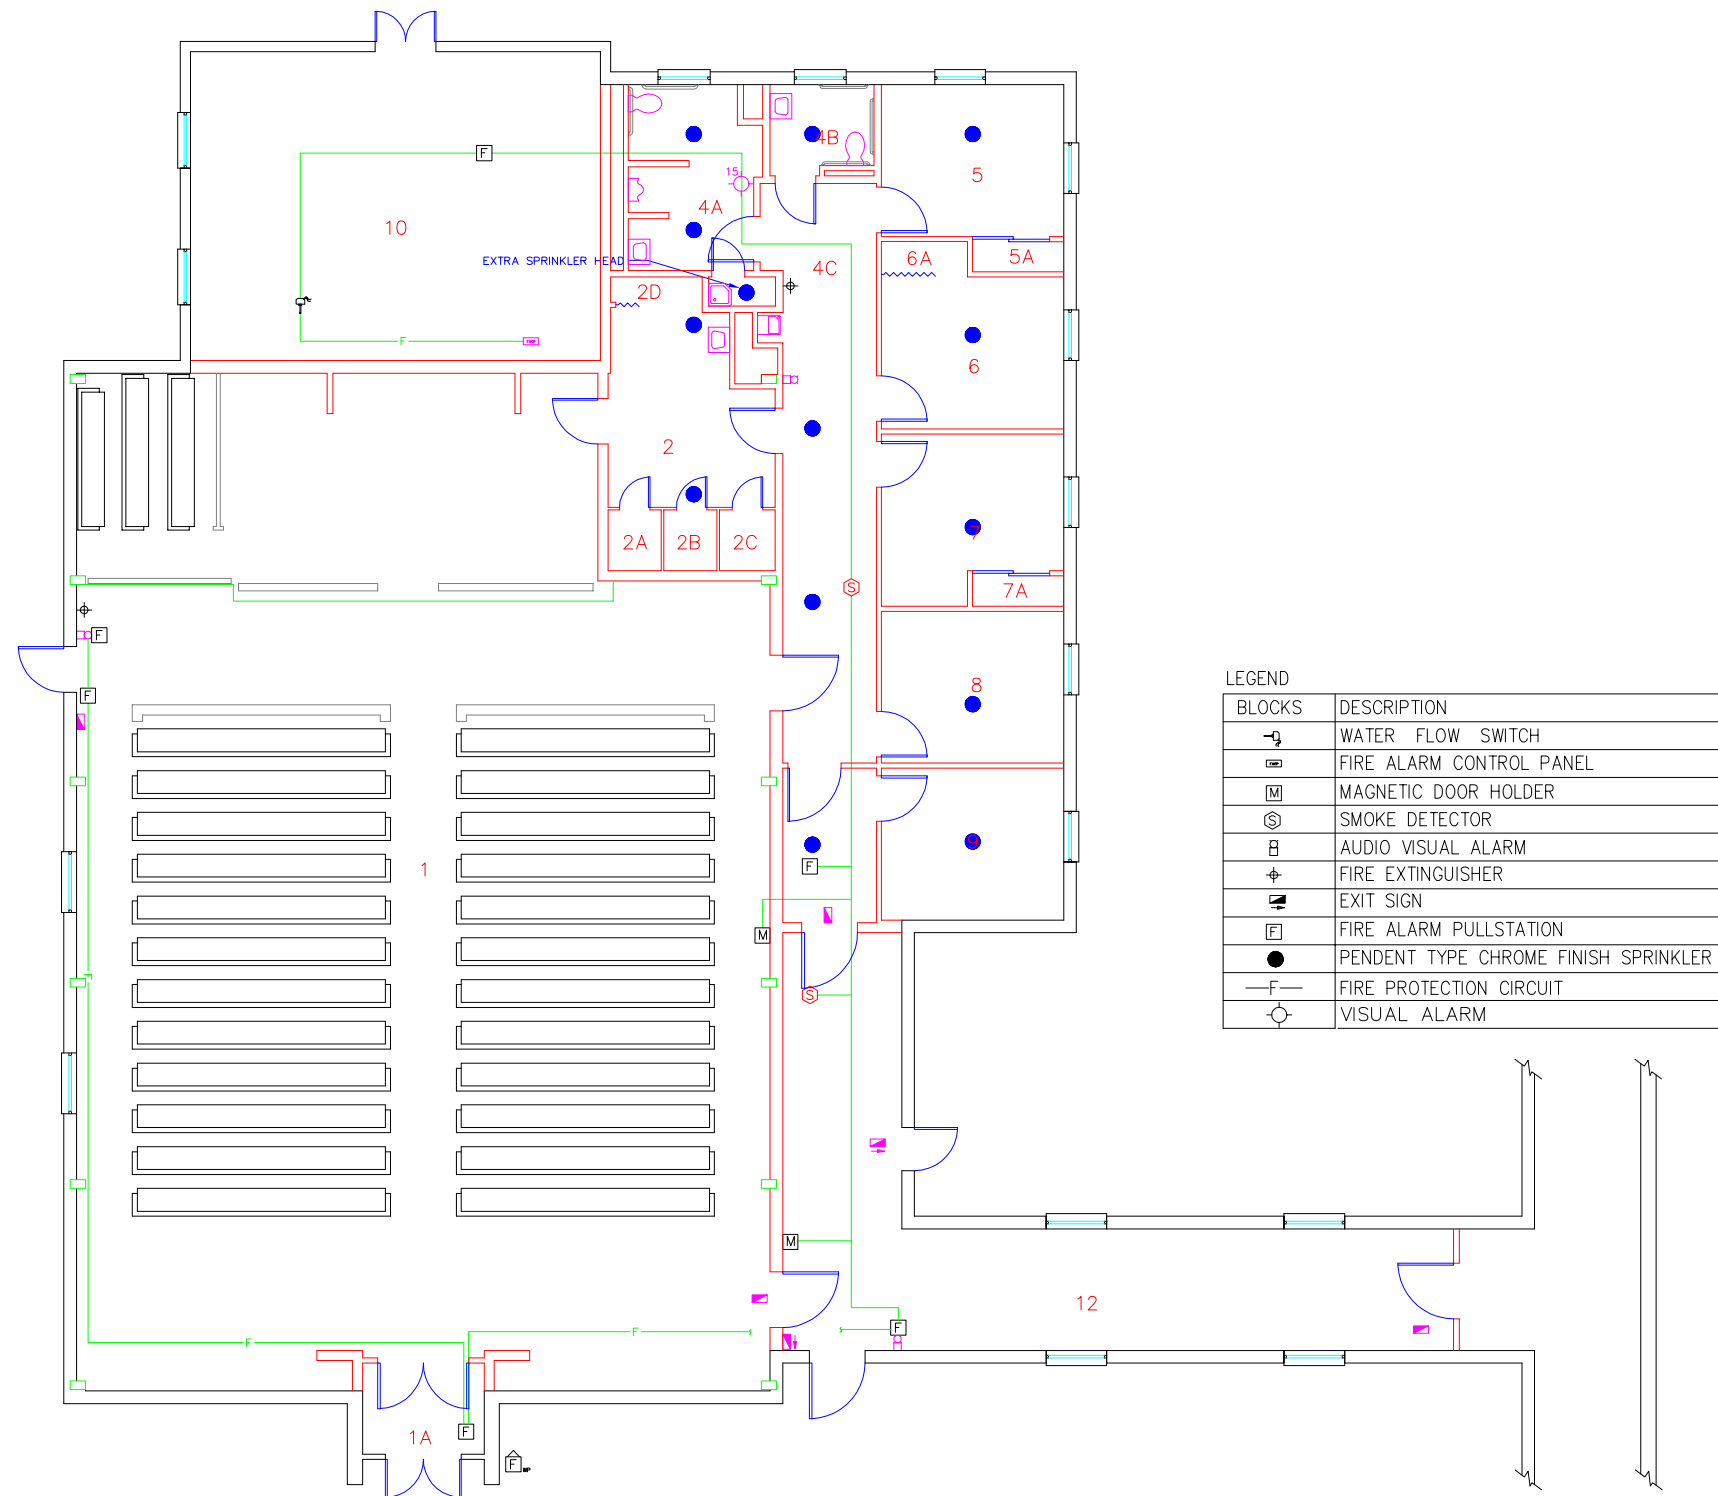

LEGEND

BLOCKS	DESCRIPTION
	WATER FLOW SWITCH
	FIRE ALARM CONTROL PANEL
	MAGNETIC DOOR HOLDER
	SMOKE DETECTOR
	AUDIO VISUAL ALARM
	FIRE EXTINGUISHER
	EXIT SIGN
	FIRE ALARM PULLSTATION
	PENDENT TYPE CHROME FINISH SPRINKLER
	FIRE PROTECTION CIRCUIT
	VISUAL ALARM

			 <b>Indus Systems, Inc.</b> 2352, Main Street, Concord MA 01742 Tel: 978-461-0555 www.indus-systems.com	Drawing Title <b>FIRST FLOOR PLAN          FIRE PROTECTION</b>	Project Title <b>AS-BUILT Drawings</b>	Date <b>04-19-2012</b>
Revisions	Date	Professional Seal		Approved:	Building Number <b>106</b>	Checked Drawn
				Approved:	Location <b>VAMC LEBANON          PA.</b>	Drawing No.

