


Vertical Datum
 NAVD 88 RELATIVE TO CITY OF SEATTLE BENCHMARK 2602.
 PUBLISHED ELEV= 346.236, AND CITY OF SEATTLE BENCHMARK
 2603, PUBLISHED ELEV= 329.154. ELEV'S WERE EXTENDED TO
 THE SITE USING CLOSED-LOOP, DIFFERENTIAL LEVELING METHODS.

0 10 20 40
SCALE 1"=20'

Call before you Dig.
 8-1-1 or
 1-800-424-5555
 UNDERGROUND SERVICE (USA)

Tree Protection
 THE CONTRACTOR SHALL COMPLY W/ DETAIL 4, SHEET
 CJ200 WHERE EXISTING TREES ARE LABELED "DO NOT
 DISTURB" OR "PROTECT"

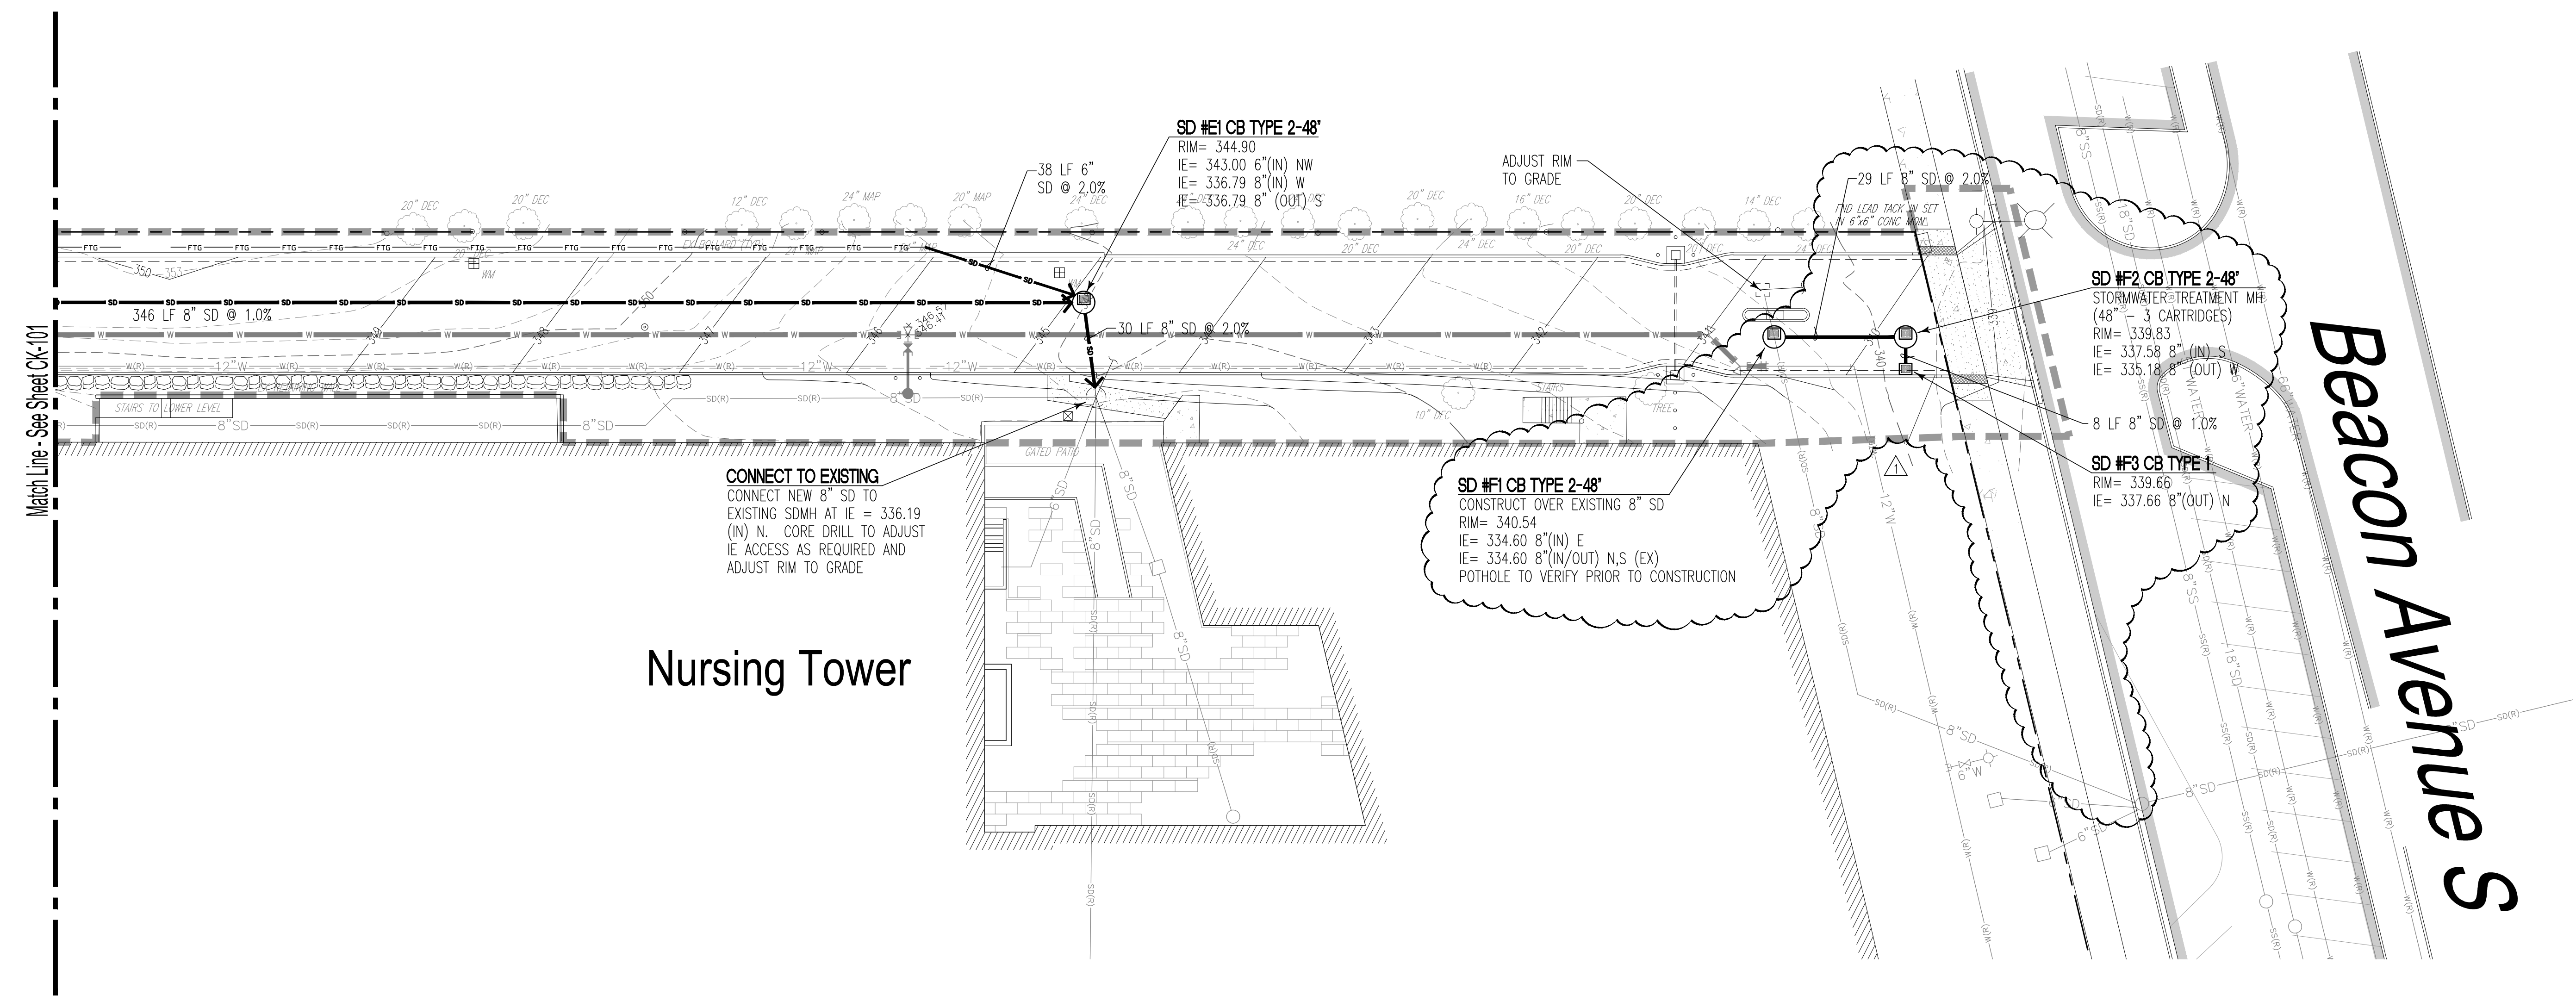


Nursing Tower

Beacon Avenue S

three inches = one foot
 one and one half inches = one foot
 one inch = one foot
 three quarter inch = one foot
 one half inch = one foot
 three eighth inch = one foot
 one quarter inch = one foot
 one eighth inch = one foot

LEGEND

	EXISTING	REMOVE	PROPOSED		EXISTING	REMOVE	PROPOSED
ASPHALT PAVING	[Symbol]	[Symbol]	[Symbol]	TREE W/ PROTECTION	[Symbol]	[Symbol]	[Symbol]
CONCRETE PAVING	[Symbol]	[Symbol]	[Symbol]	WATER METER/VALVE/FH	[Symbol]	[Symbol]	[Symbol]
BUILDINGS	[Symbol]	[Symbol]	[Symbol]	STORM CB/MH	[Symbol]	[Symbol]	[Symbol]
CURBING	[Symbol]	[Symbol]	[Symbol]	SANITARY SEWER MH/CO	[Symbol]	[Symbol]	[Symbol]
ROCKERY	[Symbol]	[Symbol]	[Symbol]	GAS VALVE/METER	[Symbol]	[Symbol]	[Symbol]
WATER LINE	[Symbol]	[Symbol]	[Symbol]	STREET LIGHT ASSEMBLY	[Symbol]	[Symbol]	[Symbol]
STORM DRAINAGE LINE	[Symbol]	[Symbol]	[Symbol]	CONSTRUCTION LIMITS	[Symbol]	[Symbol]	[Symbol]
SANITARY SEWER LINE	[Symbol]	[Symbol]	[Symbol]				
POWER	[Symbol]	[Symbol]	[Symbol]				
COMM LINE	[Symbol]	[Symbol]	[Symbol]				
GAS LINE	[Symbol]	[Symbol]	[Symbol]				

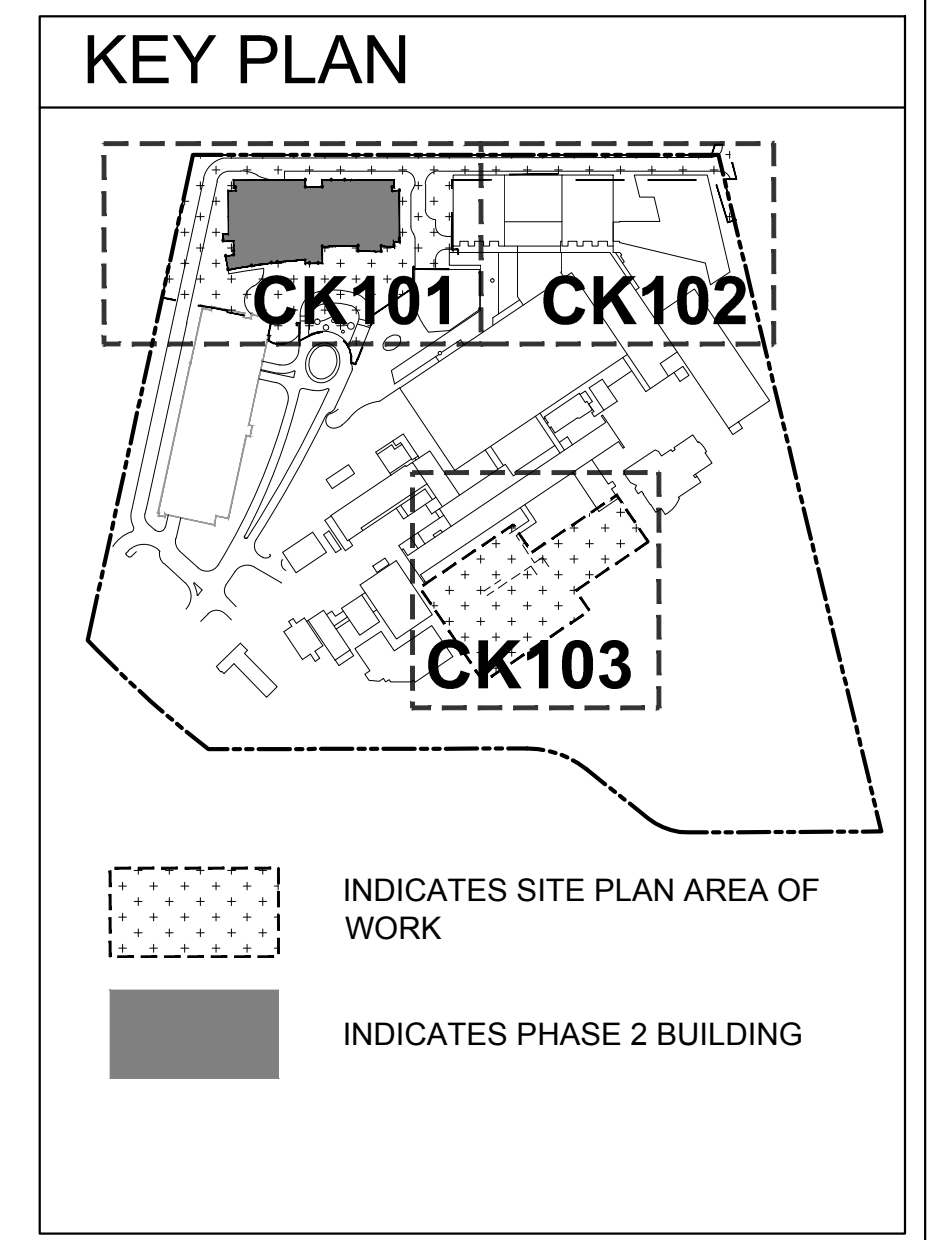


CONSTRUCTION DOCUMENT 2
 FULLY SPRINKLERED

01 - AMENDMENT A00004	07.14.2014
BID DOCUMENTS	05.30.2014
CONSTRUCTION DOCUMENTS CD2	06.05.2013
Revisions:	Date

CONSULTANTS:

COUGHLIN PORTER LUNDEEN
 A CONSULTING STRUCTURAL AND CIVIL ENGINEERING CORPORATION
 413 PINE STREET - SUITE 300 SEATTLE, WA 98101
 P: 206/343-0460 F: 206/343-5691

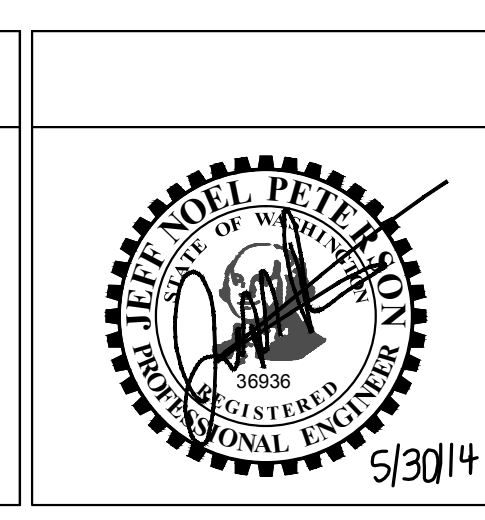

ARCHITECT

STANTEC | THE DESIGN PARTNERSHIP

Drawing Title
 Mental Health Building
 Storm Drainage Plan

Drawing Scale
 As Shown

Approved: Project Director

Project Title
 Building 101 Mental Health Services
 VAPSHCS Seattle Division - Phase 2
 MENTAL HEALTH AND RESEARCH BUILDING

Location
 1660 South Columbian Way, Seattle, WA 98105

Date
 JUNE 5, 2013

Checked
 JCF, JNP

Drawn
 SAS

Project Number
 VA# 663-405B

Building Number

Drawing Number
 CK102
 Volume 2a

Office of Construction and Facilities Management

Department of Veterans Affairs