


**REFLECTED CEILING PLAN**

SCALE: 1/4" = 1'-0"

NOTE: IF THIS PRINT IS A REDUCTION GRAPHIC SCALE MUST BE USED.

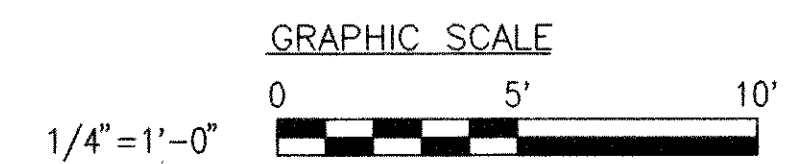

GRID CONTROL LINE

**MILLS CLAGETT & WENING CHARTERED**  
 ARCHITECTS ENGINEERS PLANNERS  
 5100 WISCONSIN AVE., N.W.  
 SUITE 407  
 WASHINGTON, D.C. 20016  
 (202) 686-2500  
 MCW PROJECT NO. 01495.00

**CARSON K.C. MOK**  
 CONSULTING ENGINEER, P.A.  
 9001 OTTAWA PLACE  
 SILVER SPRING, MD 20910  
 (301) 567-3448 / (301) 588-0008

**R. PETROSSIAN ASSOCIATES, LTD.**  
 ENGINEERS CONSULTANTS PLANNERS  
 1340 OLD CHAIN BRIDGE ROAD  
 MCLEAN, VIRGINIA 22101  
 (703) 556-0388

Drawing Title  
**REFLECTED CEILING PLAN**

Approved: Area Director  
 Approved: Cemetery Director

Project Title  
**SYSTEMS INTEGRATION CENTER**

Building Number  
 Checked  
 Drawn  
 AES/AMC

Location  
**Department of Veterans Affairs  
 National Cemetery System  
 Quantico National Cemetery, Triangle, Virginia**

Date **OCT. 10, 1995**  
~~AUGUST 21, 1995~~

Project No.  
**872-CM3-014**

Drawing No.  
**A5**

Sheet 10 of 28

**NATIONAL CEMETERY SYSTEM**

Department of Veterans Affairs

PROJECT NORTH