


NOTES: 1. TOP OF STUDS WALL (+9'-4") AT BUILDING EAVES.
 2. ROOF PITCH IS 1 3/4" RISE IN 12". SEE SECT. 1/S-4.
 3. FOR TOP OF LINTEL ELEVATION, SEE ARCH. DWG.

1 ROOF FRAMING PLAN
 S3 SCALE: 1/4" = 1'-0"

NOTE: IF THIS PRINT IS A REDUCTION GRAPHIC SCALE MUST BE USED.

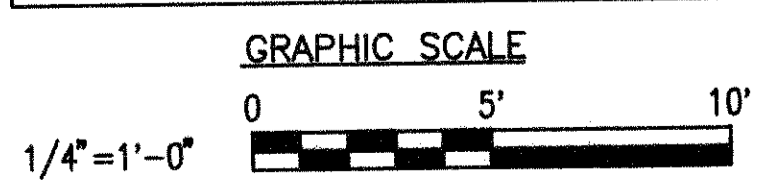

MILLS CLAGETT & WENING
 CHARTERED ARCHITECTS ENGINEERS PLANNERS
 5100 WISCONSIN AVE., N.W.
 SUITE 407 WASHINGTON, D.C. 20018
 (202) 686-2500
 MCW PROJECT NO. 01485.00

CARSON K.C. MOY
 CONSULTING ENGINEER, P.A.
 9001 OTTAWA PLACE SILVER SPRING, MD 20910
 (301) 567-3448 (301) 568-0068

R. PETROSSIAN ASSOCIATES, LTD.
 ENGINEERS CONSULTANTS PLANNERS
 1340 OLD CHAM BRIDGE ROAD MCLEAN, VIRGINIA 22101
 (703) 556-0388

Project Title		Date
SYSTEMS INTEGRATION CENTER		OCT. 10, 1995
Project No.		August 21, 1995
872-CM-014		
Building Number	Checked	Drawn
		AES/MC
Location		
Department of Veterans Affairs National Cemetery System Quantico National Cemetery, Triangle, Virginia		
Drawing No.		Sheet
S-3		18 of 28

NATIONAL CEMETERY SYSTEM

