


**1 FLOOR PLAN - MECHANICAL**  
A2 SCALE: 1/4" = 1'-0"

NOTE: IF THIS PRINT IS A REDUCTION GRAPHIC SCALE MUST BE USED.

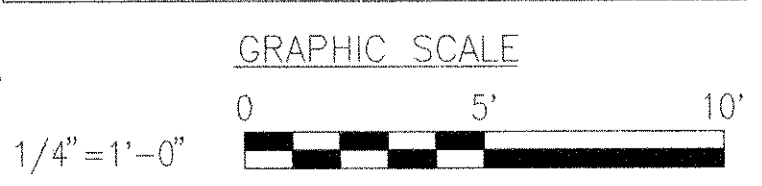

PROJECT NORTH

**MILLS CLAGETT & WENING CHARTERED**  
ARCHITECTS ENGINEERS PLANNERS  
5100 WISCONSIN AVE., N.W.  
SUITE 407  
WASHINGTON, D.C. 20016  
(202) 688-2500  
MCW PROJECT NO. 01495.00

**CARSON K.C. MOK**  
CONSULTING ENGINEER, P.A.  
9001 OTTAWA PLACE  
SILVER SPRING, MD 20910  
(301) 587-3448 / (301) 588-0088

**R. PETROSSIAN ASSOCIATES, LTD.**  
ENGINEERS CONSULTANTS PLANNERS  
1340 OLD CHAN BRIDGE ROAD  
MCLAN, VIRGINIA 22101  
(703) 556-0388

Drawing Title  
**FLOOR PLAN - MECHANICAL**

Approved: Area Director  
Approved: Cemetery Director

Project Title  
**SYSTEMS INTEGRATION CENTER**

Building Number  
Checked  
Drawn G.O.

Location  
**Department of Veterans Affairs  
National Cemetery System  
Quantico National Cemetery, Triangle, Virginia**

Date  
10-10-95

Project No.  
**872-CM-014**

Drawing No.  
**M-2**

Sheet 22 Of 28

**NATIONAL CEMETERY SYSTEM**

