


**1 FLOOR PLAN - PLUMBING**  
 P-1 SCALE: 1/4" = 1'-0"

NOTE: IF THIS PRINT IS A REDUCTION GRAPHIC SCALE MUST BE USED.

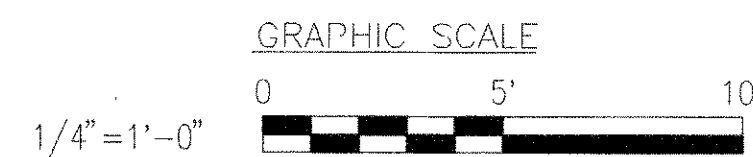

**MILLS CLAGETT & WENING CHARTERED**  
 ARCHITECTS ENGINEERS PLANNERS  
 5100 WISCONSIN AVE., N.W.  
 SUITE 407  
 WASHINGTON, D.C. 20016  
 (202) 686-2500  
 MCV PROJECT NO. 01495.00

**CARSON K.C. MOK CONSULTING ENGINEER, P.A.**  
 9001 OTTAWA PLACE  
 SILVER SPRING, MD 20910  
 (301) 587-3448 / (301) 588-0088

**R. PETROSSIAN ASSOCIATES, LTD.**  
 ENGINEERS CONSULTANTS PLANNERS  
 1340 OLD CHAIN BRIDGE ROAD  
 McLEAN, VIRGINIA 22101  
 (703) 556-0388

Drawing Title	<b>FLOOR PLAN - PLUMBING</b>		
Approved: Area Director			
Approved: Cemetery Director			

Project Title	<b>SYSTEMS INTEGRATION CENTER</b>		
Date	10/10/95		
Project No.	872-CM-014		
Drawing No.	<b>P-2</b>		
Sheet	25 Of 28		
Building Number	Checked	Drawn	
		G.O.	
Location	Department of Veterans Affairs National Cemetery System Quantico National Cemetery, Triangle, Virginia		

**NATIONAL CEMETERY SYSTEM**