




- 1- LAB FAUCETS: REPLACE EXISTING LABORATORY FAUCETS WITH NEW. INSTALL ISOLATION VALVES ON HOT AND COLD WATER SUPPLY PIPING. INSTALL CHECK VALVE ON HOT WATER SUPPLY PIPING. ISOLATION VALVES SHALL BE LOCATED IN ACCESSIBLE LOCATIONS.
- 2- MOP SINK FAUCETS: INSTALL CHECK VALVE ON HOT WATER SUPPLY PIPING. ALL VALVES SHALL BE LOCATED IN ACCESSIBLE LOCATIONS.
- 3- SHOWER FAUCETS: INSTALL CHECK VALVE ON HOT WATER SUPPLY PIPING. ALL VALVES SHALL BE LOCATED IN ACCESSIBLE LOCATIONS.
- 4- SENSOR FAUCETS: INSTALL CHECK VALVE ON HOT WATER SUPPLY PIPING. ALL VALVES SHALL BE LOCATED IN ACCESSIBLE LOCATIONS.
- 5- KNEE PEDAL CONTROL FAUCETS: INSTALL CHECK VALVE ON HOT WATER SUPPLY PIPING. ALL VALVES SHALL BE LOCATED IN ACCESSIBLE LOCATIONS.
- 6- REMOVE EXISTING AERATORS, WHERE APPLICABLE, AND INSTALL LAMINAR FLOW END DEVICE ON ALL FAUCETS.
- 7- INSTALL CHECK VALVES ON ALL HOT WATER MAINS AND HOT WATER RECIRCULATING MAINS AT EACH FLOOR. INSTALL NEW ISOLATION VALVE IF NO EXISTING ISOLATION VALVE IS INSTALLED.

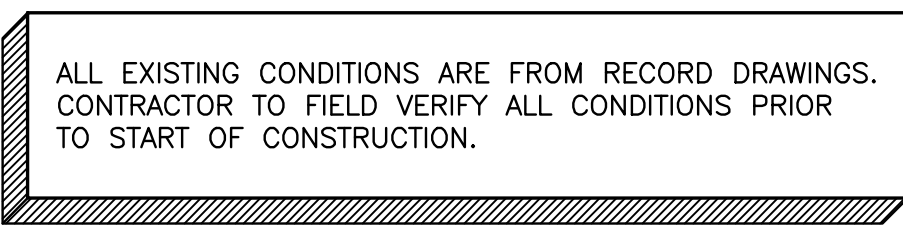



0 1 2 4 8 16 24 FT.
SCALE: 1/8"=1'-0"

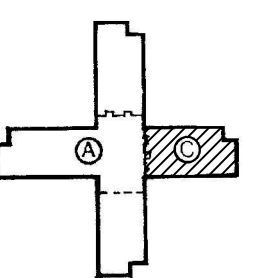

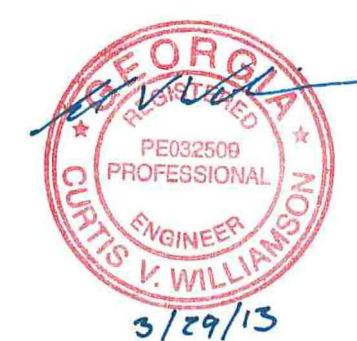KEY PLAN - SEVENTH FLOOR



		Drawn By: WBR		<div>JOHNSON, LASCHOB & ASSOCIATES, P.C. ARCHITECTS + ENGINEERS LANDSCAPE ARCHITECTS 1200 HUNTERSLEY, AUGUSTA, GEORGIA 30901 PHONE: (706) 724-5700 FAX: (706) 724-9905 WEBSITE: WWW.JLA-PC.COM</div>		Date: 03/29/13	 Department of Veterans Affairs VAMC Augusta, Georgia Engineering Service (138)
		Checked: CVW			Project Title: Replace Water Lines – Phase 6 Building 801 – Downtown Division	Project No. 509–10–124	
					Drawing Title: SEVENTH FLOOR – C WING PLUMBING PLAN	Drawing No. P–27 Dwg. 28 of 29	
ISSUED FOR CONSTRUCTION	03/29/13						
Revisions:	Date:						