


- Sanitary Manhole
- Dry Well Manhole
- Storm Manhole
- Grease Interceptor
- Catch Basin
- Carb Inlet
- Ditch Inlet
- Round Catch Basin / Area Drain
- Roof Drain Down Spout
- Back Water Valve
- Sanitary Sewer Clean Out
- Storm Sewer Clean Out
- Natural Gas Meter
- Natural Gas Valve
- Fire Hydrant
- Post Indicator Valve
- Water Valve
- Fire Department Connection
- Hose Bib
- Irrigation Valve
- Double Check Valve Assembly
- Domestic Double Check Valve
- Water Storage Tank
- Water Well
- Water Meter
- Water Vault
- Water Manhole
- Fire Protection
- Communications Vault
- Communications Manhole
- Communications Riser
- Power Vault
- Power Manhole
- Power Riser
- Traffic Signal Box
- Street Light Vault
- Unknown Vault
- Unknown Manhole
- Unknown Standpipe
- Site Street Lighting
- Storm Sewer Pipe
- Sanitary Sewer Pipe
- Natural Gas Pipe
- Electrical Line
- Water Pipe





SITE
STORM SEWER

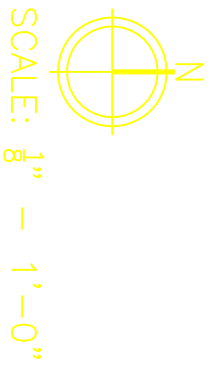

Approved: Eng. Eng.	Approved: Infect. Cont.	Approved: Chief P&O	Approved: Chief M&E	Approved: Safety Mgr.	Project Title	Date
Approved: Service Chief	Approved: Chief Facilities Mgmt	Approved: W&C Director			Project No.	2014.06.14
					Building No.	
					Drawn By	
					Drawn No.	
					Dwg. of	

US DEPARTMENT OF
VETERANS AFFAIRS

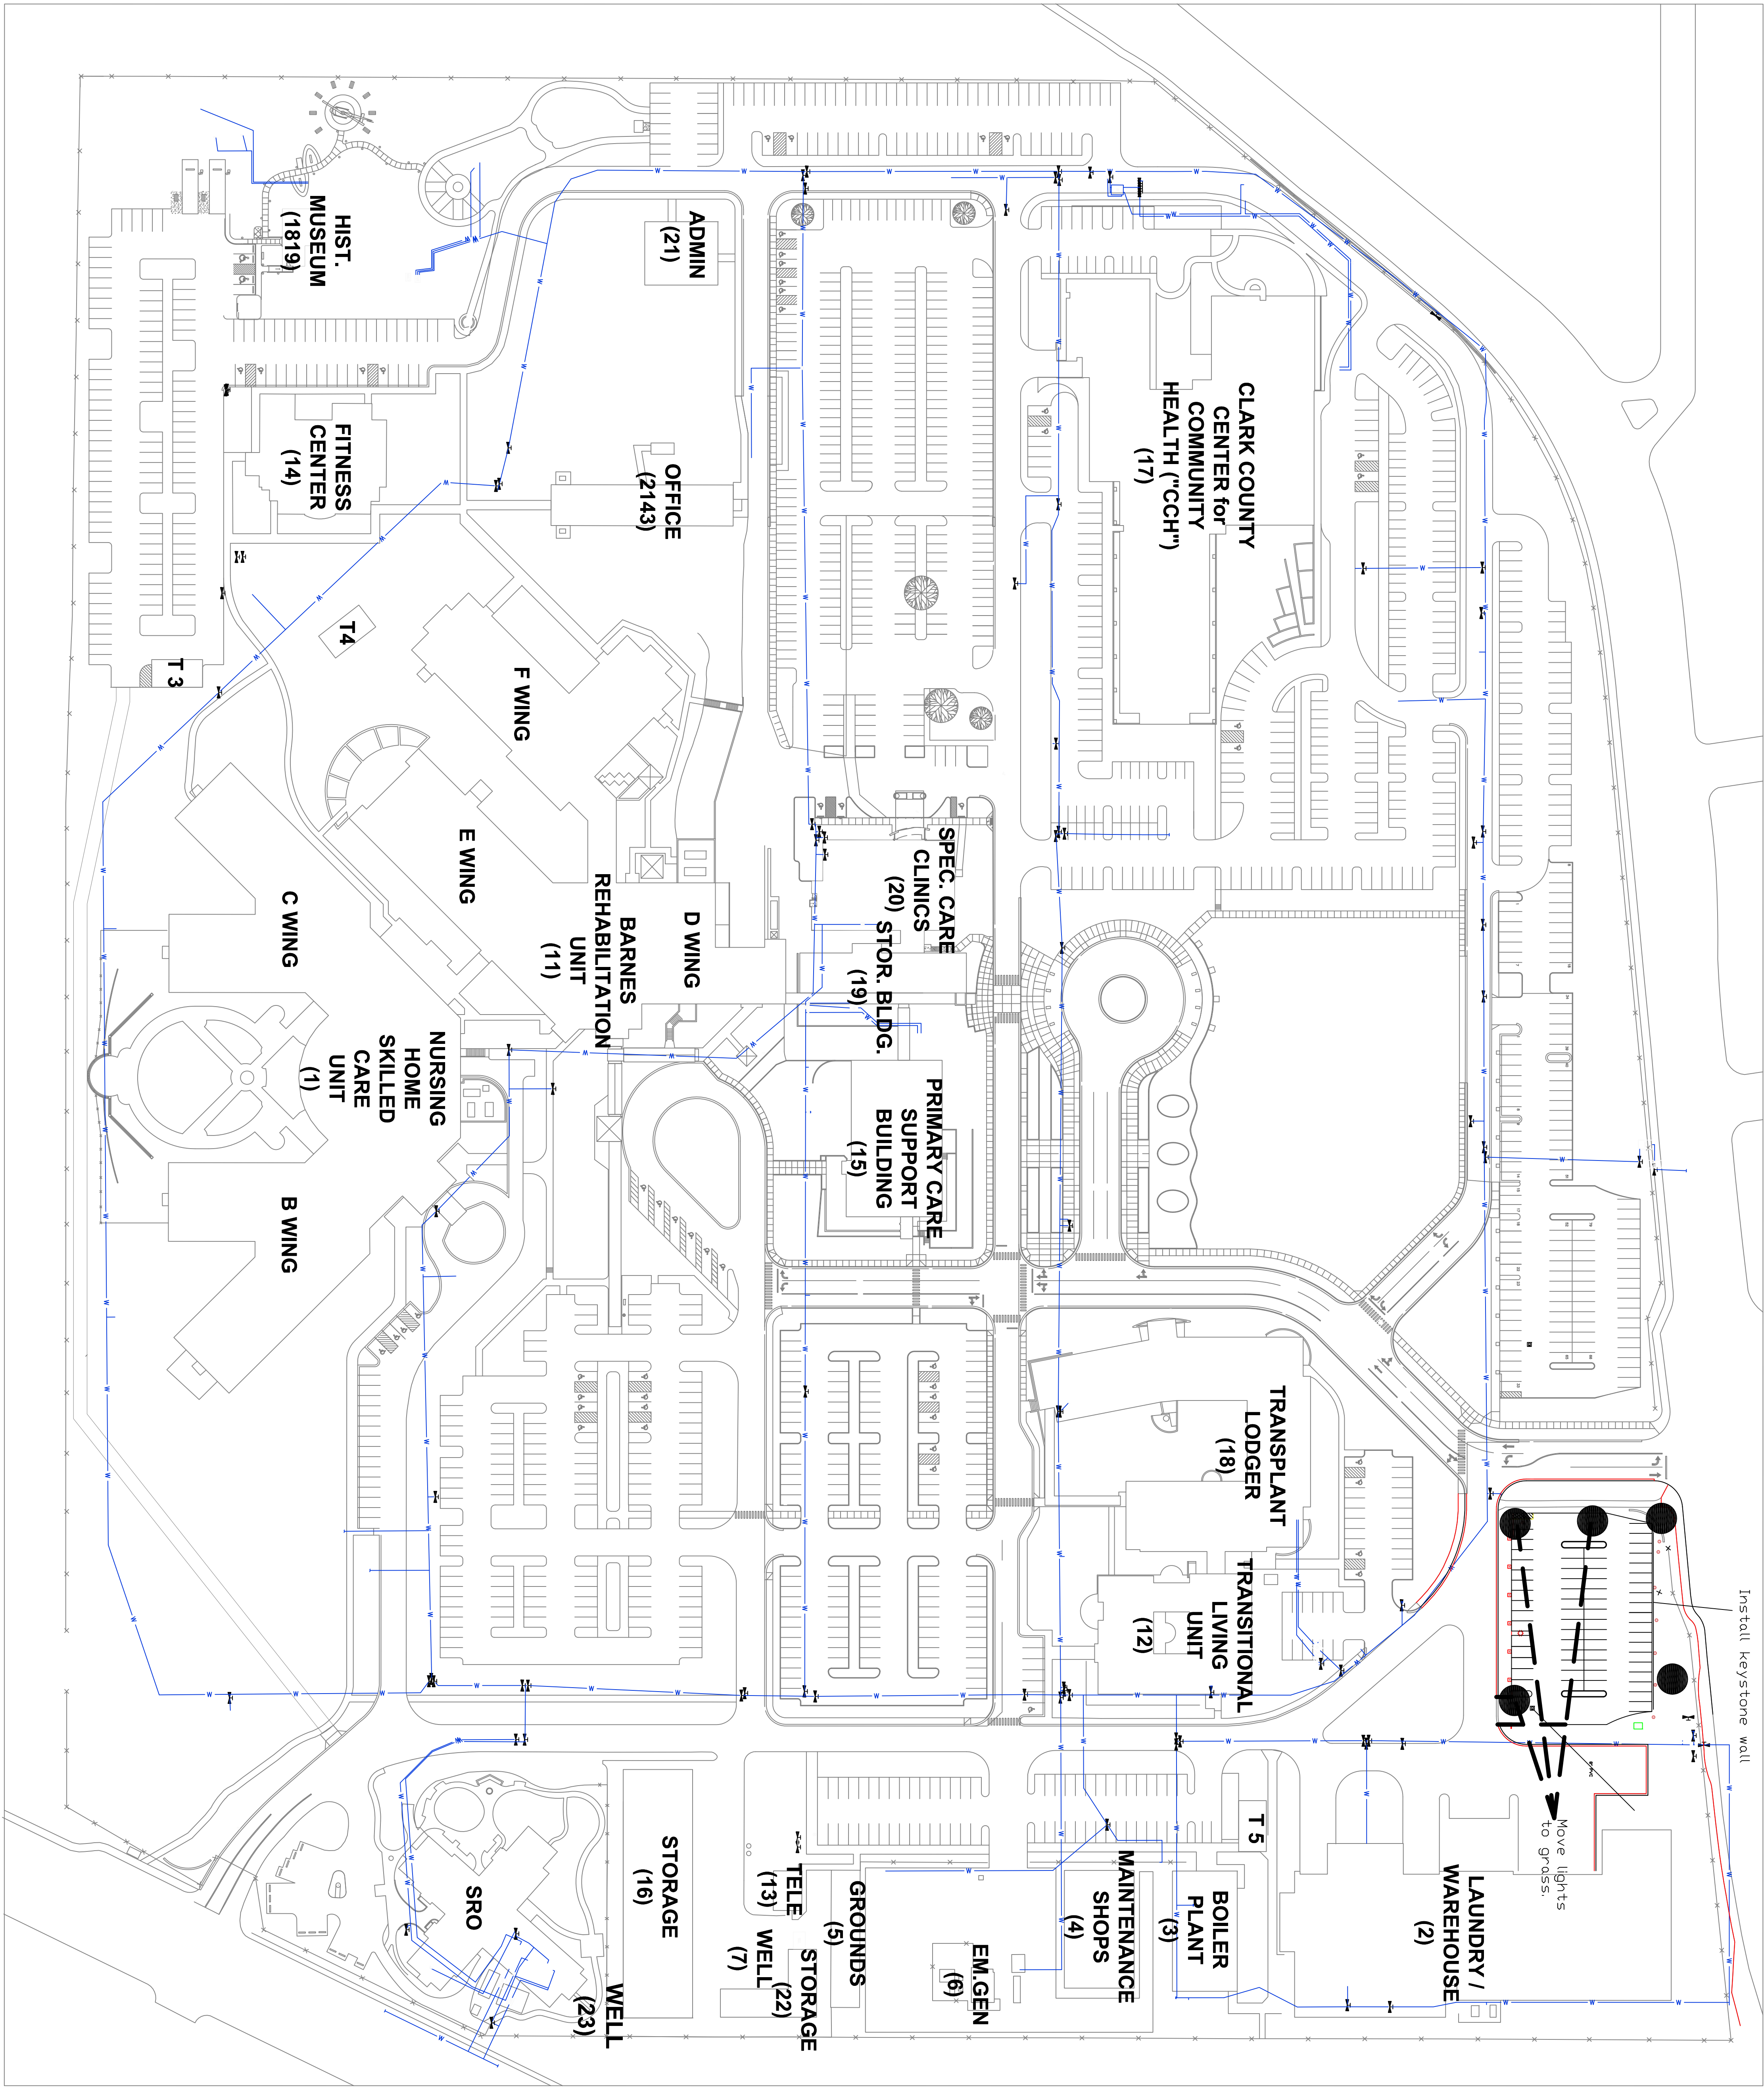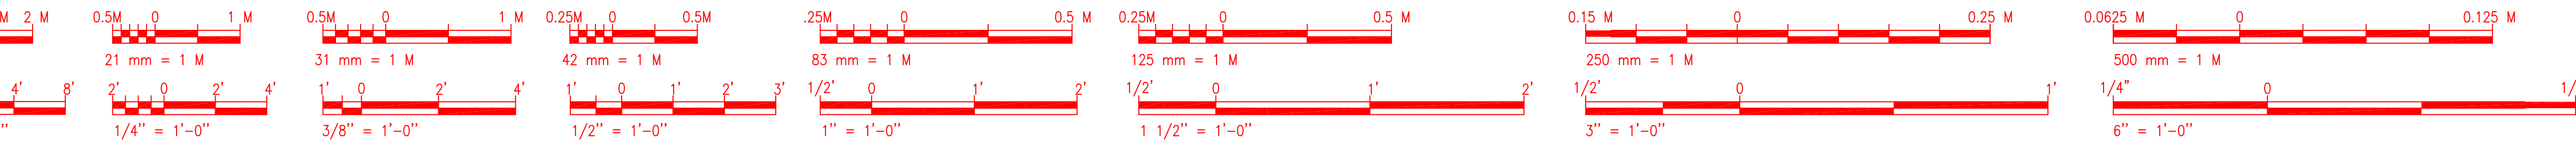

SCALE: 8' = 1'-0"

- SANITARY MANHOLE
- DRY WELL MANHOLE
- STORM MANHOLE
- GREASE INTERCEPTOR
- CATCH BASIN
- CATCH INLET
- CURB INLET
- DITCH INLET
- ROUND CATCH BASIN / AREA DRAIN
- ROOF DRAIN DOWN SPOUT
- BACK WATER VALVE
- SANITARY SEWER CLEAN OUT
- STORM SEWER CLEAN OUT
- NATURAL GAS METER
- NATURAL GAS VALVE
- FIRE HYDRANT
- POST INDICATOR VALVE
- ▲ WATER VALVE
- ▲ FIRE DEPARTMENT CONNECTION
- ▲ HOSE BIB
- ▲ IRRIGATION VALVE
- ▲ DOUBLE CHECK VALVE ASSEMBLY
- ▲ DOMESTIC DOUBLE CHECK VALVE
- ▲ WATER STORAGE TANK
- ▲ WATER WELL
- ▲ WATER METER
- ▲ WATER VALVE
- ▲ WATER MANHOLE
- ▲ FIRE PROTECTION
- ▲ COMMUNICATIONS VAULT
- ▲ COMMUNICATIONS MANHOLE
- ▲ COMMUNICATIONS RISER
- ▲ POWER VAULT
- ▲ POWER MANHOLE
- ▲ POWER RISER
- ▲ STREET SIGNAL BOX
- ▲ UNKNOWN VAULT
- ▲ UNKNOWN MANHOLE
- ▲ UNKNOWN STANDPIPE
- ▲ SITE STREET LIGHTING
- ▲ SANITARY SEWER PIPE
- ▲ SANITARY SEWER PIPE
- ▲ NATURAL GAS PIPE
- ▲ ELECTRICAL LINE
- ▲ WATER PIPE

Revisions	Date



**VETERANS AFFAIRS
MEDICAL CENTER**
VANCOUVER, WASHINGTON

SITE WATER SYSTEM			
Approved: Proj. Eng.	Approved: Infect. Contr.	Approved: Chief P&O	Approved: Chief M&E
Approved: Service Chief	Approved: Chief Facilities Mgmt	Approved: W&C Director	Approved: Safety Mgr.

Project Title	Date
SITE	2014.06.14
Building No.	Project No.
Drawn By/Proj. Mgr.	Drawn No.
Location VANCOUVER, WA	Dwg. of