


CADD Information CAD/FY06/B1/ARCH/B1-A-2	Drawing Title: B.1 SECOND FLOOR PLAN	Project Title ARCHITECTURAL ASBUILTS	Date 02/13
Approved:	Approved: Medical Center Director	Drawn C RYAN	Project No.
Approved:	Approved: Chief, Engineering	Building Number B. 1	DRAWING No. A-3
	Checked	Location VAMC, SLC. UTAH.	Dwg. 3 of 8

Department of
Veterans Affairs

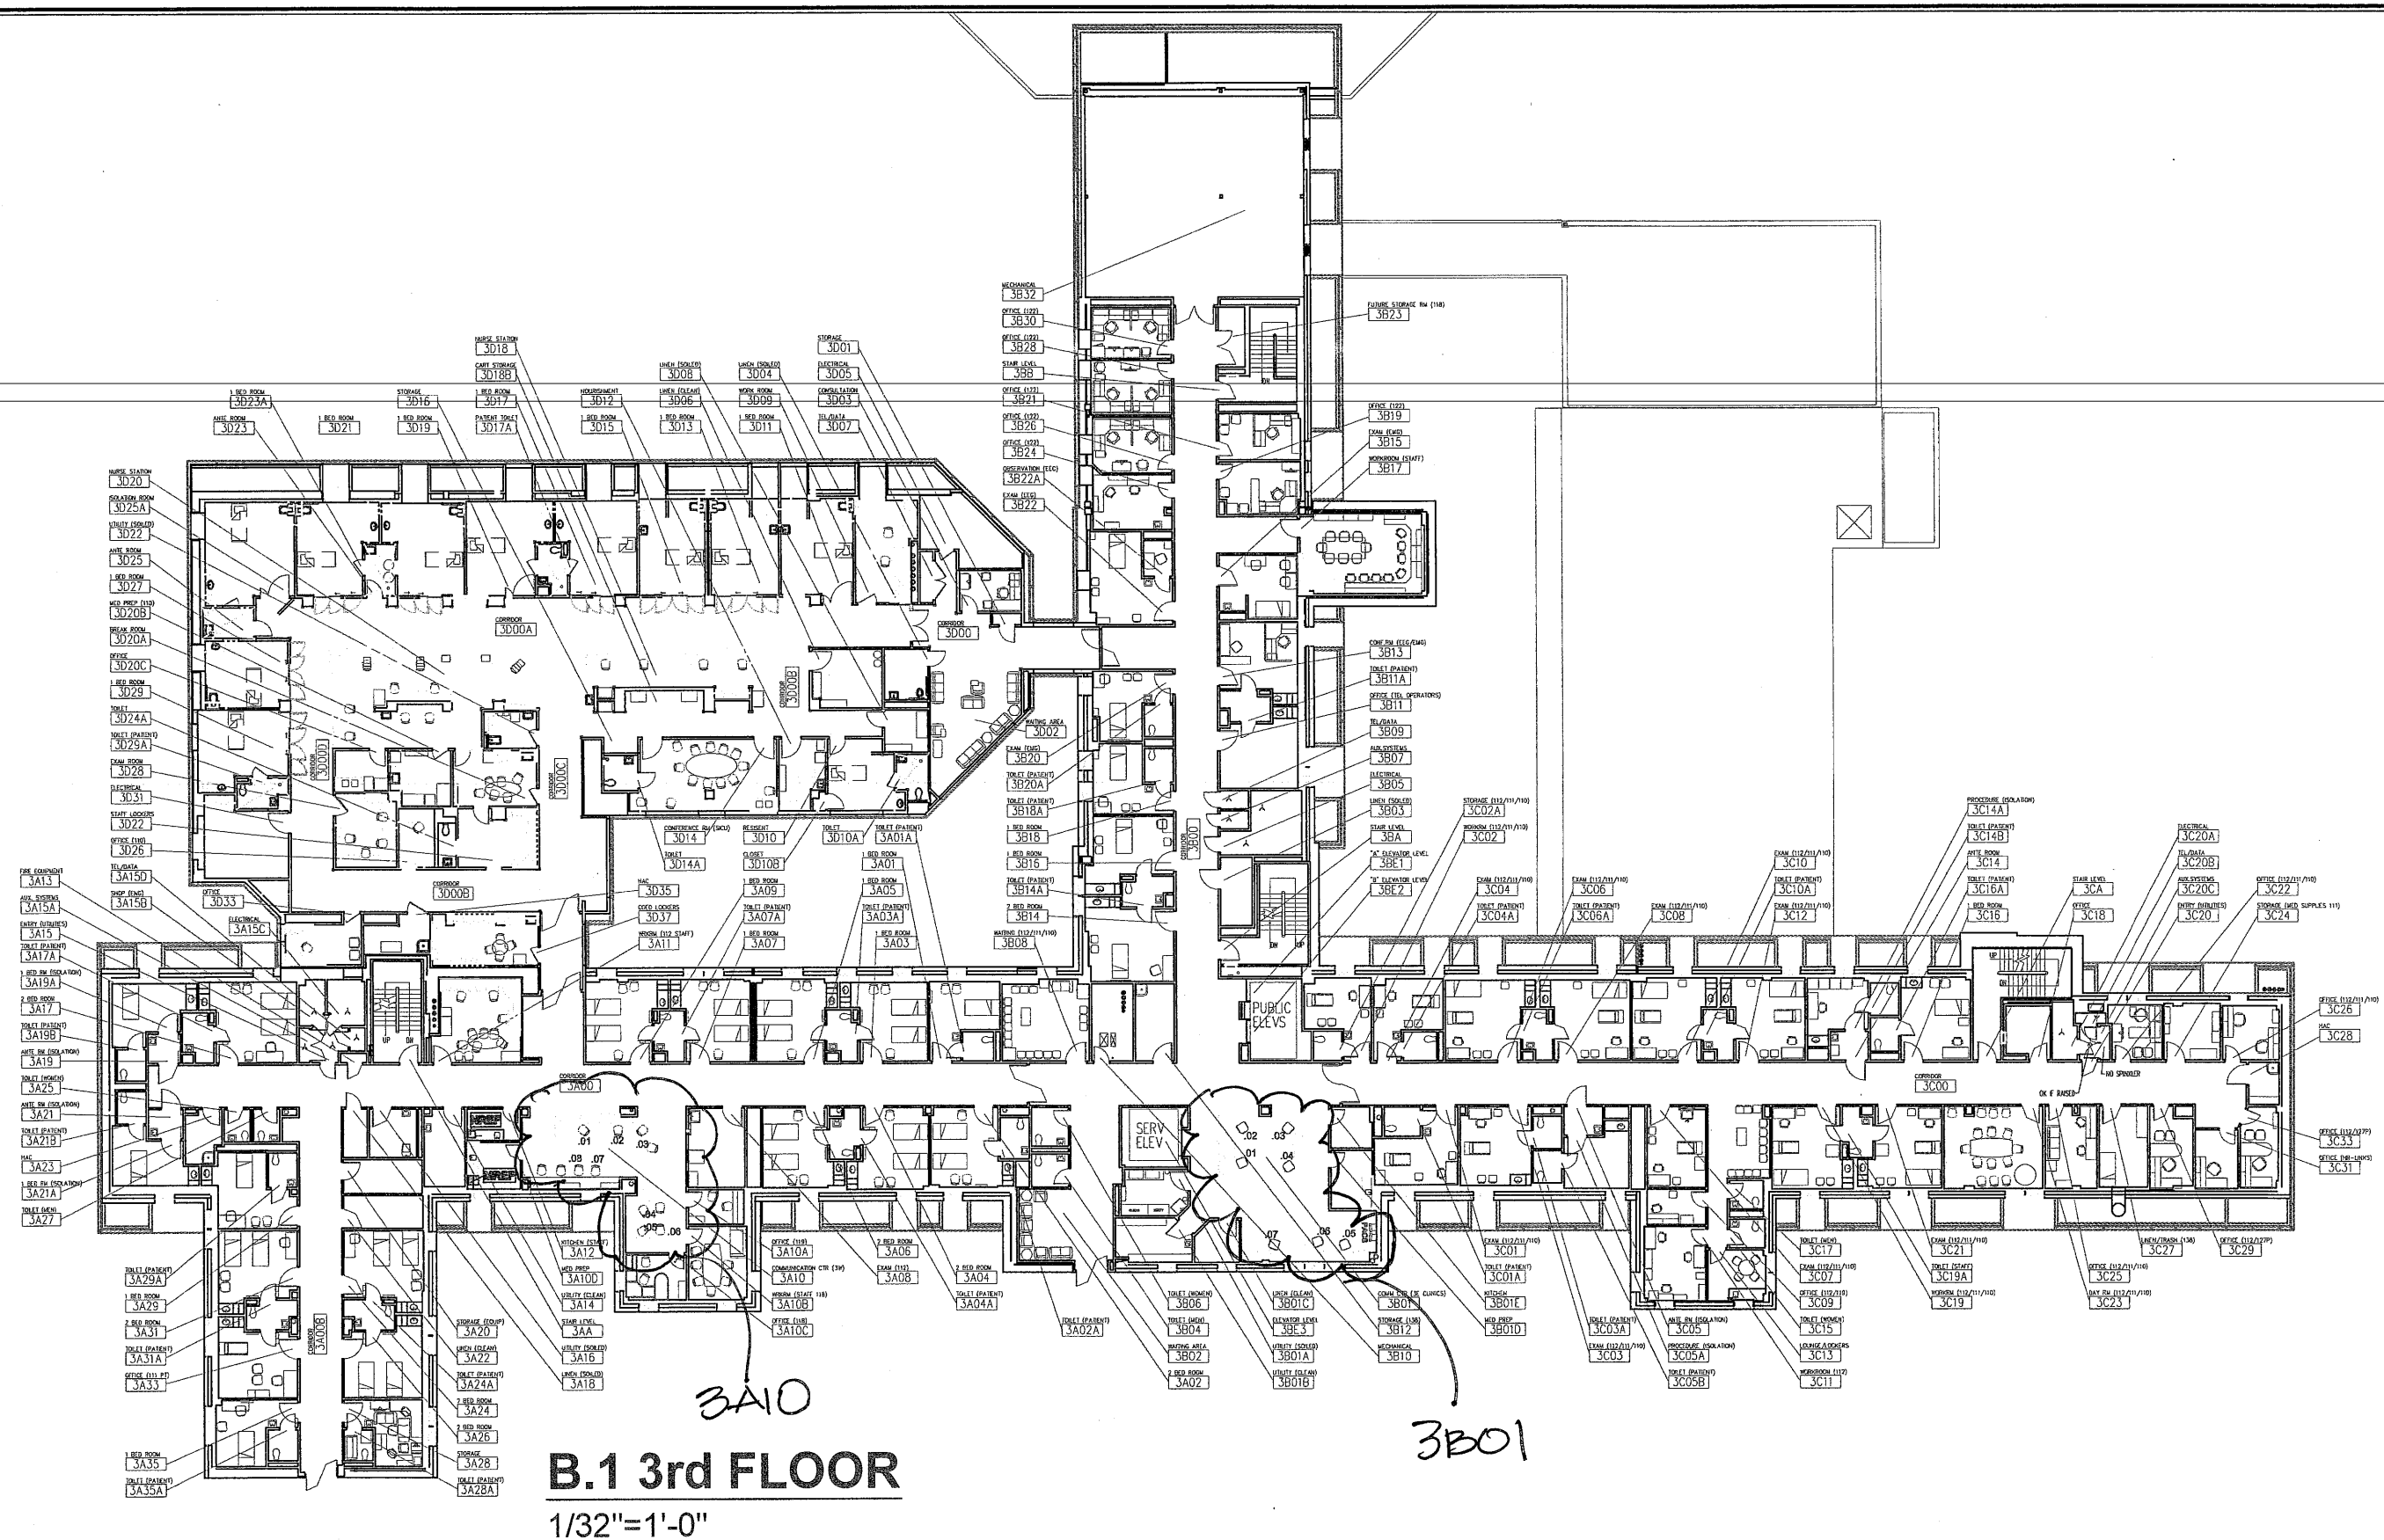

B.1 3rd FLOOR
1/32"=1'-0"

CADD Information CAD/FY06/B1/ARCH/B1-A-G		Drawing Title B.1 THIRD FLOOR PLAN		Project Title ARCHITECTURAL ASBUILTS		Date 02/13
Approved:		Approved: Medical Center Director		Building Number B. 1		Project No.
Approved:		Approved: Chief, Engineering		Location VAMC, SLIC. UTAH.		DRAWING No. A-4
		Checked C RYAN				Dwg. 4 of 8