


GENERAL NOTES:  
1. LIGHT FIXTURES SHOWN DASHED ARE EXISTING-TO-REMAIN UNLESS OTHERWISE NOTED.


The seal appearing on this document was authorized by the State of Oklahoma on 5/28/2013. Alteration of a sealed document without proper notation to the responsible engineer is an offense under the Oklahoma Engineering Practice Act.

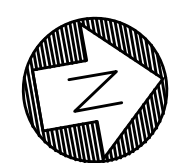

**LEVEL 2, C WING: LIGHTING PLAN**  
1/8"=1'-0"

ASBESTOS NOTE:  
IF THE EXECUTION OF THIS WORK REQUIRES THE DISTURBING OF ANY SUBSTANCE WHICH APPEARS TO BE ASBESTOS OR WHICH MAY CONTAIN ASBESTOS FIBER, NOTIFY THE OWNER BEFORE CONTINUING WORK AT THE SUSPECT LOCATION. ANY MATERIAL TESTING POSITIVE SHALL BE REMOVED BY THE OWNER BEFORE WORK CONTINUES.

NOTE: EXISTING CONDITIONS SHOWN WERE DERIVED FROM OWNER FURNISHED DRAWINGS AND FIELD OBSERVATIONS. SOME BUILDING FEATURES AND MEP SYSTEMS ARE NOT SHOWN FOR CLARITY. FIELD VERIFY BUILDING CONSTRUCTION. FIELD VERIFY THE LOCATION, SIZE AND QUANTITY OF ALL EQUIPMENT.

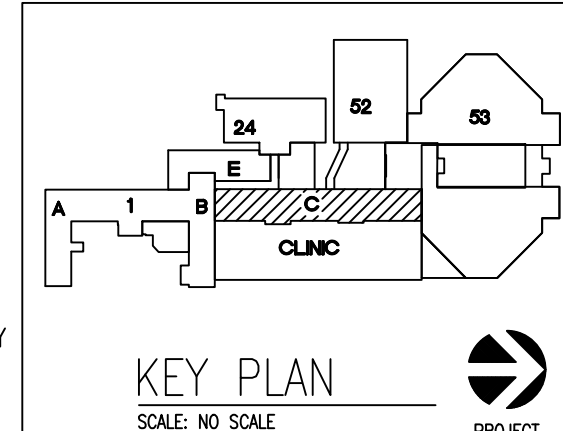

REVISIONS	DESCRIPTION	DATE



Dept. of Veterans Affairs  
Jack C. Montgomery  
Medical Center  
1011 Honor Heights Drive  
Muskogee, Oklahoma 74401

**ENGINEER:**

RMD CONSULTING, LLC  
2815 VALLEY VIEW LANE, STE. 214  
DALLAS, TX 75234  
P: 972-488-8077 F: 972-488-8174  
PROJECT NUMBER: 11-5801  
OK REG. ENGINEERING FIRM: 5183


**CONSULTANTS:**

ARCHITECT:  
ARCHITECTURAL CONCEPTS, INC.  
669 AIRPORT FREEWAY, STE. 300  
HURST, TX 76053  
P: 817-285-8885 F: 817-285-8021

APPROVED:	APPROVED: Interior Designer	APPROVED: Safety Manager	APPROVED: Medical Center Director
APPROVED:	APPROVED:	APPROVED: Infection Control Nurse	APPROVED: Associate Director
APPROVED:	APPROVED:	APPROVED: Industrial Hygienist	APPROVED: Chief of Staff
APPROVED:	APPROVED:	APPROVED: President A.F.G.E. 2250	APPROVED: Chief of Engineering Service


DRAWING TITLE	PROJECT TITLE	DATE
LEVEL 2, C WING: LIGHTING PLAN	REPLACE INDUCTION UNITS IN BLDG. #1	5/28/2013
PROJECT NO. 623-10-104	CONTRACT NO. VA256-P-1355	SCALE AS NOTED
BUILDING NO. 01	AUTOCAD FILE NAME	DESIGNED BY SRC/TGB
		DRAWN BY SRC/TGB
		CHECKED BY SRC
		DRAWING NO. 1-EL2.1
		DWG. 94 OF 97

DEPARTMENT OF  
VETERANS AFFAIRS

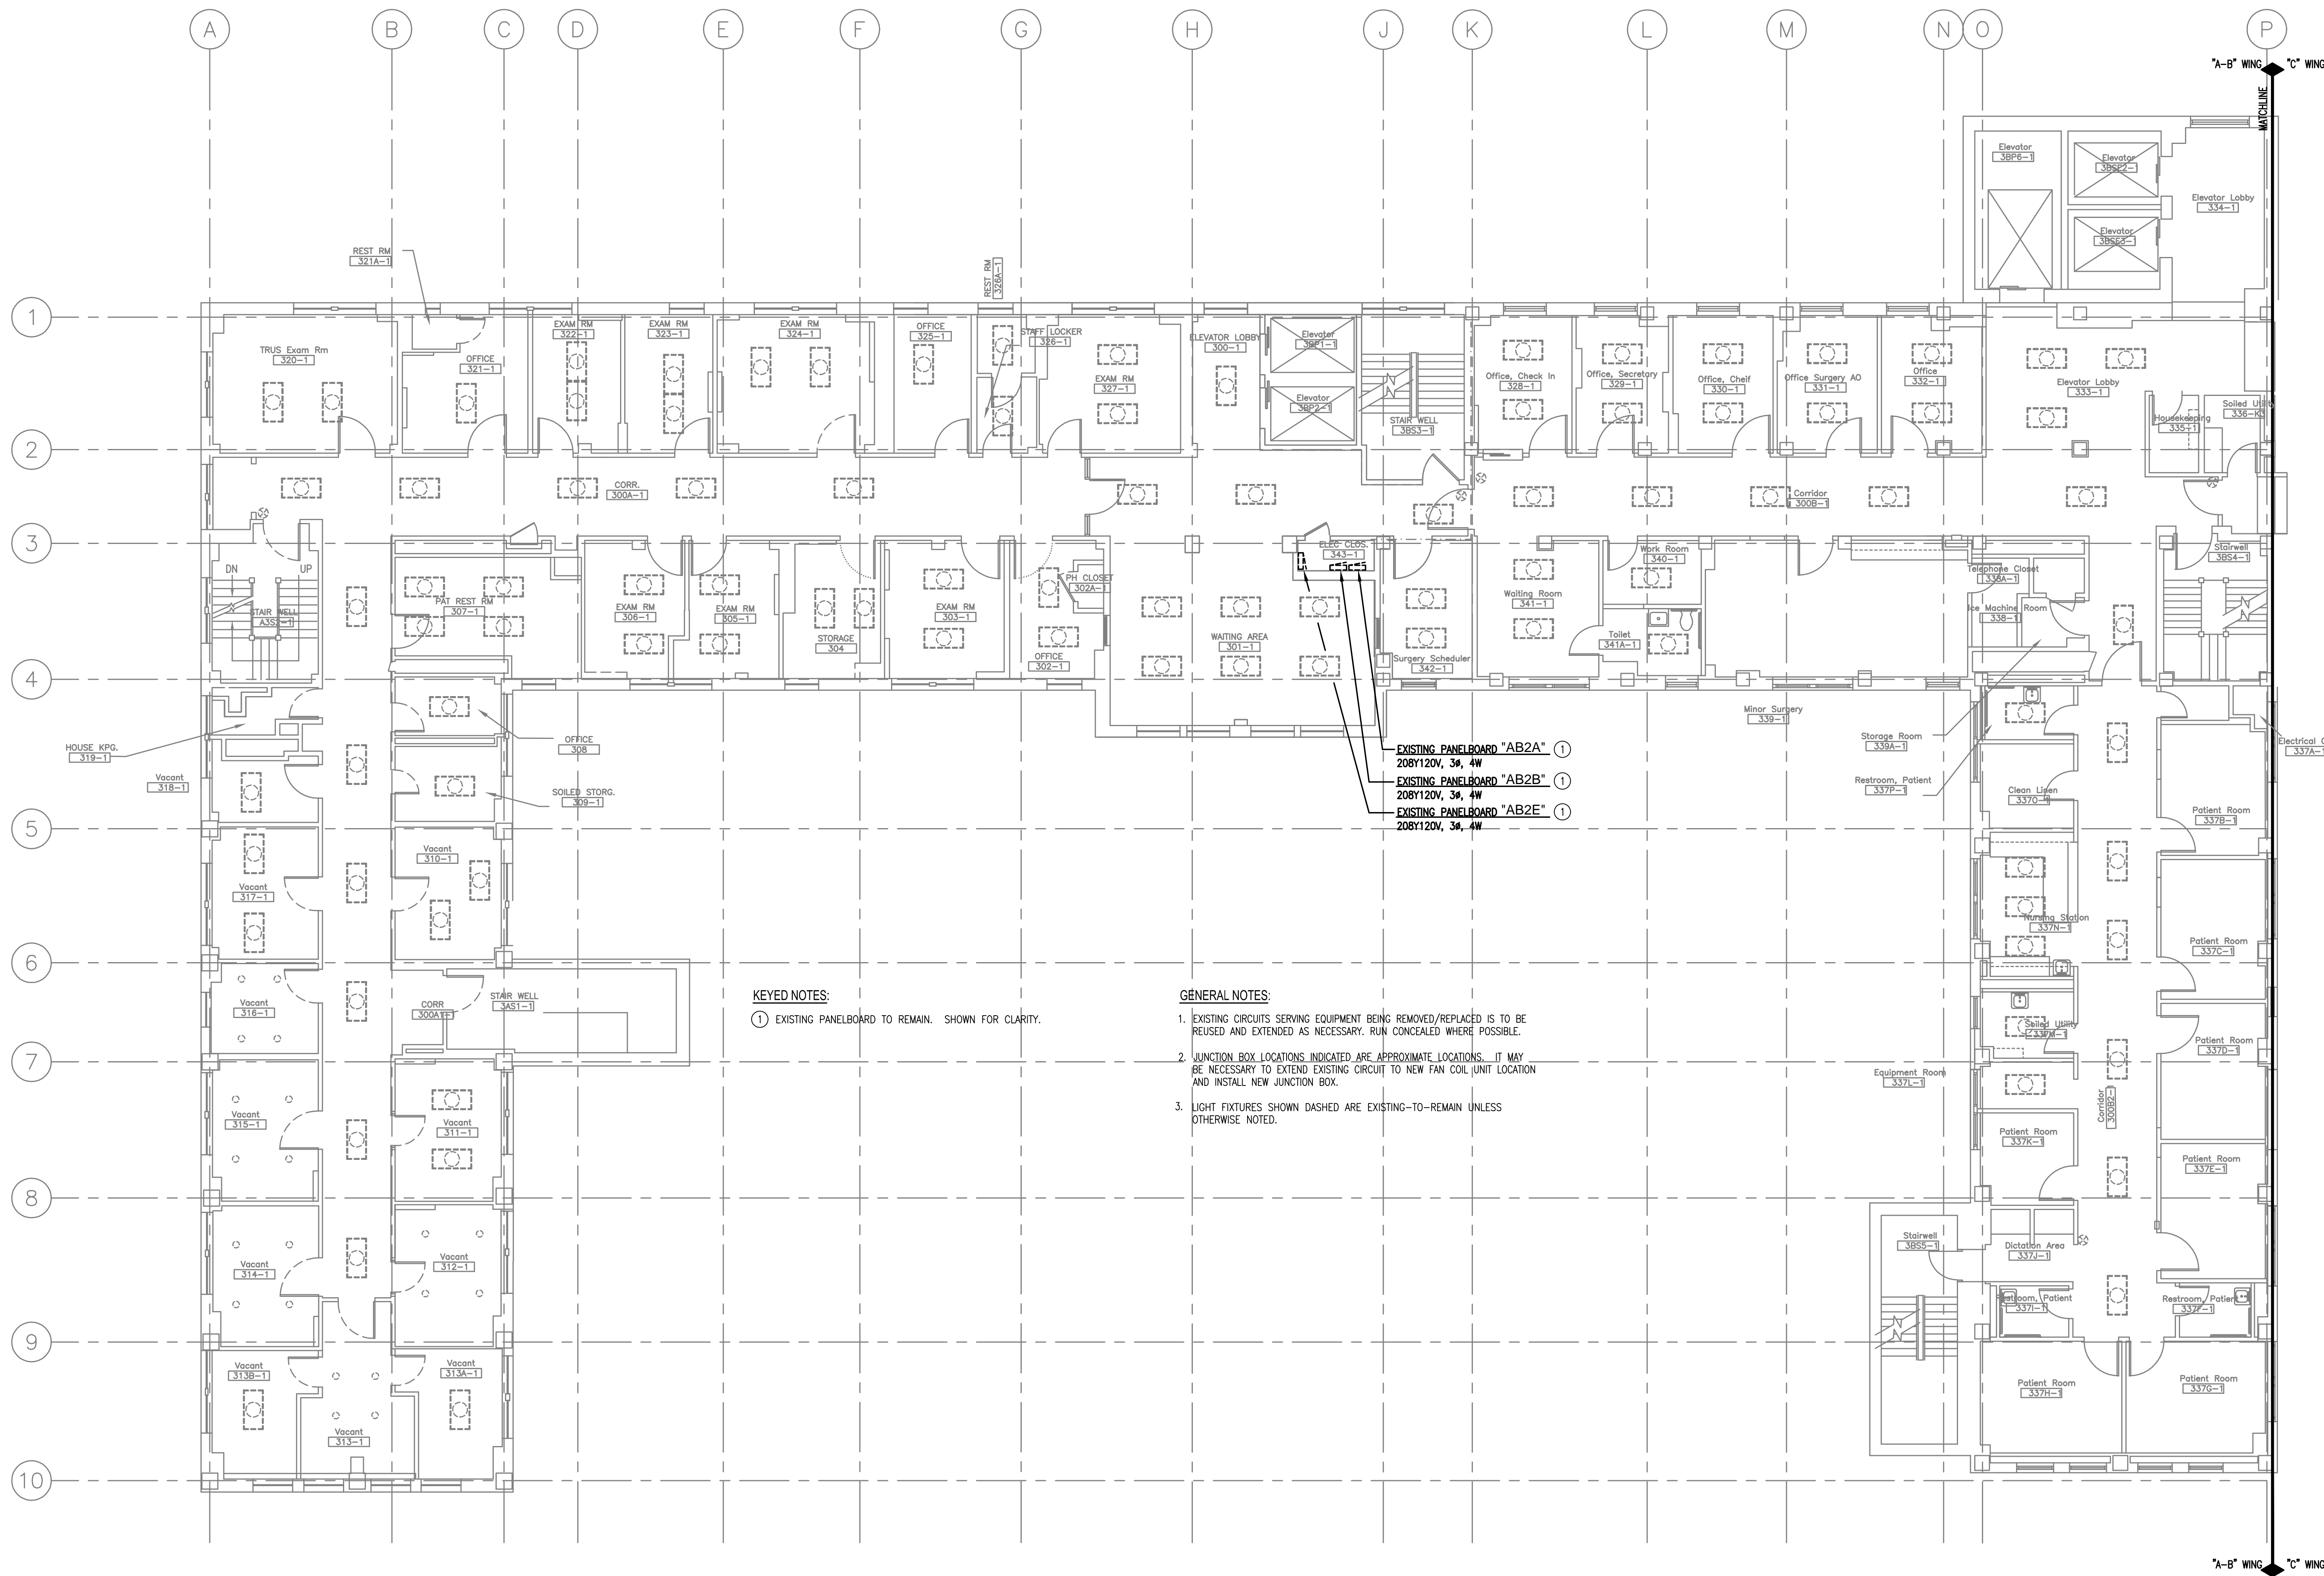

**KEYED NOTES:**  
① EXISTING PANELBOARD TO REMAIN. SHOWN FOR CLARITY.

**GENERAL NOTES:**  
1. EXISTING CIRCUITS SERVING EQUIPMENT BEING REMOVED/REPLACED IS TO BE REVISED AND EXTENDED AS NECESSARY. RUN CONCEALED WHERE POSSIBLE.  
2. JUNCTION BOX LOCATIONS INDICATED ARE APPROXIMATE LOCATIONS. IT MAY BE NECESSARY TO EXTEND EXISTING CIRCUIT TO NEW FAN COIL UNIT LOCATION AND INSTALL NEW JUNCTION BOX.  
3. LIGHT FIXTURES SHOWN DASHED ARE EXISTING-TO-REMAIN UNLESS OTHERWISE NOTED.

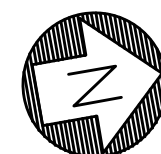

**LEVEL 3, A-B WING: LIGHTING PLAN**

1/8"=1'-0"


The seal appearing on this document was authorized by the State of Oklahoma on 5/28/2013. Alteration of a sealed document without proper notation to the responsible engineer is an offense under the Oklahoma Engineering Practice Act.



5/28/2013

**ASBESTOS NOTE:**  
IF THE EXECUTION OF THIS WORK REQUIRES THE DISTURBING OF ANY SUBSTANCE WHICH APPEARS TO BE ASBESTOS OR WHICH MAY CONTAIN ASBESTOS FIBER, NOTIFY THE OWNER BEFORE CONTINUING WORK AT THE SUSPECT LOCATION. ANY MATERIAL TESTING POSITIVE SHALL BE REMOVED BY THE OWNER BEFORE WORK CONTINUES.

**NOTE:** EXISTING CONDITIONS SHOWN WERE DERIVED FROM OWNER FURNISHED DRAWINGS AND FIELD OBSERVATIONS. SOME BUILDING FEATURES AND MEP SYSTEMS ARE NOT SHOWN FOR CLARITY. FIELD VERIFY BUILDING CONSTRUCTION. FIELD VERIFY THE LOCATION, SIZE AND QUANTITY OF ALL EQUIPMENT.

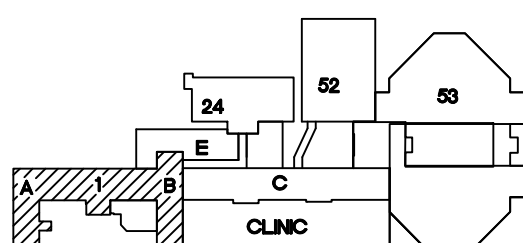

**KEY PLAN**  
SCALE: NO SCALE  
PROJECT NORTH

REVISIONS	DESCRIPTION	DATE



Dept. of Veterans Affairs  
Jack C. Montgomery  
Medical Center  
1011 Honor Heights Drive  
Muskogee, Oklahoma 74401

**ENGINEER:**

RMD CONSULTING, LLC  
2815 VALLEY VIEW LANE, STE. 314  
DALLAS, TX 75234  
P: 972-488-8077 F: 972-488-8174  
PROJECT NUMBER: 11-5801  
OK REG. ENGINEERING FIRM: 5183

**CONSULTANTS:**

ARCHITECT:  
ARCHITECTURAL CONCEPTS, INC.  
669 AIRPORT FREEWAY, STE. 300  
HURST, TX 76053  
P: 817-285-8885 F: 817-285-8021

APPROVED:	APPROVED: Interior Designer
APPROVED:	APPROVED:
APPROVED:	APPROVED:
APPROVED:	APPROVED:

APPROVED: Safety Manager
APPROVED: Infection Control Nurse
APPROVED: Industrial Hygienist
APPROVED: President A.F.G.E. 2250

APPROVED: Medical Center Director
APPROVED: Associate Director
APPROVED: Chief of Staff
APPROVED: Chief of Engineering Service

DRAWING TITLE
LEVEL 3, A-B WING: LIGHTING PLAN
PROJECT NO.
623-10-104
BUILDING NO.
01


CONTRACT NO.
VA256-P-1355
AUTOCAD FILE NAME

PROJECT TITLE
REPLACE INDUCTION UNITS IN BLDG. #1
DESIGNED BY
SRC/TGB
DRAWN BY
SRC/TGB
CHECKED BY
SRC

DATE
5/28/2013
SCALE
AS NOTED
DRAWING NO.
1-EL3.0
DWG. 95 OF 97

LOCATION
Jack C. Montgomery VA Medical Center

DEPARTMENT OF  
VETERANS AFFAIRS

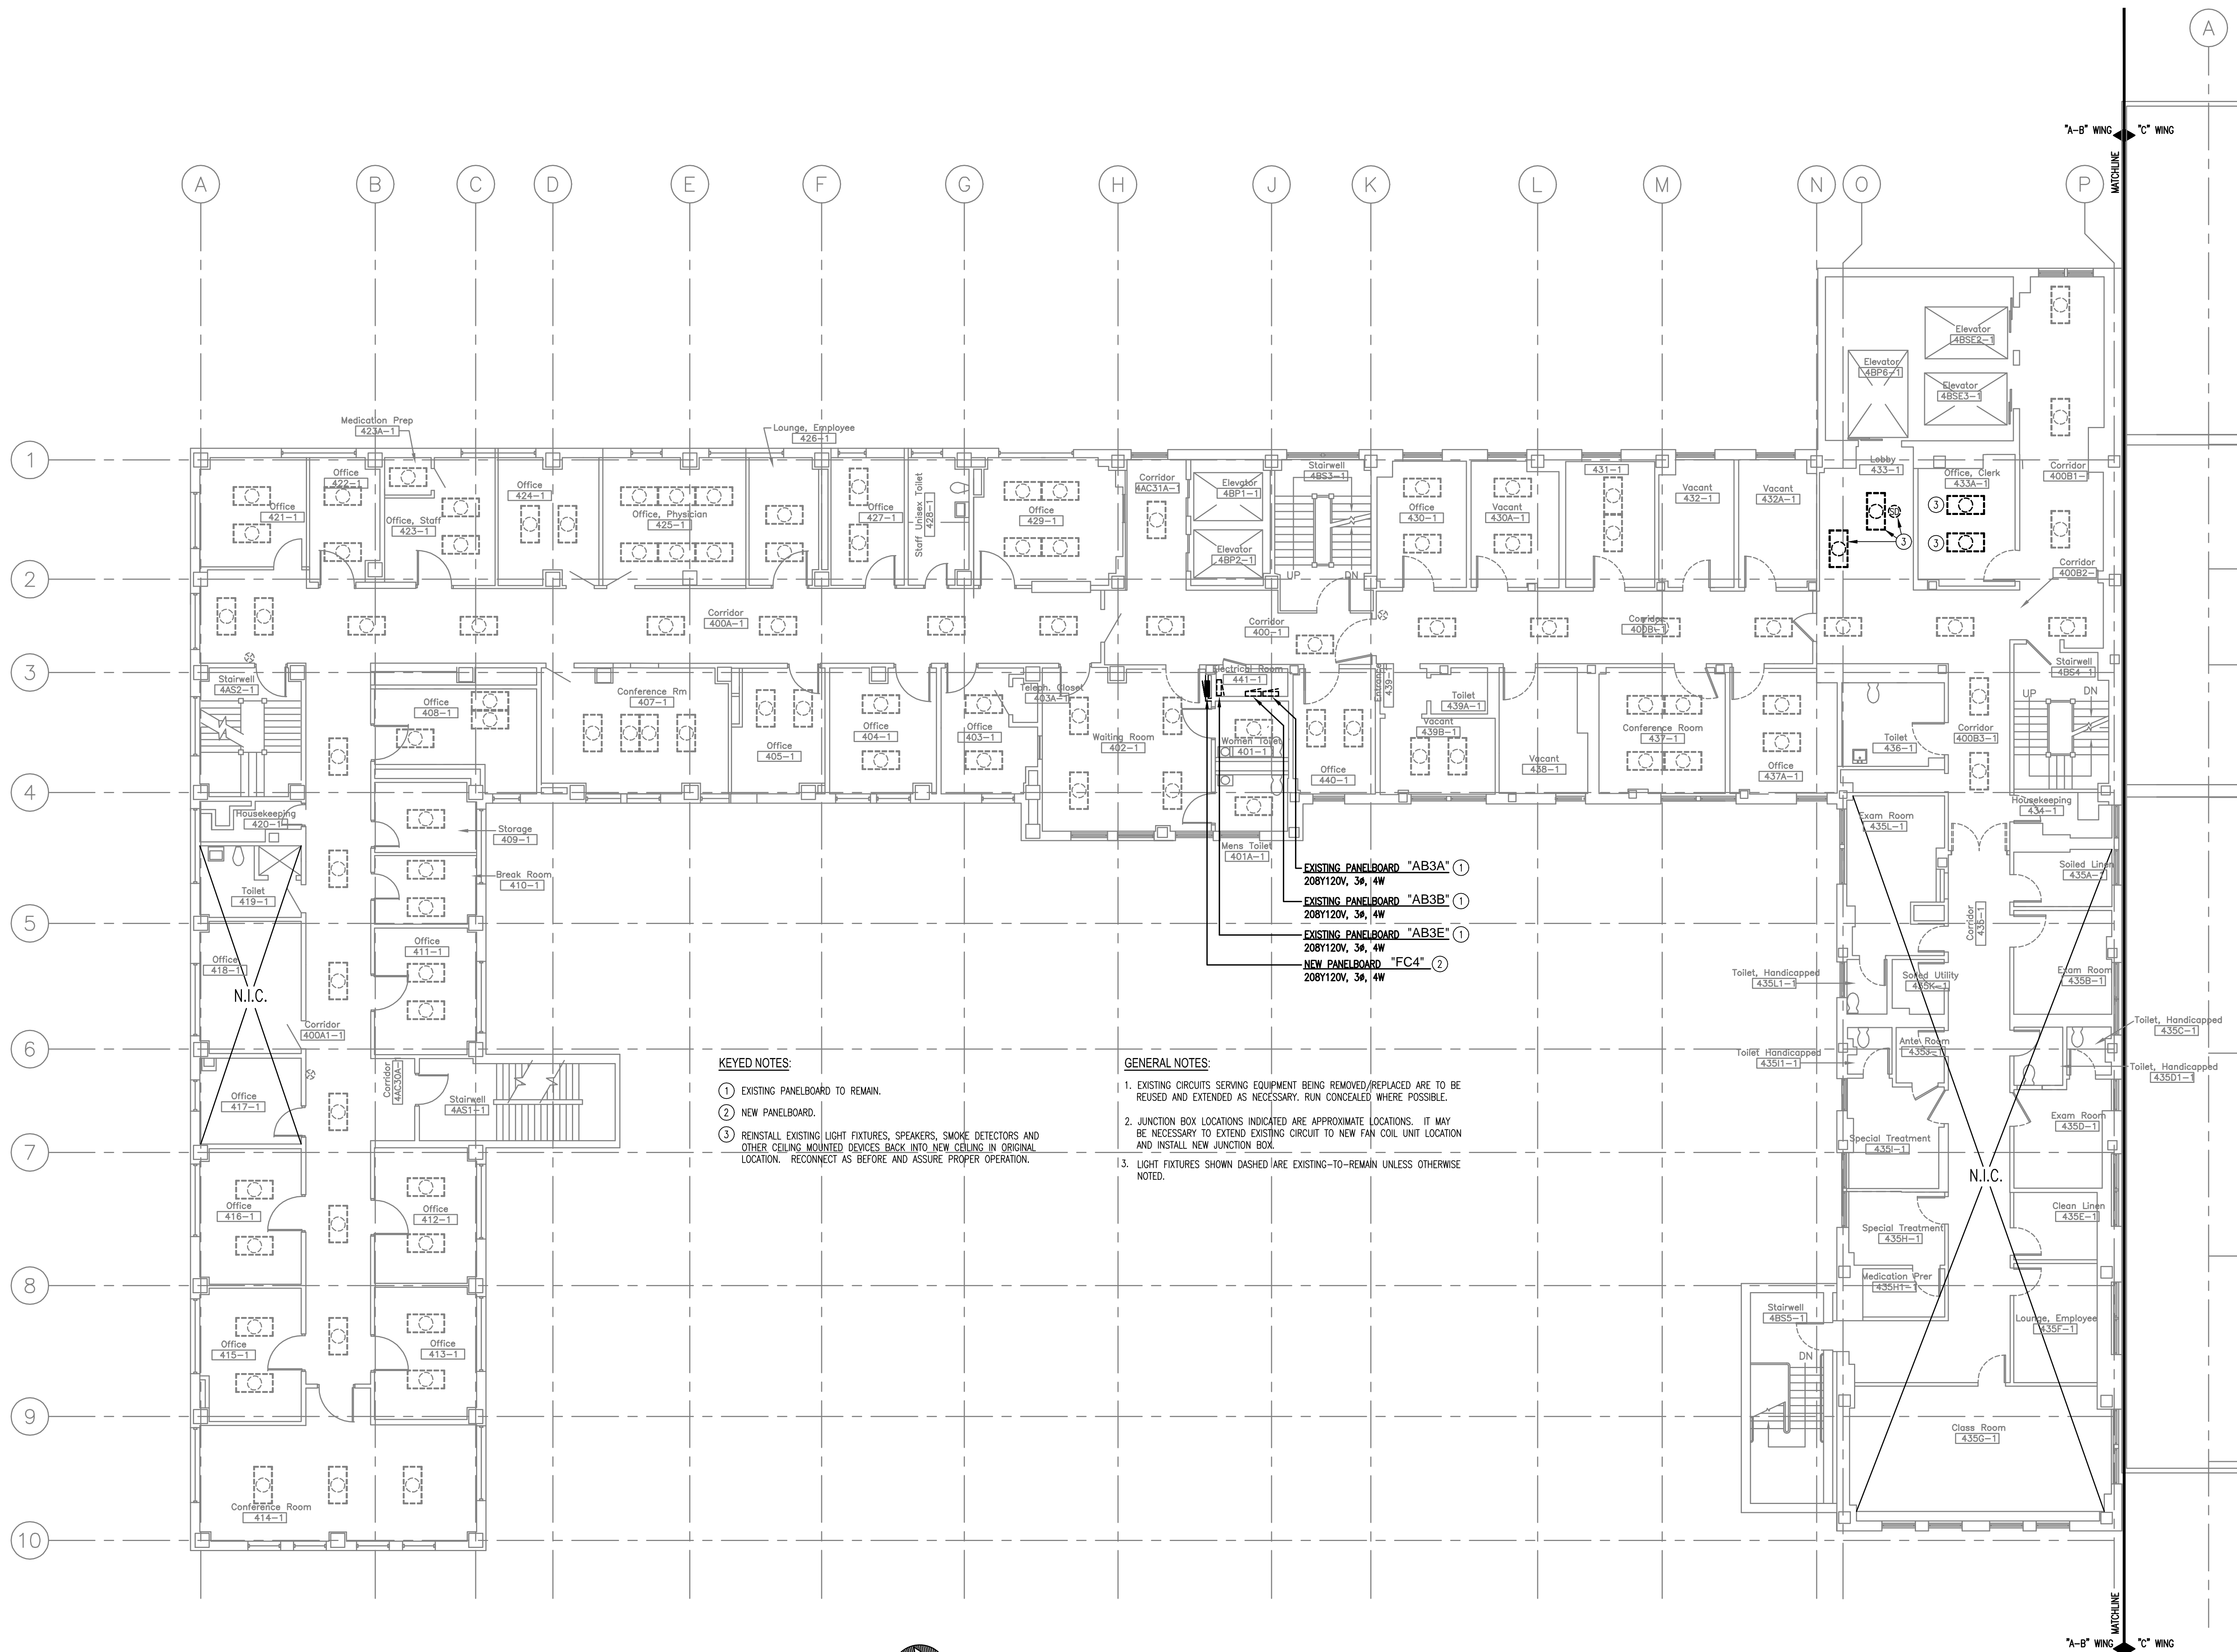


KEYED NOTES:

- EXISTING PANELBOARD TO REMAIN.
- NEW PANELBOARD.
- REINSTALL EXISTING LIGHT FIXTURES, SPEAKERS, SMOKE DETECTORS AND OTHER CEILING MOUNTED DEVICES BACK INTO NEW CEILING IN ORIGINAL LOCATION. RECONNECT AS BEFORE AND ASSURE PROPER OPERATION.

GENERAL NOTES:


- EXISTING CIRCUITS SERVING EQUIPMENT BEING REMOVED/REPLACED ARE TO BE REUSED AND EXTENDED AS NECESSARY. RUN CONCEALED WHERE POSSIBLE.
- JUNCTION BOX LOCATIONS INDICATED ARE APPROXIMATE LOCATIONS. IT MAY BE NECESSARY TO EXTEND EXISTING CIRCUIT TO NEW FAN COIL UNIT LOCATION AND INSTALL NEW JUNCTION BOX.
- LIGHT FIXTURES SHOWN DASHED ARE EXISTING-TO-REMAIN UNLESS OTHERWISE NOTED.

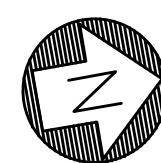


1 LEVEL 4, A-B WING: LIGHTING PLAN

1/8"=1'-0"

The seal appearing on this document was  
authorized by the State of Oklahoma on  
5/28/2013. Alteration of a sealed document  
without proper notation to the responsible  
engineer is an offense under the  
Oklahoma Engineering Practice Act.

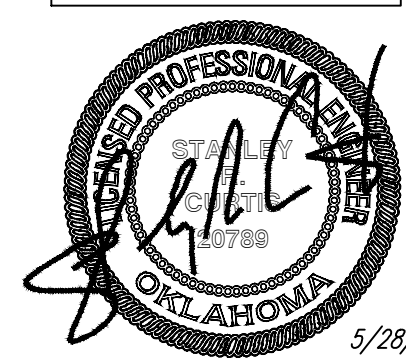

5/28/2013

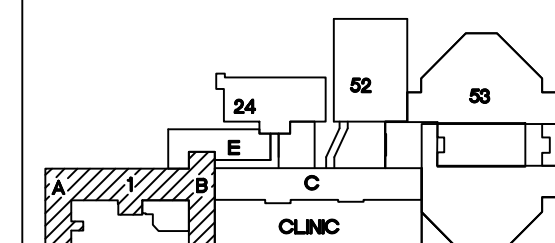

KEY PLAN  
SCALE: NO SCALE



ASBESTOS NOTE:  
IF THE EXECUTION OF THIS WORK REQUIRES THE DISTURBING OF ANY SUBSTANCE WHICH APPEARS TO BE ASBESTOS OR  
WHICH MAY CONTAIN ASBESTOS FIBER, NOTIFY THE OWNER BEFORE CONTINUING WORK AT THE SUSPECT LOCATION. ANY  
MATERIAL TESTING POSITIVE SHALL BE REMOVED BY THE OWNER BEFORE WORK CONTINUES.

NOTE: EXISTING CONDITIONS SHOWN WERE DERIVED FROM OWNER FURNISHED DRAWINGS AND FIELD OBSERVATIONS. SOME  
BUILDING FEATURES AND MEP SYSTEMS ARE NOT SHOWN FOR CLARITY. FIELD VERIFY BUILDING CONSTRUCTION. FIELD VERIFY  
THE LOCATION, SIZE AND QUANTITY OF ALL EQUIPMENT.

REVISIONS	DESCRIPTION	DATE



Dept. of Veterans Affairs  
Jack C. Montgomery  
Medical Center  
1011 Honor Heights Drive  
Muskogee, Oklahoma 74401

ENGINEER:

RMD CONSULTING, LLC  
2815 VALLEY VIEW LANE, STE. 214  
DALLAS, TX 75234  
P: 972-488-8077 F: 972-488-8174  
PROJECT NUMBER: 11-5801  
OK REG. ENGINEERING FIRM: 5183

CONSULTANTS:

ARCHITECT:  
ARCHITECTURAL CONCEPTS, INC.  
669 AIRPORT FREEWAY, STE. 300  
HURST, TX 76053  
P: 817-285-8885 F: 817-285-8021

APPROVED:

APPROVED:

APPROVED:

APPROVED:

APPROVED: Interior Designer

APPROVED:

APPROVED:

APPROVED:

APPROVED: Safety Manager

APPROVED: Infection Control Nurse

APPROVED: Industrial Hygienist

APPROVED: President A.F.G.E. 2250

APPROVED: Medical Center Director

APPROVED: Associate Director

APPROVED: Chief of Staff

APPROVED: Chief of Engineering Service

DRAWING TITLE

LEVEL 4, A-B WING:  
LIGHTING PLAN

PROJECT NO.  
623-10-104

BUILDING NO.  
01

CONTRACT NO.  
VA256-P-1355

AUTOCAD FILE NAME

PROJECT TITLE

REPLACE INDUCTION  
UNITS IN BLDG. #1

DESIGNED BY:  
SRC/TGB

DRAWN BY:  
SRC/TGB

CHECKED BY:  
SRC

LOCATION  
Jack C. Montgomery VA Medical Center

DATE  
5/28/2013

SCALE  
AS NOTED

DRAWING NO.  
1-EL4.0

DWG. 96 OF 97

DEPARTMENT OF  
VETERANS AFFAIRS