


LEGEND:


- NEW SPRINKLER
- EXISTING SPRINKLER - TO REMAIN
- NEW SPRINKLER PIPE
- EXISTING SPRINKLER PIPE - TO REMAIN


GENERAL NOTES:

- EXISTING CEILING TO BE REMOVED AND REPLACED IN NOTED AREA. EXISTING SPRINKLERS TO REMAIN AT SAME ELEVATION.
- ALL EXISTING SPRINKLERS AND PIPING ARE TO REMAIN. CONTRACTOR SHALL REMOVE/REPLACE ESCUTCHEON PLATES TO FACILITATE REMOVAL OF EXISTING CEILING AND INSTALLATION OF NEW CEILING.
- CONTRACTOR SHALL FIELD VERIFY ALL INFORMATION CONTAINED ON THE DESIGN DRAWINGS AND IS RESPONSIBLE FOR THE INSTALLATION OF THE SYSTEM IN ACCORDANCE WITH NFPA 13-2010 AND THE DESIGN SPECIFICATIONS.

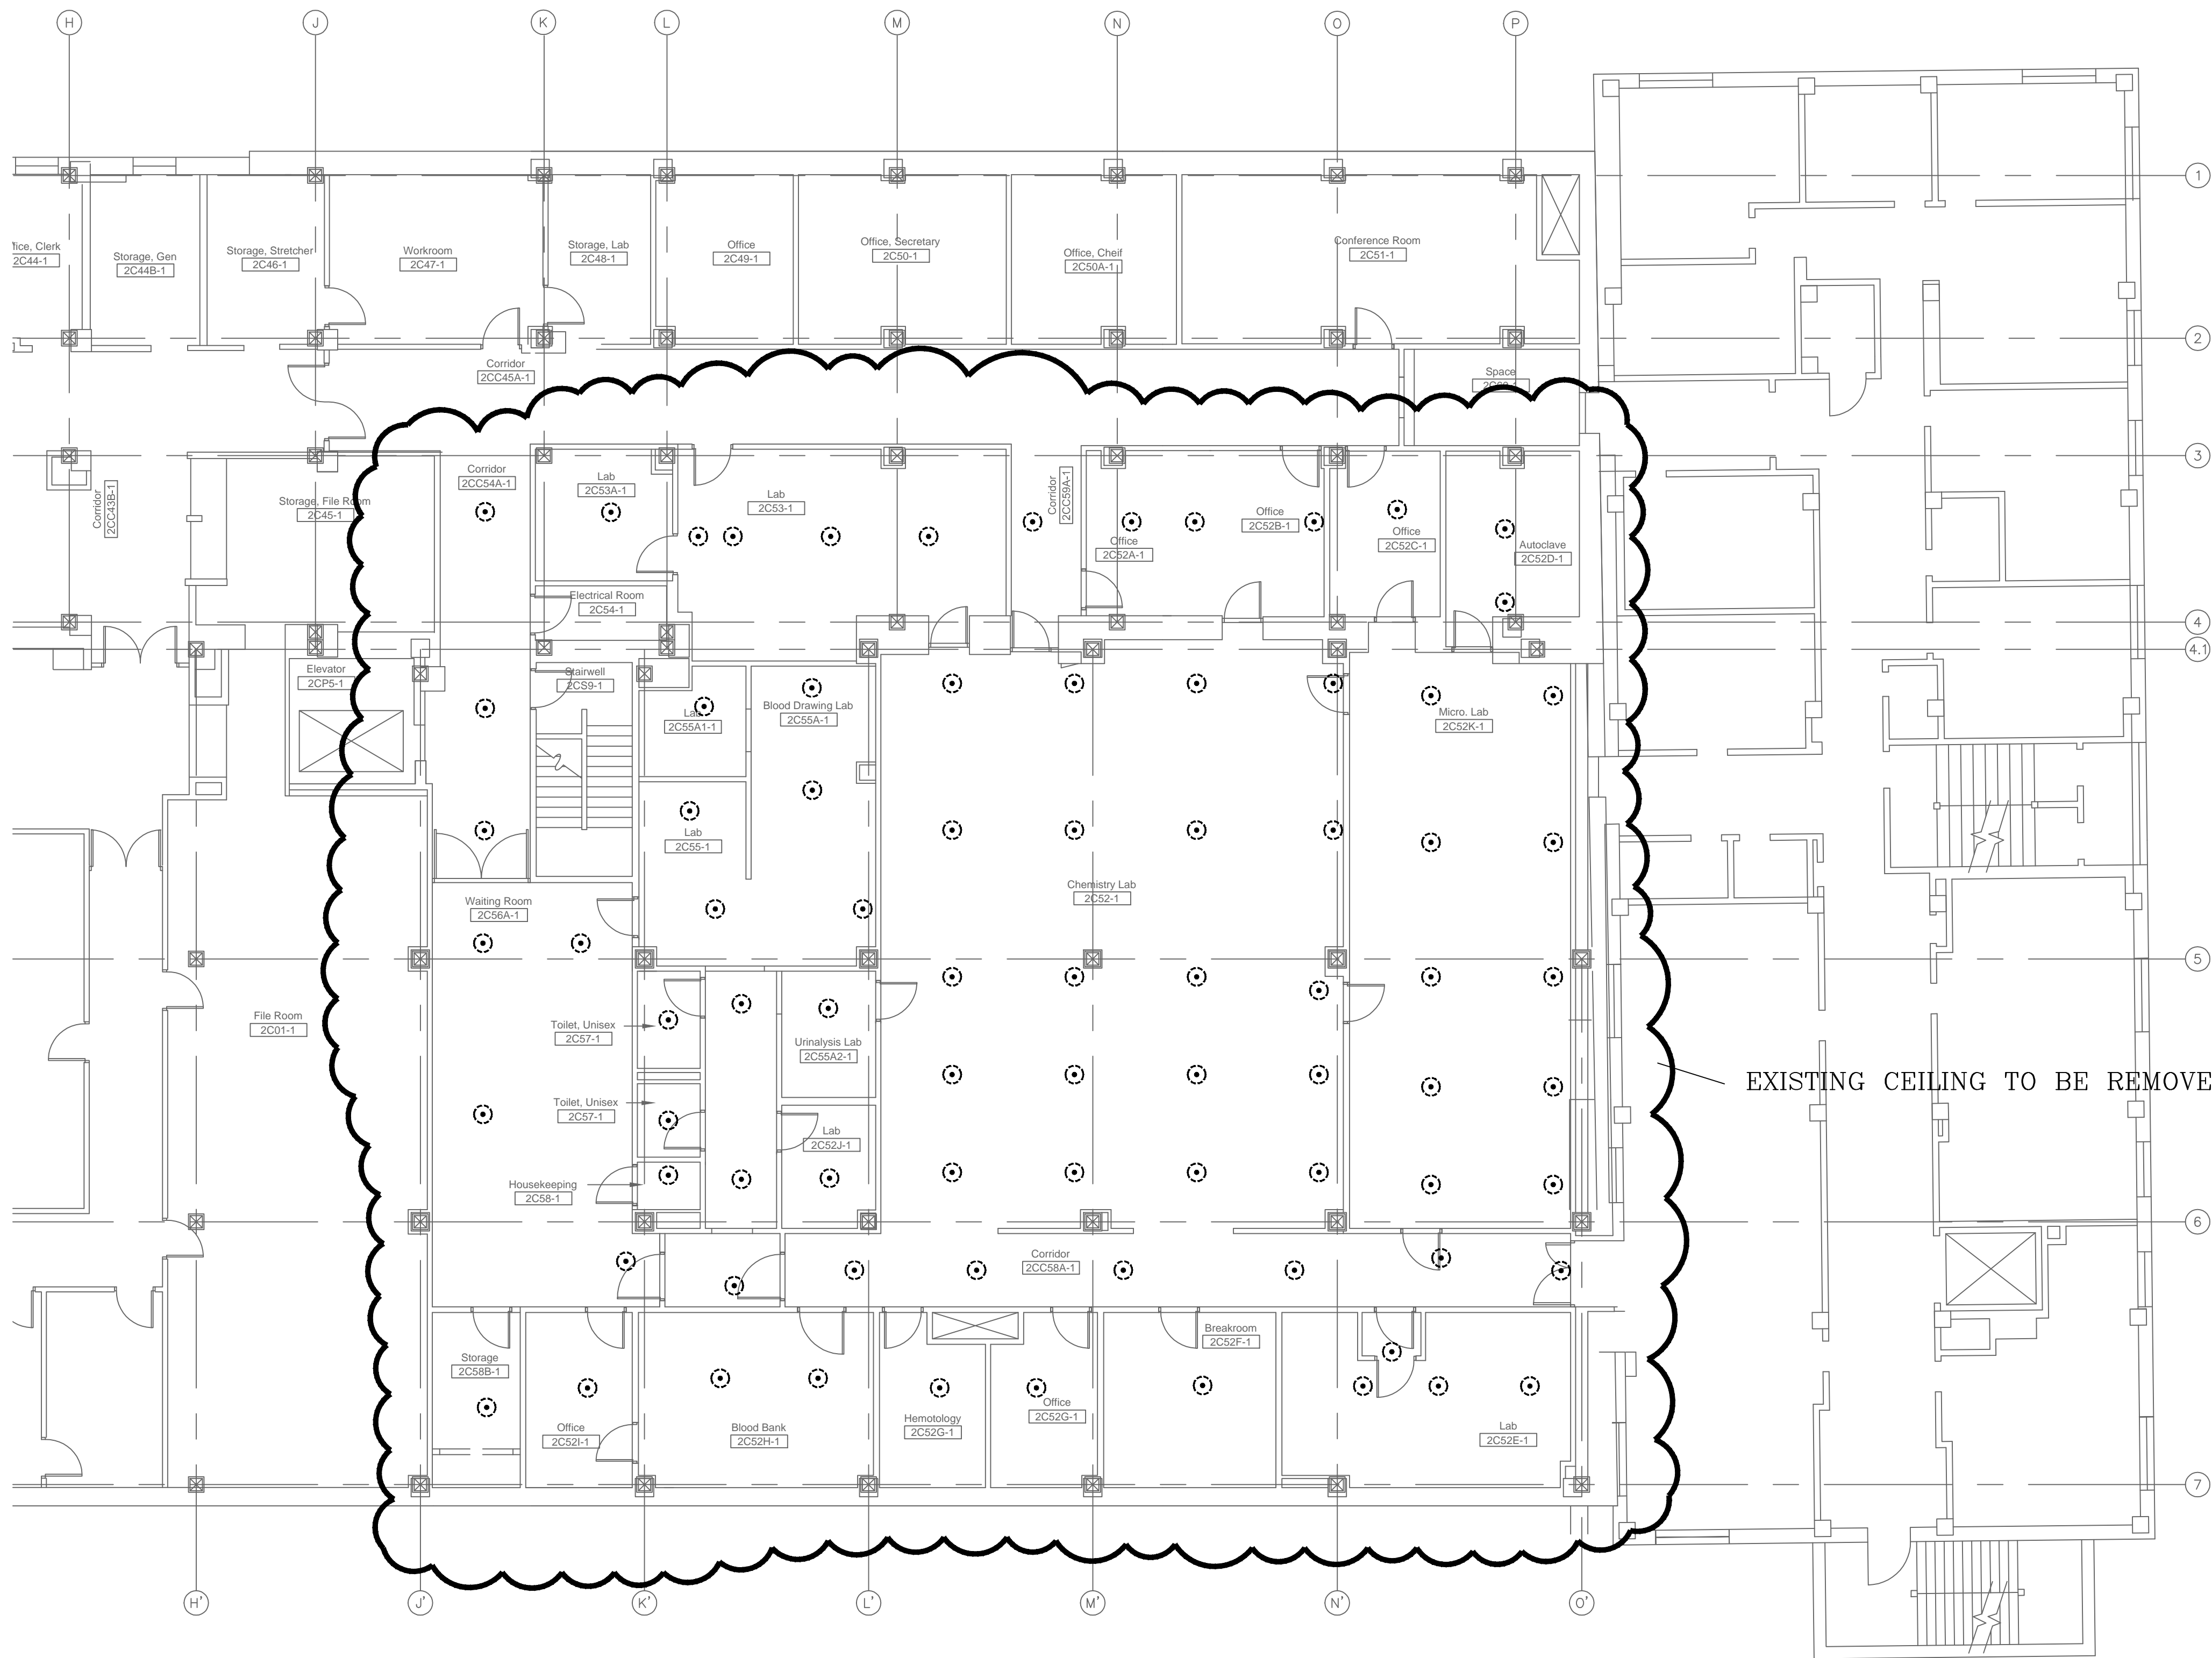

WING C LEVEL 2:  
PARTIAL SPRINKLER PLAN  
SCALE: 1/8" = 1'-0"

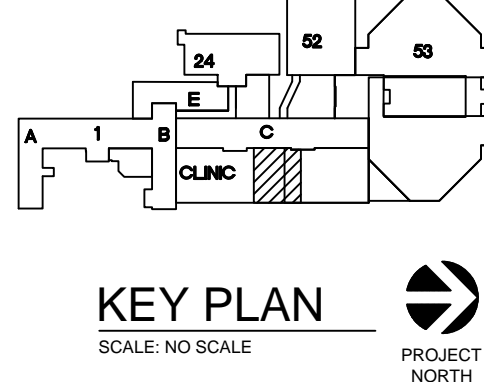

REVISIONS:	DESCRIPTION:	DATE:	 <div>Dept. of Veterans Affairs Jack C. Montgomery Medical Center 1011 Honor Height Drive Muskogee, Oklahoma 74401</div>	ENGINEER:	CONSULTANTS:	APPROVED:	APPROVED: Interior Designer	APPROVED: Safety Manager	APPROVED: Medical Center Director	DRAWING TITLE		PROJECT TITLE		DATE	DEPARTMENT OF VETERANS AFFAIRS	
				RMD CONSULTING, LLC 2815 VALLEY VIEW LANE, STE. 214 DALLAS, TX 75234 P: 972-488-8077 F: 972-488-8174 OK REG. ENGINEERING FIRM: 5183	ARCHITECT: ARCHITECTURAL CONCEPTS, INC. 669 AIRPORT FREEWAY, STE. 300 HURST, TX 76053 P: 817-285-8885 F: 817-285-8021	APPROVED:	APPROVED:	APPROVED: Infection Control Nurse	APPROVED: Associate Director	LEVEL 2 WING C: SPRINKLER PLAN		REPLACE LABORATORY AIR HANDLING UNITS		08/19/13		
						APPROVED:	APPROVED:	APPROVED: Industrial Hygienist	APPROVED: Chief of Staff	PROJECT NO. 623-11-107	CONTRACT NO. VA256-12-C-0295	DESIGNED BY: MRG	DRAWN BY: MRG	CHECKED BY: TEI		SCALE AS SHOWN
						APPROVED:	APPROVED:	APPROVED: President A.F.G.E. 2250	APPROVED: Chief of Engineering Service	BUILDING NO. CLINICAL	AUTOCAD FILE NAME:	LOCATION Jack C. Montgomery VA Medical Center		DRAWING NO. FA1.0		
														DWG. OF		