
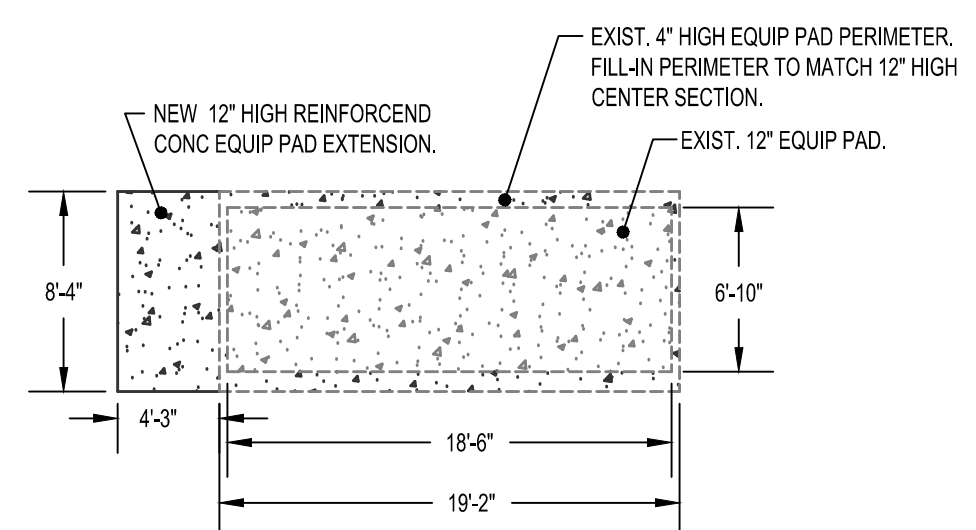


**1 LEVEL 3, WING C: INTERSTITIAL HVAC PLAN**  
1/8"=1'-0"

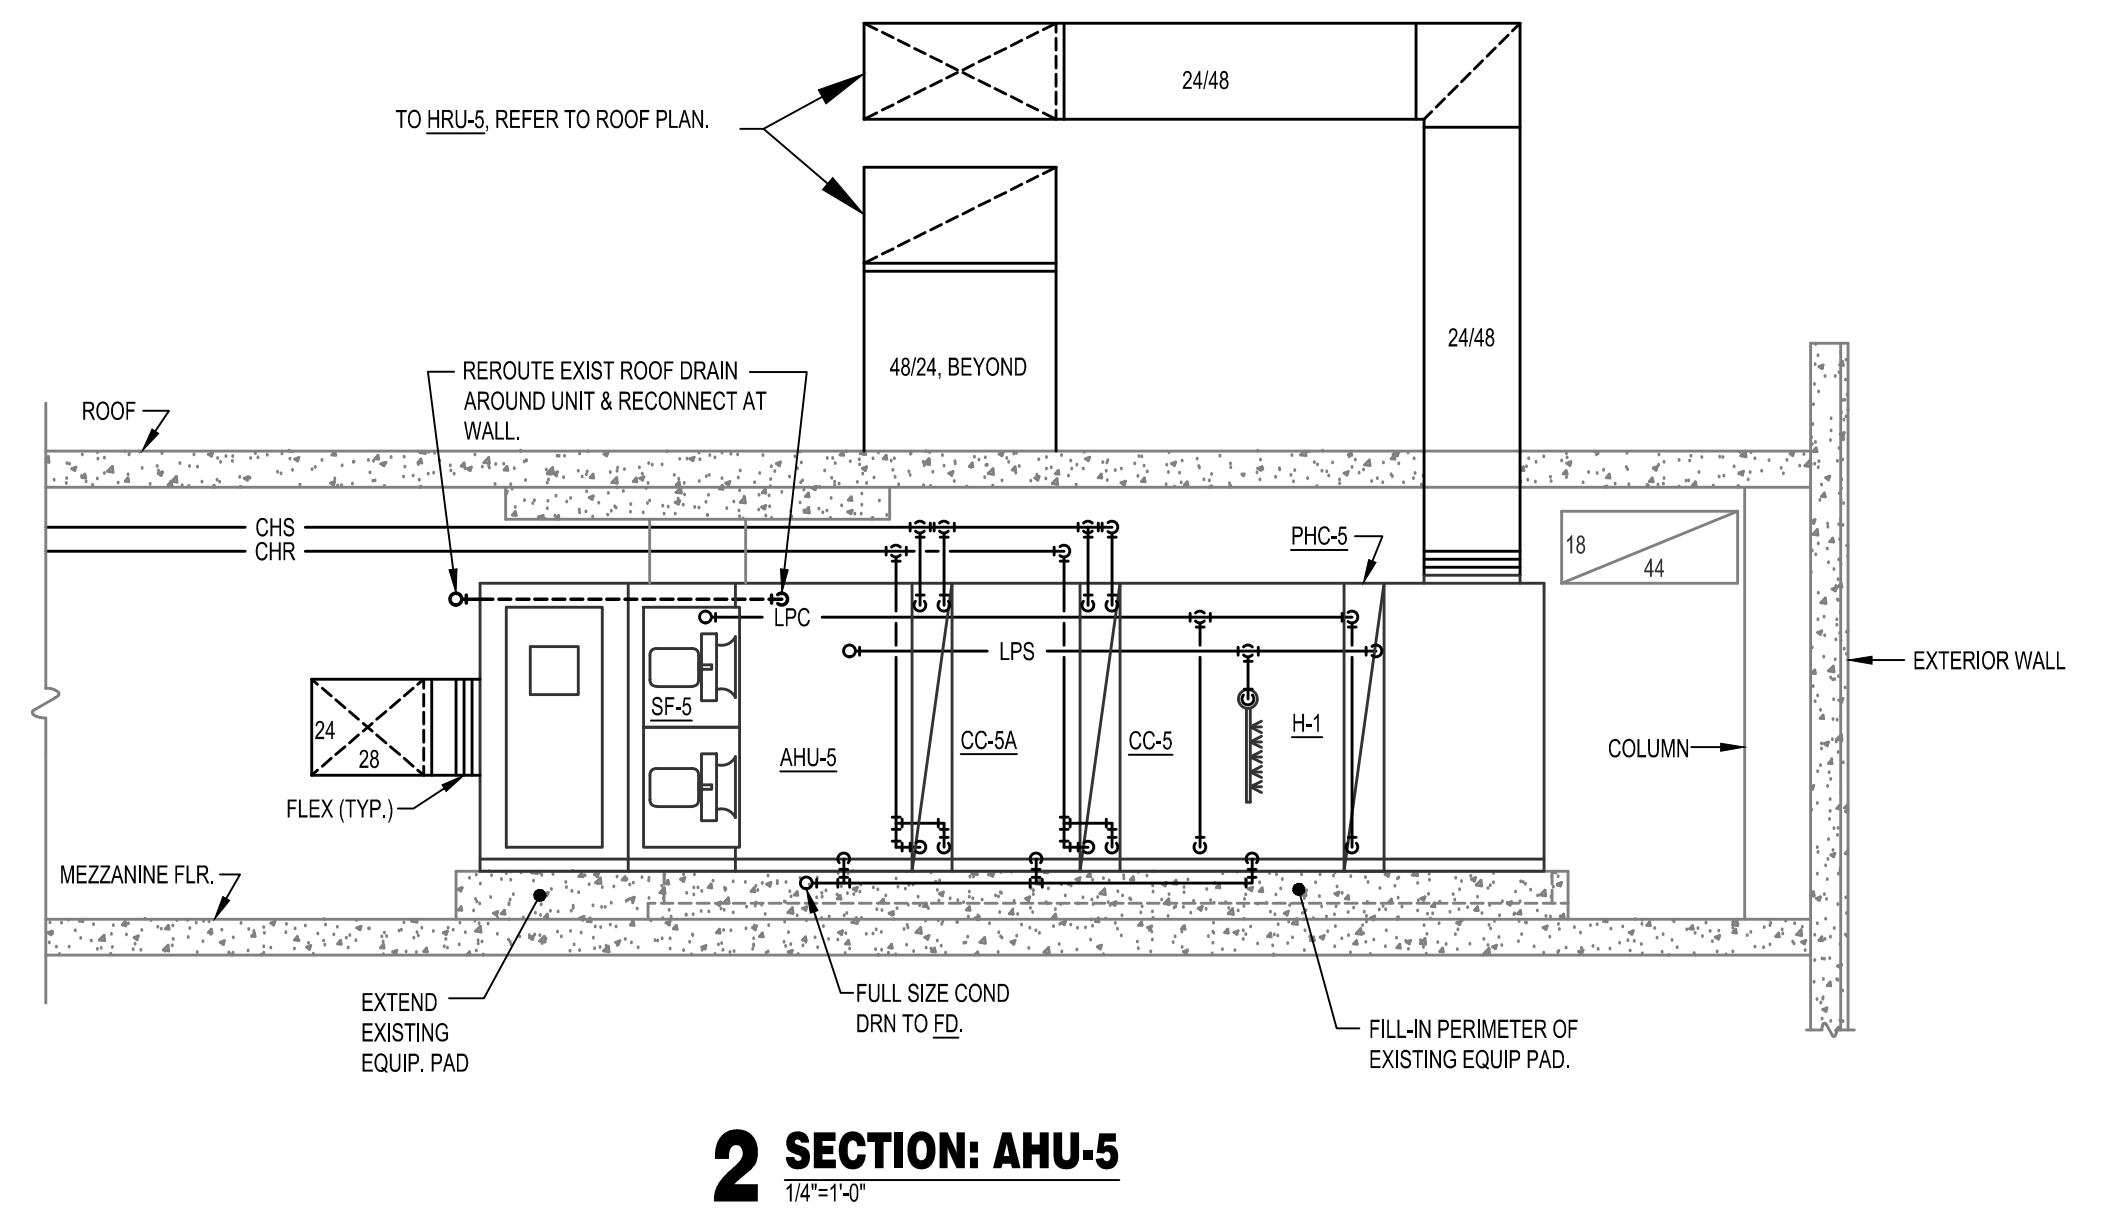

**3 AHU-5 EQUIPMENT PAD DETAIL**  
N.T.S.

- NOTES:
1. FIELD VERIFY ALL EXISTING DIMENSIONS.
  2. COORDINATE EQUIPMENT PAD DIMENSIONS WITH EQUIPMENT SUBMITTALS. EXTEND EQUIP PAD 6" BEYOND UNIT ON ALL SIDES.
  3. REFER TO STRUCTURAL DRAWINGS FOR EQUIPMENT PAD DETAILS.


The seal appearing on this document was authorized by Robert M. Dawns, 20879 on 07/19/2013. Alteration of a sealed document without proper notation to the responsible engineer is an offense under the Oklahoma Engineering Practice Act.



ASBESTOS NOTE:  
IF THE EXECUTION OF THIS WORK REQUIRES THE DISTURBING OF ANY SUBSTANCE WHICH APPEARS TO BE ASBESTOS OR WHICH MAY CONTAIN ASBESTOS FIBER, NOTIFY THE OWNER BEFORE CONTINUING WORK AT THE SUSPECT LOCATION. ANY MATERIAL TESTING POSITIVE SHALL BE REMOVED BY THE OWNER BEFORE WORK CONTINUES.

NOTE: EXISTING CONDITIONS SHOWN WERE DERIVED FROM OWNER FURNISHED DRAWINGS AND FIELD OBSERVATIONS. SOME BUILDING FEATURES AND MEP SYSTEMS ARE NOT SHOWN FOR CLARITY. FIELD VERIFY BUILDING CONSTRUCTION. FIELD VERIFY THE LOCATION, SIZE AND QUANTITY OF ALL EQUIPMENT.

NOTE: REFER TO DETAILS AND SCHEMATICS FOR PIPING, VALVES, FITTINGS AND OTHER APPURTENANCES REQUIRED, BUT NOT SHOWN FOR CLARITY.

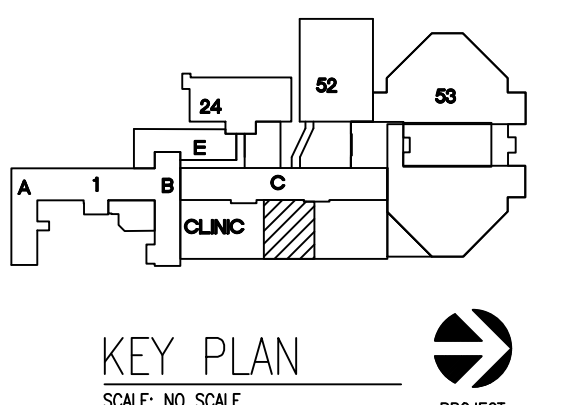

REVISIONS	DESCRIPTION	DATE



Dept. of Veterans Affairs  
Jack C. Montgomery  
Medical Center  
1011 Honor Height Drive  
Muskogee, Oklahoma 74401

**ENGINEER:**  
RMD CONSULTING, LLC  
2815 VALLEY VIEW LANE, STE. 214  
DALLAS, TX 75234  
P: 972-488-8077 F: 972-488-8174  
OK REG. ENGINEERING FIRM: 5183

**CONSULTANTS:**  
ARCHITECT:  
ARCHITECTURAL CONCEPTS, INC.  
669 AIRPORT FREEWAY, STE. 300  
HURST, TX 76053  
P: 817-285-8885 F: 817-285-8021

APPROVED:	APPROVED: Interior Designer
APPROVED:	APPROVED:
APPROVED:	APPROVED:
APPROVED:	APPROVED:

APPROVED: Safety Manager
APPROVED: Infection Control Nurse
APPROVED: Industrial Hygienist
APPROVED: President A.F.G.E. 2250

APPROVED: Medical Center Director
APPROVED: Associate Director
APPROVED: Chief of Staff
APPROVED: Chief of Engineering Service

DRAWING TITLE LEVEL 3, WING C: INTERSTITIAL HVAC PLAN
PROJECT NO. 623-11-107
BUILDING NO. CLINICAL

CONTRACT NO. VA256-12-C-0295
AUTOCAD FILE NAME

PROJECT TITLE REPLACE LABORATORY AIR HANDLING UNITS
DESIGNED BY
DRAWN BY
CHECKED BY

DATE 8/19/2013
SCALE AS SHOWN
DRAWING NO. MH2.0
DWG. 17 OF 40

LOCATION Jack C. Montgomery VA Medical Center
DEPARTMENT OF VETERANS AFFAIRS