


SHEET NOTES

- 1 HALF-SWITCHED RECEPTACLE BY LIGHT SWITCH SHOWN. TYPICAL.
- 2 FAN COIL UNIT: 0.2 AMPERE, 208V, 1-PHASE PROVIDE LOCAL DISCONNECT SWITCH. TYPICAL.
- 3 EXHAUST FAN: 1.0 AMPERE, 120V, AND INFRARED HEATER: 250-WATT. TYPICAL.
- 4 SPECIAL OUTLET FOR CLOTHES DRYER, 50-AMPERE, 250-VOLT, 2-POLE, 3-WIRE GROUNDING.
- 5 WEATHERPROOF FUSIBLE DISCONNECT SWITCH WITH 50 AMPERE FUSES, 208 VOLTS, 3-PHASE, CU-1 MCA=30.60 AMPERES.
- 6 TWO SWITCHES: ONE FOR EXHAUST FAN AND LIGHT AND ANOTHER SWITCH FOR INFRARED LAMP. SEE DETAIL 3 THIS SHEET FOR WIRING DETAILS. TYPICAL.
- 7 PROVIDE 750-WATT "ORANGE" HEAT LAMP.
- 8 CLOTHES WASHER 120 VOLT.
- 9 2#6, 1#10G-3/4" TO PNL 1PA-31,33.
- 10 COORDINATE LOCATION WITH CASEWORK.
- 11 1" WITH 3 CATEGORY 6A CABLES AND 3 JACKS-ONE TELEPHONE AND 2 DATA.
- 12 VERIFY EXACT LOCATION AT JOB SITE.
- 13 3#6, 1#10G-1".
- 14 DISCONNECT SWITCH WITH 20 AMPERES FUSES, 208 VOLT, 1-PHASE.
- 15 PRIOR TO ROUGH-IN VERIFY ACTUAL EQUIPMENT TO BE INSTALLED AND PROVIDE CODE-SIZED WIRING, FUSES, AND BREAKER.
- 16 PORCELAIN KEYLESS LAMP HOLDER WITH 18-WATT COMPACT FLUORESCENT LAMP AND PULL SWITCH.
- 17 VERIFY LOCATION OF DEVICES IN ELEVATOR PIT WITH ELEVATOR SHOP DRAWINGS.


GENERAL NOTES

- G1 FURNISH AND INSTALL MOLDABLE PUTTY PADS SIMILAR TO HLT1 OR EQUAL TO THE BACKS AND SIDES OF ALL WALL AND CEILING RECESSED OUTLET BOXES.
- G2 COORDINATE LOCATION AND MOUNTING HEIGHT OF TV OUTLETS AND DUPLEX RECEPTACLES WITH LOCATION OF TV MONITORS.
- G3 OFFSET BACK TO BACK OUTLETS ON SAME WALL BY 12" HORIZONTAL SEPARATION.


BUILDING 22 - BEDROOM TOILET EXHAUST FAN AND LIGHT DIAGRAM

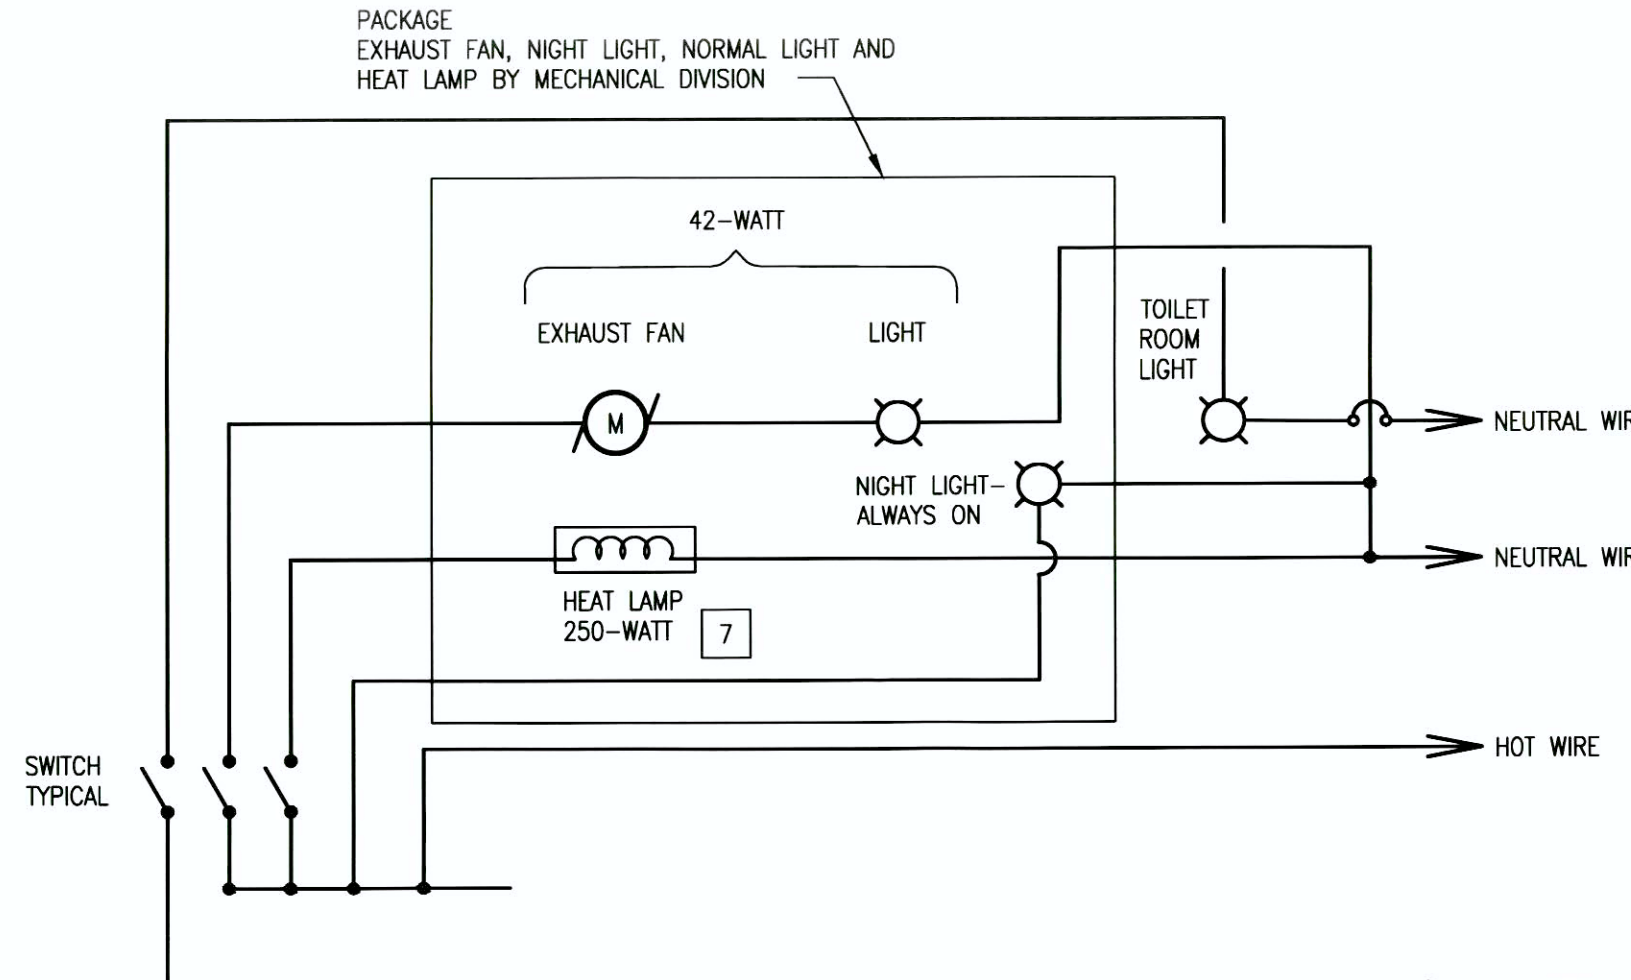

PART PLAN - ELECTRICAL ROOM

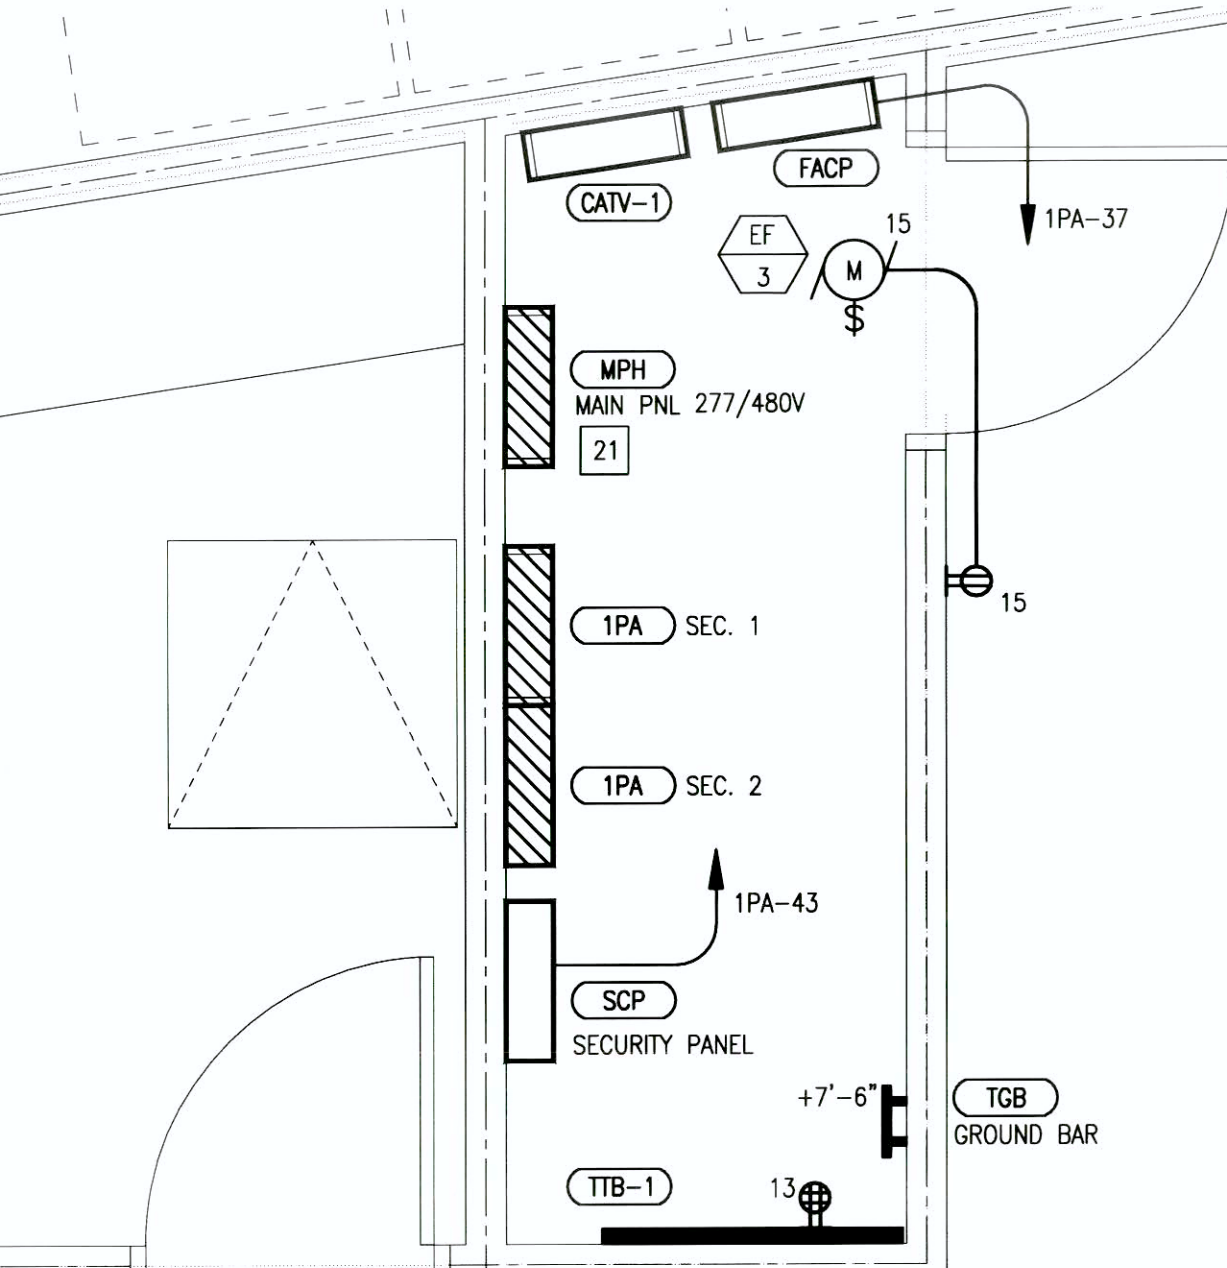

DOOR PROP ALARM

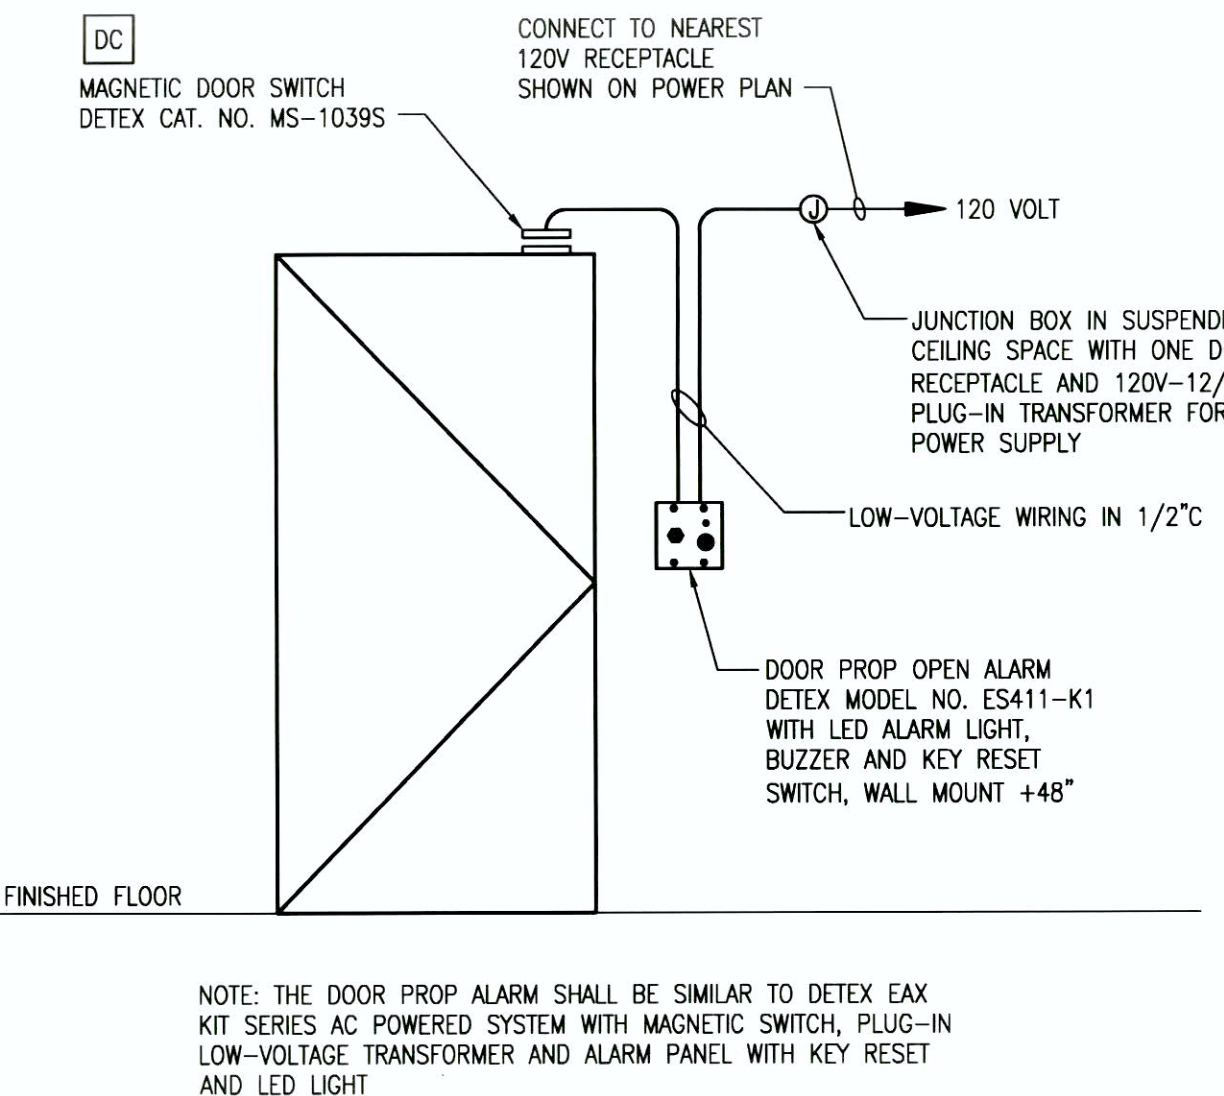

CONSULTANTS:

STRUCTURAL: DEGENKOLB ENGINEERS; 235 MONTGOMERY STREET, SUITE 500; SAN FRANCISCO, CA 94104
 MECHANICAL: HTC ENGINEERS; 1529 CYPRESS ST., SUITE 103; WALNUT CREEK, CA 94596
 ELECTRICAL: BAY AREA CONSULTING ENGINEERS; 311 CALIFORNIA STREET, SUITE 720; SAN FRANCISCO, CA 94104
 CIVIL ENGINEER: GHD CIVIL ENGINEERS; 2235 MERCURY WAY, SUITE 150; SANTA ROSA, CA 95407
 ESTIMATING: CUMMING CORPORATION; 1970 BROADWAY, SUITE 630; OAKLAND, CA 94612
 SURVEYORS: MARTIN M. RON ASSOCIATES, INC.; 859 HARRISON ST., SUITE 200; SAN FRANCISCO, CA 94107
 UTILITY LOCATORS: CRUZ BROTHERS LOCATORS; P.O. BOX 66768; SCOTTS VALLEY, CA 95067

ARCHITECT/ENGINEERS:

Architecture | Engineering | Planning
 Hammel, Green and Abrahamson, Inc.
 445 Bush Street - Fourth Floor
 San Francisco, California USA 94108
 Telephone 415.962.2592
 Facsimile 415.962.2598

ELECTRICAL - GROUND FLOOR PLAN POWER & COMMUNICATIONS

Scale: 1/4" = 1'-0"
 Approved: Project Director

Project Title VA Medical Center Seismic Replacement And Retrofit

Location: San Francisco, CA
 Date: 10 / 22 / 2012
 Checked: AEM
 Drawn: BAC

Project Number 2941-001-00

Building Number: 22
 Drawing Number: E400

Office of Facilities Management

Department of
 Veterans Affairs