

DOOR SCHEDULE																	
DOOR NUMBER	To Room: Name	DOOR SIZE		FIRE RATING	Door				FRAME			HARDWARE GROUP	PANIC	GLASS	DETAILS (SHEET A9.22 U.N.O.)		Comments
		PANEL	HEIGHT		MATERIAL	FINISH	PANEL TYPE	UNDERCUT	MATERIAL	FINISH	FRAME TYPE				HEAD	JAMB	
1A03	HK	3'-0"	7'-10"	NR	WD	PT	01 : S	0"	HM	PT	A : S	03	No	-	13	12	
1A04	TOILET	3'-0"	7'-10"	NR	WD	PT	01 : S	3/4"	HM	PT	A : S	07	No	-	13	12	
1A05	COMM. CNTR	3'-0"	7'-10"	NR	WD	PT	01 : S	0"	HM	PT	A : S	02A	No	CT	13	12	
1A06	RECEPTION	3'-0"	7'-10"	NR	WD	PT	01 : S	0"	HM	PT	A : S	06	No	CT	13	12	
1A07	EXAM/OFFICE	3'-0"	7'-10"	NR	WD	PT	01 : S	0"	HM	PT	A : S	06	No	CT	13	12	
1A08	MEN	3'-0"	7'-10"	NR	WD	PT	01 : S	3/4"	HM	PT	A : S	04	No	-	13	12	
1A09	WOMEN	3'-0"	7'-10"	NR	WD	PT	01 : S	3/4"	HM	PT	A : S	04	No	-	13	12	
1A10A	GROUP RM / QUIET RM	3'-0"	7'-10"	NR	WD	PT	05 : S	0"	HM	PT	A : S	06	No	OT	13	12	
1A10B	GROUP RM / QUIET RM	3'-0"	7'-10"	NR	WD	PT	03 : S	0"	HM	PT	A : S	06	No	CT	13	12	
1A11	OCCU. TRAIN. KITCHENETTE	3'-0"	7'-10"	NR	WD	PT	05 : S	0"	HM	PT	A : S	04B	Yes	OT	13	12	
1A12	DAY ROOM	3'-0"	7'-10"	NR	ALM	FF	05 : S	0"	ALM	FF	A : S	04A	Yes	OT	13	12	
1A-01	LOBBY	10'-0"	7'-6"	NR	ALM	FF			ALM	FF	SEE : SCH						AUTOMATED SLIDING BREAKOUT DOOR. SEE WINDOW SCHEDULE AND SPECIFICATIONS FOR DETAILS
1B01	OFFICE	3'-0"	7'-10"	NR	WD	PT	03 : S	3/4"	HM	PT	A : S	06	No	CT	13	12	
1B02	OFFICE	3'-0"	7'-10"	NR	WD	PT	03 : S	3/4"	HM	PT	A : S	06	No	CT	13	12	
1B03	OFFICE	3'-0"	7'-10"	NR	WD	PT	03 : S	3/4"	HM	PT	A : S	06	No	CT	13	12	
1B04	OFFICE	3'-0"	7'-10"	NR	WD	PT	03 : S	3/4"	HM	PT	A : S	06	No	CT	13	12	
1B05	OFFICE	3'-0"	7'-10"	NR	WD	PT	03 : S	3/4"	HM	PT	A : S	06	No	CT	13	12	
1B06	OFFICE	3'-0"	7'-10"	NR	WD	PT	03 : S	3/4"	HM	PT	A : S	06	No	CT	13	12	
1B09A	ELECTRICAL ROOM	3'-0"	8'-10"	NR	ALM	FF	01 : S	0"	HM	PT	A : S	10A	No	-	-	-	
1B09B	ELECTRICAL ROOM	3'-0"	7'-10"	20	WD	PT	01 : S	0"	HM	PT	A : S	11A	No	-	13	12	
1B10	STORAGE	3'-0"	7'-10"	NR	WD	PT	01 : S	0"	HM	PT	A : S	11B	No	-	13	12	
1B11	FIRE RISER	3'-0"	8'-10"	NR	ALM	FF	01 : S	0"	HM	PT	A : S	10	No	-	-	-	
1B12	TOILET	3'-0"	7'-10"	NR	WD	PT	01 : S	3/4"	HM	PT	A : S	07	No	-	13	12	
1B13	TOILET	3'-0"	7'-10"	NR	WD	PT	01 : S	3/4"	HM	PT	A : S	07	No	-	13	12	
1B14	LOUNGE	3'-0"	7'-10"	NR	WD	PT	01 : S	0"	HM	PT	A : S	09	No	-	13	12	
1B15	CHIEF OFFICE	3'-0"	7'-10"	NR	WD	PT	03 : S	0"	HM	PT	A : S	06	No	CT	13	12	
1B16A	TRAINING ROOM / GROUP	3'-0"	7'-10"	NR	WD	PT	01 : S	0"	HM	PT	A : S	06	No	CT	13	12	
1B16B	TRAINING ROOM / GROUP	3'-0"	7'-10"	NR	WD	PT	05 : S	0"	HM	PT	A : S	06	No	OT	13	12	
1B-1A	WAITING ROOM	3'-0"	7'-10"	NR	WD	PT	05 : S	0"	HM	PT	A : S	03A	No	OT	13	12	
1B-1B	NON RATED CORRIDOR	3'-0"	8'-10"	NR	ALM	FF	05 : S	0"	ALM	FF	SEE : SCH	05	Yes	-	-	-	
1B-1C	WAITING ROOM	3'-0"	7'-10"	NR	WD	PT	05 : S	0"	HM	PT	A : S	12	No	OT	13	12	ALTERNATE #19
1B-2	NON RATED CORRIDOR	3'-0"	8'-10"	NR	ALM	FF	05 : S	0"	ALM	FF	SEE : SCH	05A	Yes	-	-	-	
1C01	CONFERENCE ROOM	3'-0"	7'-10"	NR	WD	PT	05 : S	0"	HM	PT	A : S	06	No	OT	13	12	
1C02	CHIEF OFFICE	3'-0"	7'-10"	NR	WD	PT	03 : S	0"	HM	PT	A : S	06	No	CT	13	12	
1C03A	BIO FEEDBACK	3'-0"	7'-10"	NR	WD	PT	01 : S	0"	HM	PT	A : S	06	No	-	13	12	
1C03B	OFFICE	3'-0"	7'-10"	NR	WD	PT	01 : S	3/4"	HM	PT	A : S	06	No	-	13	12	
1C04	OFFICE	3'-0"	7'-10"	NR	WD	PT	03 : S	3/4"	HM	PT	A : S	06	No	CT	13	12	
1C05	MACHINE	3'-0"	7'-10"	20	WD	PT	01 : S	0"	HM	PT	A : S	08A	No	-	13	12	
1C06	STORAGE	3'-0"	7'-10"	NR	WD	PT	01 : S	0"	HM	PT	A : S	11B	No	-	13	12	
1C07	NEURO TEST	3'-0"	7'-10"	NR	WD	PT	01 : S	0"	HM	PT	A : S	06	No	-	13	12	
1C-1		3'-0"	7'-10"	NR	WD	PT	05 : S	0"	HM	PT	A : S	12	No	OT	13	12	
2A02	OFFICE	3'-0"	7'-10"	NR	WD	PT	03 : S	3/4"	HM	PT	A : S	06	No	CT	13	12	
2A03	NON - RATED CORRIDOR	3'-0"	7'-10"	NR	WD	PT	03 : S	0"	HM	PT	A : S	06	No	CT	13	12	
2A04	NON - RATED CORRIDOR	3'-0"	7'-10"	NR	WD	PT	01 : S	0"	HM	PT	A : S	07	No	-	13	12	
2A05	TOILET	3'-0"	7'-10"	NR	WD	PT	01 : S	3/4"	HM	PT	A : S	07	No	-	13	12	
2A06	HK	3'-0"	7'-10"	NR	WD	PT	01 : S	0"	HM	PT	A : S	03	No	-	13	12	
2A07A	EXAM ROOM	3'-0"	7'-10"	NR	WD	PT	01 : S	0"	HM	PT	A : S	06	No	CT	13	12	
2A07B	OPEN OFFICE	3'-0"	7'-10"	NR	WD	PT	01 : S	3/4"	HM	PT	A : S	06	No	CT	13	12	
2B01A	WAITING ROOM	3'-0"	7'-10"	NR	WD	PT	05 : S	0"	HM	PT	A : S	03B	No	OT	13	12	
2B01B	OPEN OFFICE	3'-0"	8'-10"	NR	ALM	FF	01 : S	3/4"	ALM	FF	A : S	05A	Yes	-	13	12	
2B01C		3'-0"	7'-10"	NR	WD	PT	05 : S	0"	HM	PT	A : S	03B	No	OT	13	12	ALTERNATE #19
2B03	ELECT	3'-0"	7'-10"	20	WD	PT	01 : S	0"	HM	PT	A : S	11D	No	-	13	12	
2B04	TOILET	3'-0"	7'-10"	NR	WD	PT	01 : S	3/4"	HM	PT	A : S	07	No	-	13	12	
2B05	OPEN OFFICE	3'-0"	7'-10"	NR	WD	PT	01 : S	0"	HM	PT	A : S	07	No	-	13	12	
2B06	MECHANICAL ROOM	5'-1"	7'-10"	NR	ALM	FF	05 : S	0"	ALM	FF	SEE : SCH	18	No	-	-	-	ALUM GATE
2B07	OPEN OFFICE	3'-0"	7'-10"	NR	WD	PT	03 : S	3/4"	HM	PT	A : S	06	No	CT	13	12	
2B08			7'-0"														
2C01	OFFICE	3'-0"	7'-10"	NR	WD	PT	03 : S	3/4"	HM	PT	A : S	06	No	CT	13	12	
2C02	OFFICE	3'-0"	7'-10"	NR	WD	PT	03 : S	3/4"	HM	PT	A : S	06	No	CT	13	12	
2C03	NON - RATED CORRIDOR	3'-0"	7'-10"	NR	WD	PT	03 : S	0"	HM	PT	A : S	06	No	CT	13	12	
2C04	STORAGE	3'-0"	7'-10"	NR	WD	PT	01 : S	0"	HM	PT	A : S	11B	No	-	13	12	
2C05	DATA	3'-0"	7'-10"	NR	WD	PT	01 : S	0"	HM	PT	A : S	11C	No	-	13	12	

DEDUCTIVE
ALTERNATE #19

DEDUCTIVE
ALTERNATE #19

DEDUCTIVE
ALTERNATE #19

DEDUCTIVE
ALTERNATE #19

1 DOOR FRAMES

1/4" = 1'-0"



2 DOOR PANELS

1/4" = 1'-0"

3 DOOR SCHEDULE LEGEND

12" = 1'-0"

DOOR SCHEDULE LEGEND	
ALM	ALUMINUM
CT	CLEAR TEMPERED GLAZING
OT	OBSCURE TEMPERED GLAZING
FF	FACTORY FINISH
FR	FIRE RATED
HM	HOLLOW METAL
NA	NOT APPLICABLE
NR	NOT RATED
PT	STAINED WOOD WITH TRANSPARENT FINISH
	- REFER TO SPECIFICATION SECTION (08 14 00) INTERIOR WOOD DOORS
	(09 06 00) SCHEDULE FOR FINISHES
PC	POWDER COATED
PH	PANIC HARDWARE
PR	PAIR/ DOORS AND HARDWARE
SGL	SINGLE DOOR
SST	STAINLESS STEEL
STL	STEEL
T1	TEMPERED GLAZING, CLASS I (GLASS PANEL ≤ 9 SQ. FT)
T2	TEMPERED GLAZING, CLASS II (GLASS PANEL ≥ 9 SQ. FT)
WD	WOOD DOOR
SCH	SCHEDULE - SEE A930'S SERIES OF DRAWINGS FOR STOREFRONT SCHEDULE

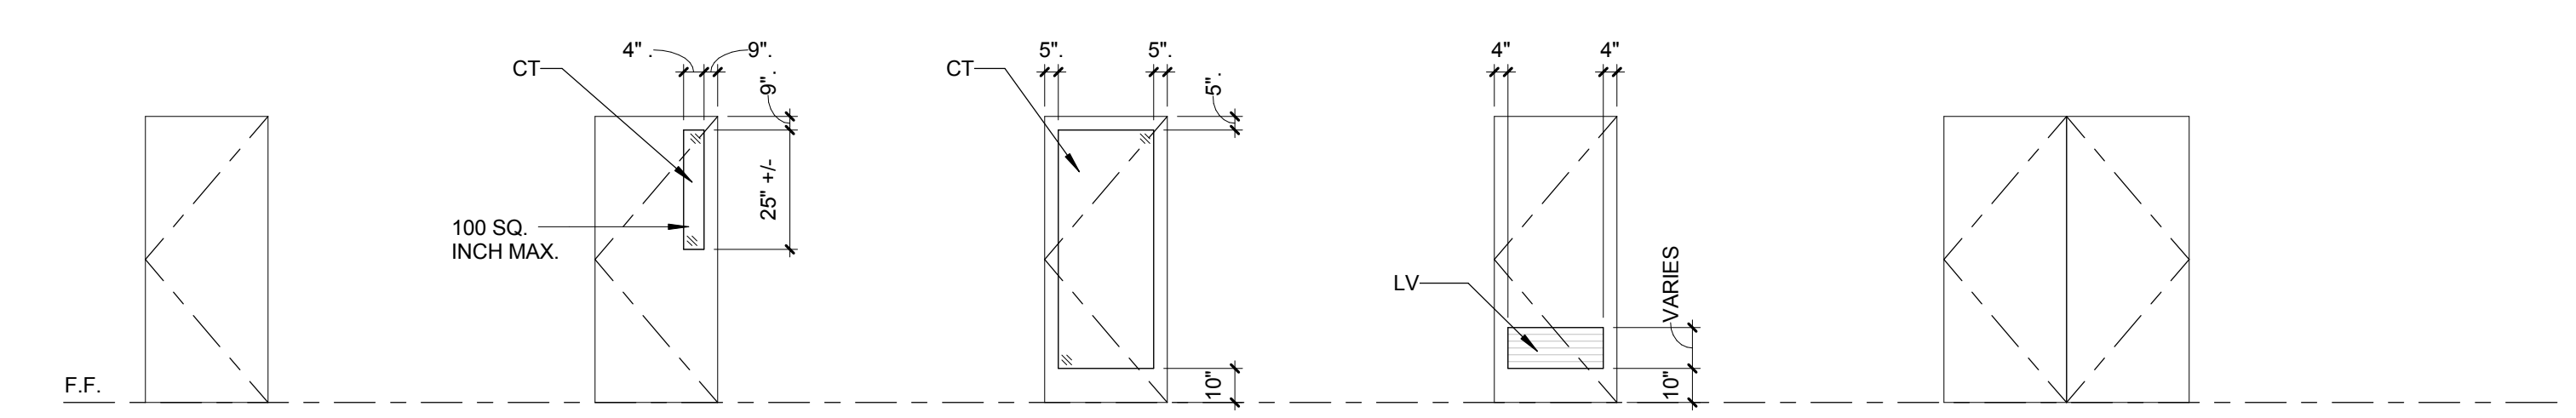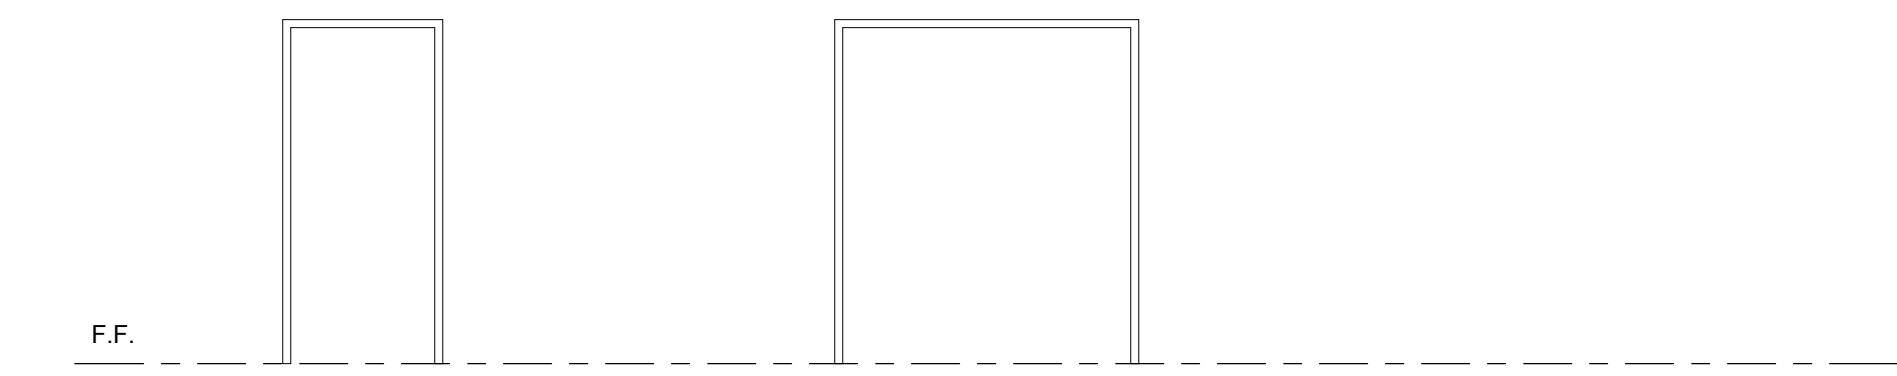

01:S 03:S 05:S 06:S 01:D

1. REFER TO SHEET G001 FOR TYPICAL SYMBOLS AND ABBREVIATIONS
2. REFER TO SHEET A9303 FOR THRESHOLD DETAILS
3. REFER TO SHEET A974 FOR SIGNAGE DETAILS

LEGEND

AREA OF DEDUCTIVE ALTERNATE #19

THIS SPACE TO BE LABELED AS "UNFINISHED" DEDUCT ALL INTERIOR WALLS, FINISHES, CEILINGS, FF&E, PLUMBING FIXTURES, TOILET ROOM ACCESSORIES, ETC. PROVIDE CODE REQUIRED EXIT LIGHTING, HVAC AND ACCESS TO MACHINE ROOM 1C05 & DATA ROOM 2C05 AND IDENTIFY MEP POINTS OF CONNECTION FOR FUTURE BUILD OUT OF THIS AREA.

CONSULTANTS:			ARCHITECT/ENGINEERS: HMC Architects 1827 E. Fir Avenue / Studio 103 / Fresno, CA 93720 T 559 322 2444 / www.hmcarchitects.com HMC PROJECT #1393002-000	Drawing Title DOOR SCHEDULE		Project Title Mental Health Psychosocial Rehab Recovery and Health Care for Homeless Veteran Center		Project Number 570-217		Office of Construction and Facilities Management: 	
				Approved: Project Director		Location 2615 E. CLINTON AVE, FRESNO, CA 93703		Building Number 37			
						Date 08/11/2014		Checked WB, GV		Drawing Number AS920 Dwg. 57 of 197	
								Drawn MB, CLO, LS			