

- ARCHITECTURAL NOTES
- 1) LAYOUT BINDERS ARE NOT FINAL AND SHOULD NOT BE CONSIDERED VALID CONSTRUCTION DOCUMENTS–NOT FOR CONSTRUCTION
  - 2) LAYOUTS ARE SUBJECT TO CHANGES UPON REVIEW
  - 3) EQUIPMENT OVERLAYS ARE FOR REPRESENTATION ONLY
  - 4) HUNTAIR, INC PROVIDES MECHANICAL EQUIPMENT AND DOES NOT ASSUME ANY ARCHITECTURAL RESPONSIBILITIES OR LIABILITIES INCLUDING
    - ARCHITECTURAL MODIFICATIONS OF WALL, DOORS, WINDOWS ETC...
    - ARCHITECTURAL MATERIALS OTHER THAN THOSE INCLUDED OR RELATED TO OUR EQUIPMENT
    - ARCHITECTURAL MODIFICATIONS THAT MAY OCCUR DUE TO FILE SHARING AND MULTIPLE USER USE

KEY:



FILE NAME: 14-6019_VA_CATH_Layout_rev06.dwg			
REV:	DATE:	BY:	DESCRIPTION
THIS DRAWING, SPECIFICATIONS, AND CONCEPTS CONTAINED HEREIN ARE THE SOLE PROPERTY OF HUNTAIR, AND MAY NOT BE REPRODUCED OR USED IN ANY FASHION WITHOUT THE PRIOR WRITTEN PERMISSION OF HUNTAIR CORPORATION.			

TOLERANCES UNLESS OTHERWISE SPECIFIED	
FRACTIONS :	±1/32
0.0 :	±0.1
0.00 :	±0.03
0.000 :	±0.010
0.0000 :	GIVEN
ANGLES :	±0.5°

CATH LAB BACKGROUND

CLEANSUITE


DRAWN BY: mfarnsworth		19855 SW 124th AVENUE TUALATIN, OR 97062 Phone (503) 639-0113 Fax (503) 639-1269	
ISSUED ON: 8/19/2014		TITLE: VA-PALO ALTO CATH LAB CLEANSUITE LAYOUT	
CHECKED BY:	SIZE: <b>B</b>	DRAWING NO: 14-6019	
SCALE: NONE	JOB NO: xxxx-xxx	SHEET:    OF:	

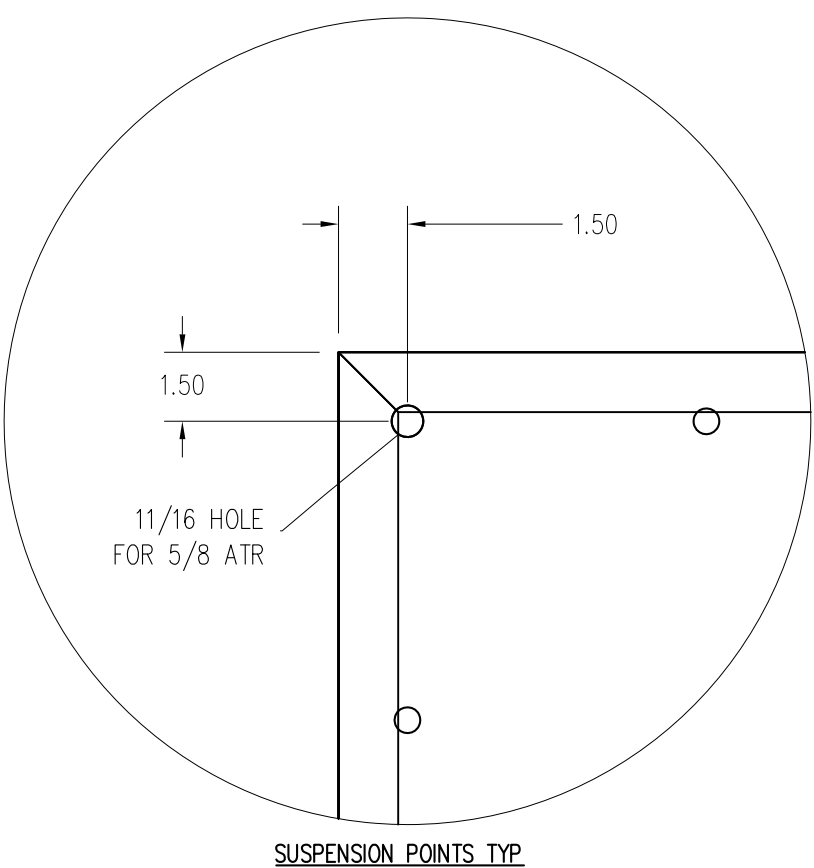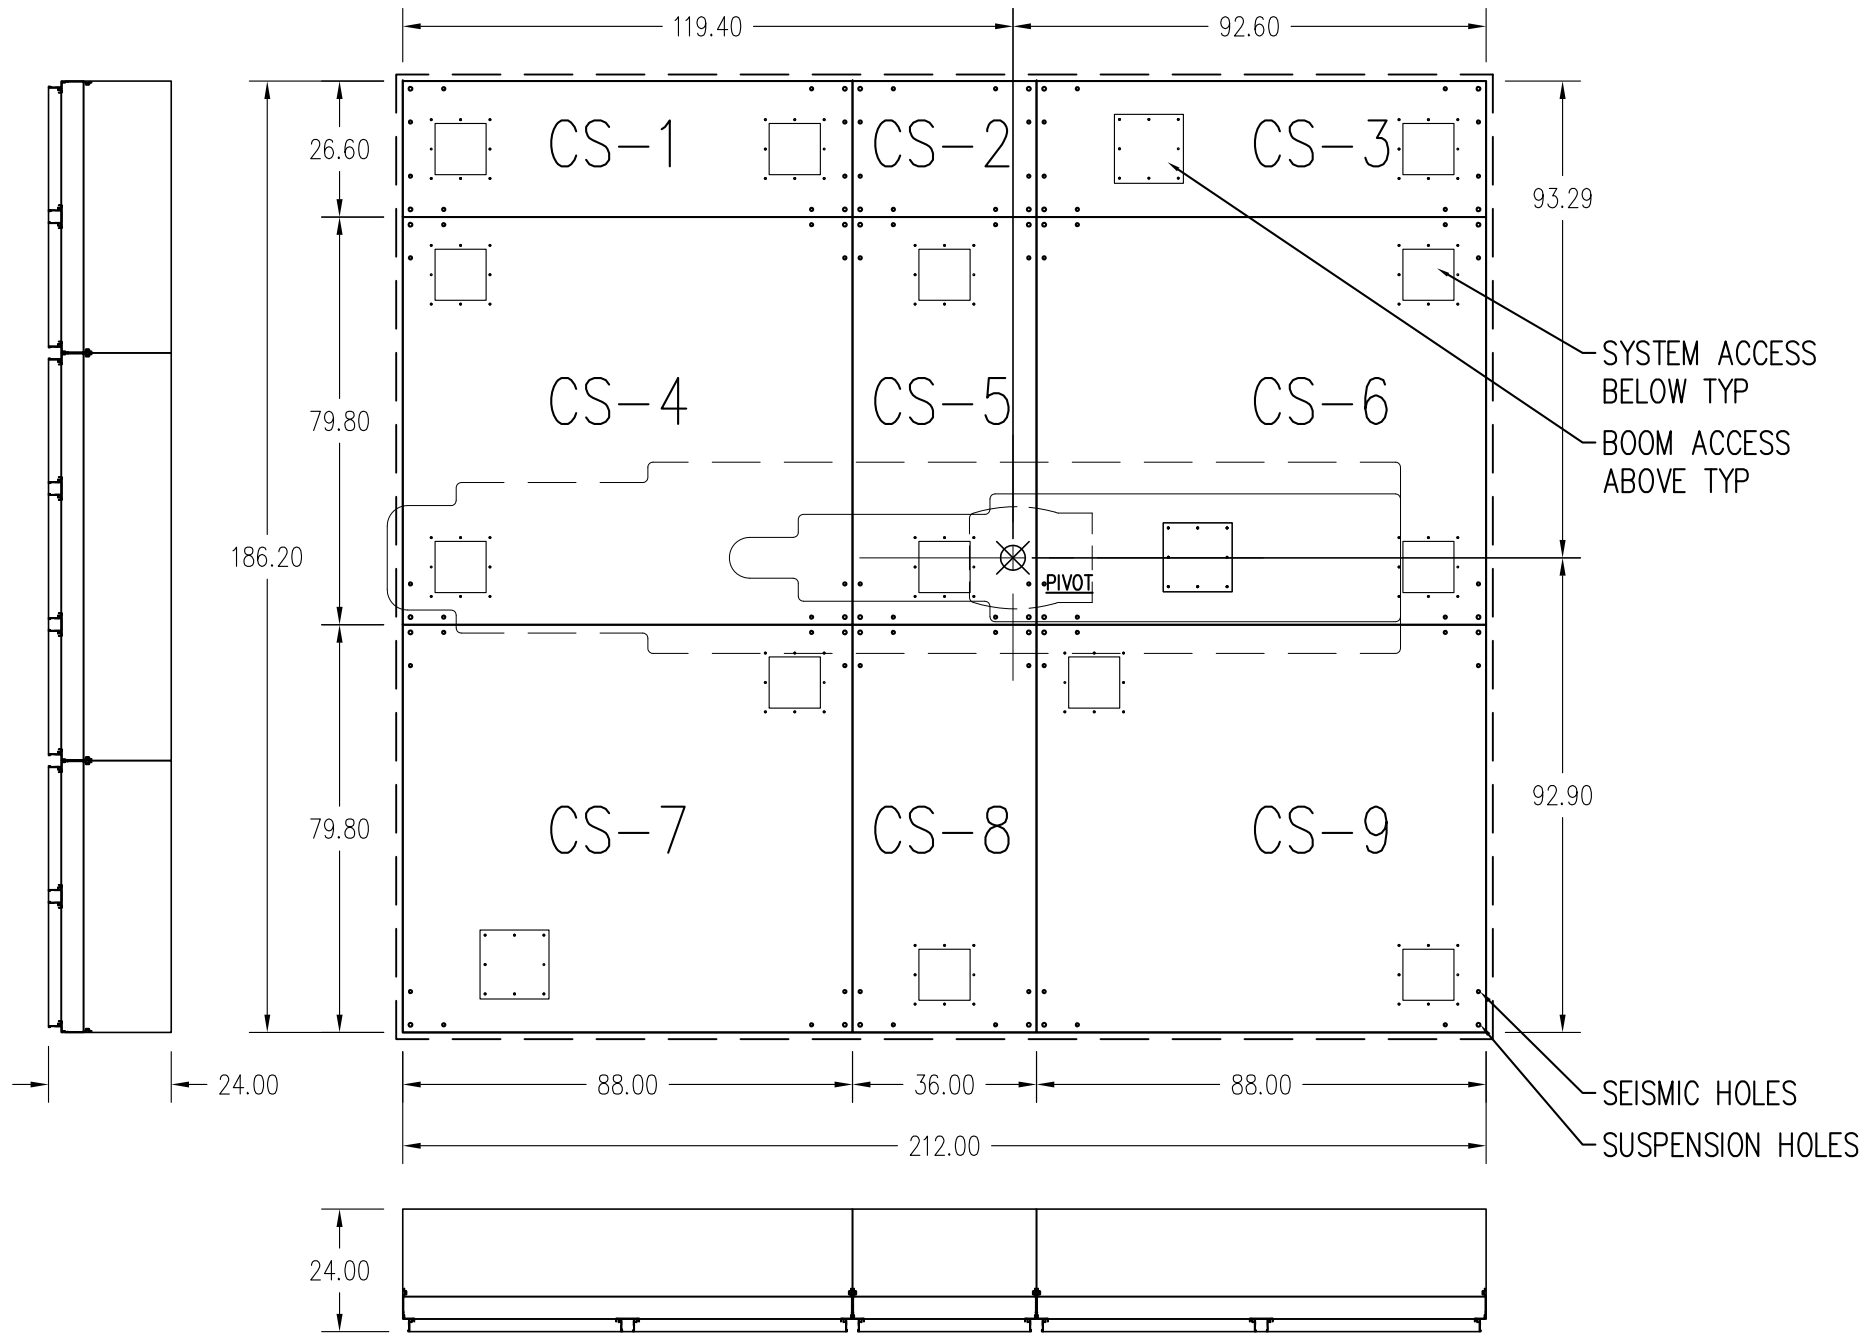


- ESTIMATED DEAD LOADS ---  
divide load by four for individual point loads
- TBD
  - CS-1
  - CS-2
  - CS-3
  - CS-4
  - CS-5
  - CS-6
  - CS-7
  - CS-8
  - CS-9


- NOTE:
- 1. SINGLE LARGE DIFFUSER (SLD): 9 UNITS WITHIN MOVE-IN PATH REQUIREMENTS TBD.
  - 2. MOUNTING POINTS LOCATED @ PERIMETER OF MODULES
  - 3. MOUNTING POINTS NOT FINAL AND SUBJECT TO CHANGE UPON FULL STRUCTURAL CALCULATIONS AND/OR DESIGN CHANGES

KEY:


FILE NAME: 14-6019_CATH_Layout_rev06.dwg				TOLERANCES UNLESS OTHERWISE SPECIFIED	MODULE LAYOUT	DRAWN BY: mfarnsworth		 <div>19855 SW 124th AVENUE TUALATIN, OR 97062 Phone (503) 639-0113 Fax (503) 639-1269</div>
REV:	DATE:	BY:	DESCRIPTION			ISSUED ON: 8/4/2014		
						CHECKED BY:		
						SCALE: NONE		
						SIZE: <b>B</b> DRAWING NO: 14-6019		
THIS DRAWING, SPECIFICATIONS, AND CONCEPTS CONTAINED HEREIN ARE THE SOLE PROPERTY OF HUNTAIR, AND MAY NOT BE REPRODUCED OR USED IN ANY FASHION WITHOUT THE PRIOR WRITTEN PERMISSION OF HUNTAIR CORPORATION.						JOB NO: xxxx-xxx		
				FRACTIONS : ±1/32	CLEANSUITE			
				0.0 :    ±0.1				
				0.00 :    ±0.03				
				0.000 :    ±0.010				
				0.0000 :    GIVEN				
				ANGLES : ±0.5°				

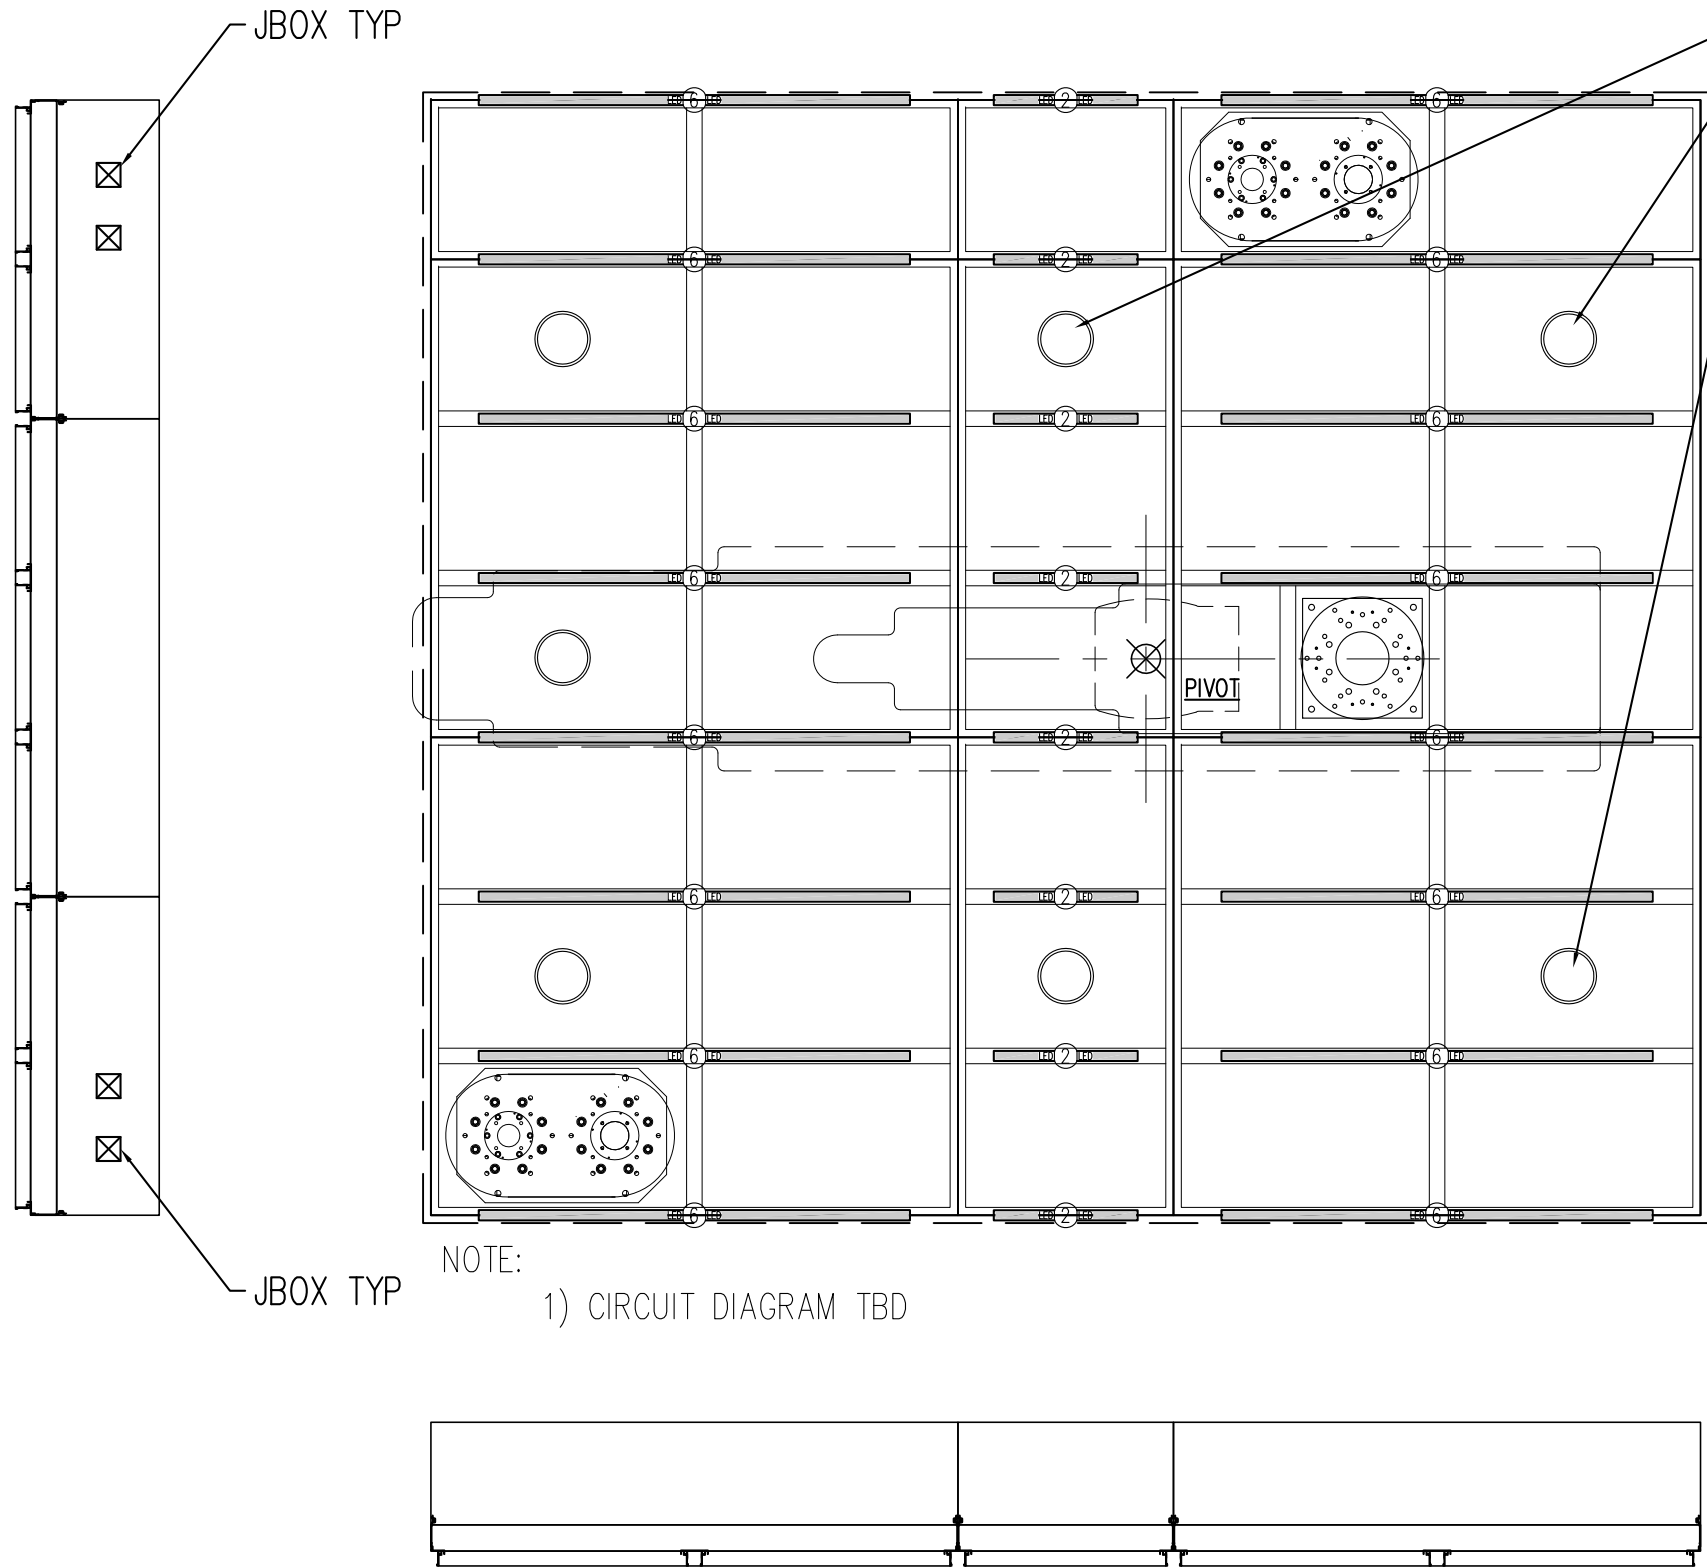

CAN LIGHTING LOCATIONS  
(RECOMMENDED LOCATIONS PER PREVIOUS REVISIONS)

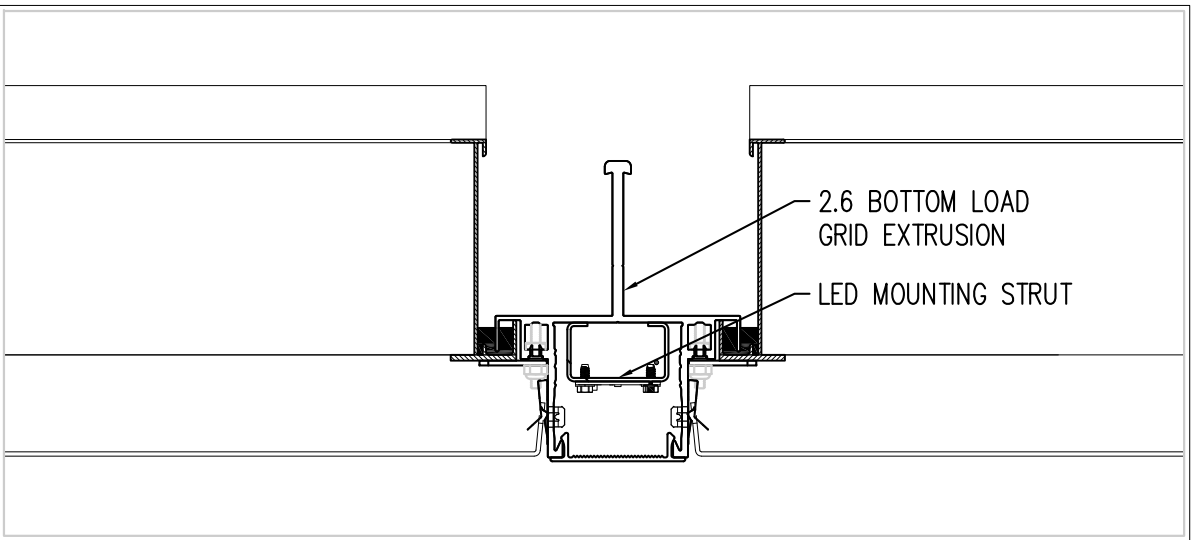

LED LIGHTING SECTION TYP

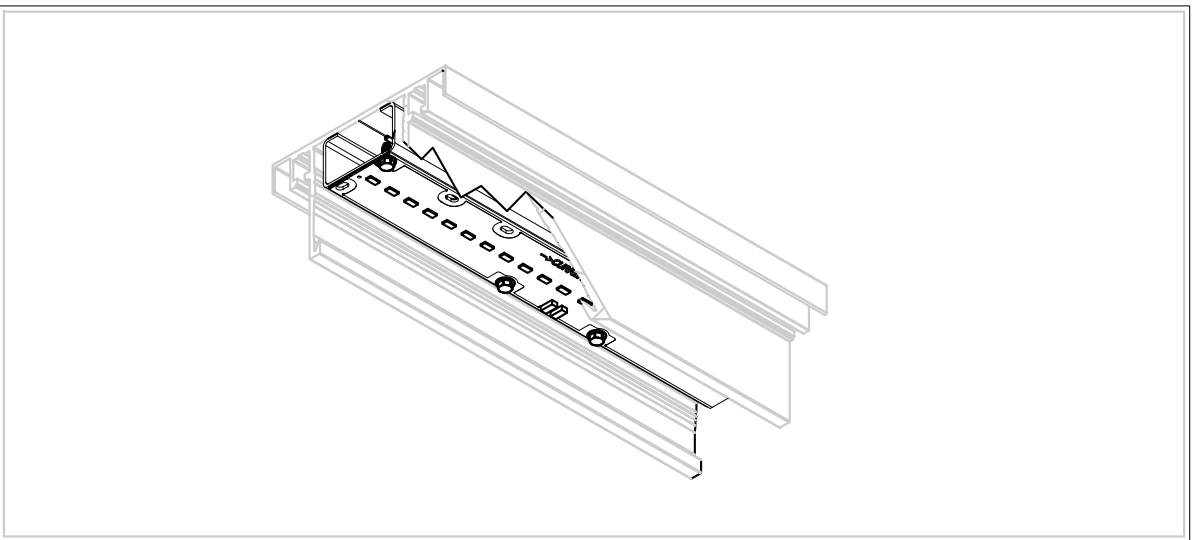

LED LIGHTING ISOMETRIC TYP

KEY:

 =LED LIGHTS

FILE NAME: 14-6019_VA_CATH_Layout_rev06.dwg			
REV:	DATE:	BY:	DESCRIPTION
THIS DRAWING, SPECIFICATIONS, AND CONCEPTS CONTAINED HEREIN ARE THE SOLE PROPERTY OF HUNTAIR, AND MAY NOT BE REPRODUCED OR USED IN ANY FASHION WITHOUT THE PRIOR WRITTEN PERMISSION OF HUNTAIR CORPORATION.			

TOLERANCES  
UNLESS OTHERWISE  
SPECIFIED

FRACTIONS : ±1/32

0.0 : ±0.1

0.00 : ±0.03

0.000 : ±0.010



0.0000 : GIVEN

ANGLES : ±0.5°

# LIGHTING LAYOUT

# CLEANSUITE


DRAWN BY: mfarnsworth		19855 SW 124th AVENUE TUALATIN, OR 97062 Phone (503) 639-0113 Fax (503) 639-1269	
ISSUED ON: 8/4/2014		TITLE: VA-PALO ALTO CATH LAB CLEANSUITE LAYOUT	
CHECKED BY:	SIZE: <b>B</b>	DRAWING NO: 14-6019	
SCALE: NONE	JOB NO: xxxx-xxx	SHEET: OF:	

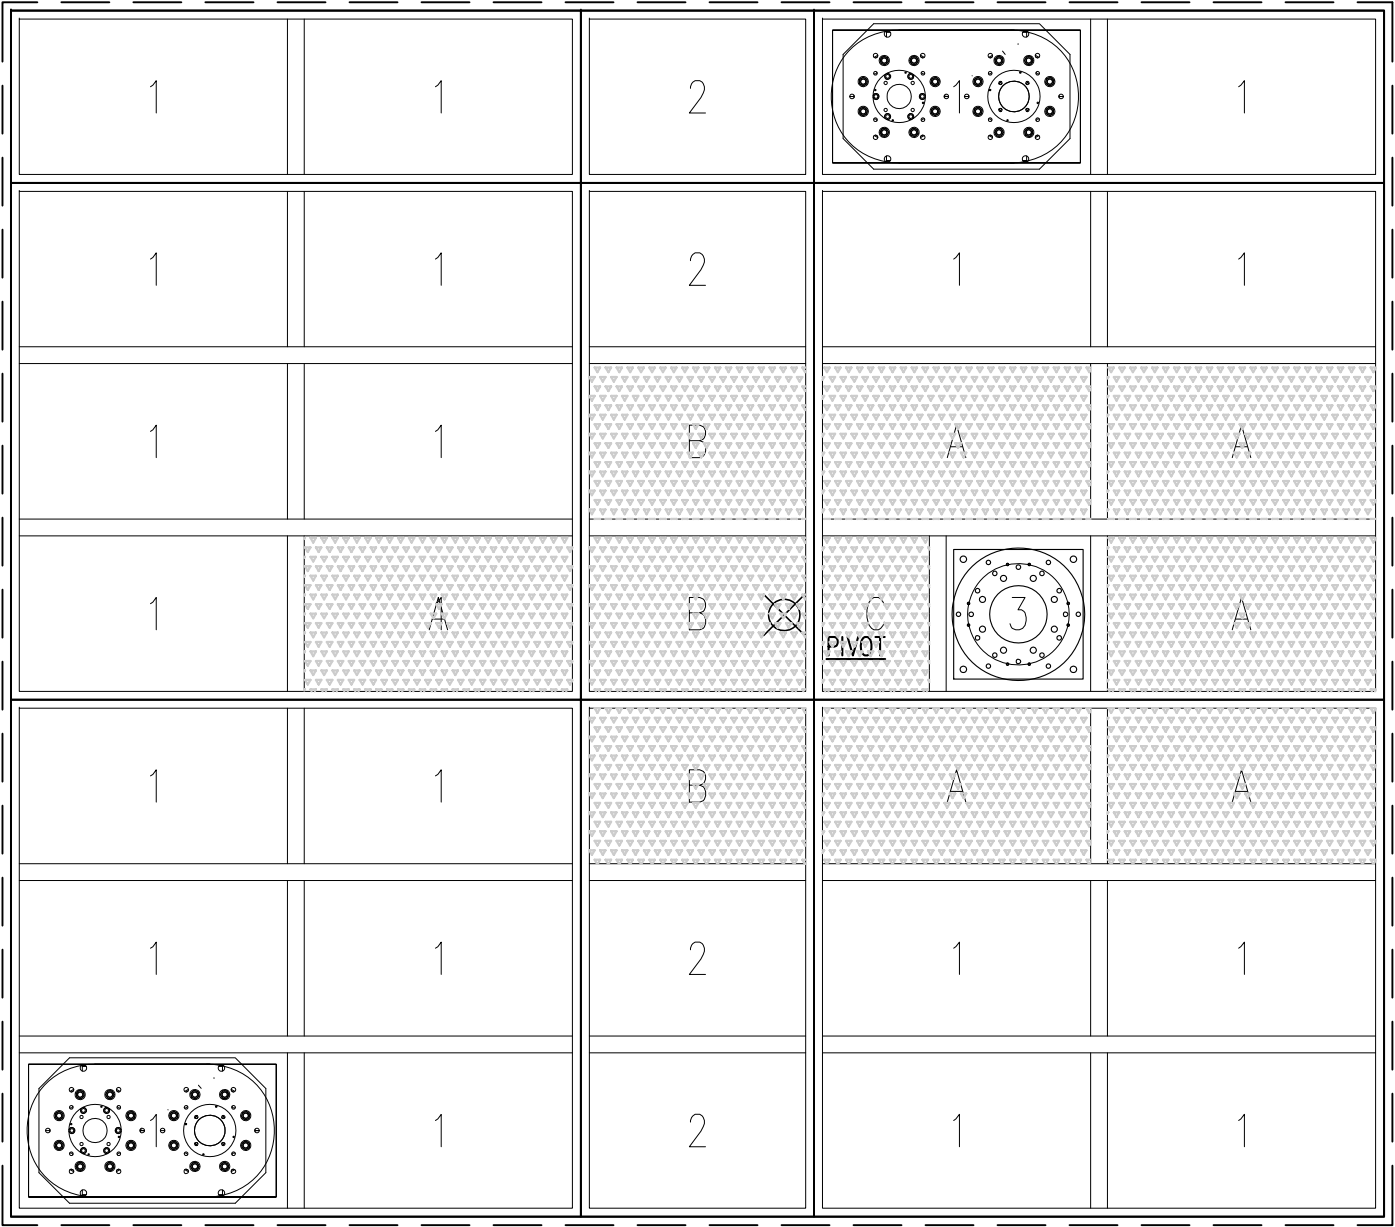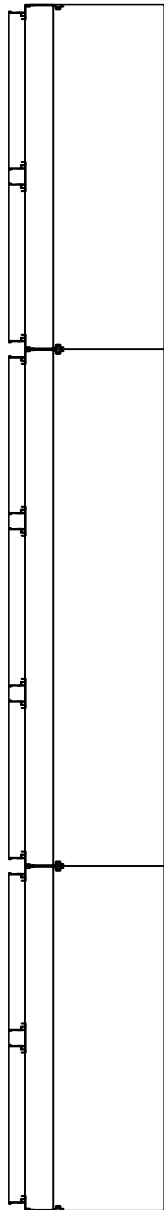


---- SUPPLY OPENINGS ----		
TAG	SIZE	QTY
A	26.600 x 44.000	6
B	26.600 x 36.000	3
C	19.000 x 26.600	1

---- BLANK TAGS ----		
TAG	SIZE	QTY
1	26.600 x 44.000	22
2	26.600 x 36.000	4
3	25.000 x 26.600	1

SYSTEM SIZING

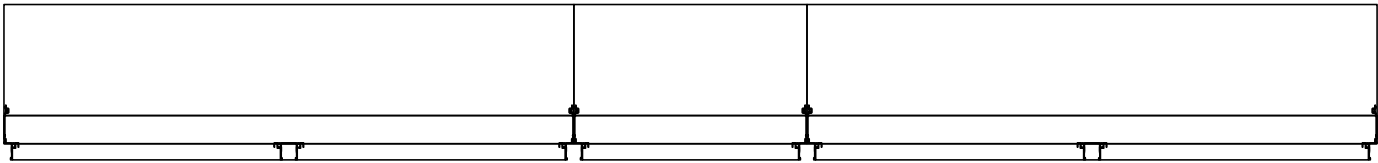

DIFFUSER AREA: 72.2SF  
ACH: 24 VELOCITY: 32fpm CFM: 2360


KEY:  
 = SUPPLY AIR


FILE NAME: 14-6019_VA_CATH_Layout_rev06.dwg			
REV:	DATE:	BY:	DESCRIPTION
THIS DRAWING, SPECIFICATIONS, AND CONCEPTS CONTAINED HEREIN ARE THE SOLE PROPERTY OF HUNTAIR, AND MAY NOT BE REPRODUCED OR USED IN ANY FASHION WITHOUT THE PRIOR WRITTEN PERMISSION OF HUNTAIR CORPORATION.			

TOLERANCES UNLESS OTHERWISE SPECIFIED	
FRACTIONS : ±1/32	
0.0 :	±0.1
0.00 :	±0.03
0.000 :	±0.010
0.0000 :	GIVEN
ANGLES :	±0.5°

GRID OPENING LAYOUT

CLEANSUITE

DRAWN BY: mfarnsworth		19855 SW 124th AVENUE TUALATIN, OR 97062 Phone (503) 639-0113 Fax (503) 639-1269	
		TITLE: VA-PALO ALTO CATH LAB CLEANSUITE LAYOUT	
ISSUED ON: 8/4/2014	CHECKED BY:	SIZE: <b>B</b> DRAWING NO: 14-6019	
SCALE: NONE	JOB NO: xxxx-xxx	SHEET:	OF:

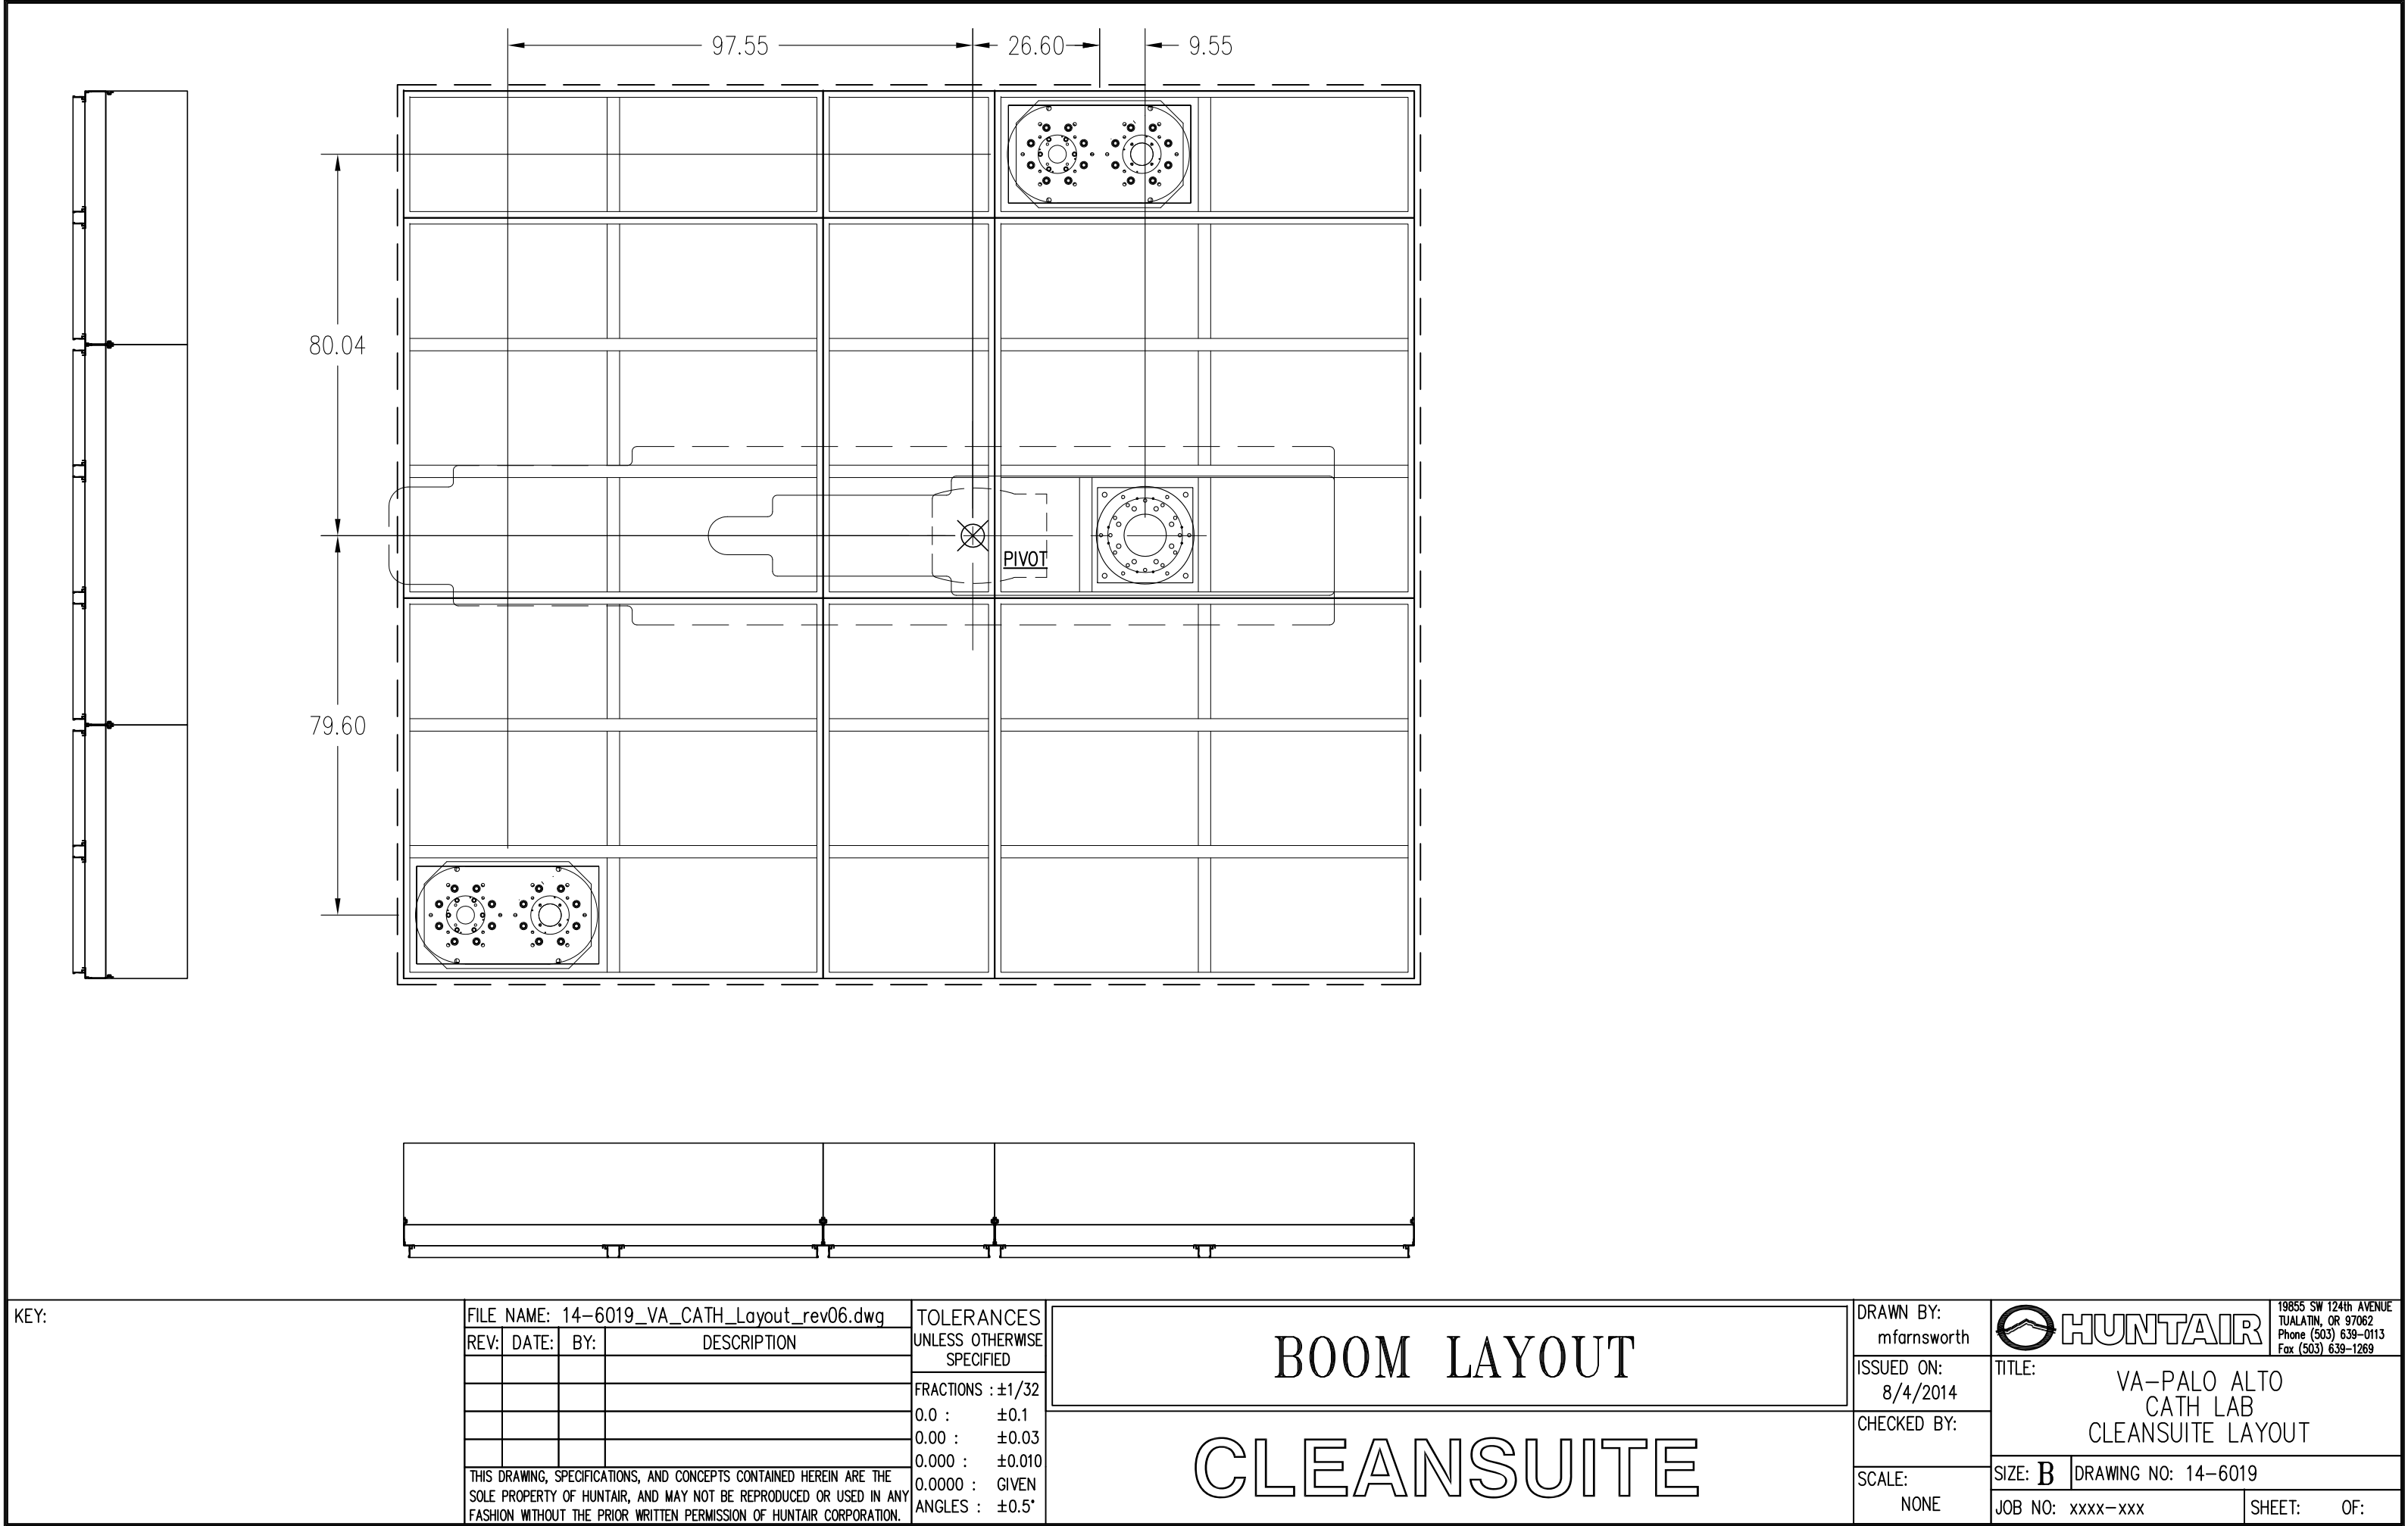


KEY:

FILE NAME: 14-6019_VA_CATH_Layout_rev06.dwg			
REV:	DATE:	BY:	DESCRIPTION
THIS DRAWING, SPECIFICATIONS, AND CONCEPTS CONTAINED HEREIN ARE THE SOLE PROPERTY OF HUNTAIR, AND MAY NOT BE REPRODUCED OR USED IN ANY FASHION WITHOUT THE PRIOR WRITTEN PERMISSION OF HUNTAIR CORPORATION.			

TOLERANCES UNLESS OTHERWISE SPECIFIED	
FRACTIONS : ±1/32	
0.0 :	±0.1
0.00 :	±0.03
0.000 :	±0.010
0.0000 :	GIVEN
ANGLES :	±0.5°

BOOM LAYOUT	
CLEANSUITE	

DRAWN BY: mfarnsworth
ISSUED ON: 8/4/2014
CHECKED BY:
SCALE: NONE

	19855 SW 124th AVENUE TUALATIN, OR 97062 Phone (503) 639-0113 Fax (503) 639-1269	
	TITLE: VA-PALO ALTO CATH LAB CLEANSUITE LAYOUT	
SIZE: <b>B</b>	DRAWING NO: 14-6019	
JOB NO: xxxx-xxx	SHEET:	OF: