


KEY NOTES


- REFRIGERANT PIPING DROPS DOWN TO CU'S STACKED, EXTEND IN ATTIC AS SHOWN.
- REFRIGERANT PIPING DROPS DOWN TO FIRST FLOOR, SEE SHEET MP220 FOR CONTINUATION.
- REFRIGERANT PIPING IN SECOND FLOOR ATTIC, EXTEND TO SHEET MP20 FOR PIPING SCHEDULES AND PIPING SIZES ON SCHEMATICS.
- REFRIGERANT PIPING IN ATTIC, SEE PIPING SCHEDULES SHEET MP20 FOR PIPING SIZES ON SCHEMATICS.
- CONDENSER WATER PIPING DROPS DOWN TO CU'S STACKED, EXTEND IN ATTIC AS SHOWN. SEE SHEET MP20 FOR PIPING SIZES ON SCHEMATICS.
- UNIT SERVICE CLEARANCE AREA.
- REFRIGERANT PIPING DROPS THRU ROOF FROM CU AND EXTEND IN ATTIC AS SHOWN.
- CONDENSER WATER PIPING DROPS THRU ROOF FROM CU'S AND EXTEND IN ATTIC AS SHOWN.

EQUIPMENT NOTE

REFER TO SHEET MP20 FOR EQUIPMENT SCHEDULES. REFER TO SHEETS MP20 AND MP22 FOR PIPING SCHEDULES AND PIPING SIZES ON SCHEMATICS. SEE SHEET MP20 FOR PIPING SIZES ON SCHEMATICS. ALL ACCESS LOCATIONS FOR EQUIPMENT.

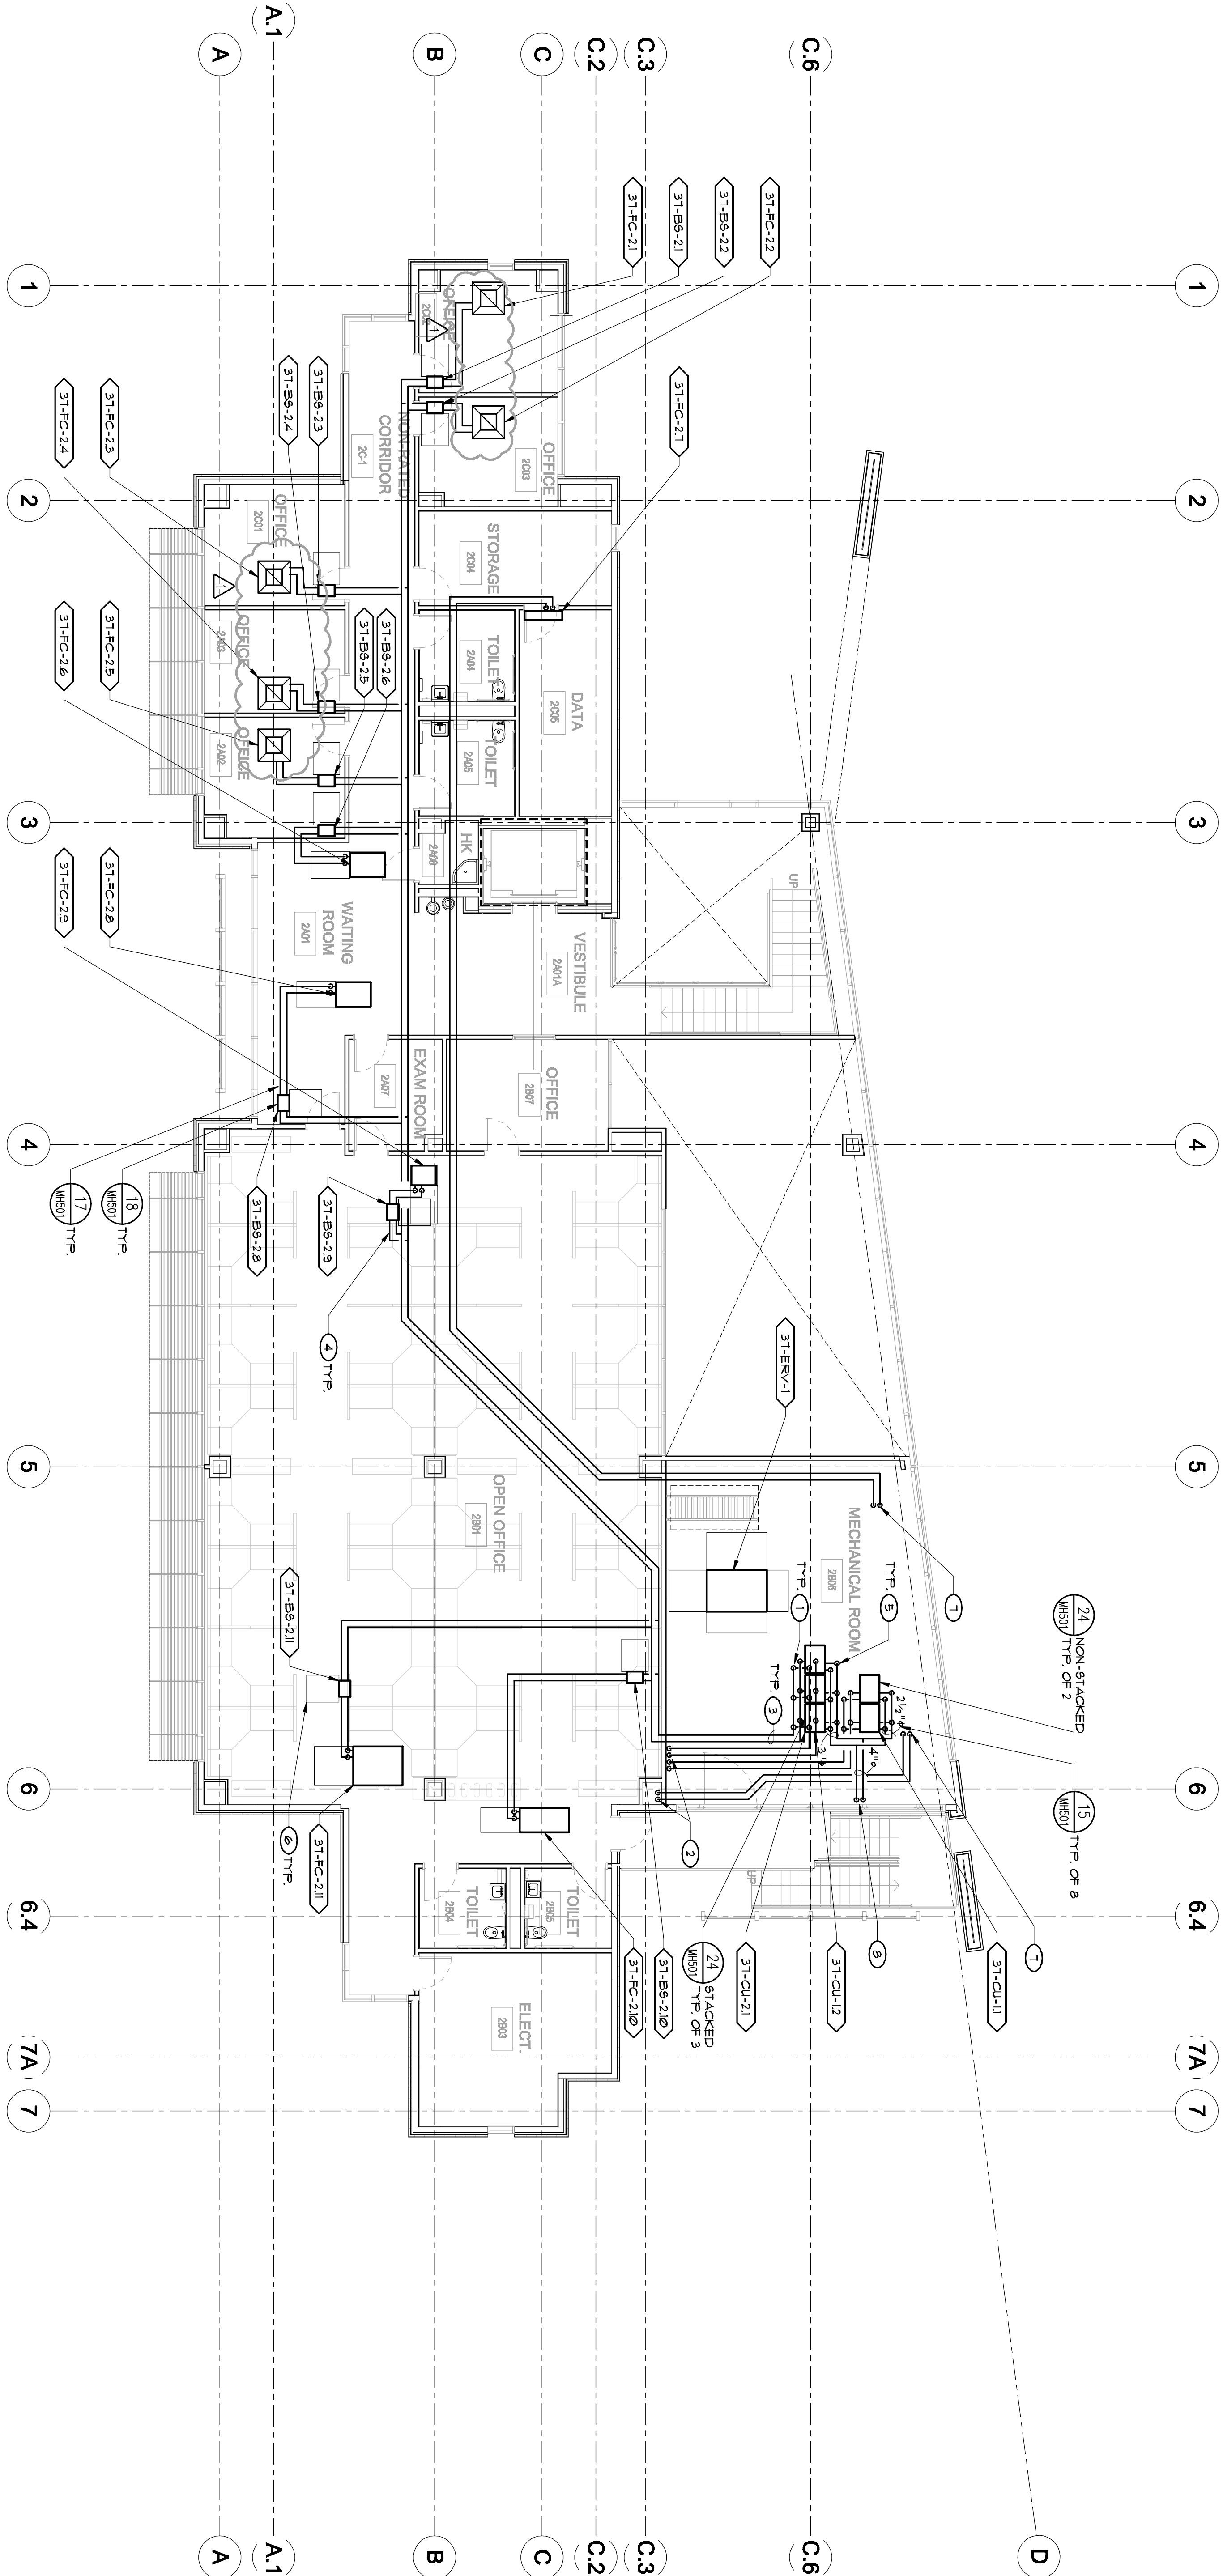

SECOND FLOOR MECHANICAL PLAN

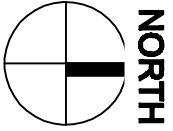

CONSULTANTS:

ARCHITECT/ENGINEERS:

SECOND FLOOR MECH. PIPING PLAN

Project Title

Project Number

Office of Construction and Facilities Management

Department of Veterans Affairs

Building Number

Drawing Number

MP220

Sheet of

08/11/2014

Checked

Drawn

DK GL

DN

Location

2016 E. CLINTON AVE, FRESNO, CA 93703

Project Title

Mental Health Psychosocial Rehab Recovery and Health Care for Homeless Veteran Center

Project Number

570-217

Building Number

37

Drawing Number

MP220

Sheet of

08/11/2014

Checked

Drawn

DK GL

DN

Location

2016 E. CLINTON AVE, FRESNO, CA 93703

Project Title

Mental Health Psychosocial Rehab Recovery and Health Care for Homeless Veteran Center

Project Number

570-217

Building Number

37

Drawing Number

MP220

Sheet of

08/11/2014

Checked

Drawn

DK GL

DN

Location

2016 E. CLINTON AVE, FRESNO, CA 93703

Project Title

Mental Health Psychosocial Rehab Recovery and Health Care for Homeless Veteran Center

Project Number

570-217

Building Number

37

Drawing Number

MP220

Sheet of

08/11/2014

Checked

Drawn

DK GL

DN

Location

2016 E. CLINTON AVE, FRESNO, CA 93703

Project Title

Mental Health Psychosocial Rehab Recovery and Health Care for Homeless Veteran Center

Project Number

570-217

Building Number

37

Drawing Number

MP220

Sheet of

08/11/2014

Checked

Drawn

DK GL

DN

Location

2016 E. CLINTON AVE, FRESNO, CA 93703

Project Title

Mental Health Psychosocial Rehab Recovery and Health Care for Homeless Veteran Center

Project Number

570-217

Building Number

37

Drawing Number

MP220

Sheet of

08/11/2014

Checked

Drawn

DK GL

DN

Location

2016 E. CLINTON AVE, FRESNO, CA 93703

Project Title

Mental Health Psychosocial Rehab Recovery and Health Care for Homeless Veteran Center

Project Number

570-217

Building Number

37

Drawing Number

MP220

Sheet of

08/11/2014

Checked

Drawn

DK GL

DN

Location

2016 E. CLINTON AVE, FRESNO, CA 93703

Project Title

Mental Health Psychosocial Rehab Recovery and Health Care for Homeless Veteran Center

Project Number

570-217

Building Number

37

Drawing Number

MP220

Sheet of

08/11/2014

Checked

Drawn

DK GL

DN

Location

2016 E. CLINTON AVE, FRESNO, CA 93703

Project Title

Mental Health Psychosocial Rehab Recovery and Health Care for Homeless Veteran Center

Project Number

570-217

Building Number

37

Drawing Number

MP220

Sheet of

08/11/2014

Checked

Drawn

DK GL

DN

Location

2016 E. CLINTON AVE, FRESNO, CA 93703

Project Title

Mental Health Psychosocial Rehab Recovery and Health Care for Homeless Veteran Center

Project Number

570-217

Building Number

37

Drawing Number

MP220

Sheet of

08/11/2014

Checked

Drawn

DK GL

DN

Location

2016 E. CLINTON AVE, FRESNO, CA 93703

Project Title

Mental Health Psychosocial Rehab Recovery and Health Care for Homeless Veteran Center

Project Number

570-217

Building Number

37

Drawing Number

MP220

Sheet of

08/11/2014

Checked

Drawn

DK GL

DN

Location

2016 E. CLINTON AVE, FRESNO, CA 93703

Project Title

Mental Health Psychosocial Rehab Recovery and Health Care for Homeless Veteran Center

Project Number

570-217

Building Number

37

Drawing Number

MP220

Sheet of

08/11/2014

Checked

Drawn

DK GL

DN

Location

2016 E. CLINTON AVE, FRESNO, CA 93703

Project Title

Mental Health Psychosocial Rehab Recovery and Health Care for Homeless Veteran Center

Project Number

570-217

Building Number

37

Drawing Number

MP220

Sheet of

08/11/2014

Checked

Drawn

DK GL

DN

Location

2016 E. CLINTON AVE, FRESNO, CA 93703

Project Title

Mental Health Psychosocial Rehab Recovery and Health Care for Homeless Veteran Center

Project Number

570-217

Building Number

37

Drawing Number

MP220

Sheet of

08/11/2014

Checked

Drawn

DK GL

DN

Location

2016 E. CLINTON AVE, FRESNO, CA 93703

Project Title

Mental Health Psychosocial Rehab Recovery and Health Care for Homeless Veteran Center

Project Number

570-217

Building Number

37

Drawing Number

MP220

Sheet of

08/11/2014

Checked

Drawn

DK GL

DN

Location

2016 E. CLINTON AVE, FRESNO, CA 93703

Project Title

Mental Health Psychosocial Rehab Recovery and Health Care for Homeless Veteran Center

Project Number

570-217

Building Number

37

Drawing Number

MP220

Sheet of

08/11/2014

Checked

Drawn

DK GL

DN

Location

2016 E. CLINTON AVE, FRESNO, CA 93703

Project Title

Mental Health Psychosocial Rehab Recovery and Health Care for Homeless Veteran Center

Project Number

570-217

Building Number

37

Drawing Number

MP220

Sheet of

08/11/2014

Checked

Drawn

DK GL

DN

Location

2016 E. CLINTON AVE, FRESNO, CA 93703

Project Title

Mental Health Psychosocial Rehab Recovery and Health Care for Homeless Veteran Center

Project Number

570-217

Building Number

37

Drawing Number

MP220

Sheet of

08/11/2014

Checked

Drawn

DK GL

DN

Location

2016 E. CLINTON AVE, FRESNO, CA 93703

Project Title

Mental Health Psychosocial Rehab Recovery and Health Care for Homeless Veteran Center

Project Number