

ELECTRICAL GENERAL NOTES

- ELECTRICAL PLAN IS DIAGRAMMATIC ONLY.
- FIELD VERIFY ALL EXISTING CONDITIONS, INCLUDING LOCATIONS OF EXISTING OUTLETS AND INFEEDES, AND VERIFY THE SUITABILITY OF THE EXISTING ELECTRICAL AND VOICE/DATA INFEEDES AND OUTLETS FOR REUSE IN THE NEW FURNITURE LAYOUT. REUSE EXISTING ELECTRICAL AND VOICE/DATA INFEEDES WHERE POSSIBLE. COORDINATE WITH GSA & AGENCY FOR EXACT LOCATIONS OF FURNITURE CONNECTIONS AND POWER AND DATA REQUIREMENTS.
- PROVIDE ADDITIONAL ELECTRICAL AND VOICE/DATA INFEEDES AS NECESSARY TO MEET AGENCY AND GSA REQUIREMENTS.
- IDENTIFY AND DOCUMENT CRITICAL DIMENSIONS FOR INFEEDE LOCATIONS. SUBMIT A PLAN TO GSA & AGENCY FOR REVIEW AND COORDINATION OF LOCATIONS OF PROPOSED NEW AND REUSED INFEEDE LOCATIONS. COMPLY WITH ALL APPLICABLE CODE REQUIREMENTS.
- VERIFY & COORDINATE PLACEMENT OF AGENCY EQUIPMENT (NIC) WITH ELECTRICAL AND DATA OUTLETS.
- REVIEW AND VERIFY WITH GSA ALL SYSTEMS FURNITURE PANEL (POWERED, NON-POWERED, AND PASS-THROUGH) LOCATIONS.
- SEE WORKSTATION TYPICALS FOR OUTLET LOCATIONS IN WORKSTATIONS. VERIFY WITH AGENCY & GSA.

ELECTRICAL LEGEND

- PROPOSED NEW POWER INFEEDE LOCATED IN WALL FOR SYSTEMS FURNITURE. FURNITURE MANUFACTURER/DEALER COORDINATE WITH AGENCY FOR EXACT REQUIREMENTS AND LOCATION.
- PROPOSED NEW POWER INFEEDE LOCATED IN FLOOR, FLUSH MOUNTED, FOR SYSTEMS FURNITURE. FURNITURE MANUFACTURER/DEALER COORDINATE WITH AGENCY FOR EXACT REQUIREMENTS AND LOCATION.
- PROPOSED NEW VOICE & DATA INFEEDE LOCATED IN WALL. COORDINATE WITH AGENCY FOR EXACT REQUIREMENTS AND LOCATION.
- PROPOSED NEW VOICE & DATA INFEEDE LOCATED IN FLOOR, FLUSH MOUNTED, FOR SYSTEMS FURNITURE AND CONFERENCE ROOMS. COORDINATE WITH AGENCY FOR EXACT REQUIREMENTS AND LOCATION.
- EXISTING POWER OUTLET, DUPLEX, WALL MOUNTED
- NEW POWER OUTLET, DUPLEX, WALL MOUNTED
- NEW POWER OUTLET, QUAD, WALL MOUNTED
- NEW POWER OUTLET, QUAD, FLOOR FLUSH MOUNTED

NOTES:

- *"E" DENOTES EXISTING VOICE/POWER/DATA OUTLETS
- W&P SYSTEM APPROVAL IS PENDING

FURNITURE GENERAL NOTES

- FURNITURE PLAN IS CONCEPTUAL LAYOUT ONLY. VERIFY & COORDINATE WITH GSA & AGENCY FOR EXACT REQUIREMENTS. PROVIDE TYPICAL WORKSTATION AND COMPLETE INSTALLATION PLANS FOR REVIEW AND APPROVAL.
- FURNITURE MANUFACTURER/DEALER TO FIELD VERIFY CRITICAL DIMENSIONS FOR FURNITURE FIT.
- FOR PRIVATE OFFICES FURNITURE MANUFACTURER/DEALER SHALL COORDINATE DESIGN WITH THE MANUFACTURED PARTITION ASSEMBLIES. MANUFACTURER/DEALER TO PROVIDE A DIMENSIONALLY COMPATIBLE, STABLE, COST-EFFECTIVE DESIGN. COORDINATE FURNITURE PLACEMENT WITH LOCATIONS OF VOICE/DATA OUTLETS PROVIDED BY THE MANUFACTURED PARTITION ASSEMBLIES. MANUFACTURER/DEALER. PROVIDE INSTALLATION DRAWINGS AND CAD FILES AS REQUIRED.
- FURNITURE MANUFACTURER/DEALER TO COORDINATE AND VERIFY WITH AGENCY & GSA EXACT LOCATIONS OF FURNITURE CONNECTIONS AND POWER REQUIREMENTS.
- DESKTOP EQUIPMENT IN WORKSTATIONS NOT SHOWN. TYPICAL. COORDINATE WITH AGENCY FOR EXACT REQUIREMENTS.
- FURNITURE DEALER TO VERIFY INSTALLATION PLAN COMPLIES WITH ALL APPLICABLE CODE REQUIREMENTS FOR EGRESS AND ACCESSIBILITY.
- GENERAL CONTRACTOR'S ELECTRICIAN TO COORDINATE WITH THE FURNITURE DEALER FOR POWER HOOK-UP FOR INFEEDES AND OUTLETS. INCLUDE ALL COMPONENTS AND ACCESSORIES FOR A COMPLETE INSTALLATION.
- FOR SECURITY REQUIREMENTS, SEE DRAWINGS AND SPECS BY TTG ENGINEERING.
- EXISTING FURNITURE & EQUIPMENT TO BE RELOCATED AND REUSED IS DENOTED WITH "A" TAG PER SCHEDULE ABOVE. FIELD VERIFY EXISTING CONDITIONS AND CLEARANCE REQUIREMENTS.

PLAN LEGEND


- NOT IN CONTRACT (NIC)
- NEW WORKSTATION DESIGNATED AREA
- EXISTING WALL/PARTITION
- NEW PARTITION/WALL
- NEW MANUFACTURED PARTITION ASSEMBLY

CONFERENCE ROOM


- 612 TYPICAL NAME ROOM OR AREA NUMBER
- PS-1 EQUIPMENT TAG & SIZE, SEE SCHEDULE & INVENTORY
- 24' x 20'
- BC-1 FURNITURE TAG, SEE SCHEDULE & INVENTORY

FURNITURE /EQUIPMENT KEY SCHEDULE



FURN/EQUIP	DESCRIPTION	FURN/EQUIP	DESCRIPTION
AV	AUDIO/VIDEO COMPONENT UNIT	OT	OCCASIONAL TABLE
BC	BOOK CASE	OV	TOASTER/MICROWAVE OVEN
CH	CHAIR	PC	COPY/PRINTER/SCANNER
CR	CRENZIA	PR	PRINTER
CT	CONFERENCE TABLE	PS	PAPER SHREDDER
DS	DESK	RF	REFRIGERATOR, BOTTOM FREEZER
EP	ELEC PUNCH MACHINE	SC	STORAGE UNIT, METAL
FX	FAX MACHINE	TV	TELEVISION
LF	LATERAL FILE	VD	VENDING MACHINE, BEVERAGE
LM	LAMINATOR		

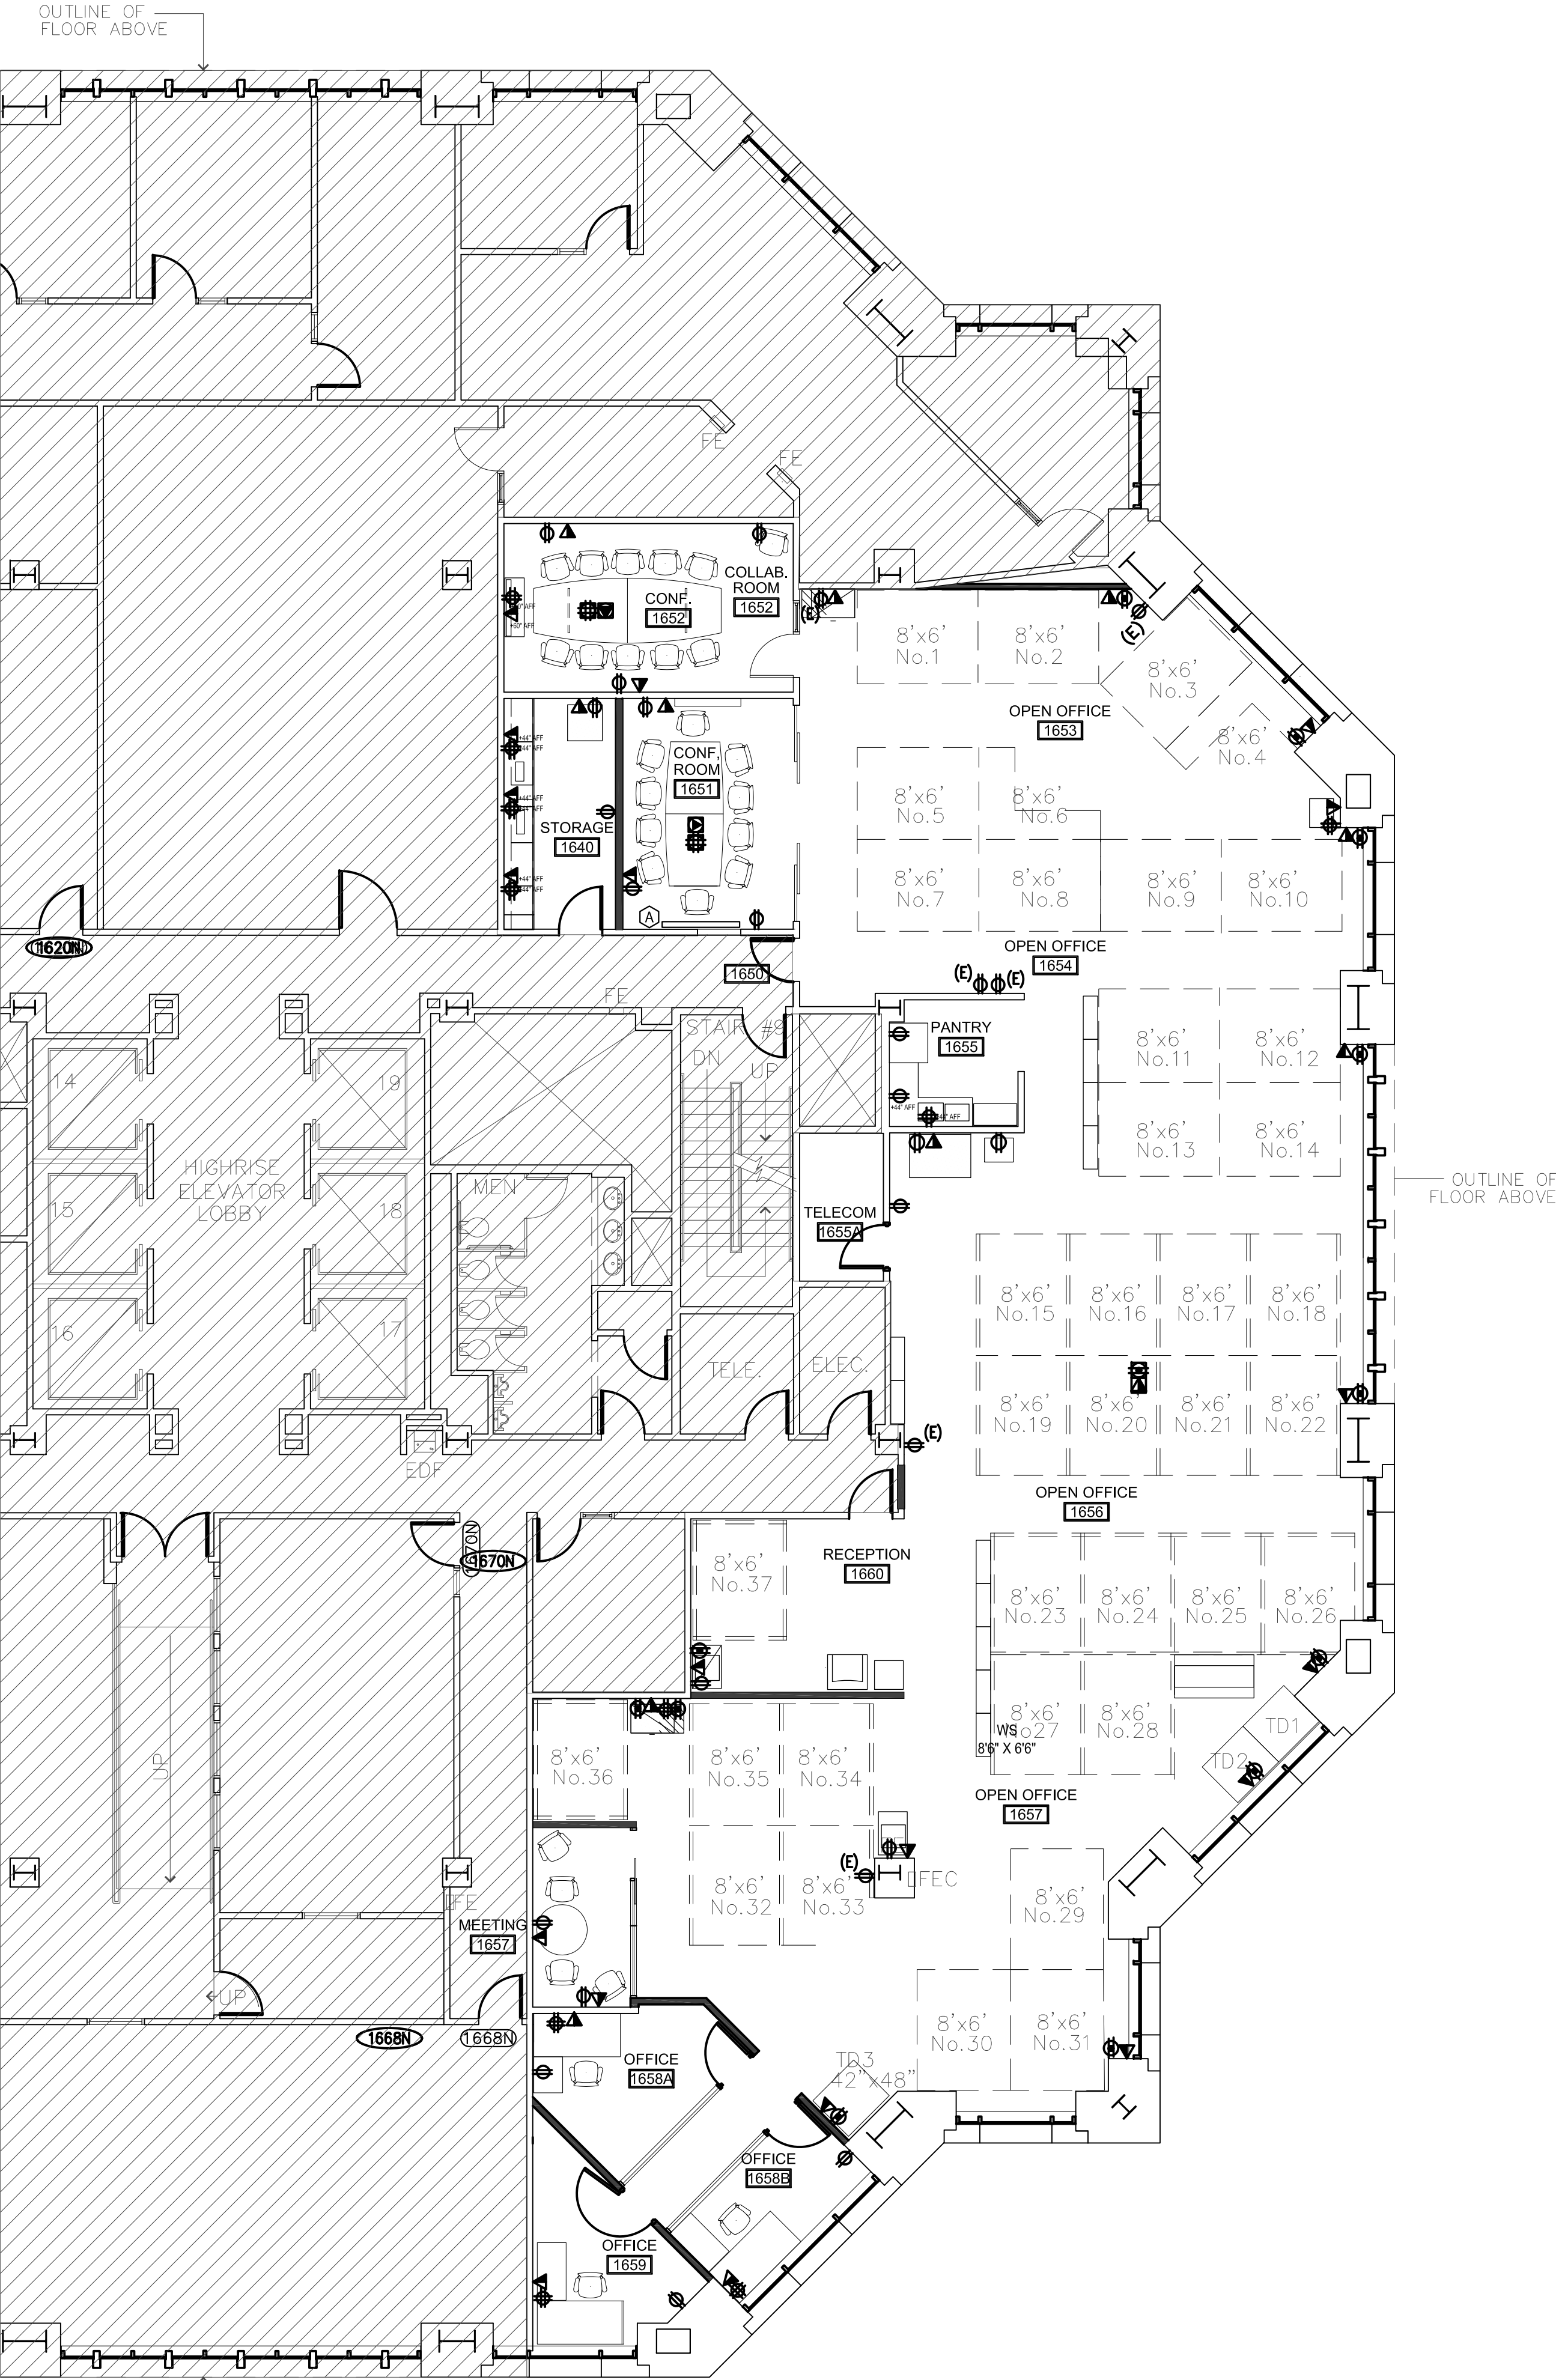

FILE:1631_Base Plan FLOOR 16.DWG

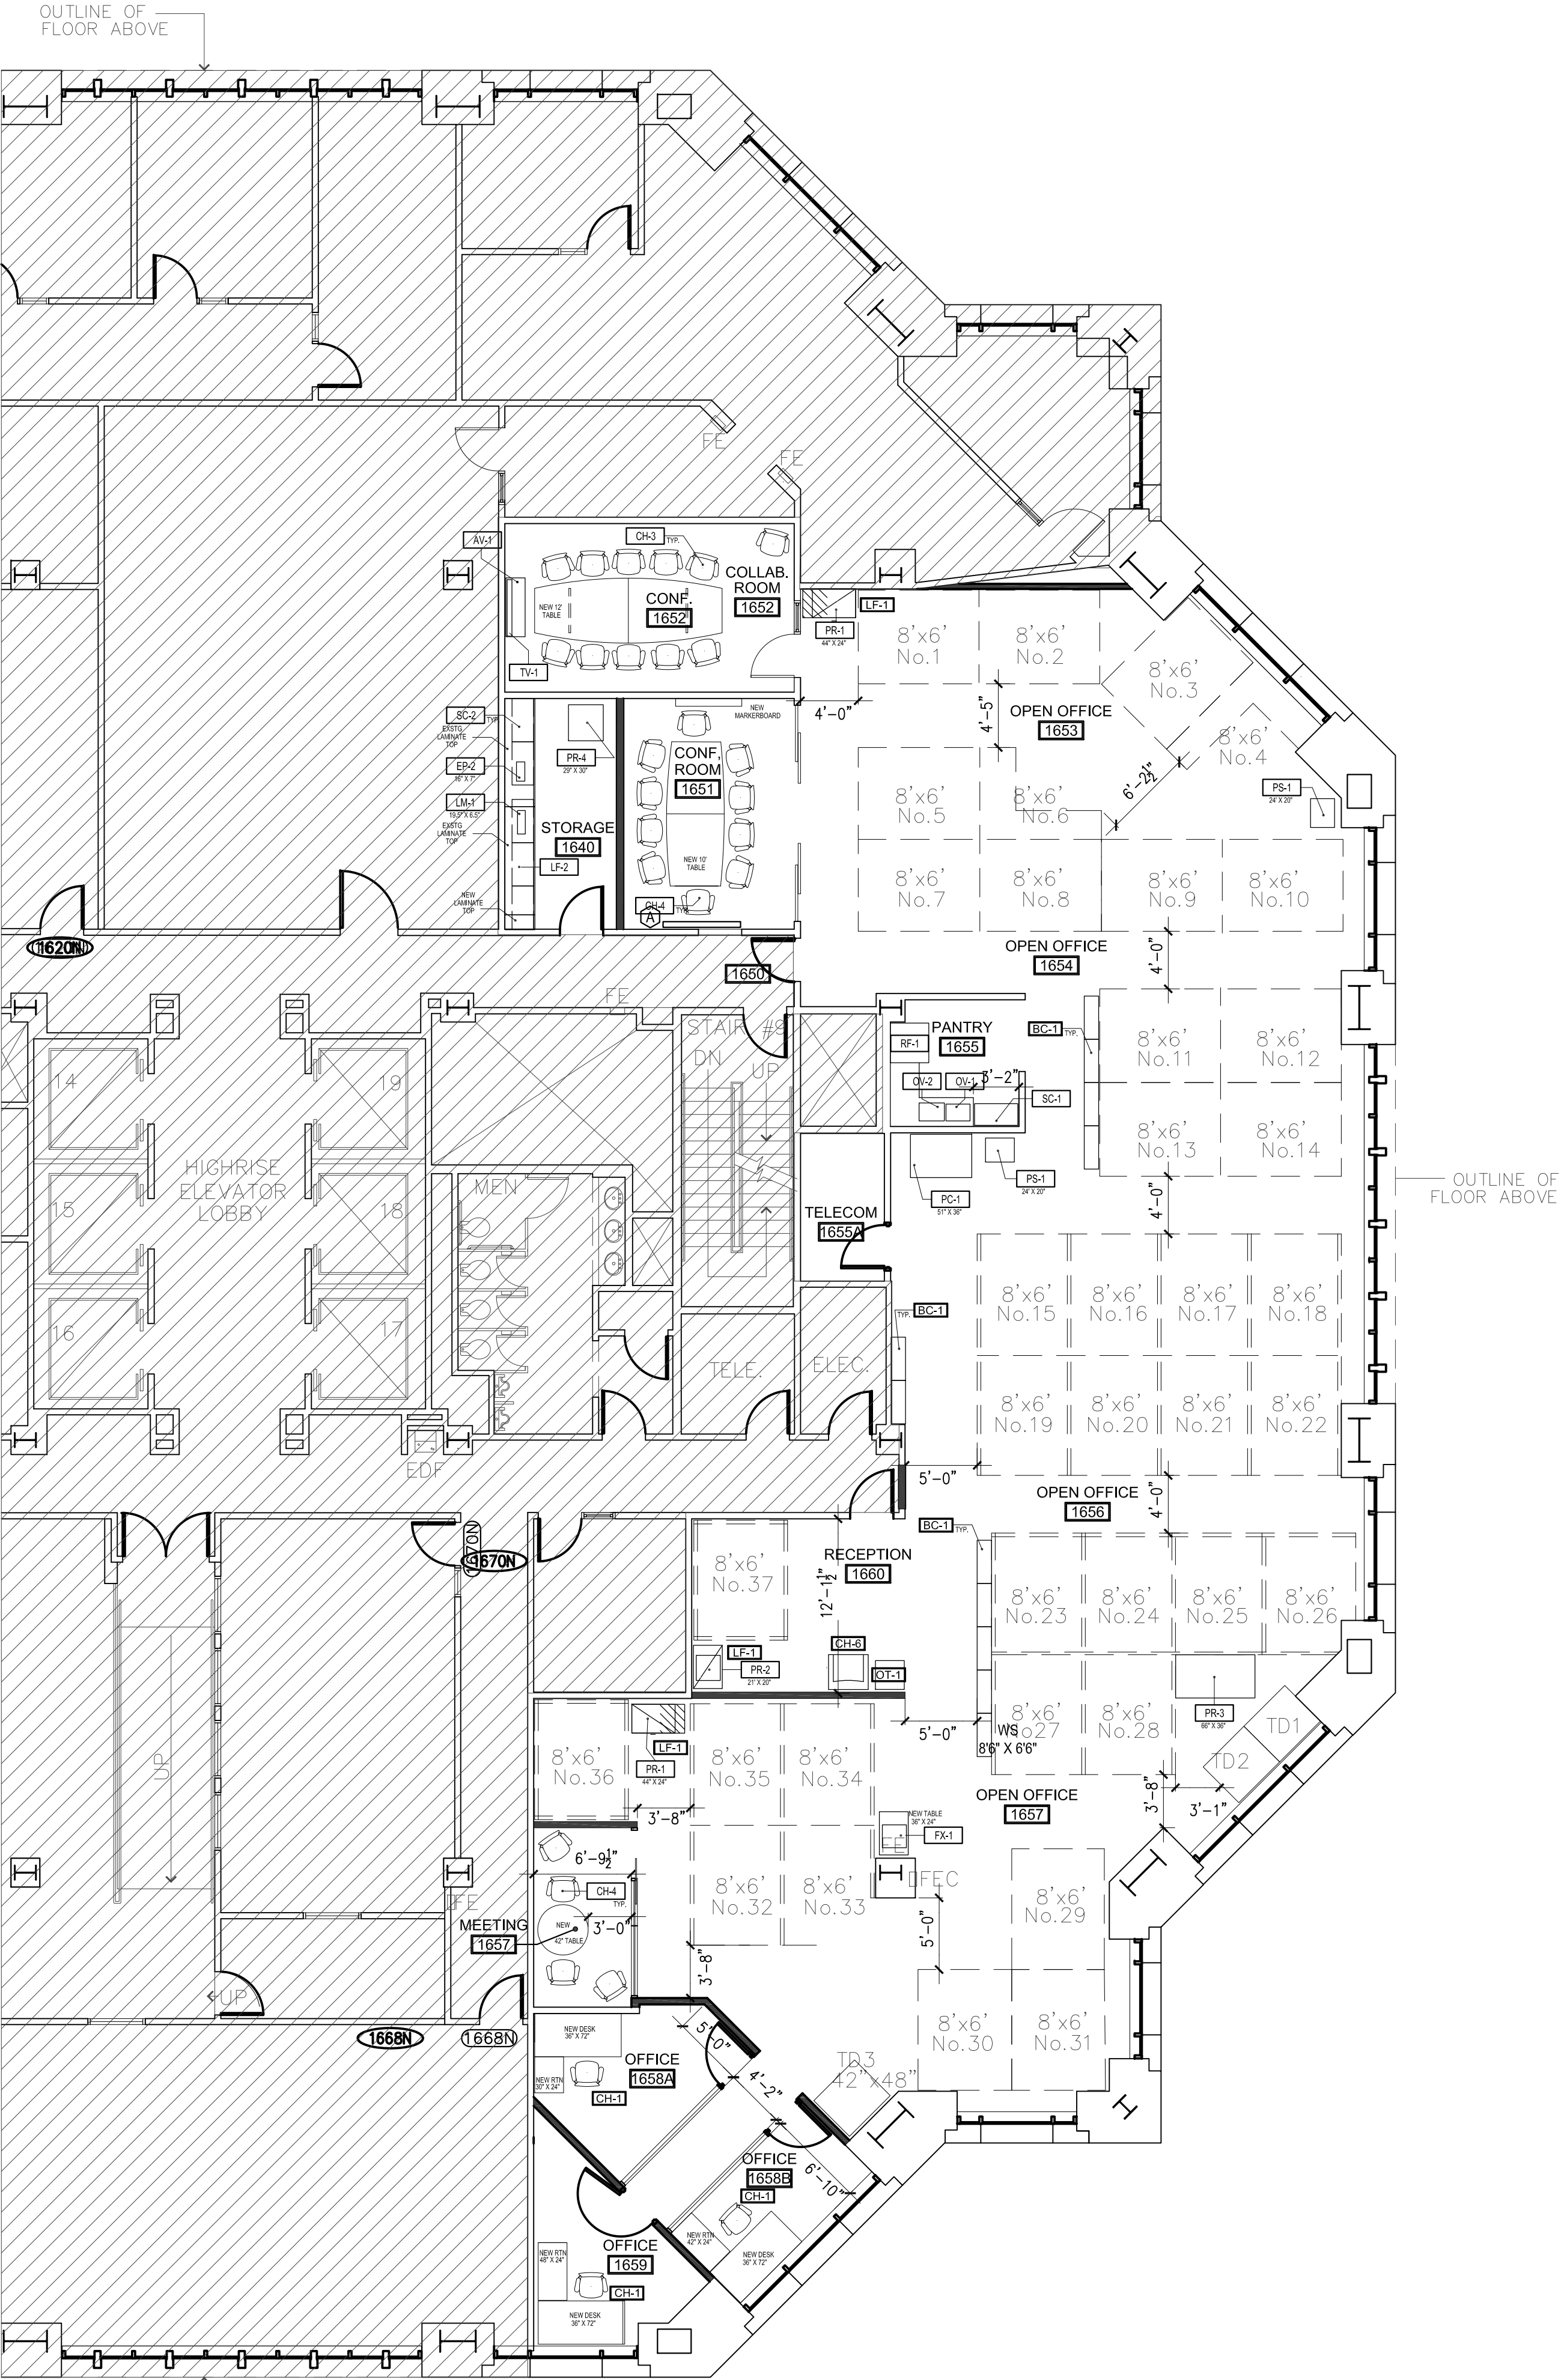

FILE:1631_Base Plan FLOOR 16.DWG

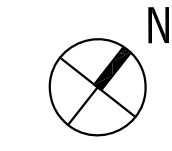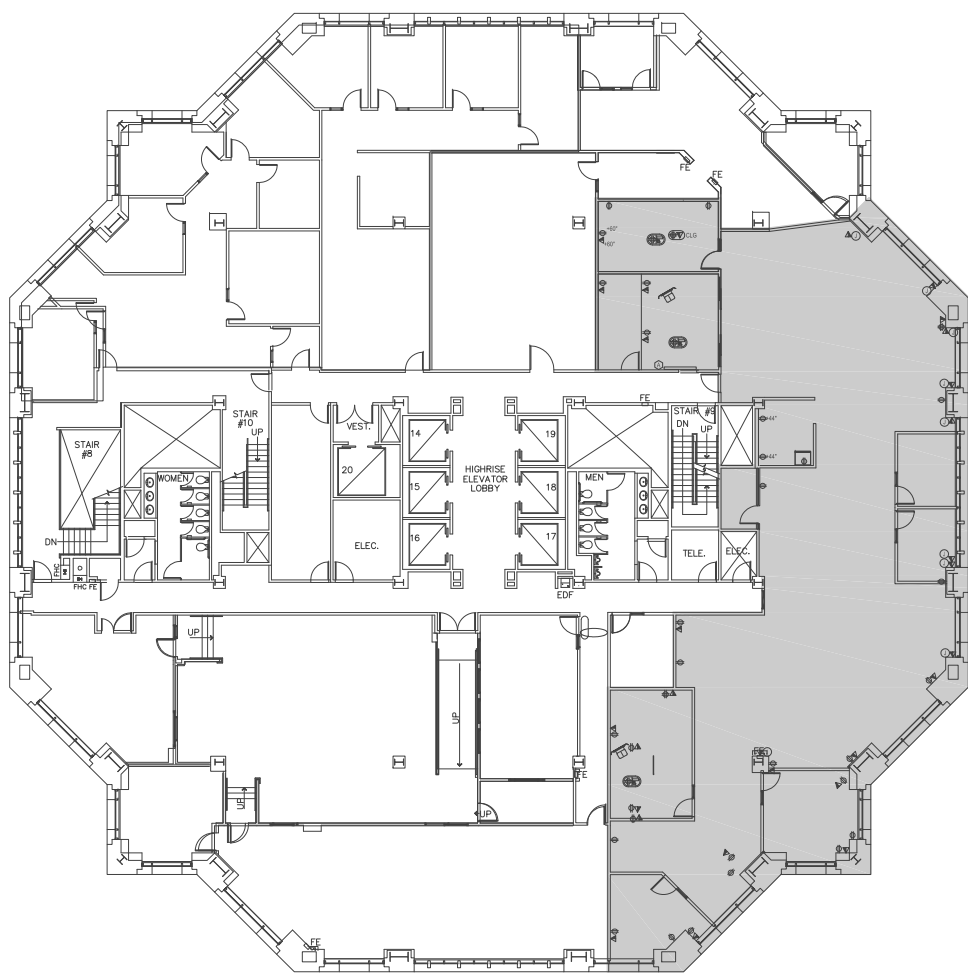

NOT TO SCALE

GENERAL SERVICES ADMINISTRATION
PUBLIC BUILDING SERVICES
SAN FRANCISCO, CALIF.
FACILITIES MANAGEMENT DIVISION
REGION 9



GENERAL SERVICES ADMINISTRATION
TECHNICAL SECTION/INTERIOR DESIGN 9P3PMFT
450 GOLDEN GATE AVENUE, 4TH Floor
SAN FRANCISCO, CALIFORNIA 94102

PROJECT:

VETERAN'S ADMINISTRATION
OFFICE OF INFORMATION TECHNOLOGY

RONALD DELLUM FEDERAL BUILDING
1301 CLAY STREET
OAKLAND, CA. 94612

PROPERTY OF THE UNITED STATES GOVERNMENT
FOR OFFICIAL USE ONLY
Do not remove this notice
Properly destroy documents when no longer needed

ARCHITECT

.XrefRAW_logo_cmyk_mid.tif

Planning, Programming, Design, & Management
801 S. GRAND AVENUE, SUITE 502
LOS ANGELES CA 90017
PHONE: 213-622-4993 FAX: 213-614-0538
WEB: HTTP://WWW.RAWINTERNATIONAL.COM

ENGINEER

RAW PROJECT NO. 1341

DATE	ISSUANCE
06/23/14	50% FURNITURE & SPACE LAYOUT SUBMITTAL
07/03/14	100% FURNITURE & SPACE LAYOUT SUBMITTAL

BUILDING	NAME	STR.	
PROJECT	ADDRESS	CITY:	
DRAWING	NUMBER		
	DESCRPT.	OAKLAND O&T	
	ACT/DESIGN:	CONSOLIDATION TO 16TH FLOOR	
	DRAWN BY		
	CHECKED BY		
	DATE		
	TITLE	CONCEPTUAL FURNITURE LAYOUT	
		& VOICE/POWER/DATA PLAN	
	NUMBER	A	06 01
	TYPE		
	SERIES		
	SEQUENCE		
FACIL. SURVEY/DOC. SVCS.	DESIGN CONTRACT NO.	GS-09P-08-KN-00020	
	TASK ORDER	GS-P-09-13-K2-5024	

SCALE: 1/8"=1'-0"

NOT FOR CONSTRUCTION

16TH FLOOR VOICE/POWER/DATA PLAN - FOR REF. ONLY

SCALE: 1/8"=1'-0" 2

16TH FLOOR FURNITURE PLAN - FOR REF. ONLY

SCALE: 1/8"=1'-0" 1

16TH FLOOR - AREA OF WORK

NOT TO SCALE

NOT FOR CONSTRUCTION

PROPERTY OF THE UNITED STATES GOVERNMENT
Do not remove this notice
Properly destroy documents when no longer needed