



1 ENLARGED TOILET ROOM PLAN
1/4" = 1'-0"

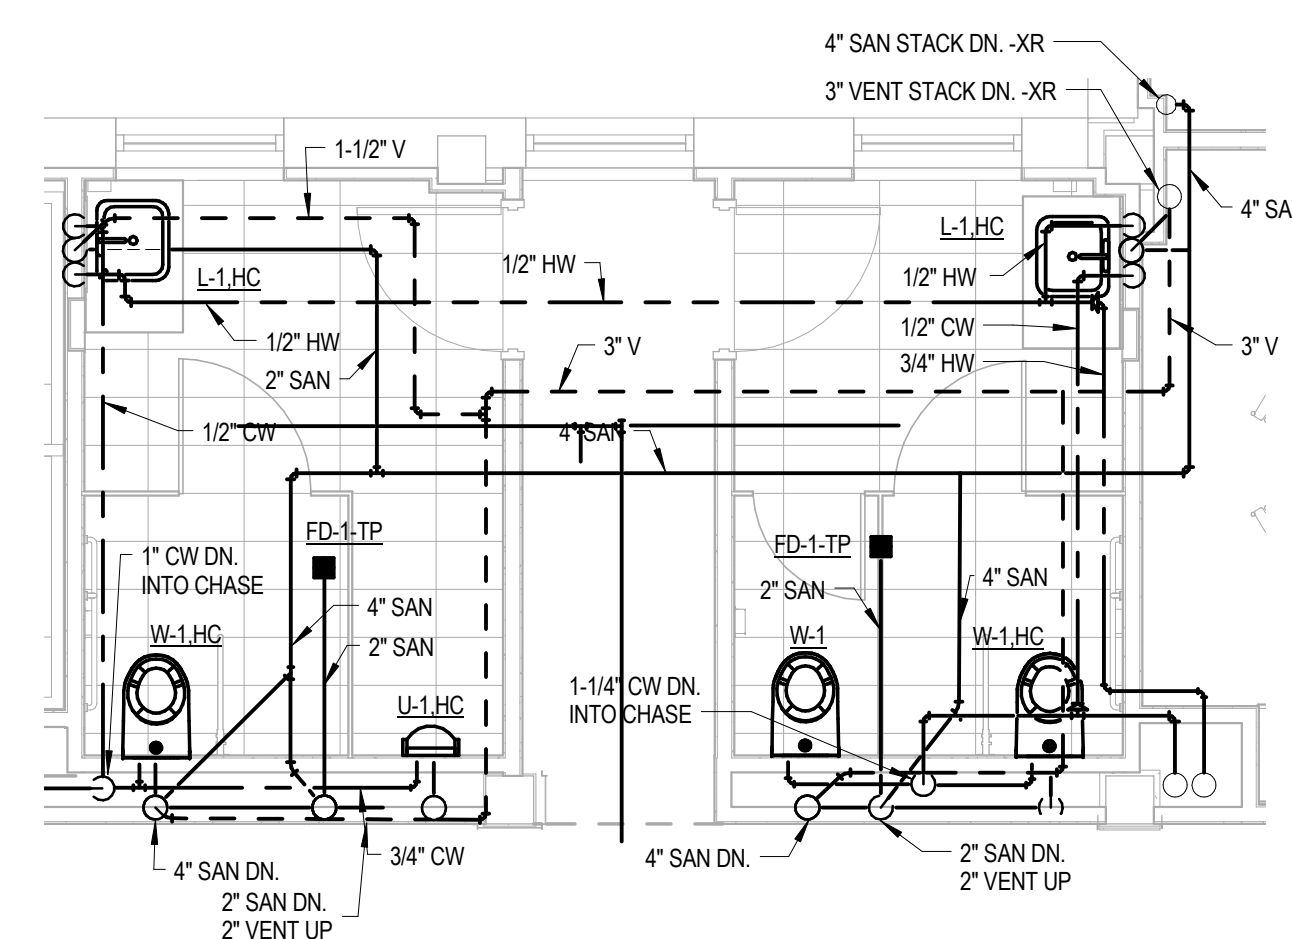


2 ENLARGED TOILET ROOM PLAN
1/4" = 1'-0"

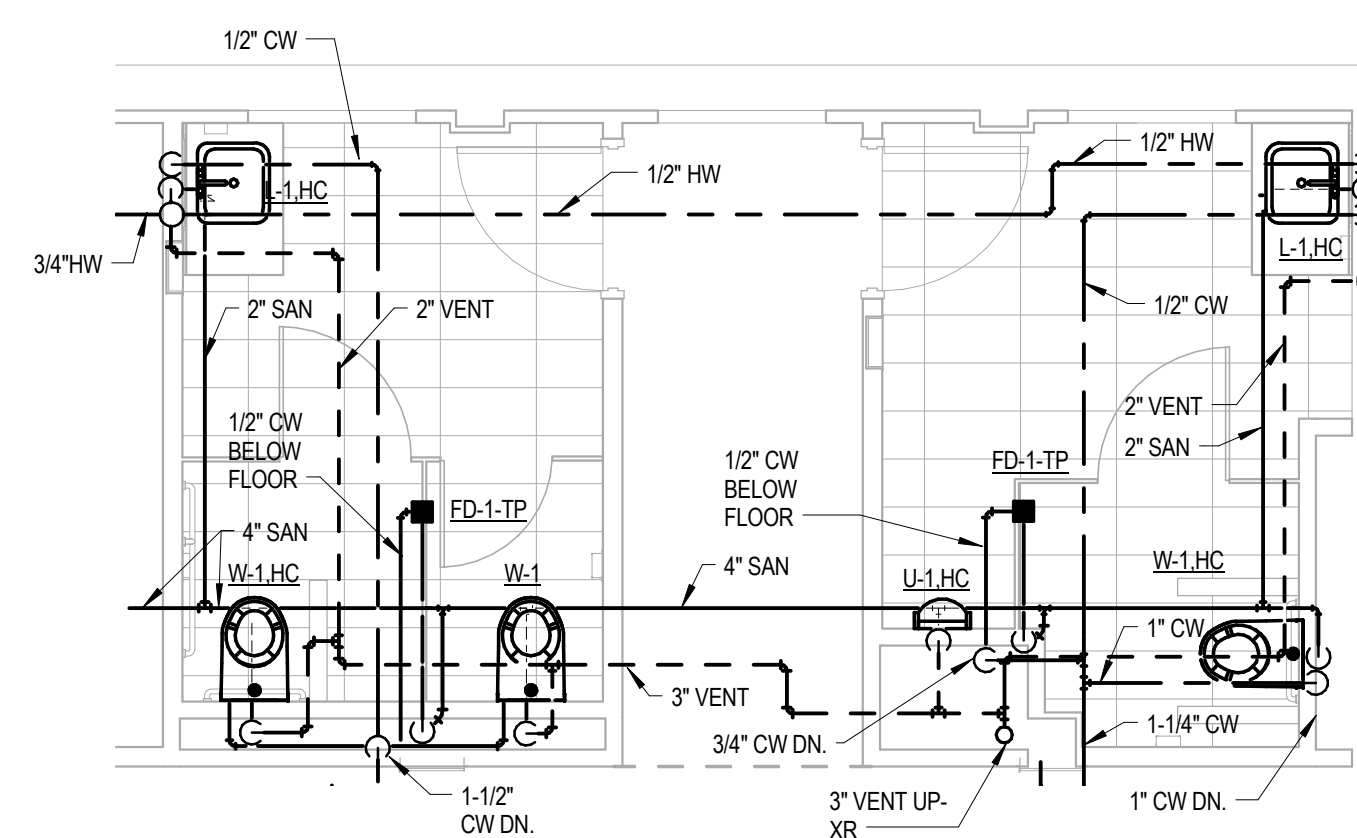

3 ENLARGED TOILET ROOM PLAN
1/4" = 1'-0"

Revisions:	Date

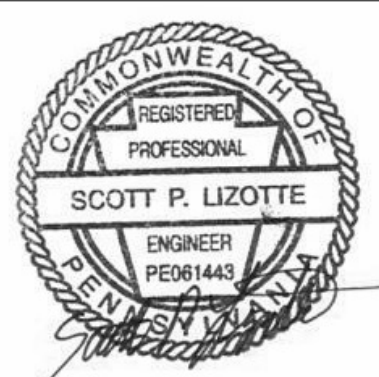CONSULTANTS:**ARCHITECTS/ENGINEERS:**

Drawing Title	ENLARGED PLUMBING PLANS
---------------	-------------------------

Approved: Project Director

Project Title	BUILDING 9 - SECOND FLOOR RENOVATION
---------------	---

Location: 1400 Blackhorse Hill Road
Coatesville, PA 19320

Date
05 / 12 / 14

Checked
MEW

Drawn	MEW
-------	-----

Project Number	542-13-105
Building Number	9

Drawing Number
P201
Dwg. 76 of 125

**Office of
Construction
and Facilities
Management**

