
 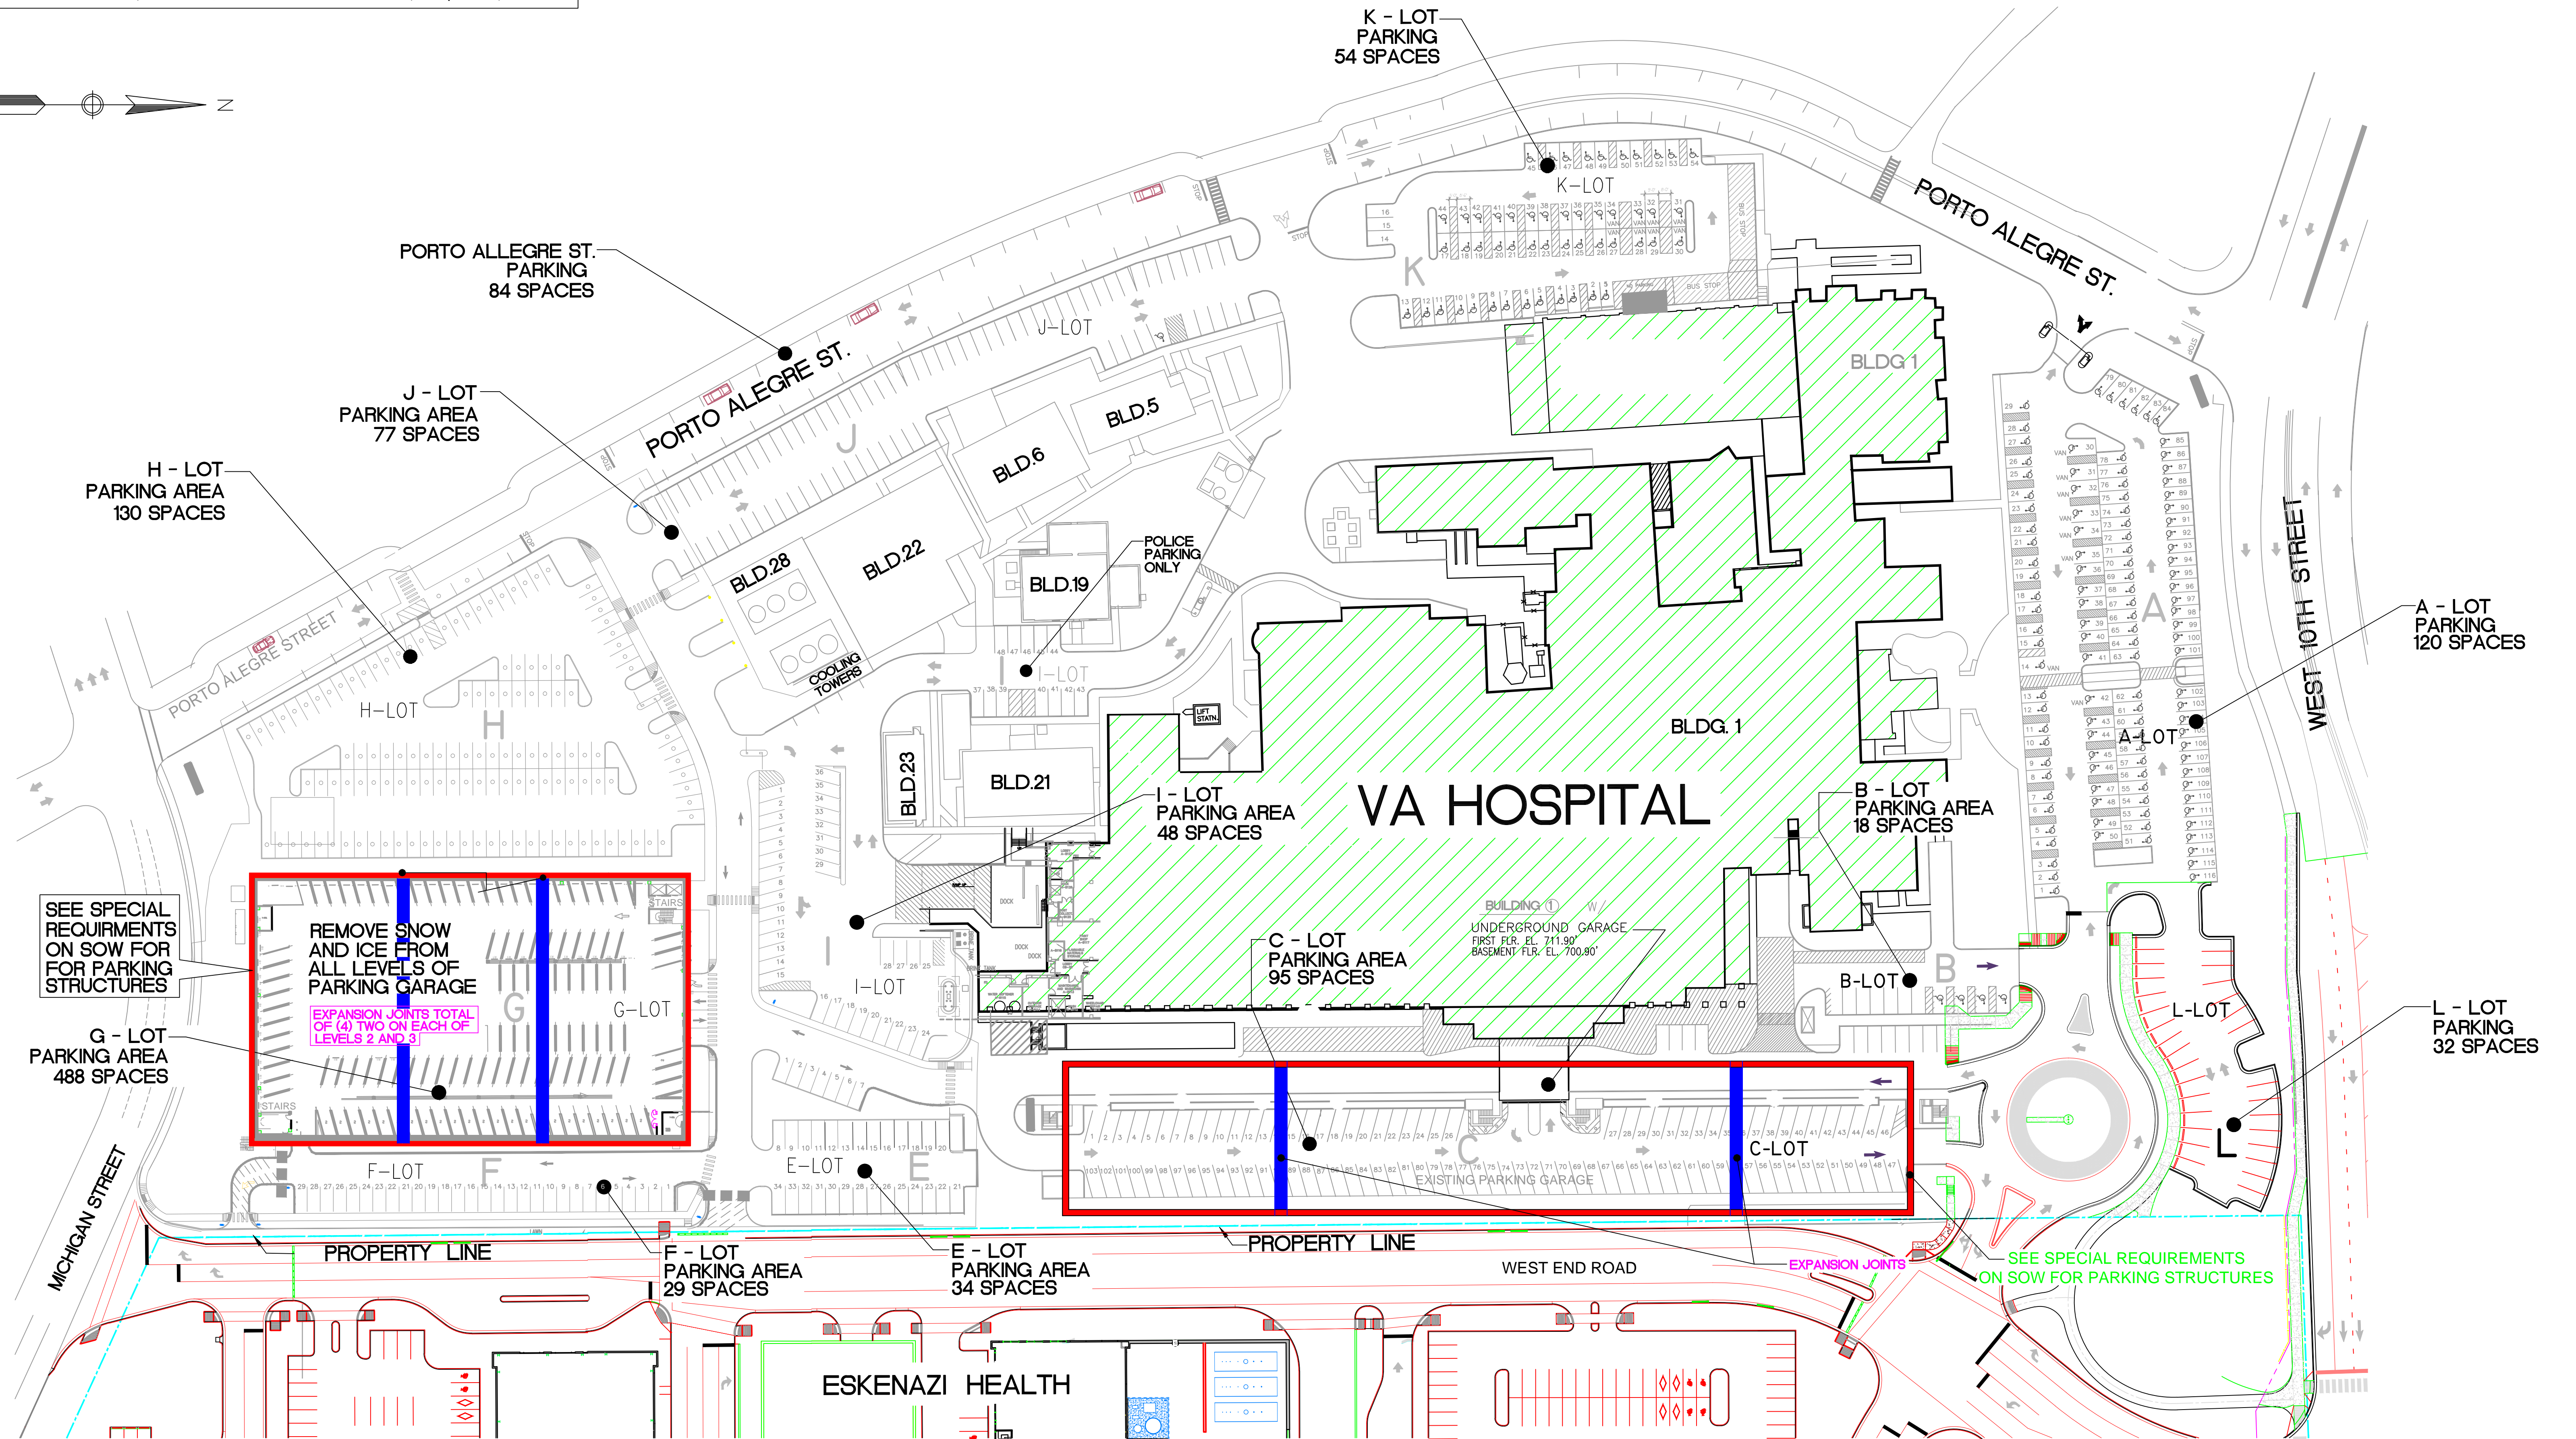


VA MEDICAL CENTER

WTS SNOW AND ICE REMOVAL SPECIAL REQUIREMENT



WTS - SNOW AND ICE REMOVAL AND SPECIAL REQUIREMENTS
SCALE: 1" = 50'

MAY 2014

Revisions	Date	ADDRESS:	NORTH REFERENCE	PROJECT ENGINEERS:	Drawing Title	Project Title	Project Number	Engineering and Facilities Management Services
		Richard L. Roudebush VA Medical Center 1481 W. 10th St. Indianapolis, Indiana 46202			WTS - SNOW AND ICE REMOVAL AND SPECIAL REQUIREMENTS	SNOW REMOVAL SITE PLAN	-	Engineering and Facilities Management Services
					Approved Project Director	Location	Building Number	
						WEST TENTH STREET	WTS	
						Date	Drawing Number	
						05 JUNE 2014	XFY010	
						Checked	Dwg. 1 of 1	
						Drawn		
						A. FERNANDEZ		