




1 **BLDG 7 - BASEMENT - POWER**
SCALE: 1/8"=1'-0"

2 BLDG 7 - FIRST FLOOR - POWER
SCALE: 1/8"=1'-0"

BLDG 6 - BASEMENT - POWER

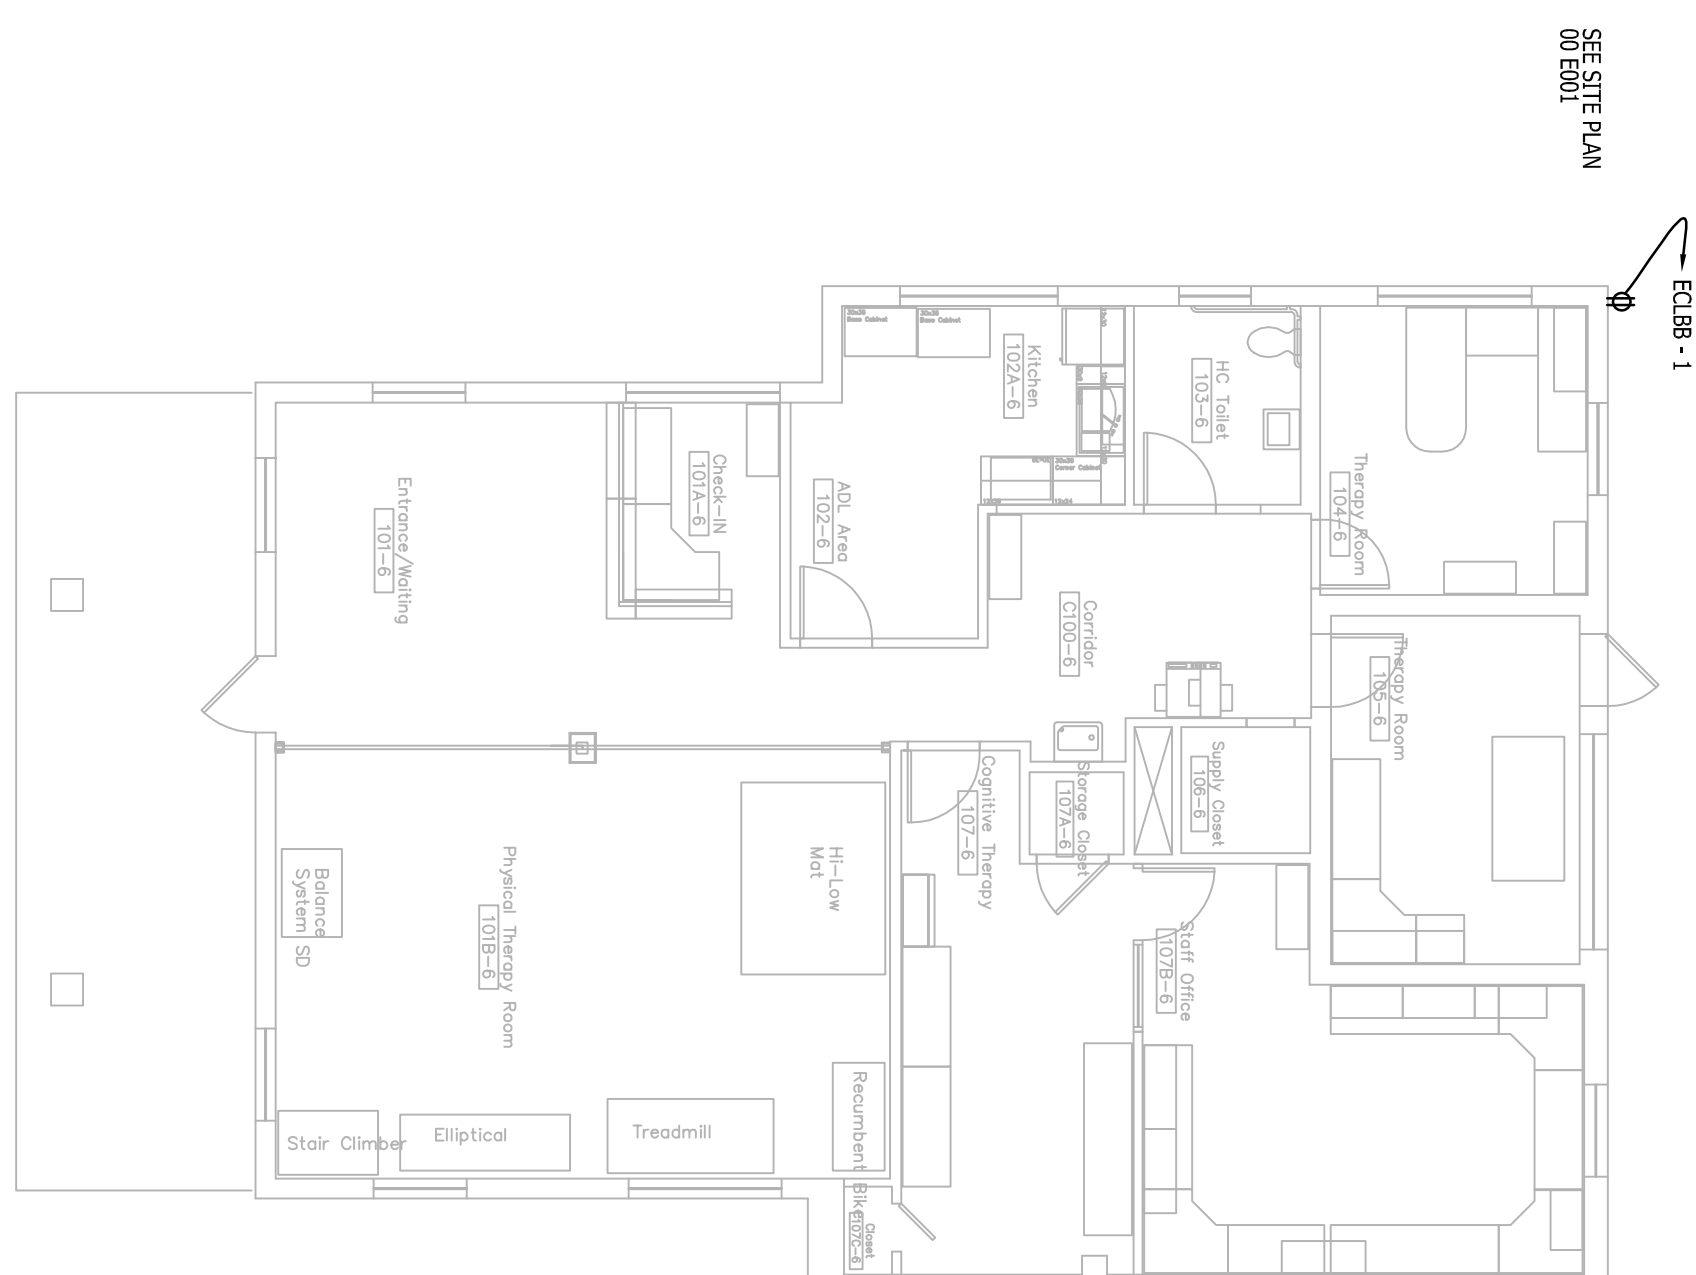

4 BLDG 6 - FIRST FLOOR - POWER
SCALE: 1/8"=1'-0"

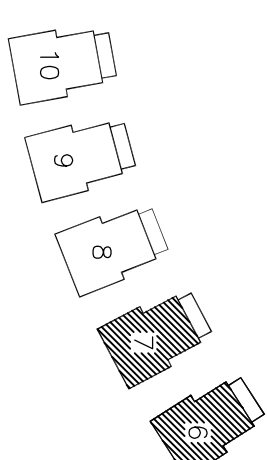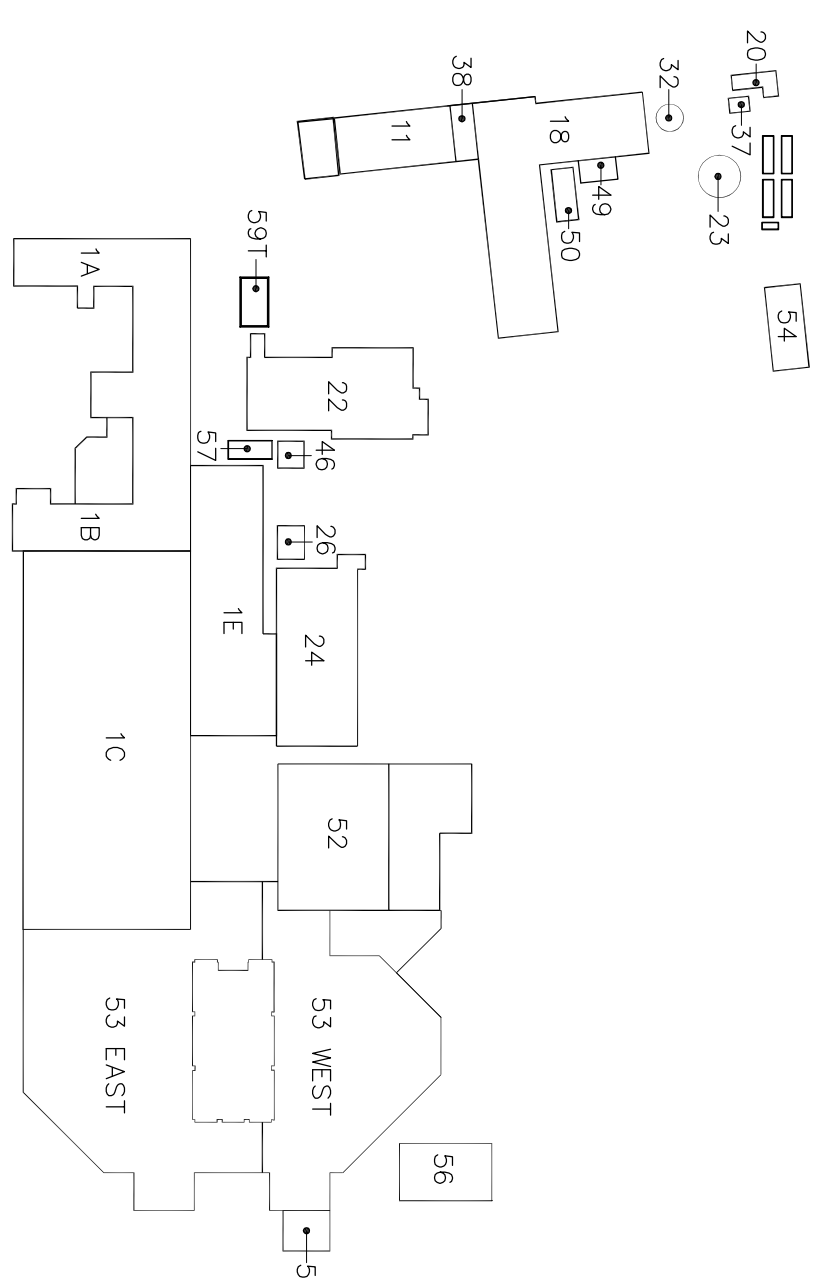

KEY PLAN

[illegible]

CONSULTANTS:



#15 SUMNER DRIVE, SUITE 104
ST. LOUIS, MISSOURI 63143
314.643.1131
FAX: 314.643.1173
www.jpw.com

STRUCTURAL | MECHANICAL | ELECTRICAL
TECHNOLOGY | MEDICAL EQUIPMENT SOLUTIONS

KAPV, P.C.
Missouri State Certificate of Authority #20030888

ARCHITECTS/ENGINEERS:



303rd Engineering Group, Ltd.
A Service Disabled Veterans-Owned Small Business
1935 ARDENAL STREET
ST. LOUIS, MO 63118
PHONE: (314) 664-3382
HTTP://WWW.303ENGINEERING.CO

Dept. of Veterans Affairs
Jack C. Montgomery
Medical Center
1011 Honor Height Drive
Muskogee, Oklahoma 74401

APPROVED: CHIEF VA POLICE
APPROVED:
APPROVED:
APPROVED:

APPRVLEDPresident_A.F.G.E.: 2250
APPRVLEDB
APPRVLEDB
APPRVLEDB

APPROVEDEnergy Engineer
APPROVEDSafety Manager
APPROVEDInfection Control Nurse
APPROVEDIndustrial Hygienist

APPRVE/DeMedical_Center_Director
APPRVE/DAssociate_Director
APPRVE/DChief_of_Staff
APPRVE/DChief_of_Engineering_Service

Drawing Title:	BASEMENT AND FIRST FLOOR PLANS
Scale:	AS SHOWN
Building Number:	6 & 7









Project Title:	
REPLACE SURVEILLANCE SYSTEM	
Approved:	Checked By:
TWC - JCM/VAMC	CKF
Drawn By:	
MMW	
Location: Jack G. Montgomery VA Medical Center - Miskogee, OK	

Date: MM - DD - YY
08 - 23 - 13


Project No.
623.12.105

Drawing No.
06 07 E101

Dwg. 13 of 122

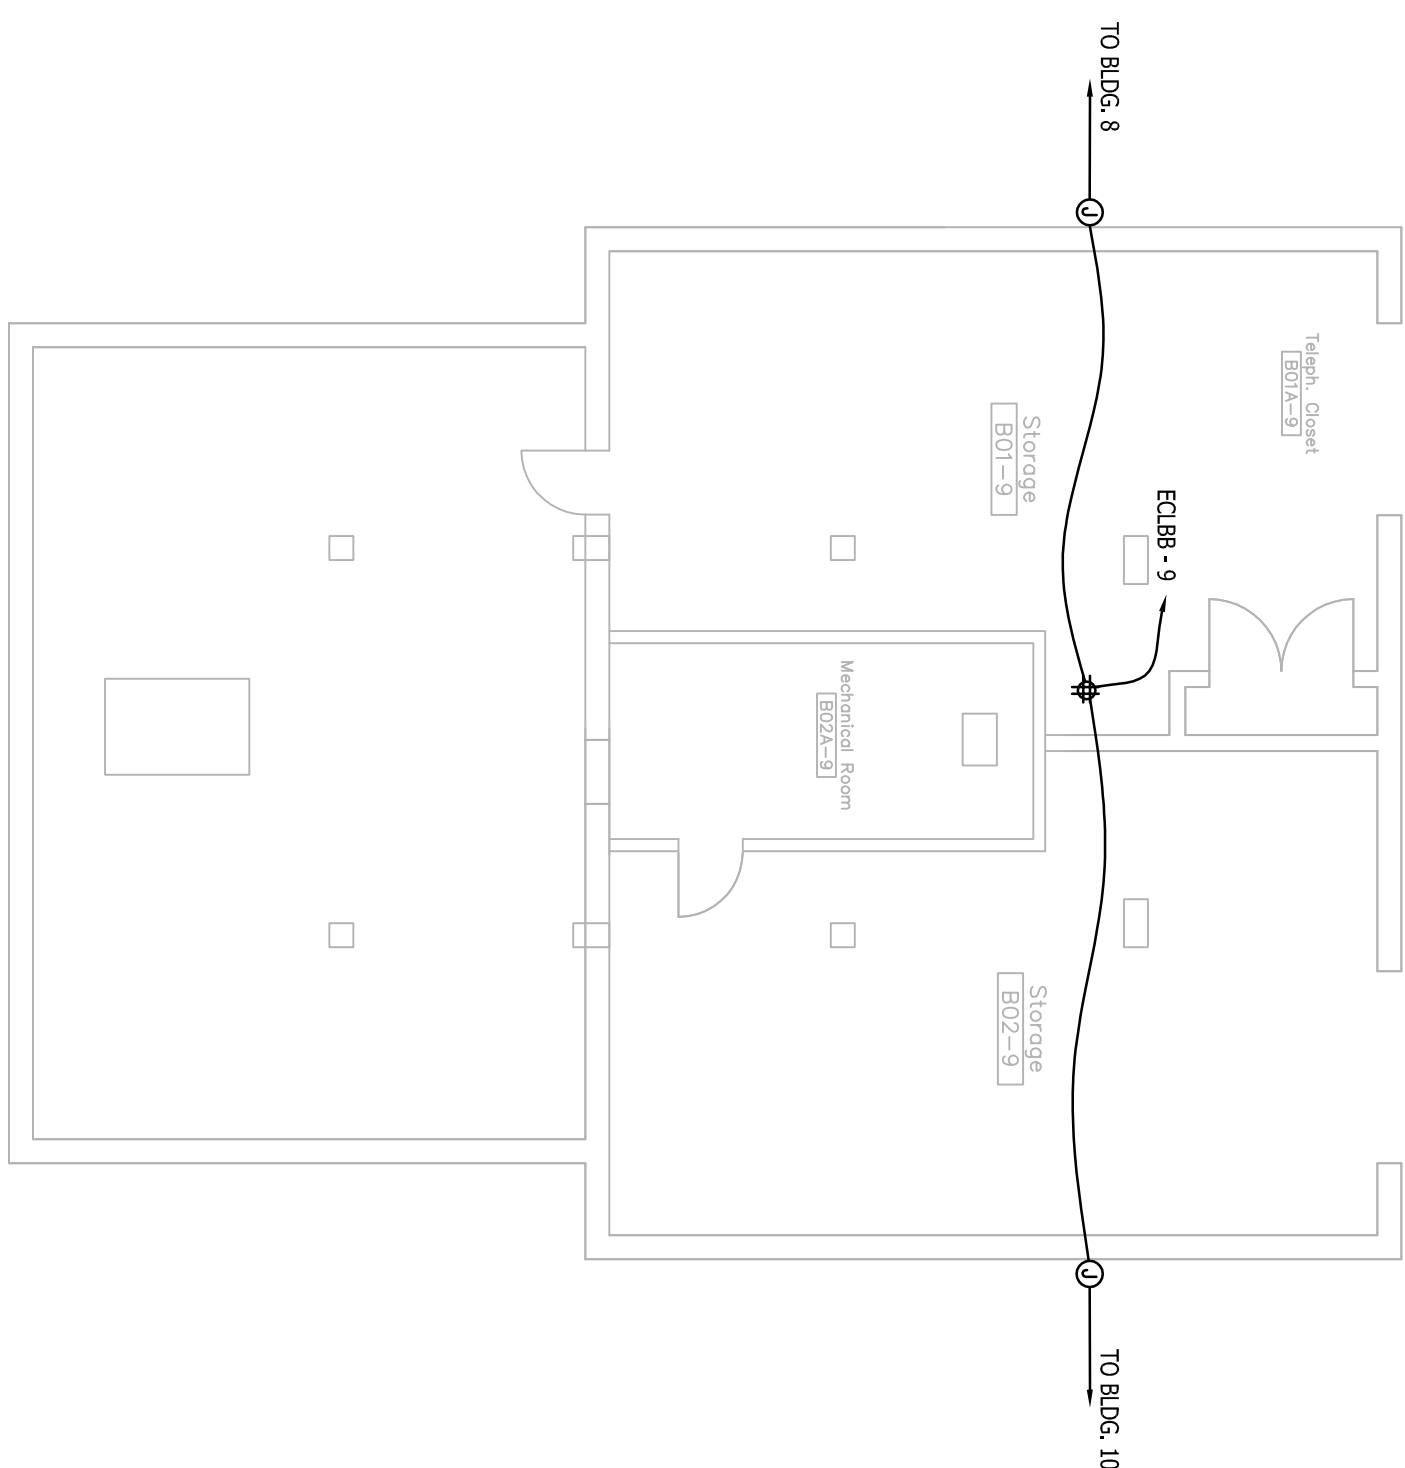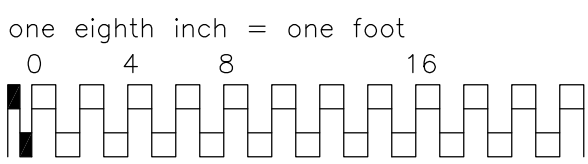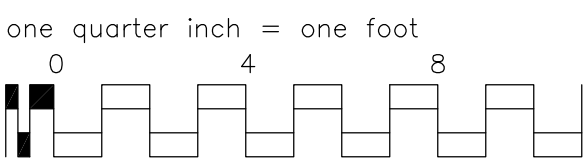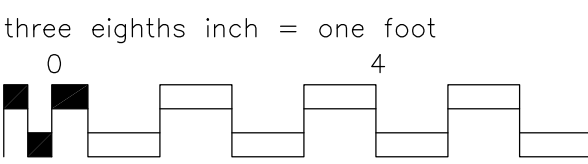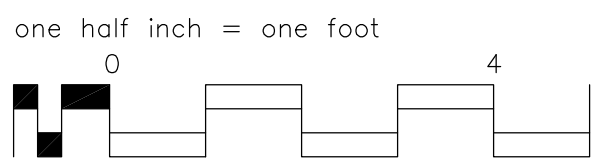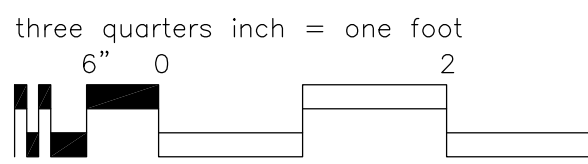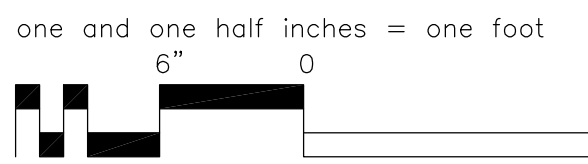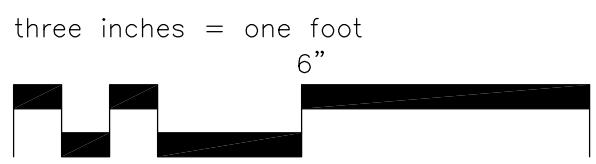



1 **BLDG 9 - BASEMENT - POWER**
SCALE: 1/8"=1'-0"

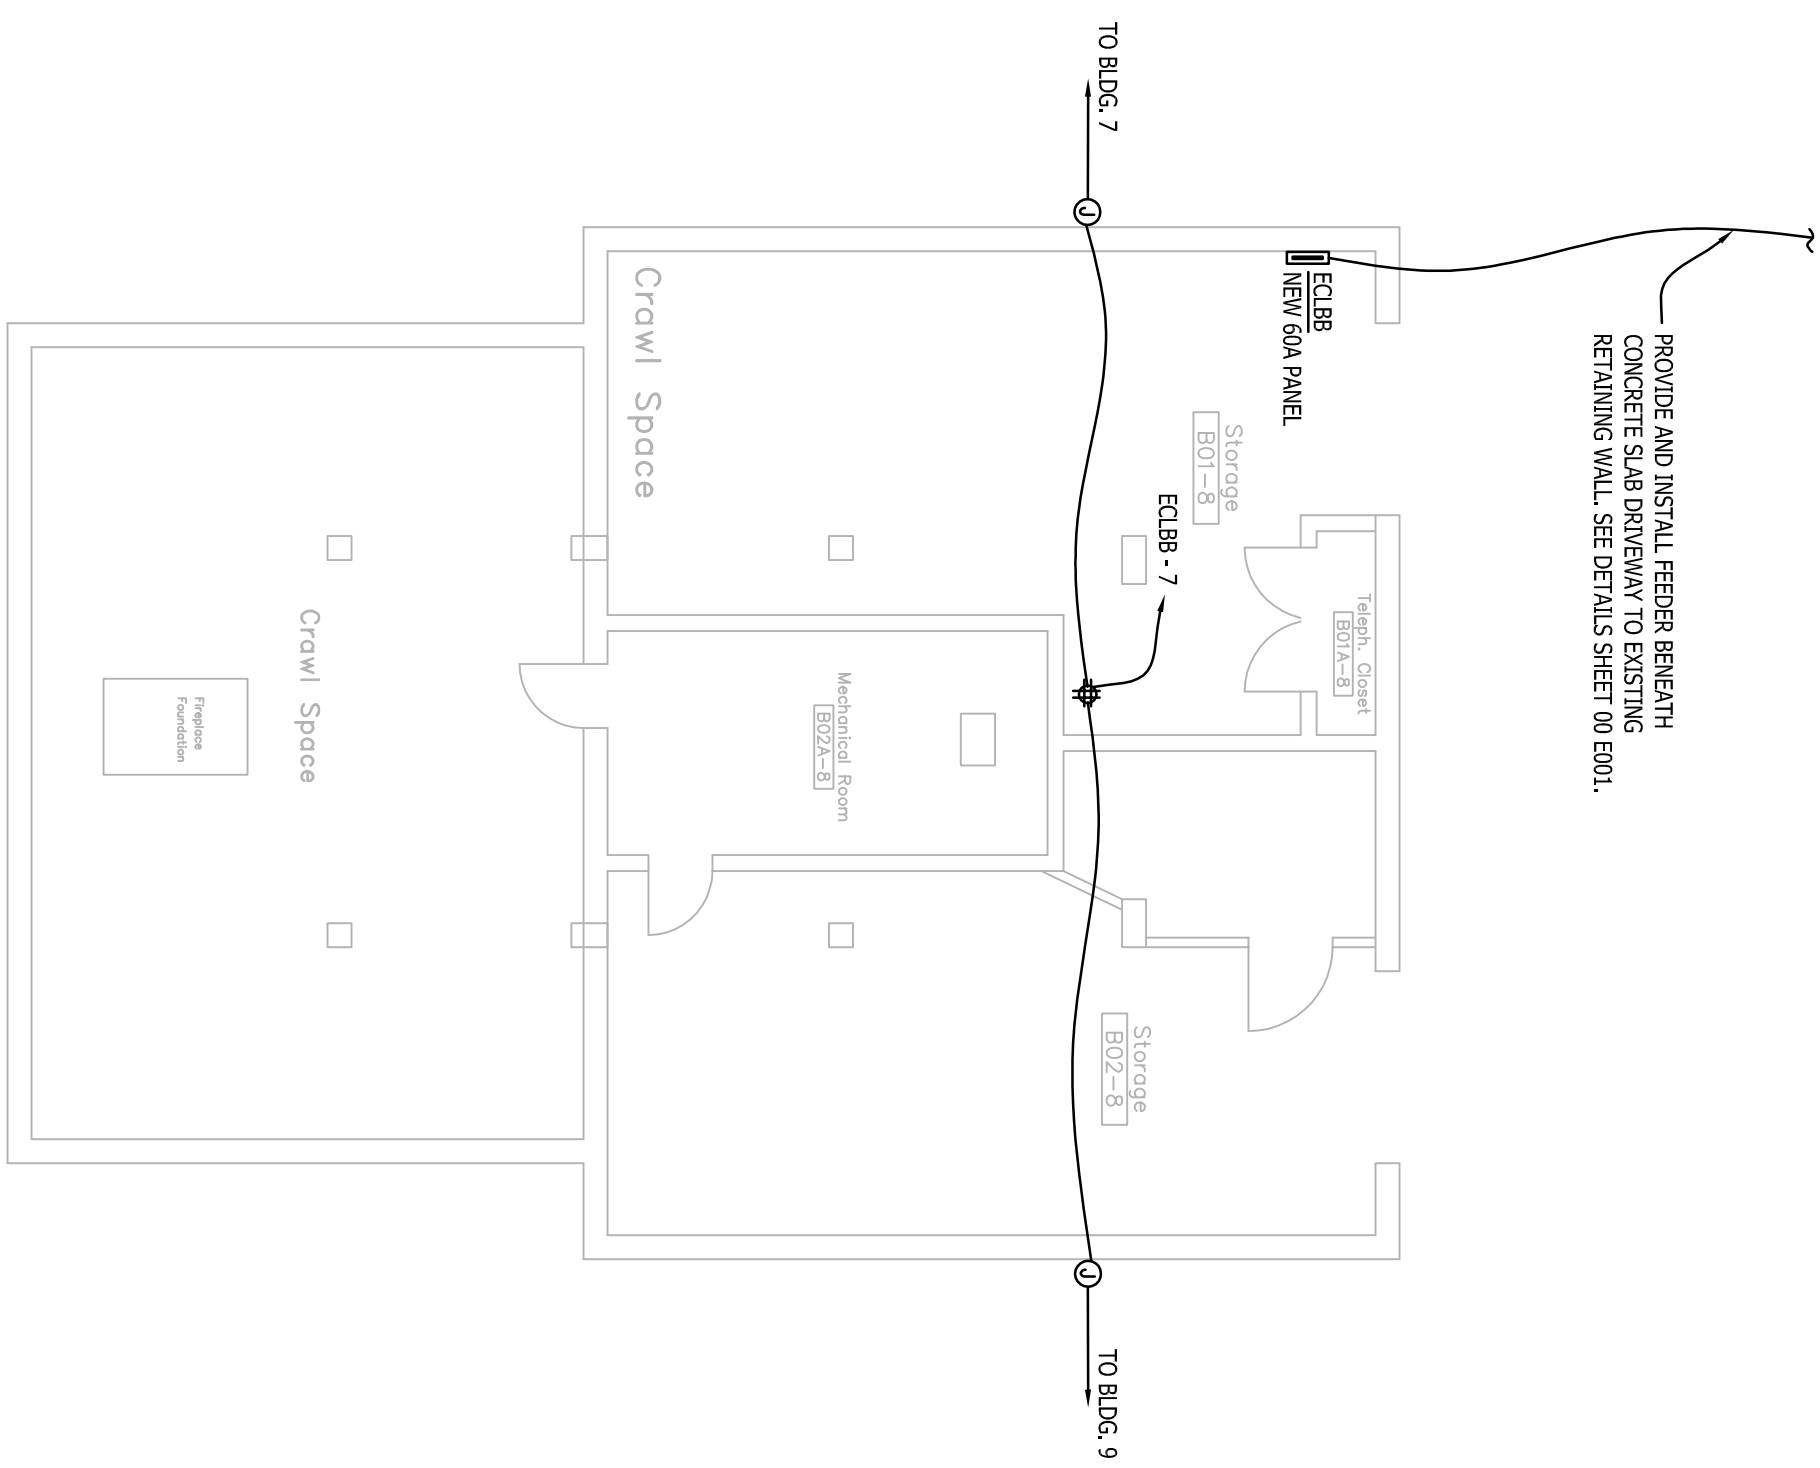

2 BLDG 9 - FIRST FLOOR - POWER
SCALE: 1/8"=1'-0"

2 BLDG 9 - FIRST FLOOR - POWER
SCALE: 1/8"=1'-0"

2 BLDG 9 - FIRST FLOOR - POWER
SCALE: 1/8"=1'-0"

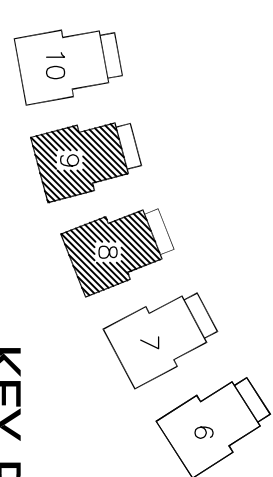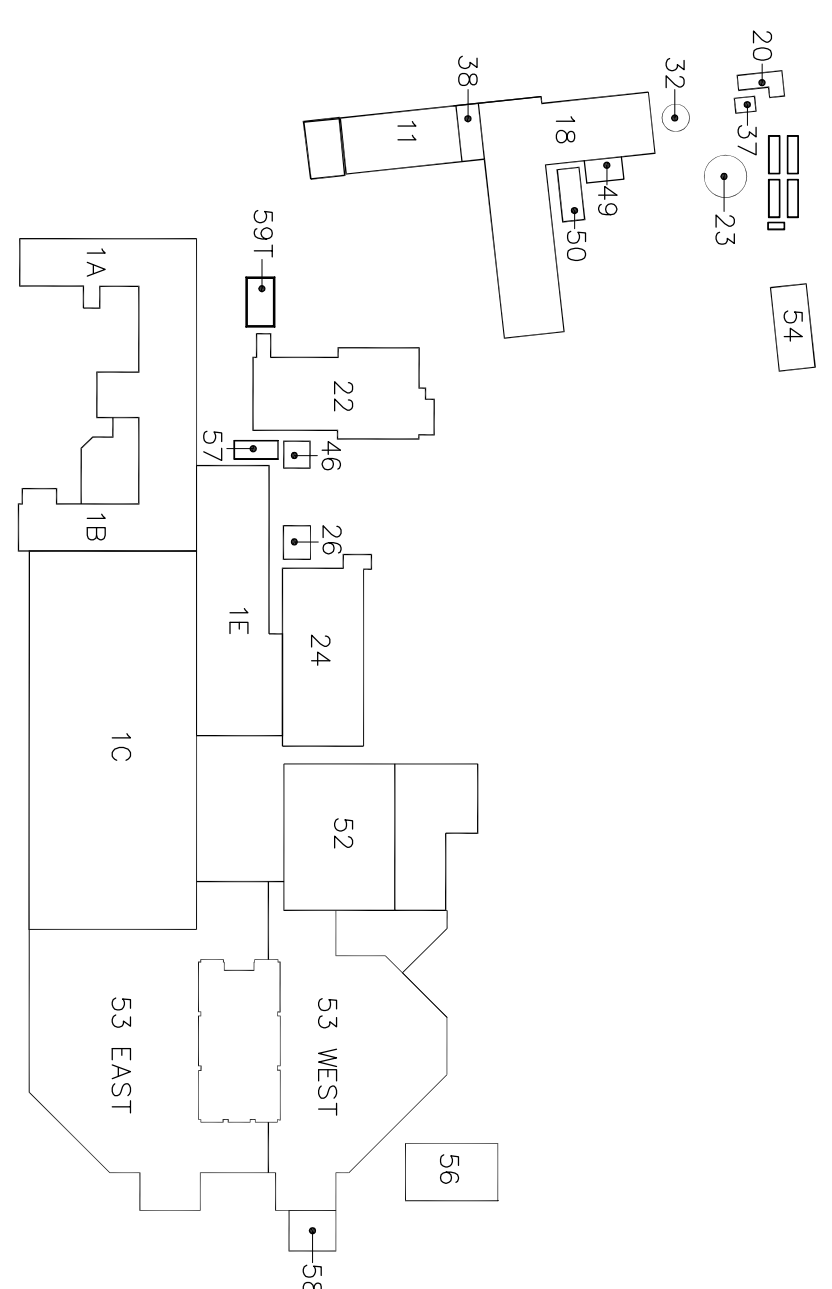[illegible]

CONSULTANTS:

 **ENGINEERING
CONSULTANTS**

Experiencing you can build on.

815 SOUTH MAIN STREET, SUITE 104
ST. LOUIS, MISSOURI 63104
FAX: 314.634.3172
www.kjww.com

**STRUCTURAL | MECHANICAL | ELECTRICAL
| THERMAL | MEDICAL EQUIPMENT SOLUTIONS**

Missouri State Council of Property Appraisers

2007-2008

303rd Engineering Group, LLC
A Service Disabled Veterans-Owned Small Business
975 N. 10th Street, Suite 200
St. Louis, MO 63118
PHONE: (314) 664-5382
FAX: (314) 664-5383
HTTP://WWW.303RDENGRGRP.COM

Dept. of Veterans Affairs
Jack C. Montgomery
Medical Center
1011 Honor Height Drive
Muskogee, Oklahoma 74401

APPROVED: CHIEF VA POLICE
APPROVED:
APPROVED:
APPROVED:

	APPROVEDPresident A.F.G.E. 2250
	APPROVED
	APPROVED
	APPROVED

APPROVED Energy Engineer	
APPROVED Safety Manager	
APPROVED Infection Control	
APPROVED Industrial Hygiene	

	APPROVED/Medical Center I
	APPROVED/Associate Direct
Nurse	APPROVED/Chief of Staff
Att	APPROVED/Chief of Engineer

Drawing Title:	BASEMENT FIRST FLOOR PLANS
Scale:	
Building Number:	AS SHOWN 8 & 9









Project Title:	REPLACE SURVEILLANCE SYSTEM		
Approved:	TWC - JCM/VAMC	Checked By:	CKF
Location:	Jack C. Montgomery VA Medical Center - Muskogee, OK		
		Drawn By:	WMW

Date: MM - DD - YY
08 - 23 - 13

Project No.
623.12.105

Drawing No.
08 09 E101

Dwg. 14 of 122

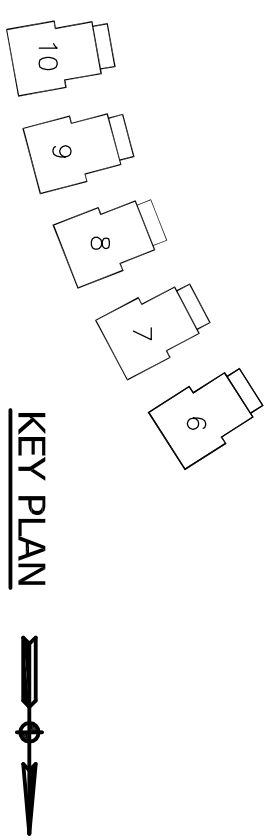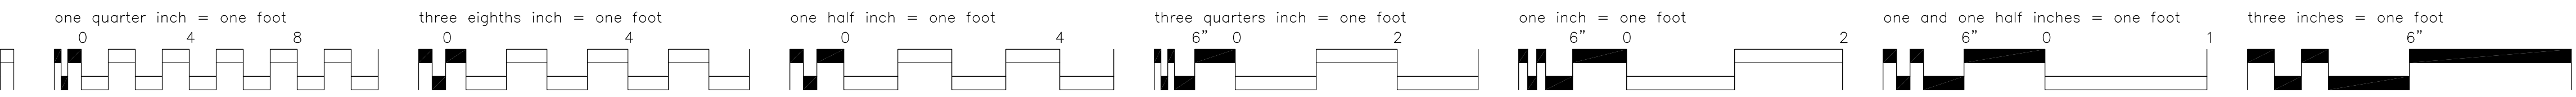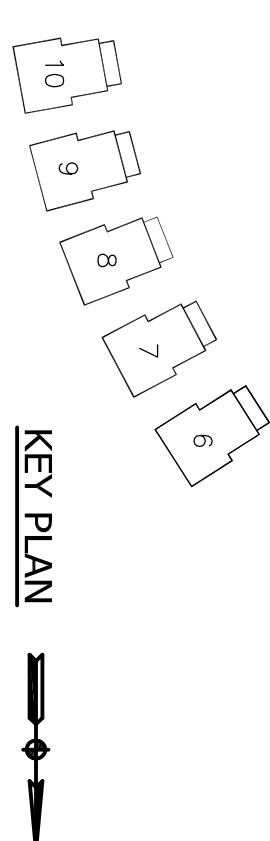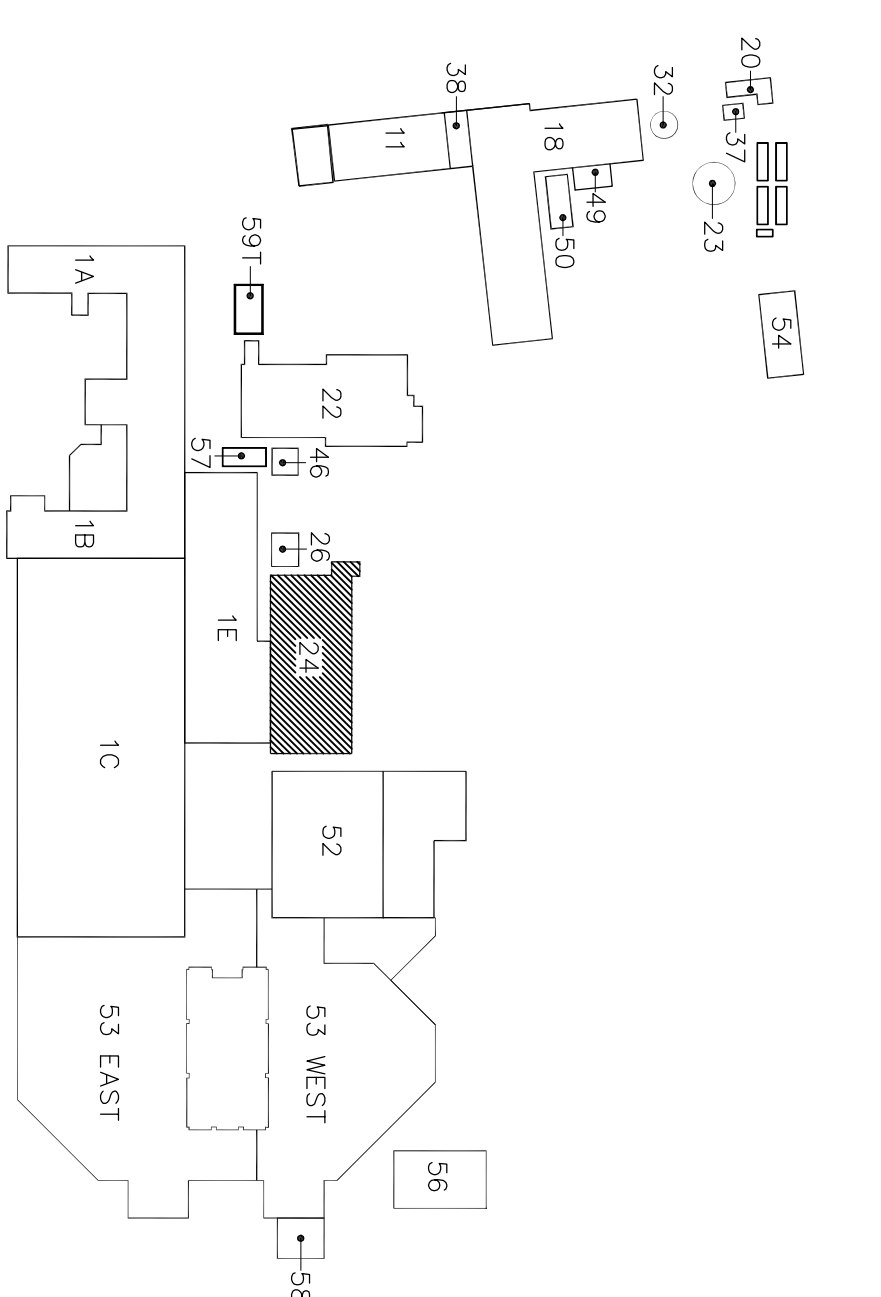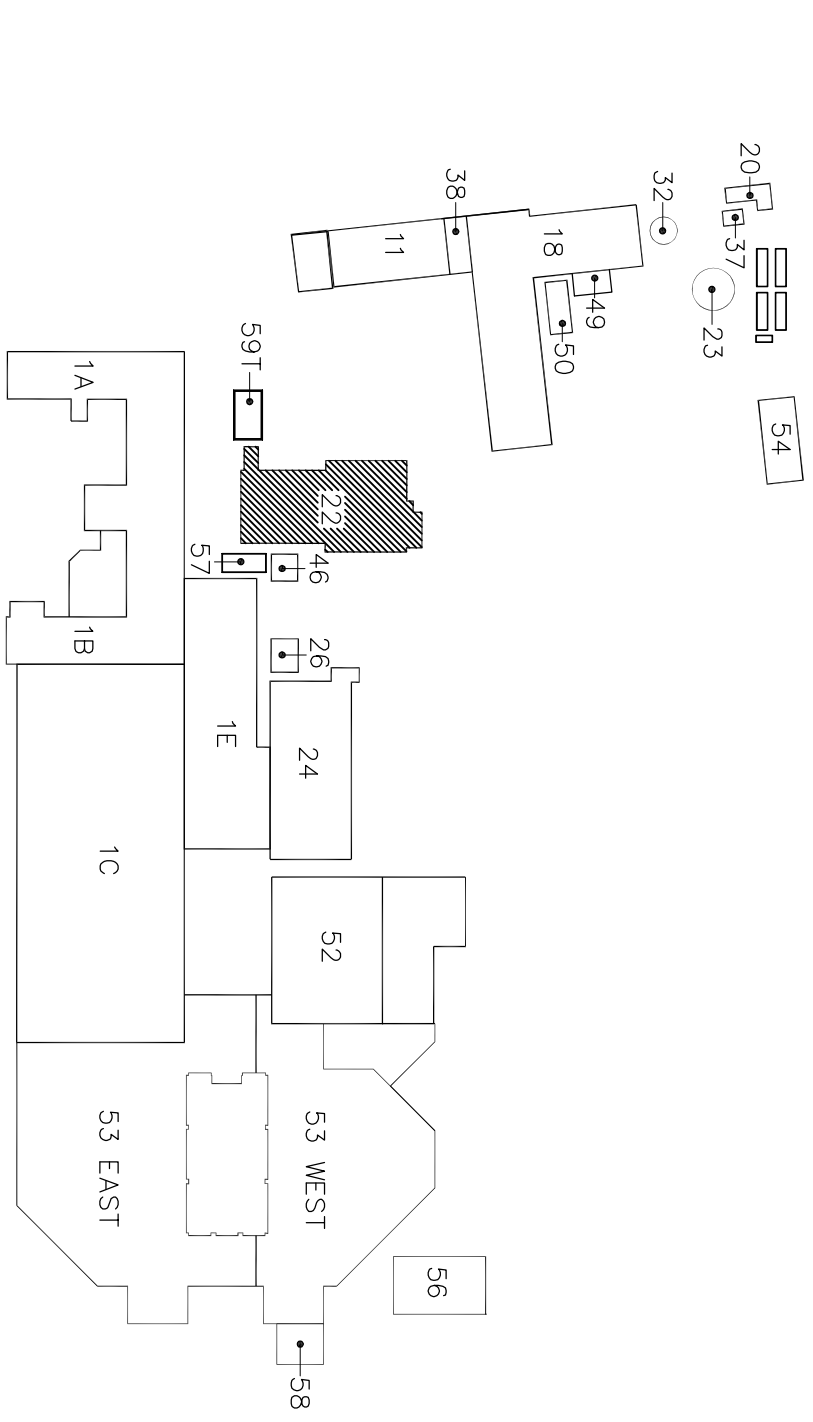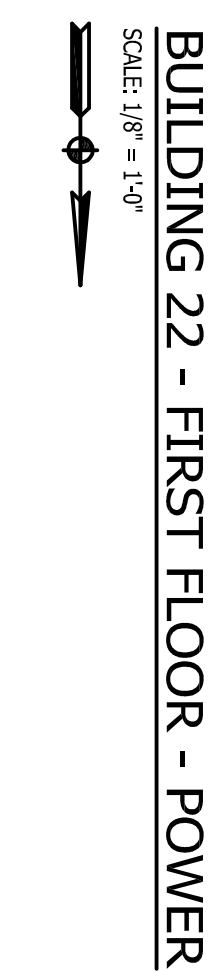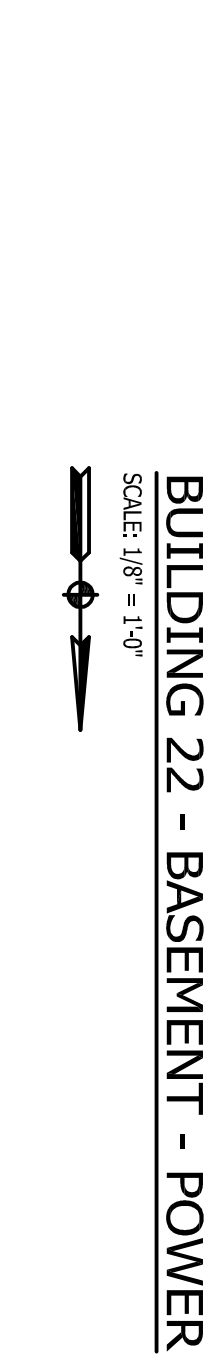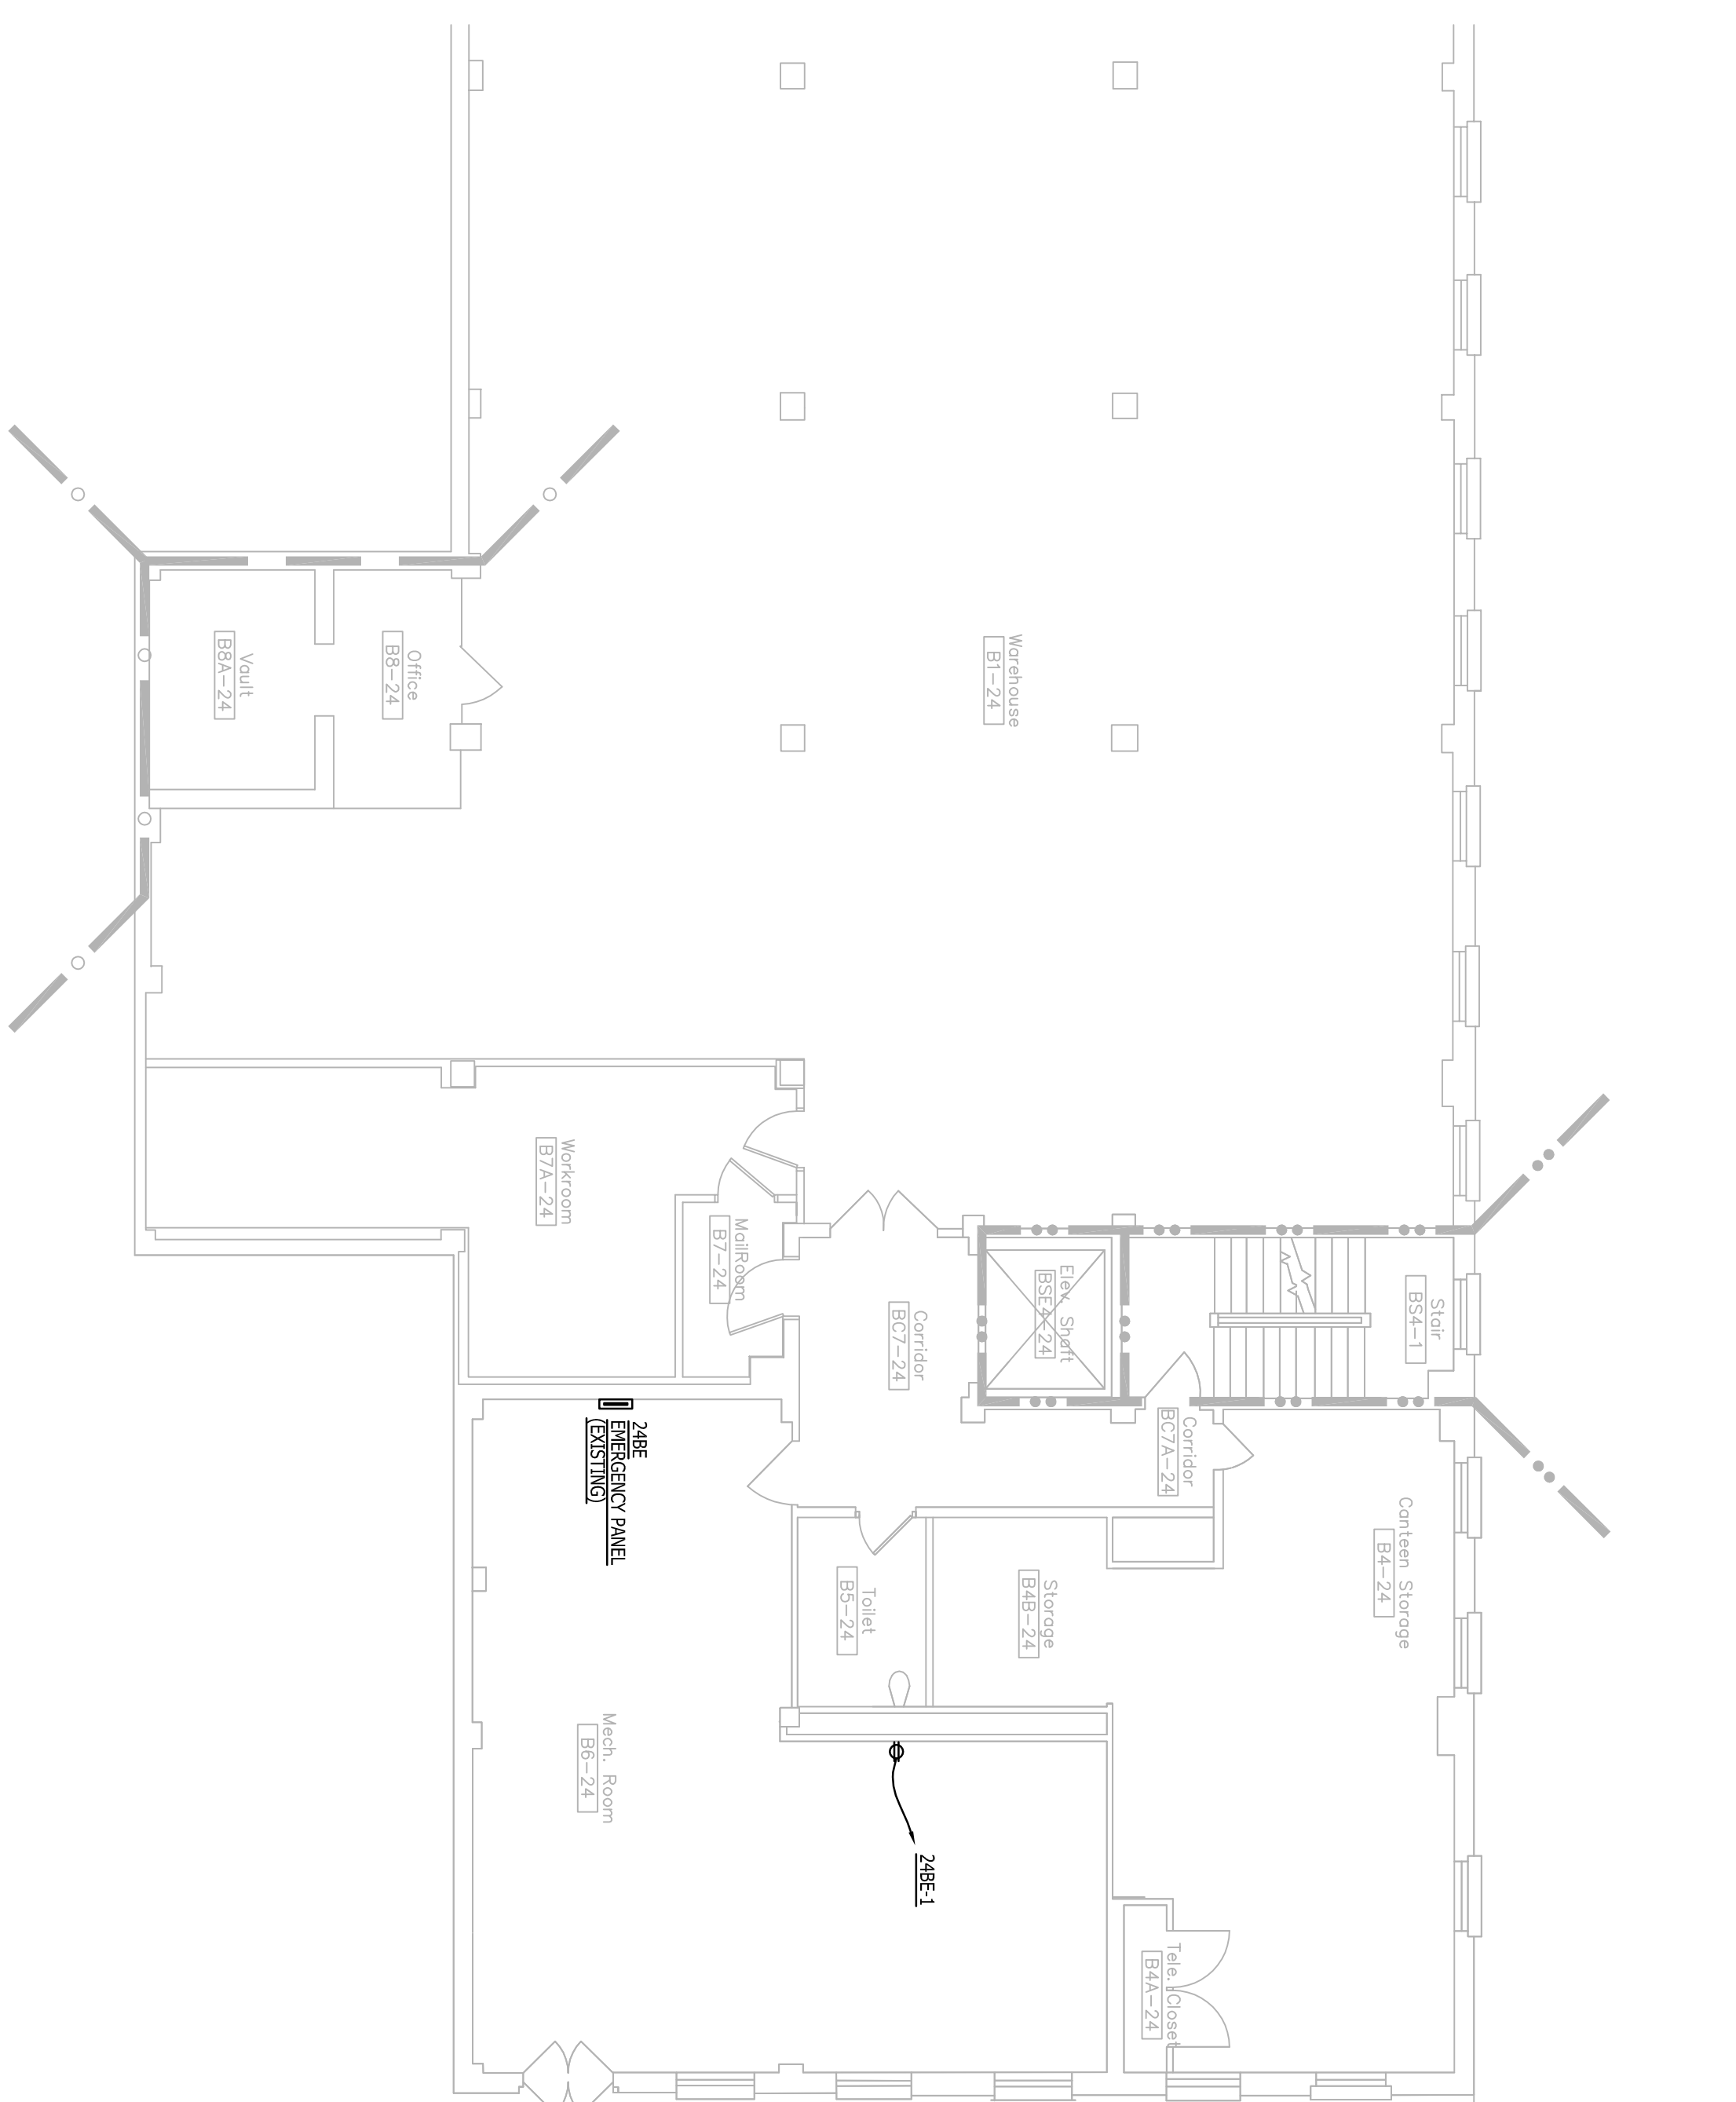
[illegible]

KEY PLAN

CONSULTANTS:

CONSULTANTS:

ARCHITECTS/ENGINEERS



303rd Engineering Group, LLC

A Service Disabled Veteran-Owned Small Business
10000 Highway 100, Suite 100
B-17, Houston, TX 77036
713-461-3030
H1P@303ENG.COM 303RNGRUP@303ENG.COM

ENGINEERING CONSULTANTS

303 ENGINEERING CONSULTANTS
10000 Highway 100, Suite 100
B-17, Houston, TX 77036
713-461-3030
H1P@303ENG.COM 303RNGRUP@303ENG.COM

2004-2005
2004-2005

Dept. of Veterans Affairs
Jack C. Montgomery
Medical Center
1011 Honor Height Drive
Muskogee, Oklahoma 74401

APPROVED CHIEF VA POLICE
APPROVED
APPROVED
APPROVED

APPROVEDPresident A.F.G.E. 2250
APPROVED
APPROVED
APPROVED

APPROVEDEnergy Engineer
APPROVEDSafety Manager
APPROVEDInfection Control Nurse
APPROVEDIndustrial Hygienist

APPROVED Medical Center Director
APPROVED Associate Director
APPROVED Chief of Staff
APPROVED Chief of Engineering Service

Drawing Title:	BLDG 22 & 24 BASEMENT POWER
Scale:	AS SHOWN
Building Number:	22 & 59T

Project Title:	REPLACE SURVEILLANCE SYSTEM		
Approved:	TWC - JCNVAMC	Checked By:	CKF
Location:	Jack C. Montgomery VA Medical Center - Muskogee, OK		
		Drawn By:	WMM

Date: MM - DD - YY
08 - 23 - 13

Project No.
623.12.105

Drawing No.
2224E101

Dwg. 17 of 122