




one eighth inch = one foot  
0 4 8 16  
one quarter inch = one foot  
0 4 8  
three eighths inch = one foot  
0 4 8  
one half inch = one foot  
0 4 8  
three quarters inch = one foot  
0 4 8  
one inch = one foot  
0 6 12  
one and one half inches = one foot  
0 6 12  
three inches = one foot  
0 6 12

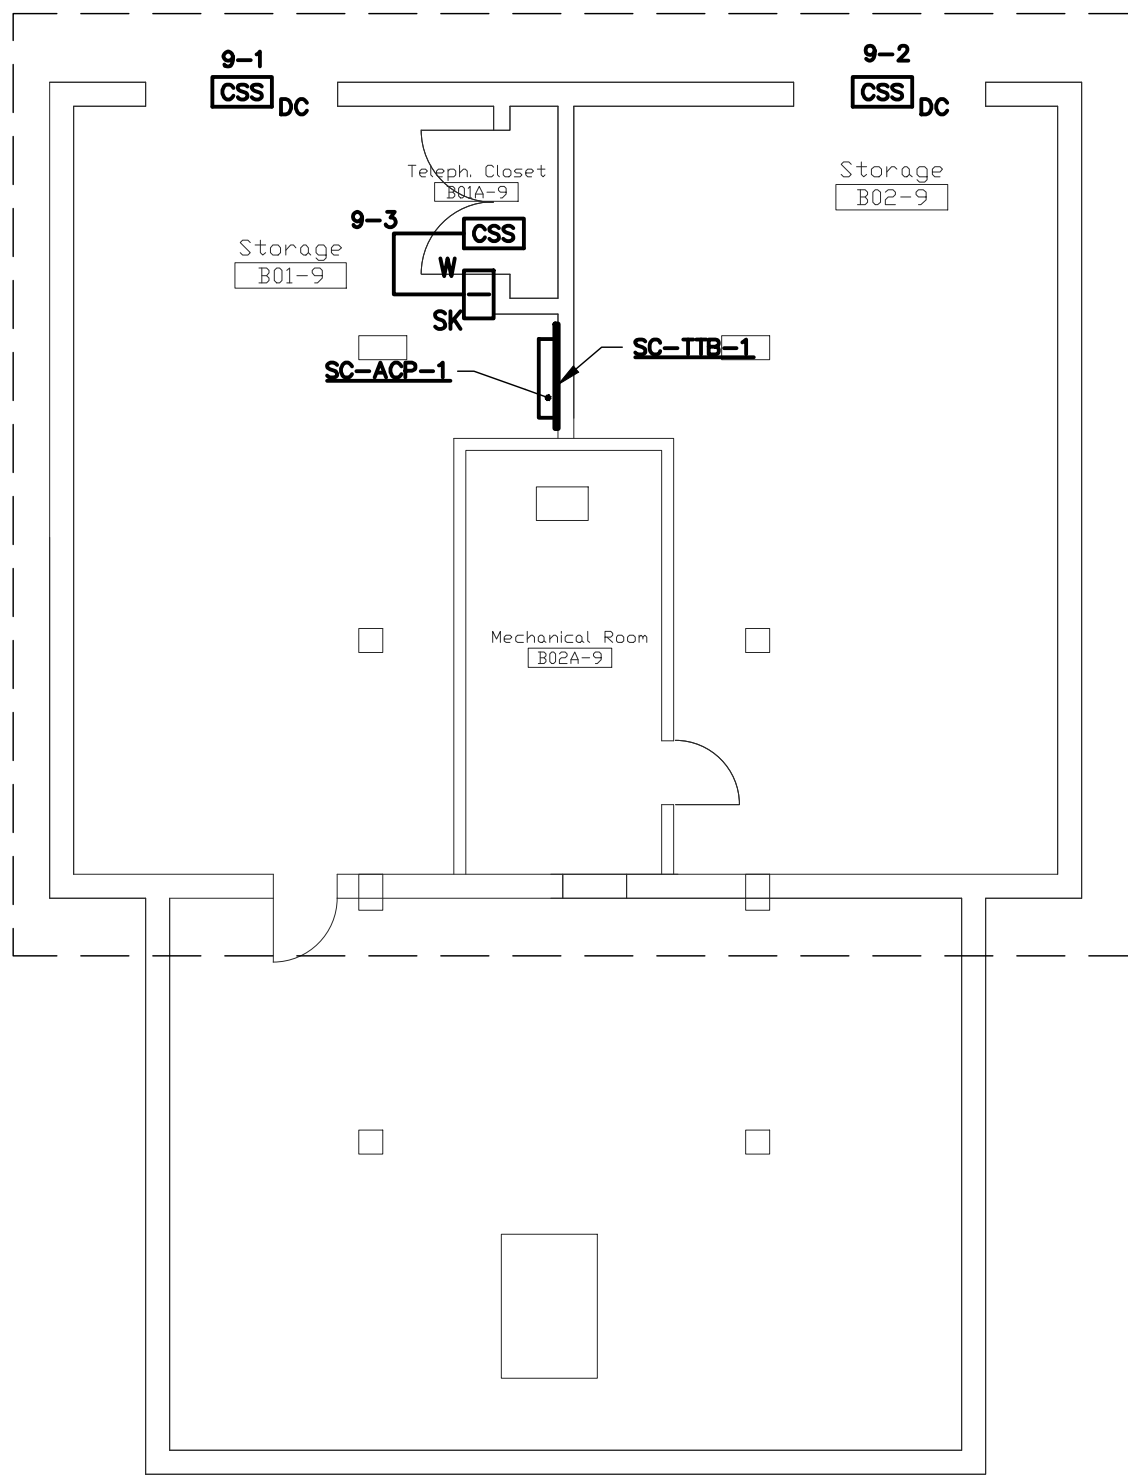


**BLDG 9 - BASEMENT - SECURITY**  
SCALE: 1/8"=1'-0"

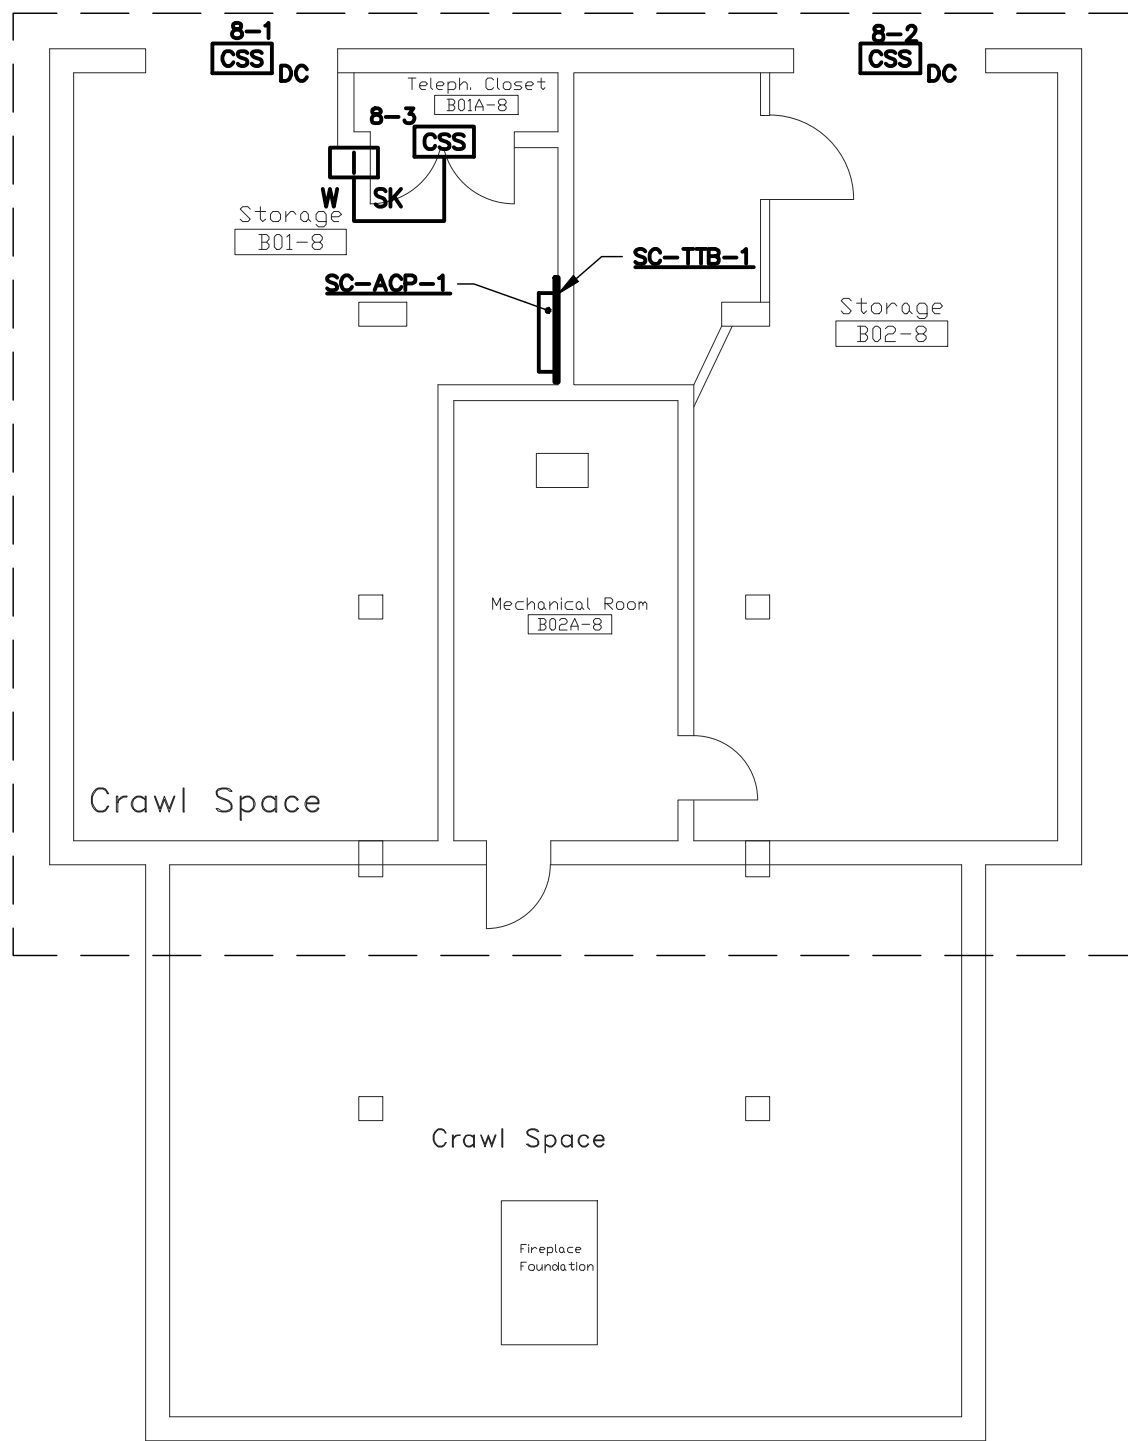


**BLDG 8 - BASEMENT - SECURITY**  
SCALE: 1/8"=1'-0"

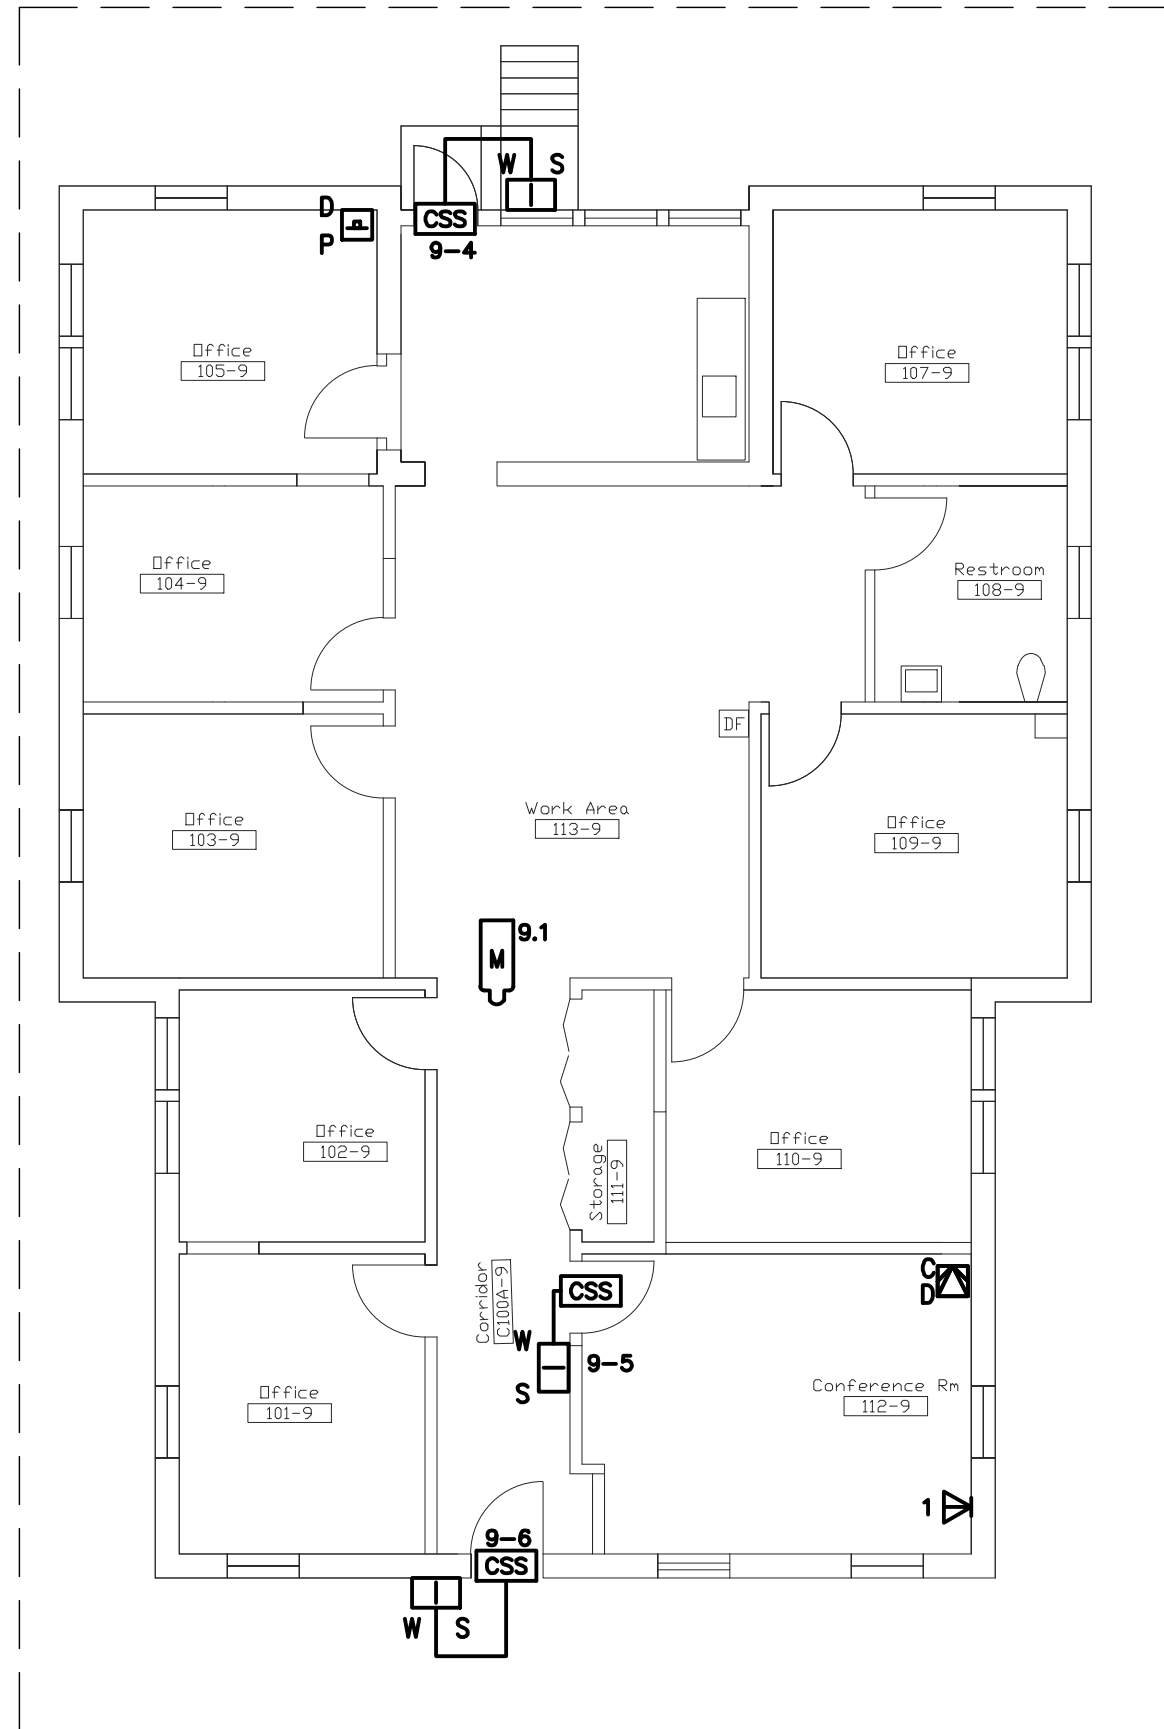

**BLDG 9 - FIRST FLOOR - SECURITY**  
SCALE: 1/8"=1'-0"

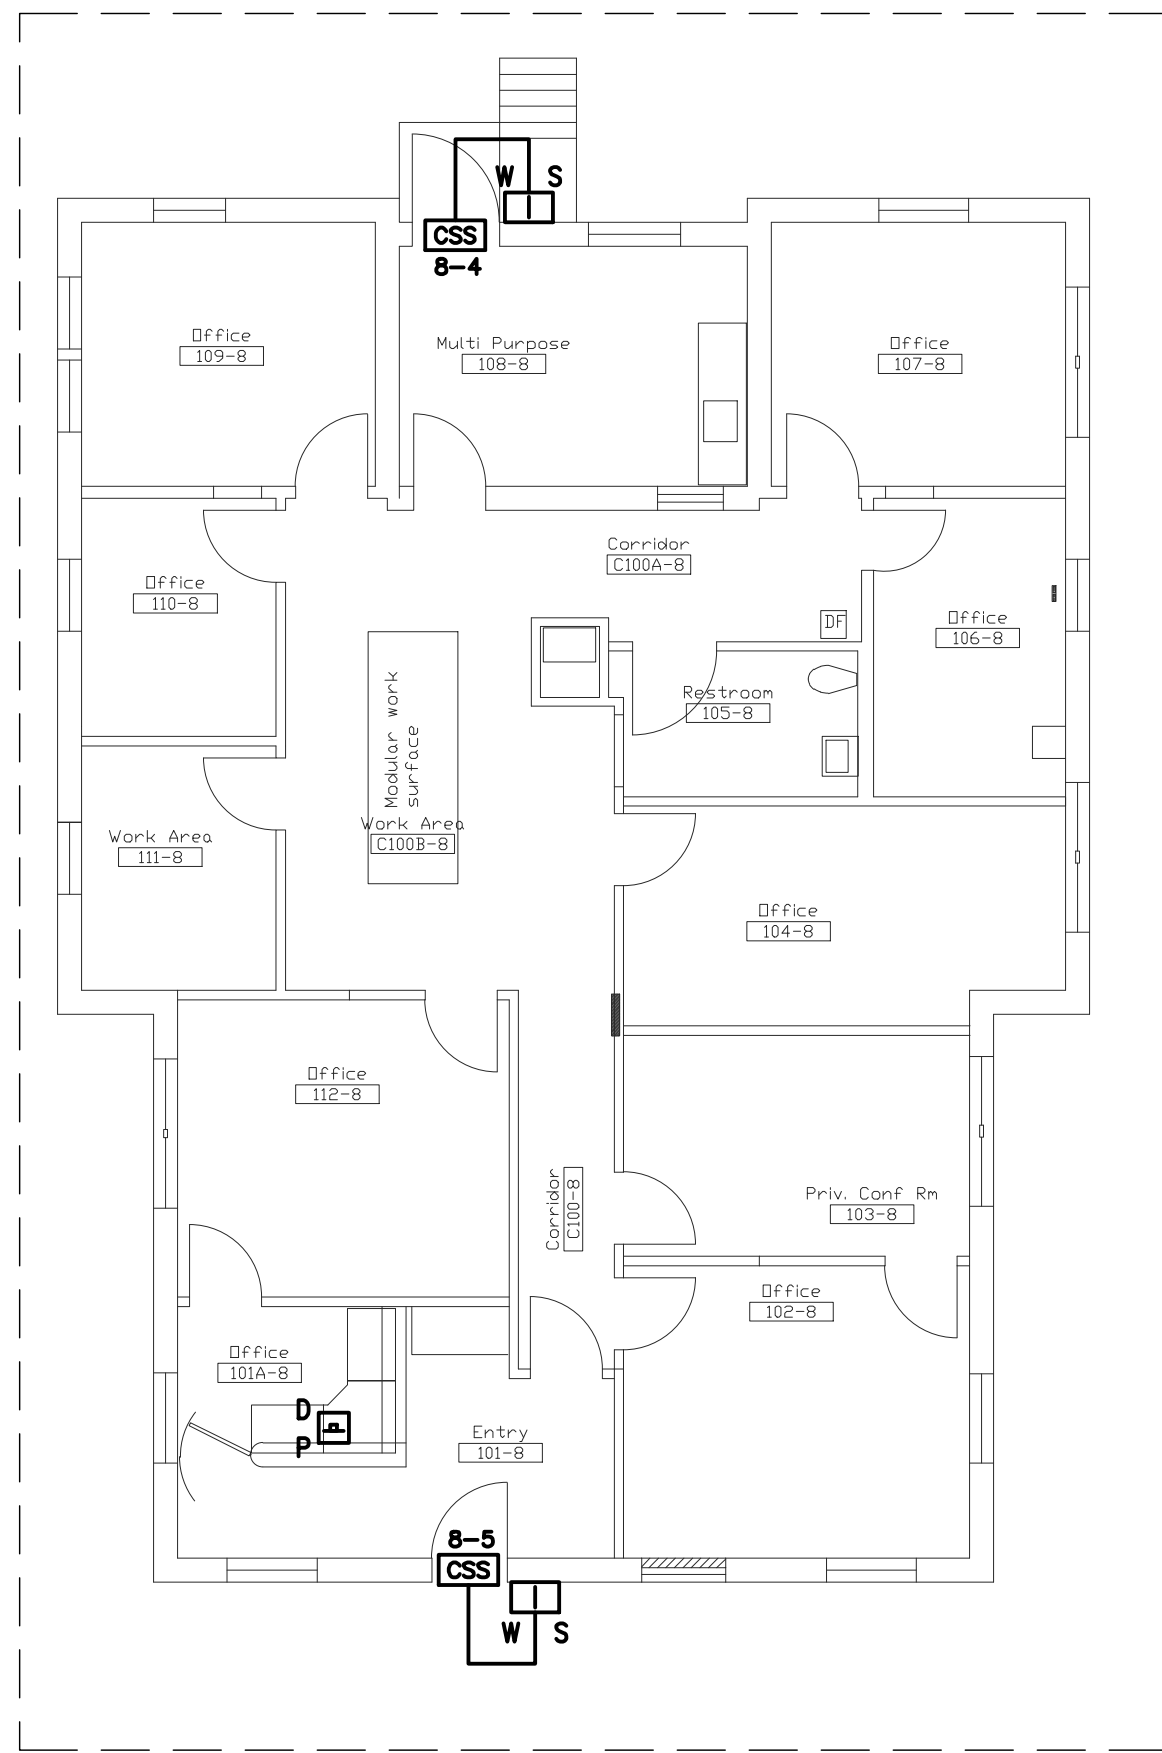



**BLDG 8 - FIRST FLOOR - SECURITY**  
SCALE: 1/8"=1'-0"

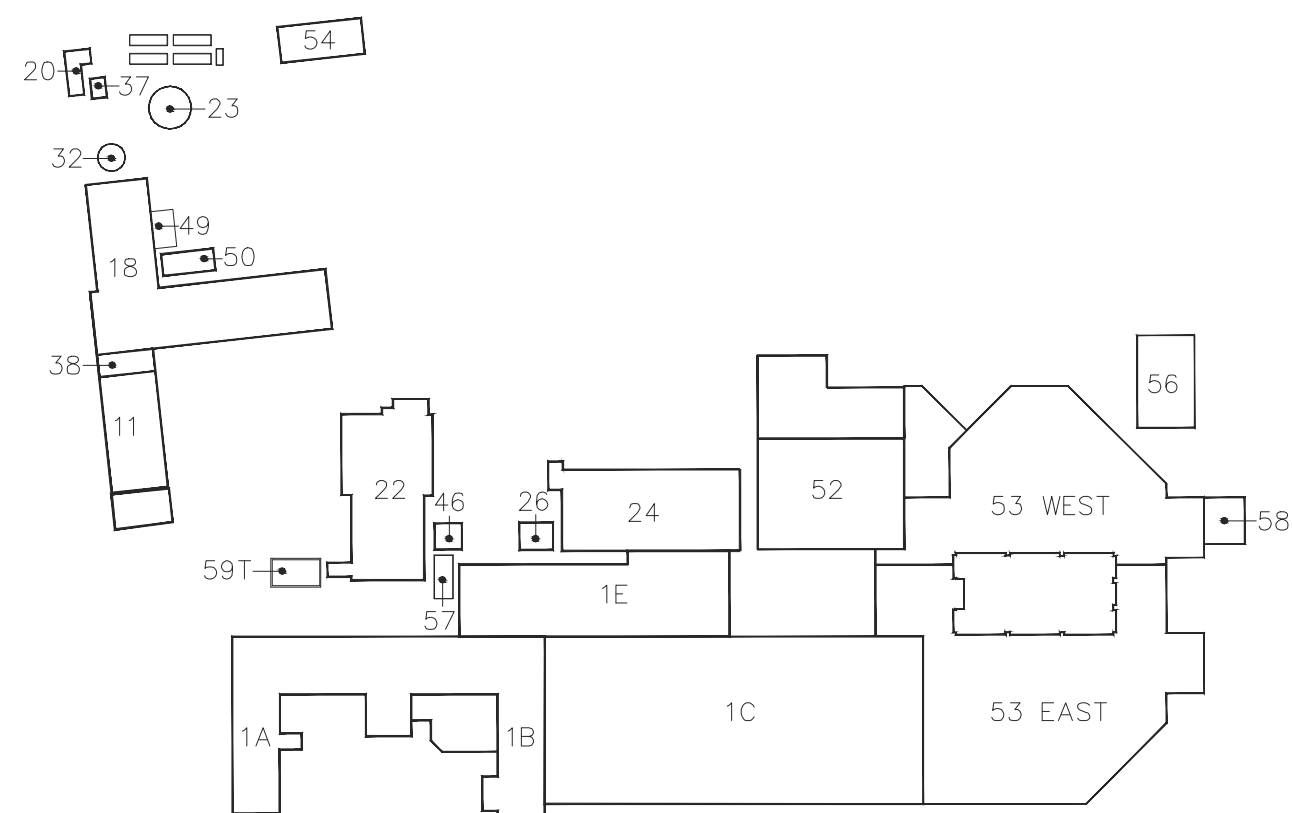





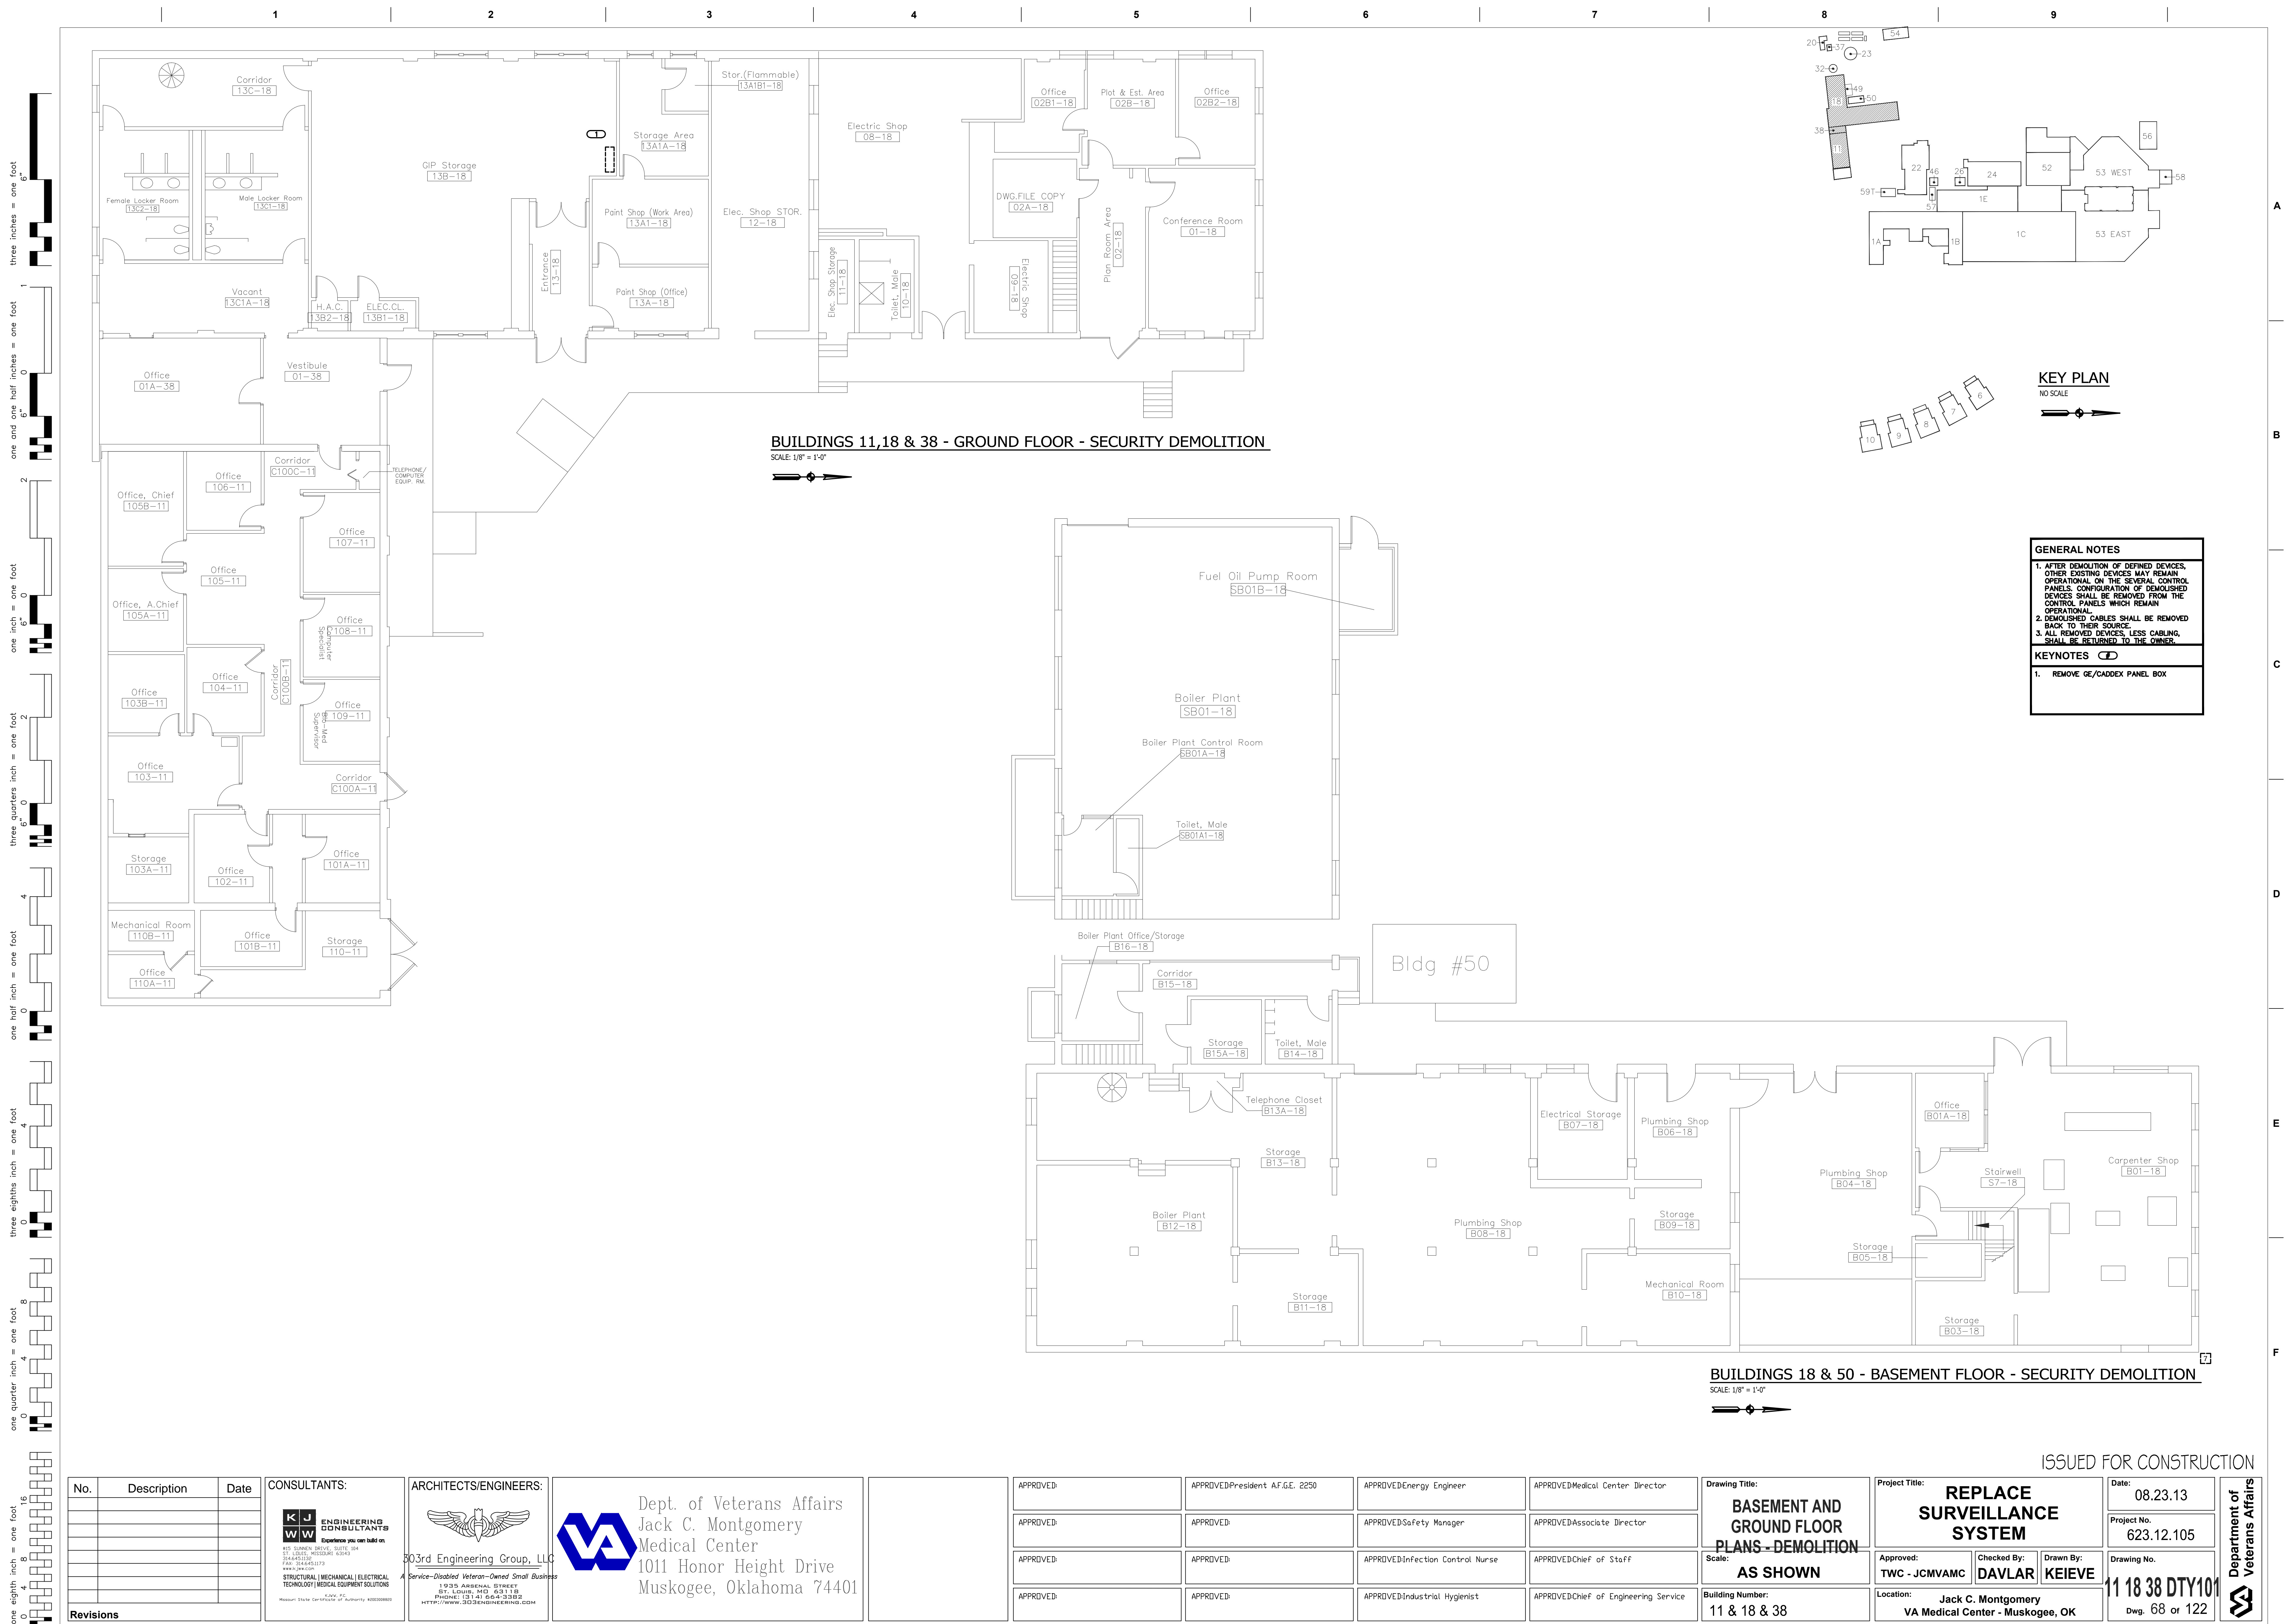

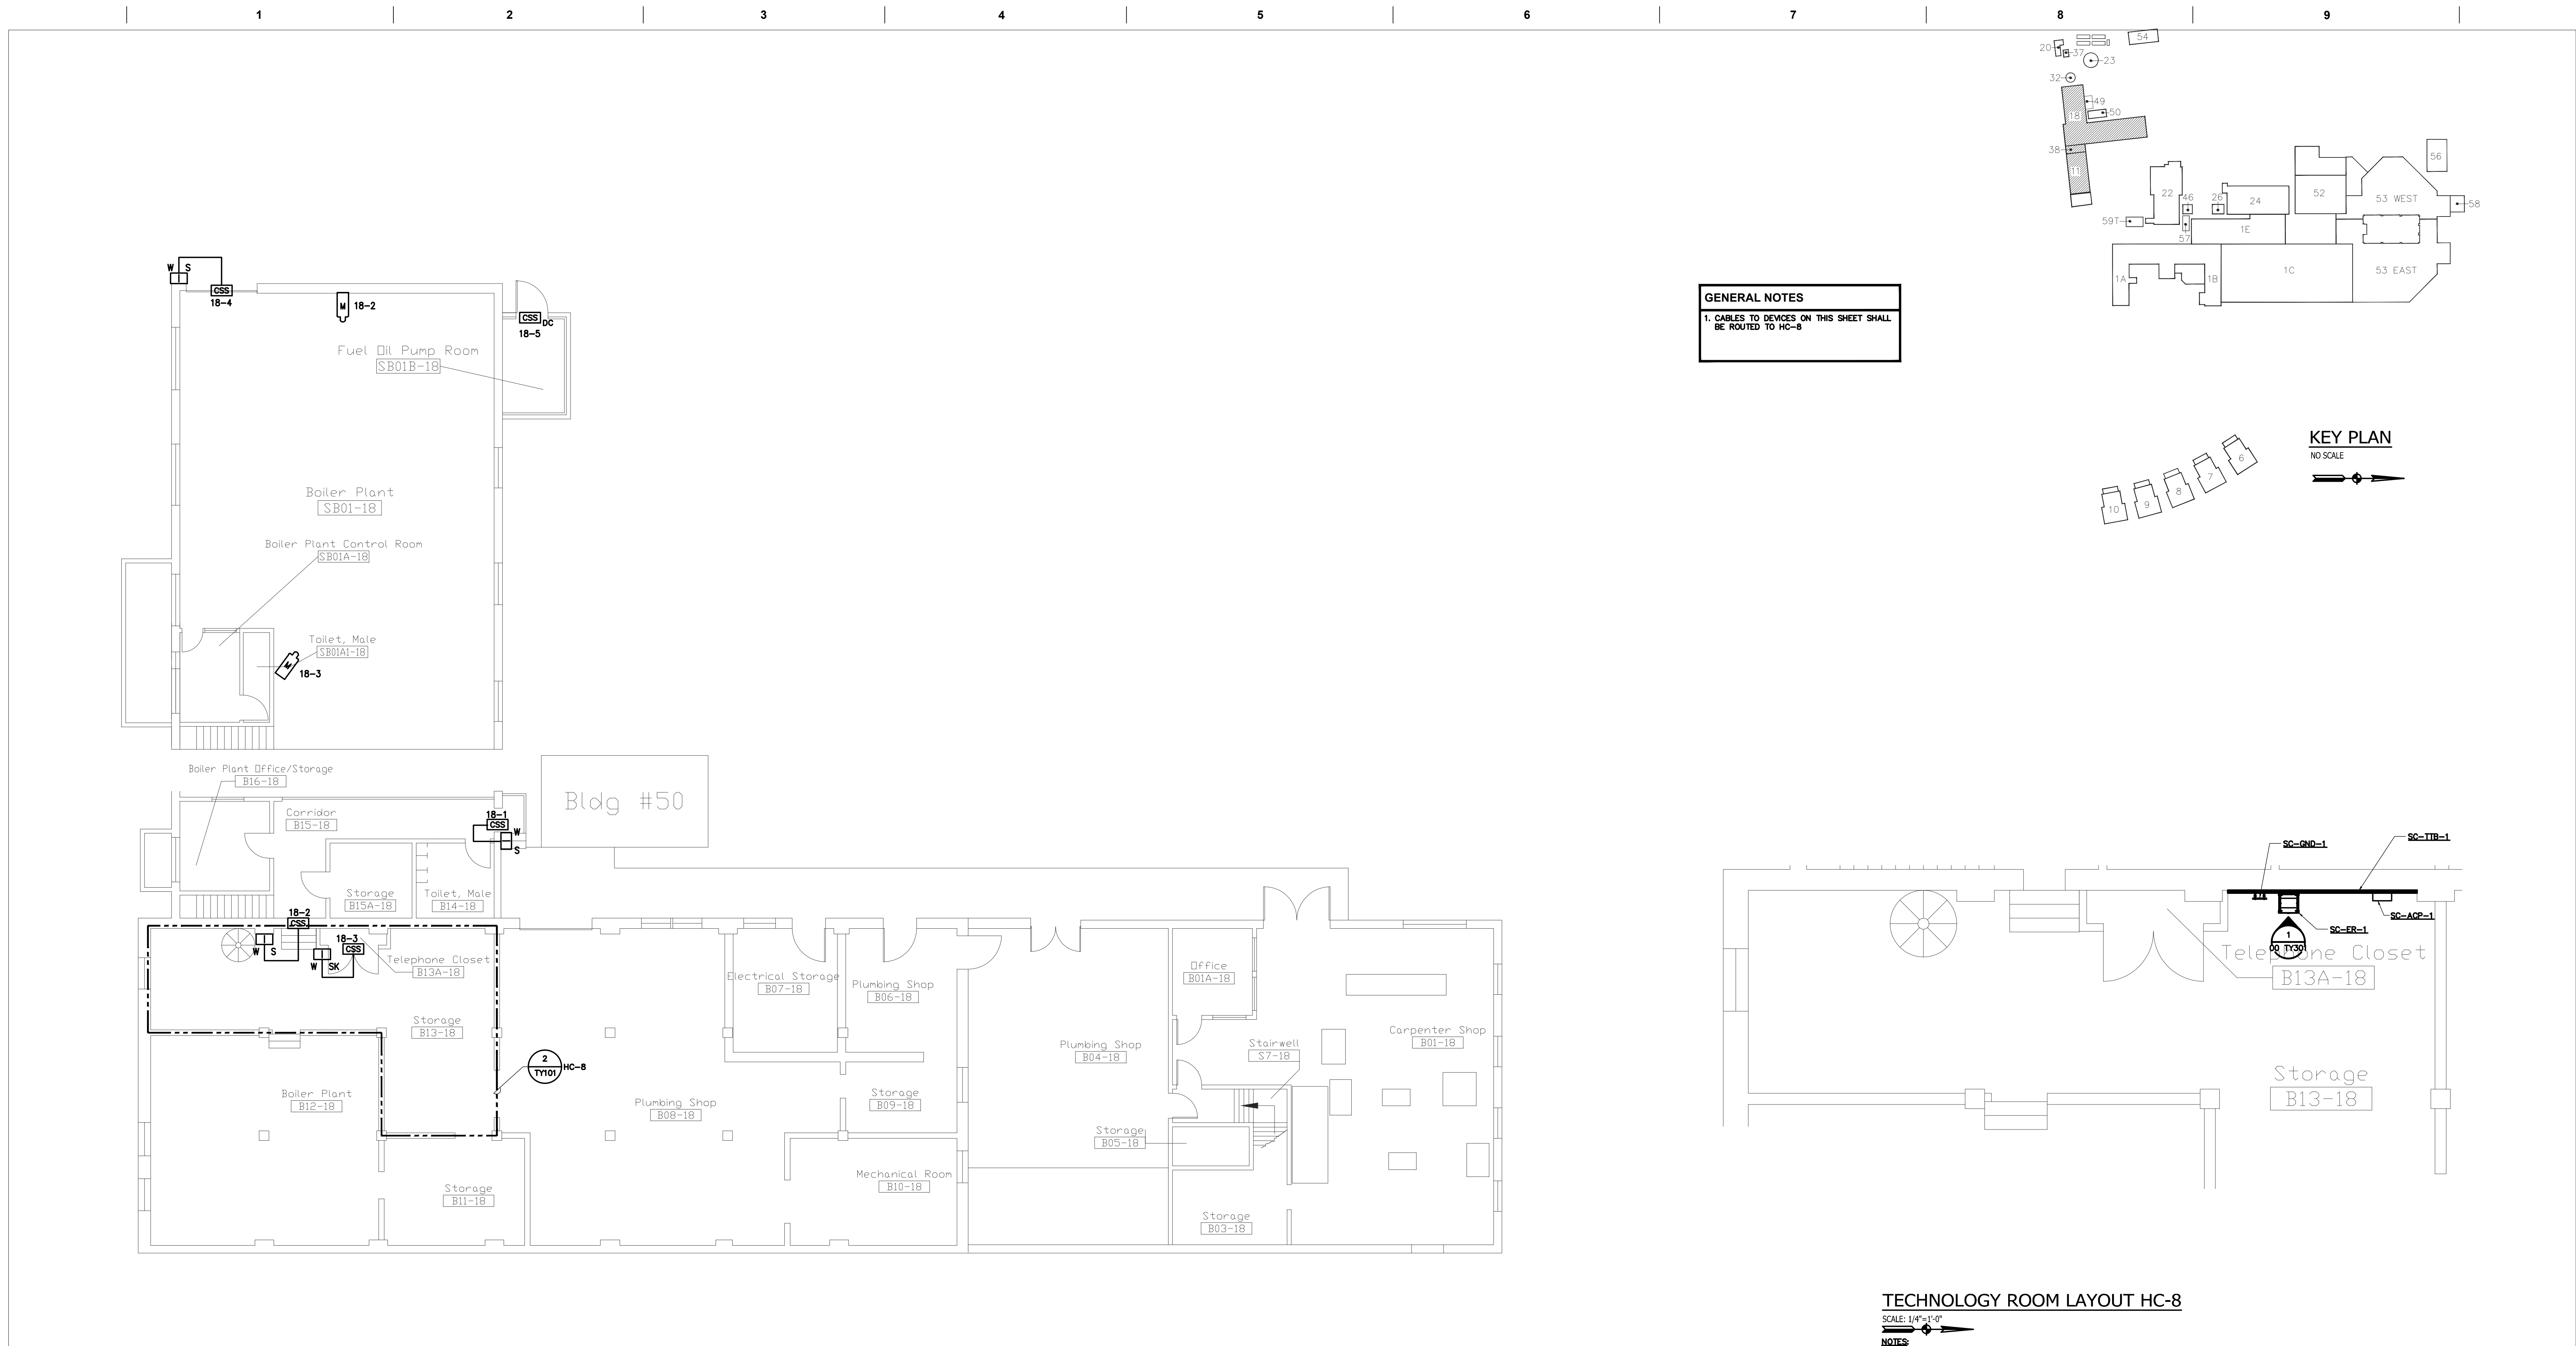

SCALE: 1/8"=1'-0"



SCALE: 1/4"=1'-0"

- NOTES:**
1. REFER TO ELECTRICAL DRAWINGS FOR GROUNDING RISER DIAGRAM.
  2. REFER TO FOR 2/00TY401 FOR CONNECTIVITY RISER DIAGRAM.
  3. REFER TO 00 TY600 FOR TECHNOLOGY GENERAL EQUIPMENT SCHEDULE.



[illegible]

ISSUED FOR CONSTRUCTION

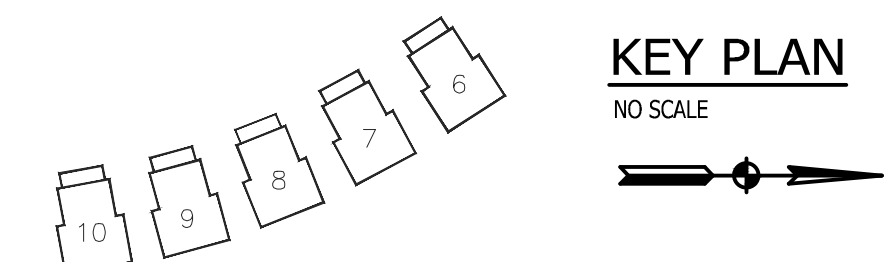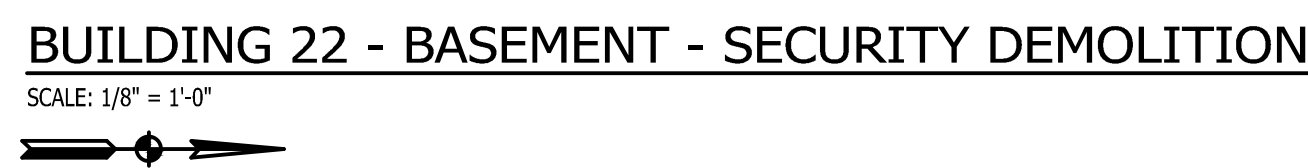





ISSUED FOR CONSTRUCTION

No.	Description	Date	CONSULTANTS:	ARCHITECTS/ENGINEERS:				APPROVED	APPROVEDPresident A.F.G.E. 2250	APPROVEDEnergy Engineer	APPROVEDMedical Center Director	Drawing Title: SUB-BASEMENT AND BASEMENT - DEMOLITION	Project Title: REPLACE SURVEILLANCE SYSTEM	Date: 08.23.13	Department of Veterans Affairs	
			 ENGINEERING CONSULTANTS Experience you can build on. 9700 NORTH AVENUE SUITE 100 ST. LOUIS, MISSOURI 63143 (314) 931-1010 WWW.KJW.COM	 303rd Engineering Group, LLC Service-Disabled Veteran-Owned Small Business 1935 ARSENAL STREET APT. LK 140 MD 6818 PHOENIX (314) 564-3382 HTTP://WWW.303ENGINEERING.COM	Dept. of Veterans Affairs Jack C. Montgomery Medical Center 1011 Honor Height Drive Muskogee, Oklahoma 74401			APPROVEDSafety Manager	APPROVEDAssociate Director		Scale: AS SHOWN	Approved By: TWC - JC/MVAMC	Checked By: DAVLAR	Drawn By: KEIEVE		Drawing No. 22 DTY101 Dwg. 71 or 122
								APPROVEDInfection Control Nurse	APPROVEDChief of Staff		BUILDING NUMBER: 22	Location: Jack C. Montgomery VA Medical Center - Muskogee, OK				
								APPROVEDIndustrial Hygienist	APPROVEDChief of Engineering Service							
Revisions																


SCALE: 1/8" = 1'-0"

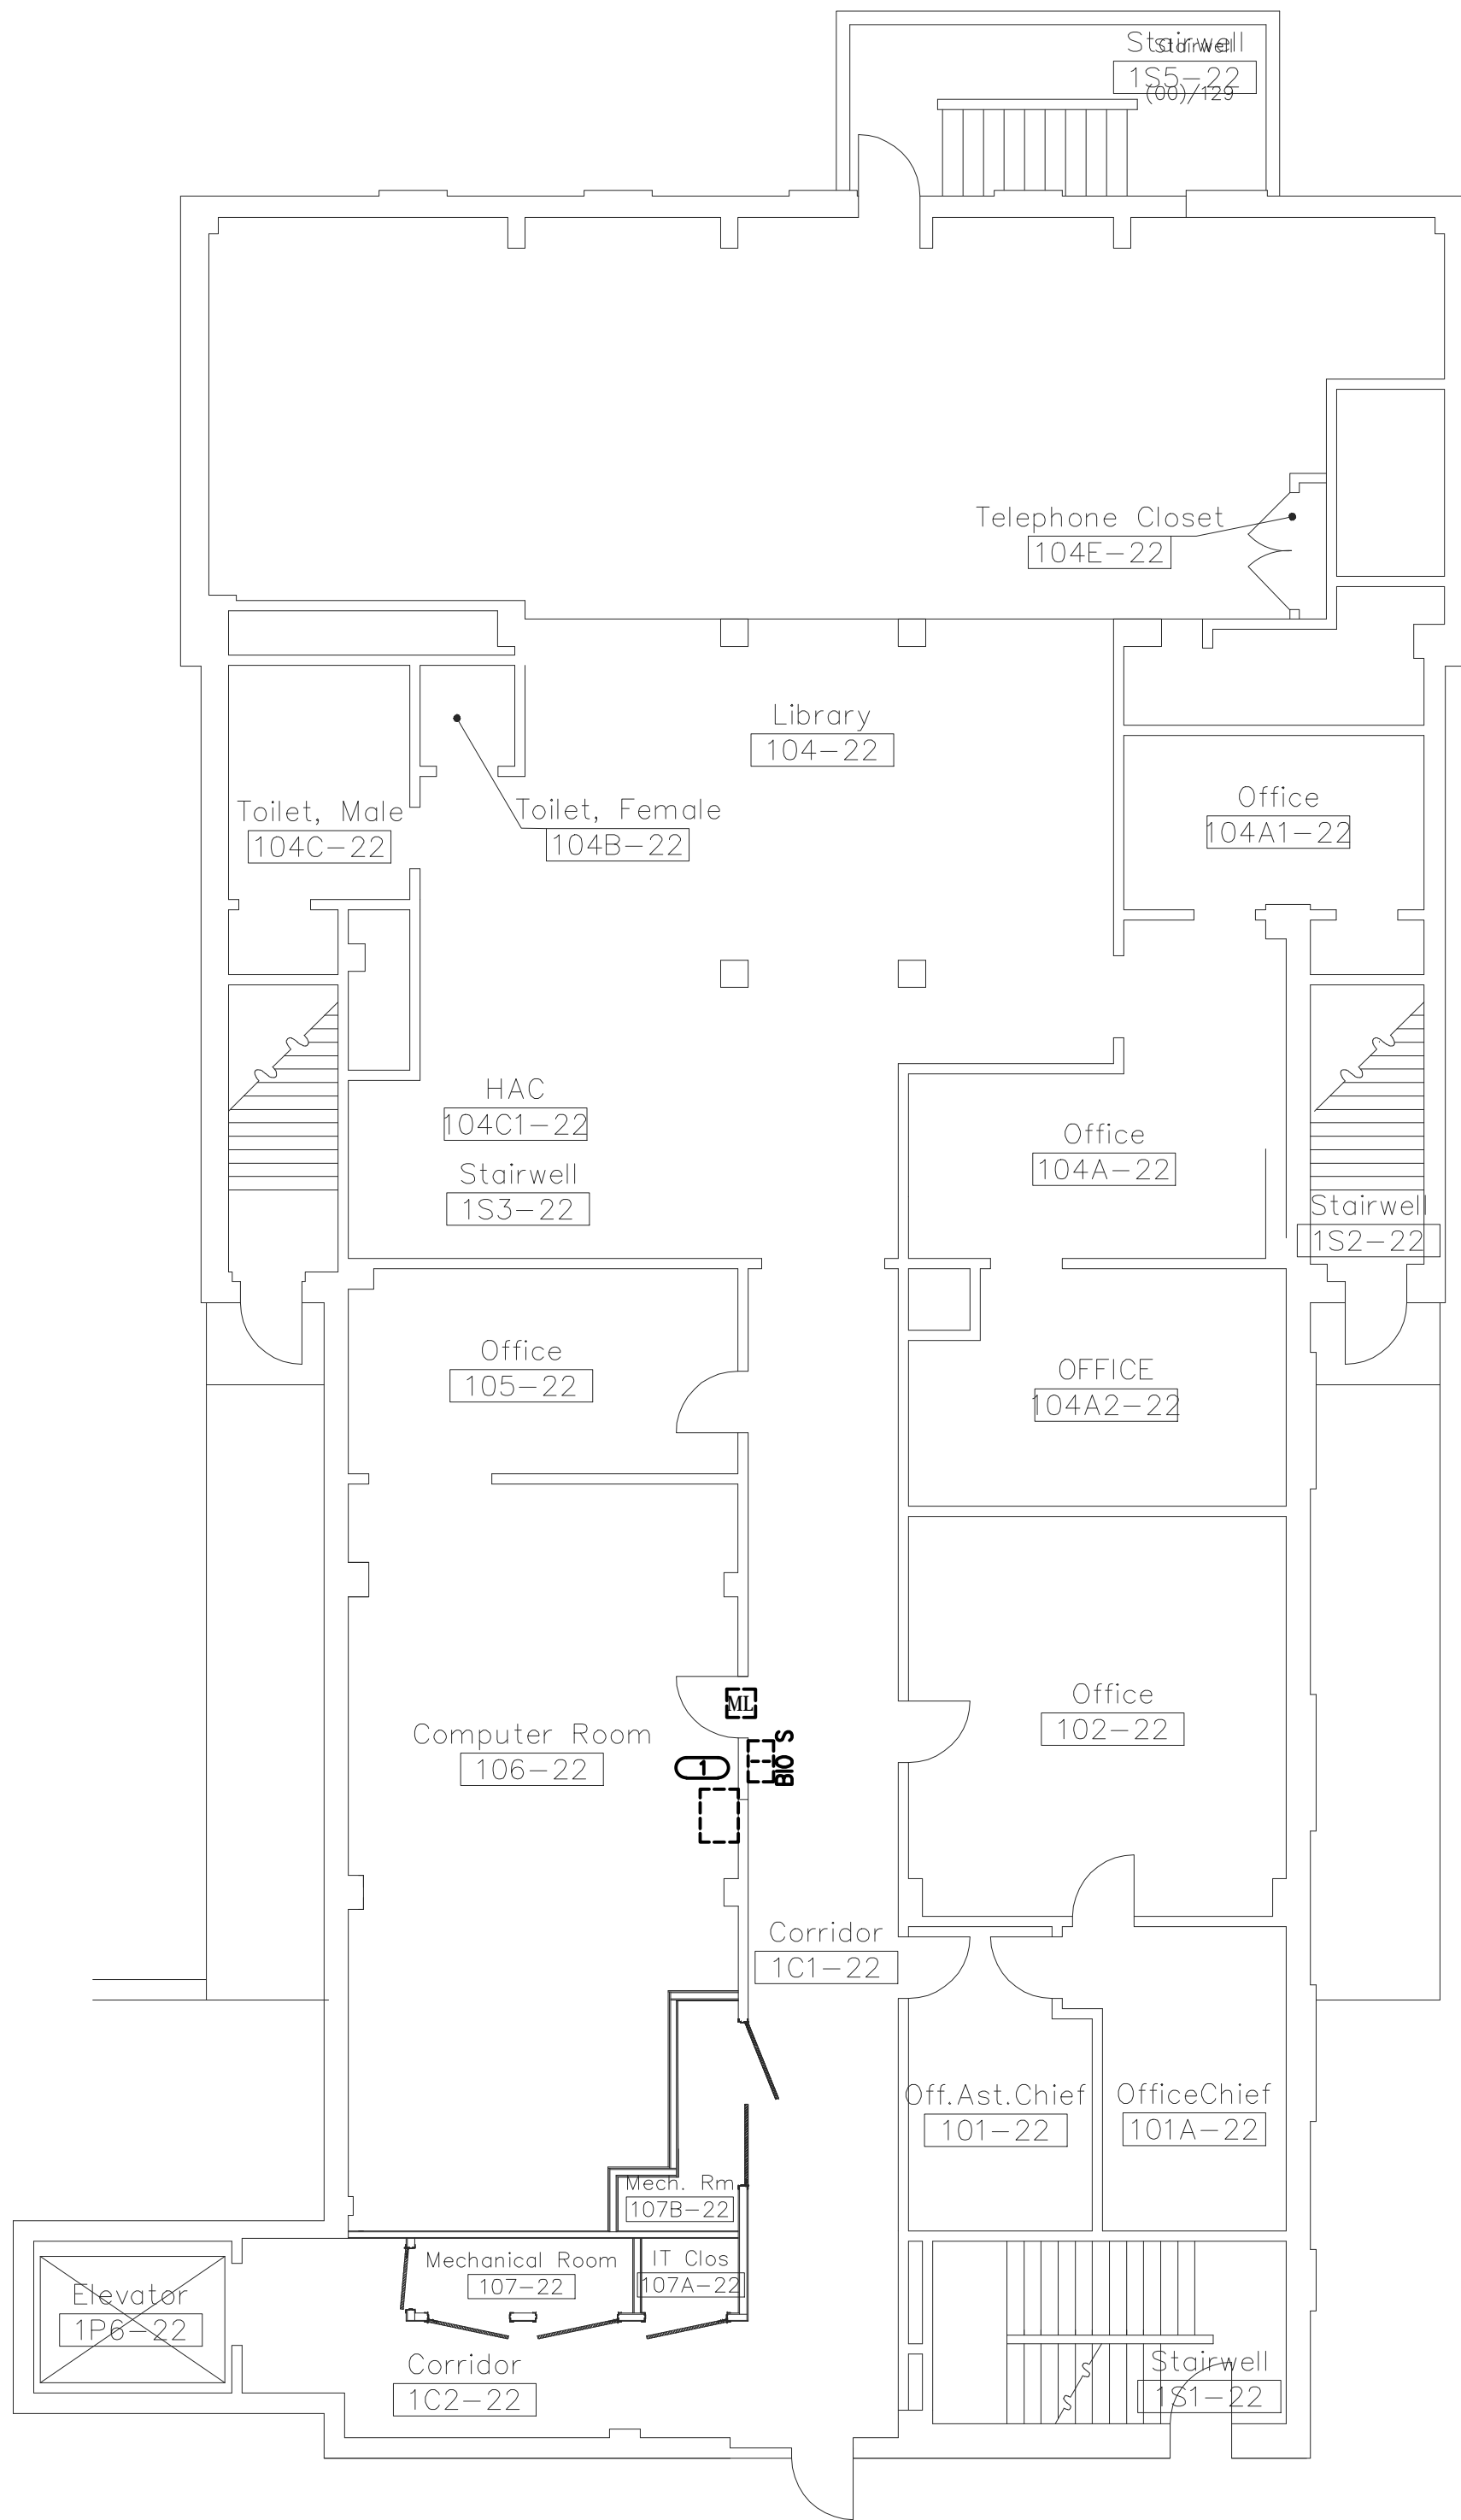


SCALE: 1/8" = 1'-0"

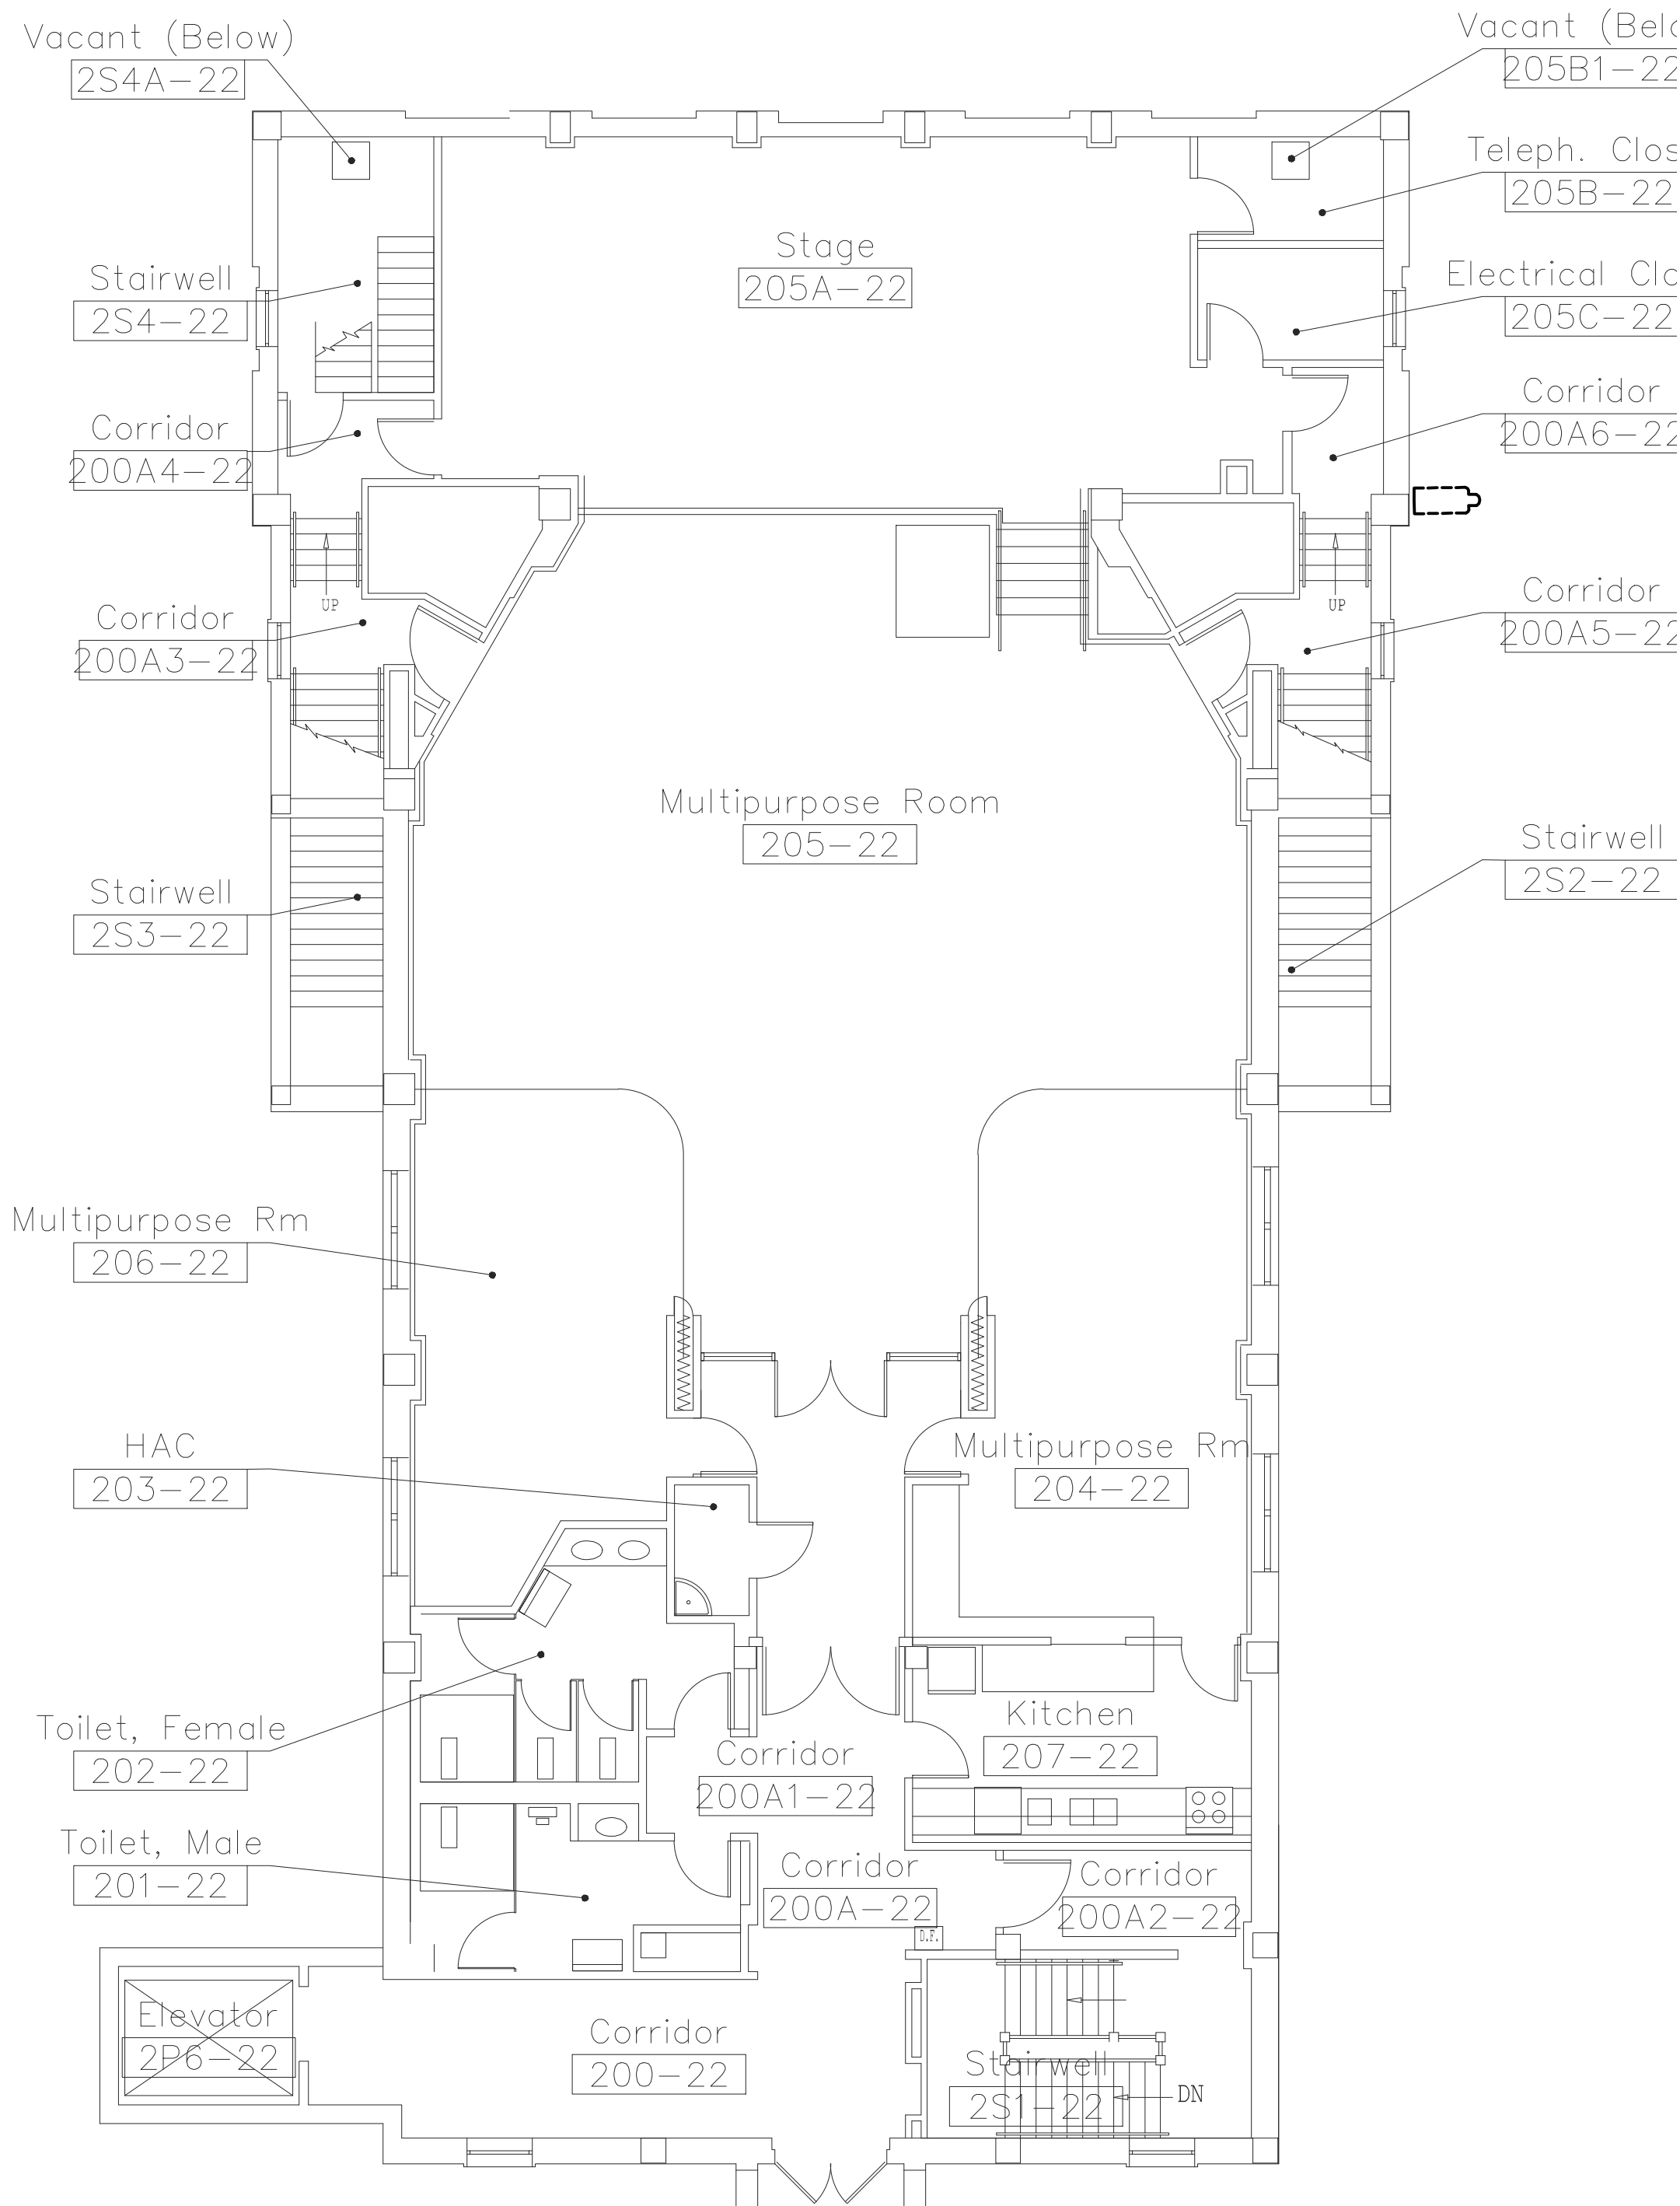


SCALE: 1/8" = 1'-0"

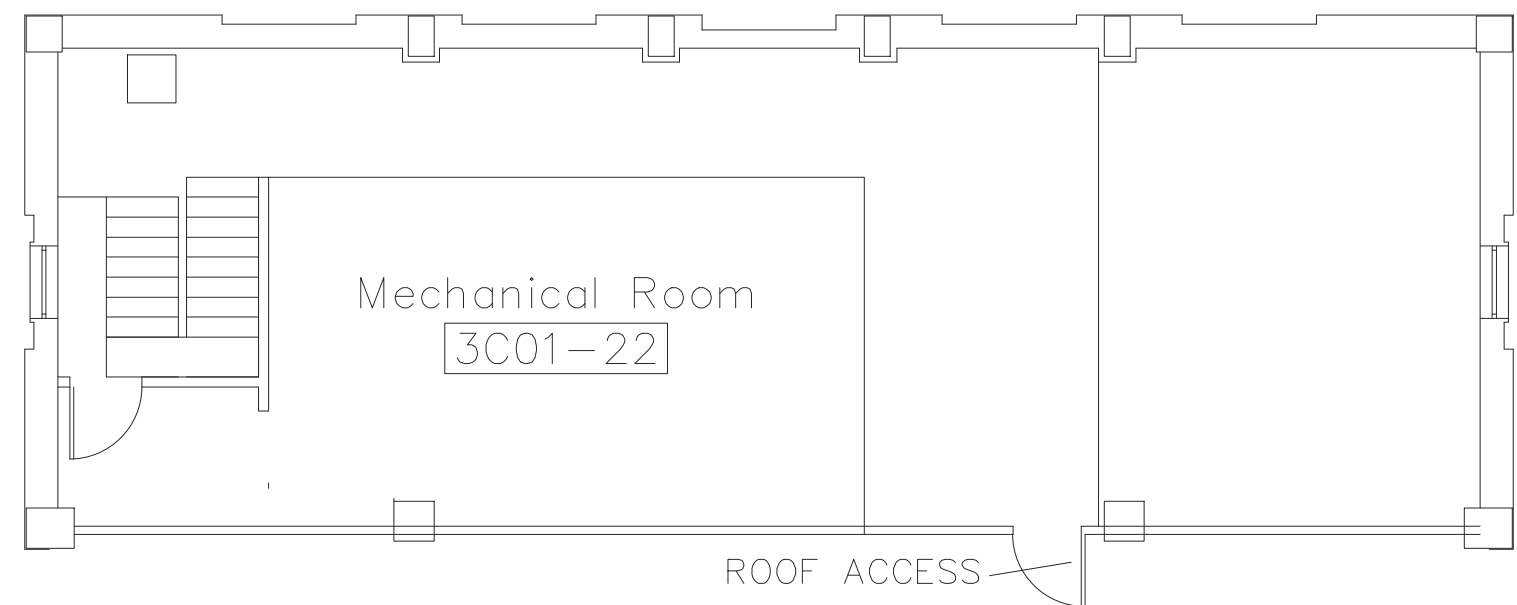

SCALE: 1/8" = 1'-0"

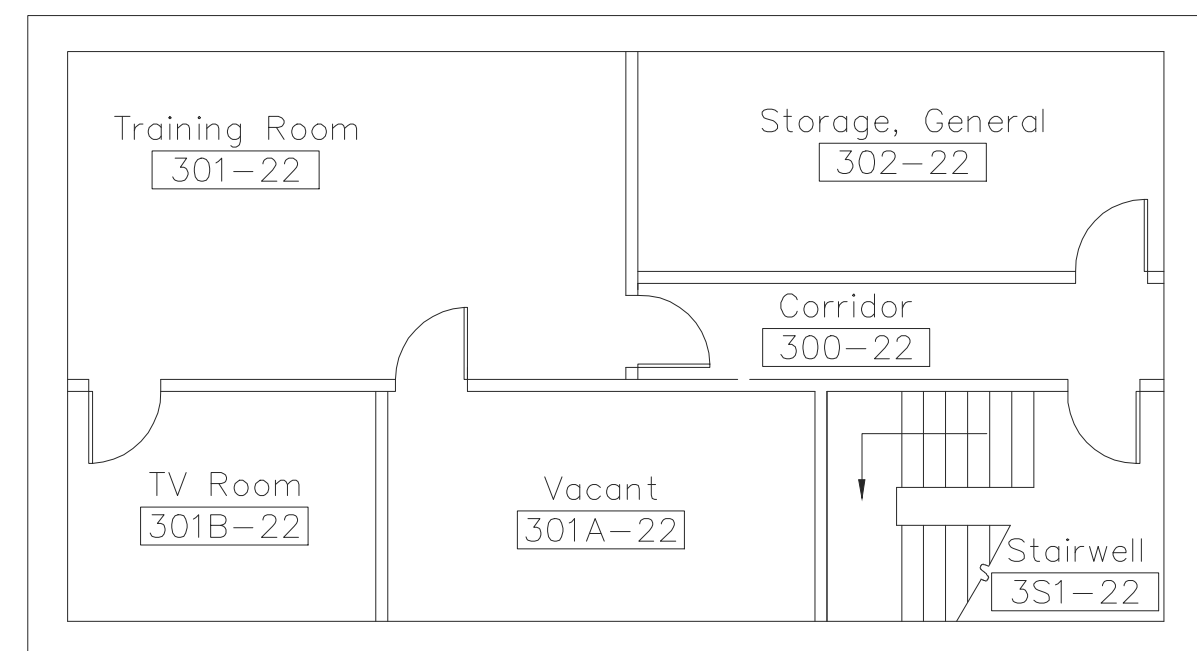

SCALE: 1/8" = 1'-0"

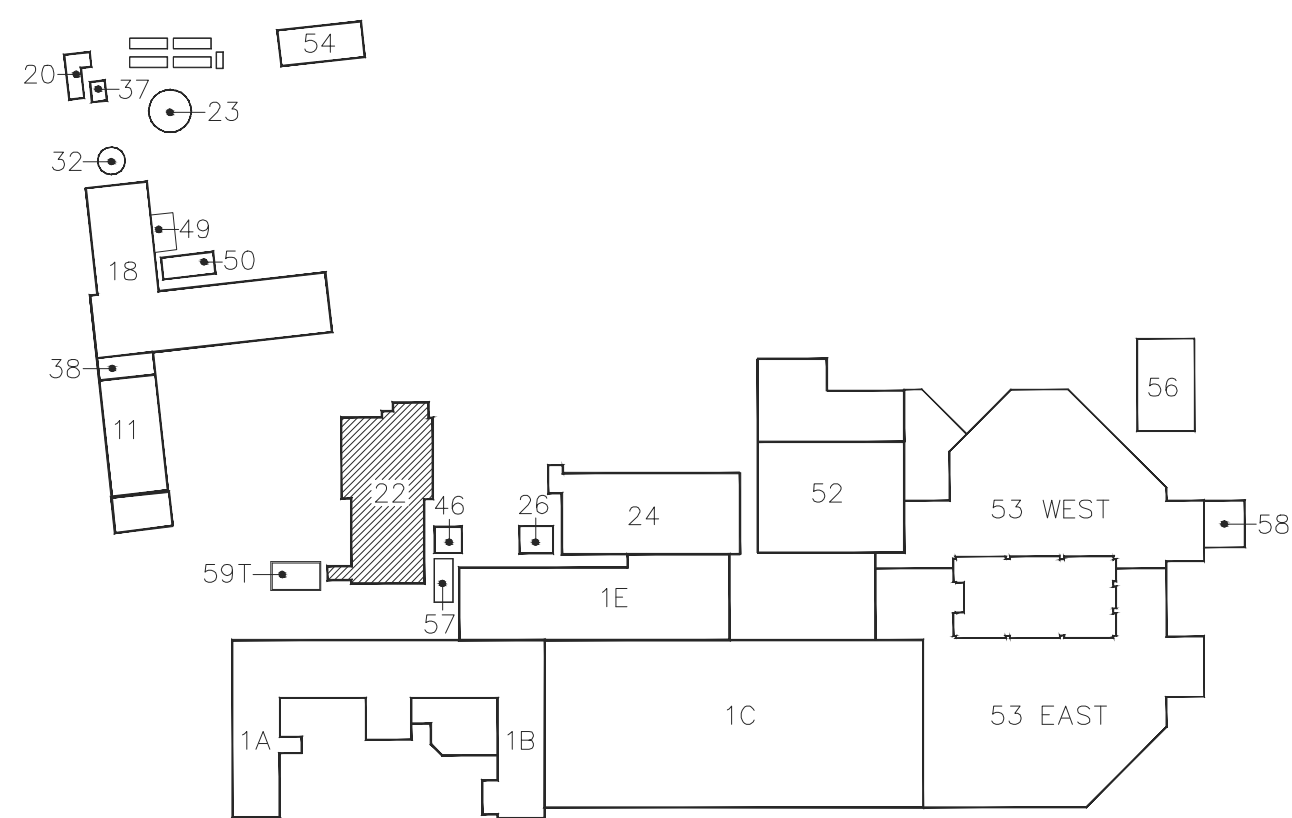

Drawing Title:  
**FIRST SECOND AND  
THIRD FLOOR -  
DEMOLITION**

Scale: **AS SHOWN**

Building Number:  
22

Project Title: **REPLACE  
SURVEILLANC  
SYSTEM**

Approved: <b>TWC - JCMVAMC</b>	Checked By: <b>DAVLAR</b>	Drawn By: <b>KEIEVE</b>
-----------------------------------	------------------------------	----------------------------

Location: Jack C. Montgomery  
VA Medical Center - Muskogee, OK

Date: 08.23.13

Project No.	623.12.105
-------------	------------

Drawing No.

**22 DTY102**  
Dwg. 72 of 122

No.	Description	Date
<b>Revisions</b>		

CONSULTANTS:




335 SUNNEN DRIVE, SUITE 104  
ST. LOUIS, MISSOURI 63143  
314.645.1132  
FAX: 314.645.1173  
www.kjew.com


**STRUCTURAL | MECHANICAL | ELECTRICAL  
TECHNOLOGY | MEDICAL EQUIPMENT SOLUTIONS**

KJWW, P.C.  
Missouri State Certificate of Authority: 000330000

ARCHITECTS/ENGINEERS:

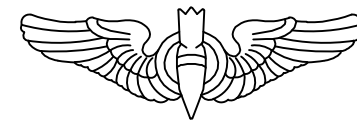

303rd Engineering Group, LLC  
Service-Disabled Veteran-Owned Small Business  
1935 ARSENAL STREET  
ST. LOUIS, MO 63118  
PHONE: (314) 664-3382



Dept. of Veterans Affairs  
 Jack C. Montgomery  
 Medical Center  
 1011 Honor Height Drive  
 Muskogee, Oklahoma 74401

APPROVED	APPROVEDPresident A.F.G.E. 2250	APPROVEDEnergy Engineer	APPROVEDMedical Center Director
APPROVED	APPROVED	APPROVEDSafety Manager	APPROVEDAssociate Director
APPROVED	APPROVED	APPROVEDInfection Control Nurse	APPROVEDChief of Staff
APPROVED	APPROVED	APPROVEDIndustrial Hygienist	APPROVEDChief of Engineering Service



Department of  
Veterans Affairs