

1

2

3

4

5

6

7

8

9

one eighth inch = one foot

one quarter inch = one foot

three eighths inch = one foot

one half inch = one foot

three quarters inch = one foot

one inch = one foot

one and one half inches = one foot

two inches = one foot

three inches = one foot

four inches = one foot

five inches = one foot

six inches = one foot

seven inches = one foot

eight inches = one foot

nine inches = one foot

ten inches = one foot

eleven inches = one foot

twelve inches = one foot

thirteen inches = one foot

fourteen inches = one foot

fifteen inches = one foot

sixteen inches = one foot

one foot

1

201B-52

1

TELEPHONE EQUIPMENT ROOM ENLARGEMENT 201B-52

SCALE: 1/4"=1'-0"

KEYNOTES:
1. EXISTING MAIN FIBER CROSS CONNECT PANEL. THERE IS EXISTING SPARE FIBER FROM THIS PANEL TO O&T ROOMS. REFER TO 00 TY400 FOR O&T ROOMS TO BE USED IN THIS PROJECT. CONTRACTOR SHALL FURNISH, INSTALL AND TERMINATE FIBER FROM THIS PANEL TO MC-1 IN ROOM 201A1-52.

2

TECHNOLOGY ROOM LAYOUT MC-1

SCALE: 1/4"=1'-0"

NOTES:
1. REFER TO ELECTRICAL DRAWINGS FOR GROUNDING RISER DIAGRAM.
2. REFER TO 3/00 TY401 FOR CONNECTIVITY RISER DIAGRAM.
3. REFER TO 00 TY600 FOR TECHNOLOGY GENERAL EQUIPMENT SCHEDULE.

SC-TIR-1 (TRP)
SC-AOP-1
SC-GND-1
3 00 TY301

No.

Description

Date

Revisions

CONSULTANTS:

KJW

ENGINEERING CONSULTANTS

Experience you can build on

870 DUNN DRIVE, SUITE 104
ST. LOUIS, MISSOURI 63143
203-711-1136
FAX: 203-711-1173
WWW.KJW.COM

STRUCTURAL | MECHANICAL | ELECTRICAL
TECHNOLOGY | MEDICAL EQUIPMENT SOLUTIONS

Missouri State Certificate of Authority: 8000000000

ARCHITECTS/ENGINEERS:

303rd Engineering Group, LLC

Service-Disabled Veteran-Owned Small Business

1925 ARSENAL STREET
ST. LOUIS, MO 63118
PHONE: (314) 564-3282
HTTP://WWW.303ENGINEERING.COM

Dept. of Veterans Affairs
Jack C. Montgomery
Medical Center
1011 Honor Height Drive
Muskogee, Oklahoma 74401

APPROVED:

APPROVED:President AF.GE. 2250

APPROVED:Energy Engineer

APPROVED:Medical Center Director

APPROVED:

APPROVED:

APPROVED:Safety Manager

APPROVED:Associate Director

APPROVED:

APPROVED:

APPROVED:Infection Control Nurse

APPROVED:Chief of Staff

APPROVED:

APPROVED:

APPROVED:Industrial Hygienist

APPROVED:Chief of Engineering Service

Drawing Title:

ROOM ENLARGEMENTS

Scale:

AS SHOWN

Building Number:

52

Project Title:

REPLACE SURVEILLANCE SYSTEM

Approved:

TWC - JCMVAMC

Checked By:

DAVLAR

Drawn By:

KEIEVE

Location:

Jack C. Montgomery
VA Medical Center - Muskogee, OK

Date:

08.23.13

Project No.

623.12.105

Drawing No.

52 TY200

Dwg. 81 of 122


ISSUED FOR CONSTRUCTION


Department of Veterans Affairs


VA FORM 08-6231


PRINTED ON: August 20, 2013

ORIGINAL SIZE OF SHEET IS 30" X 42"

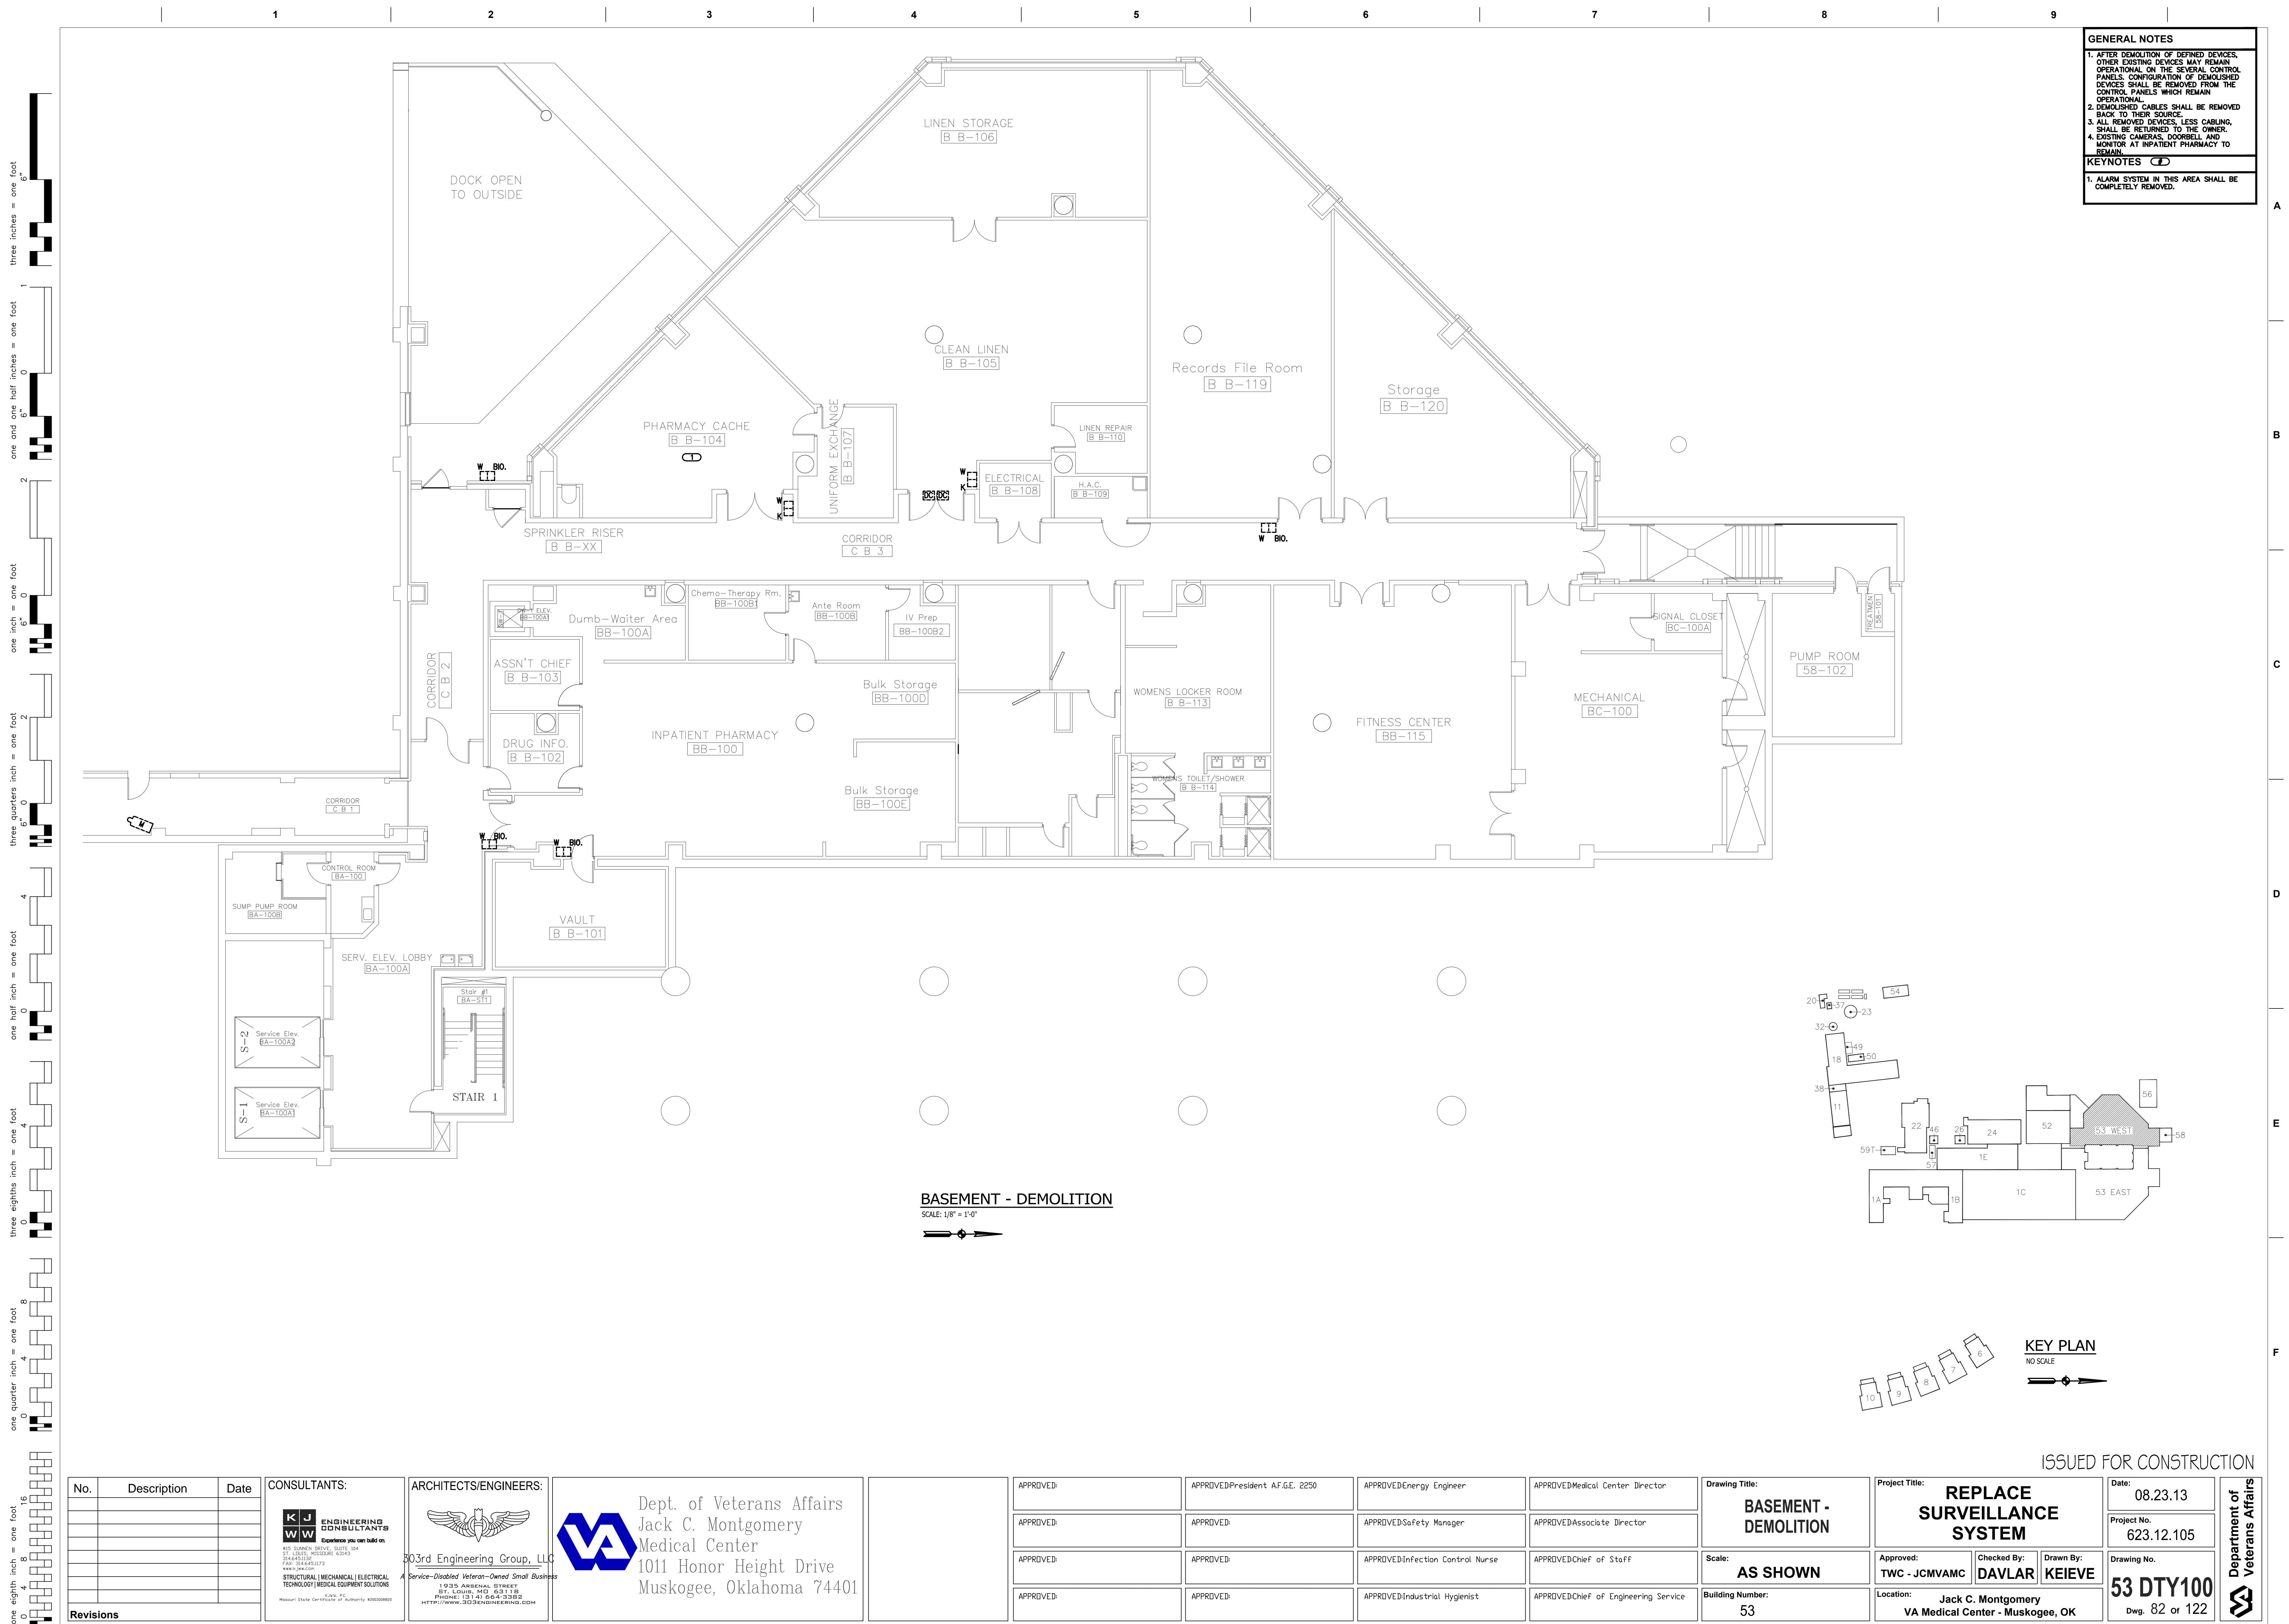

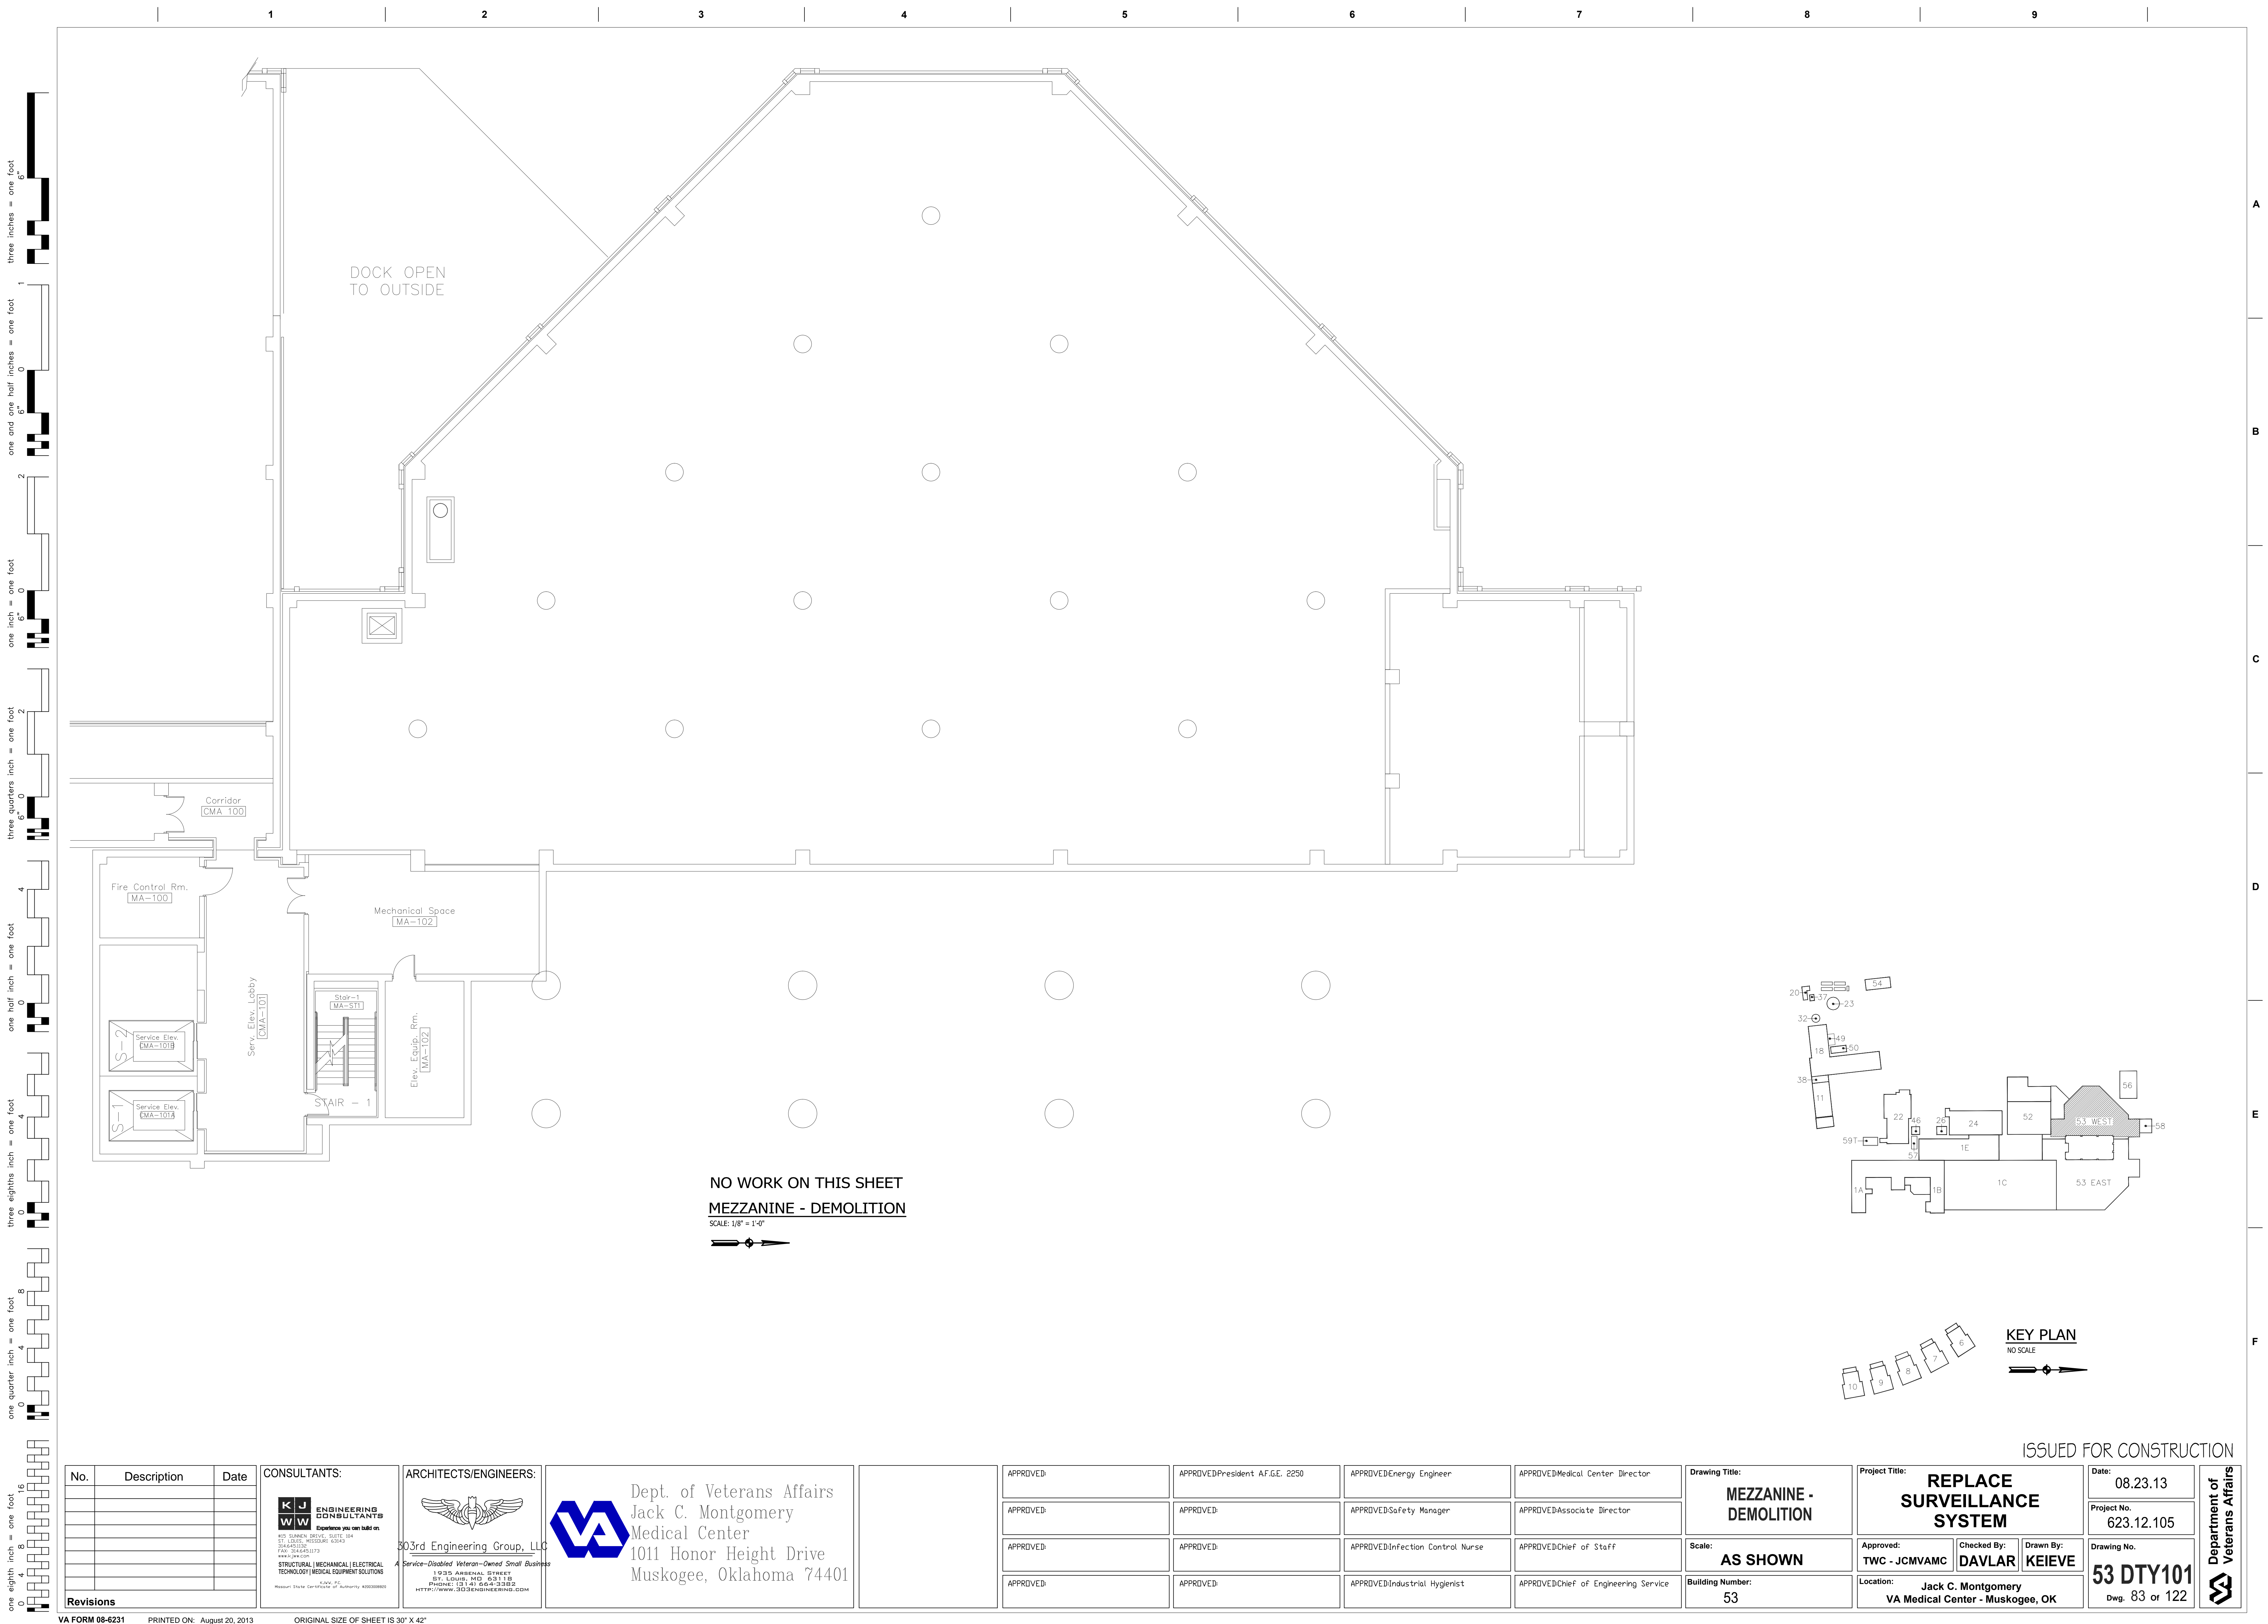

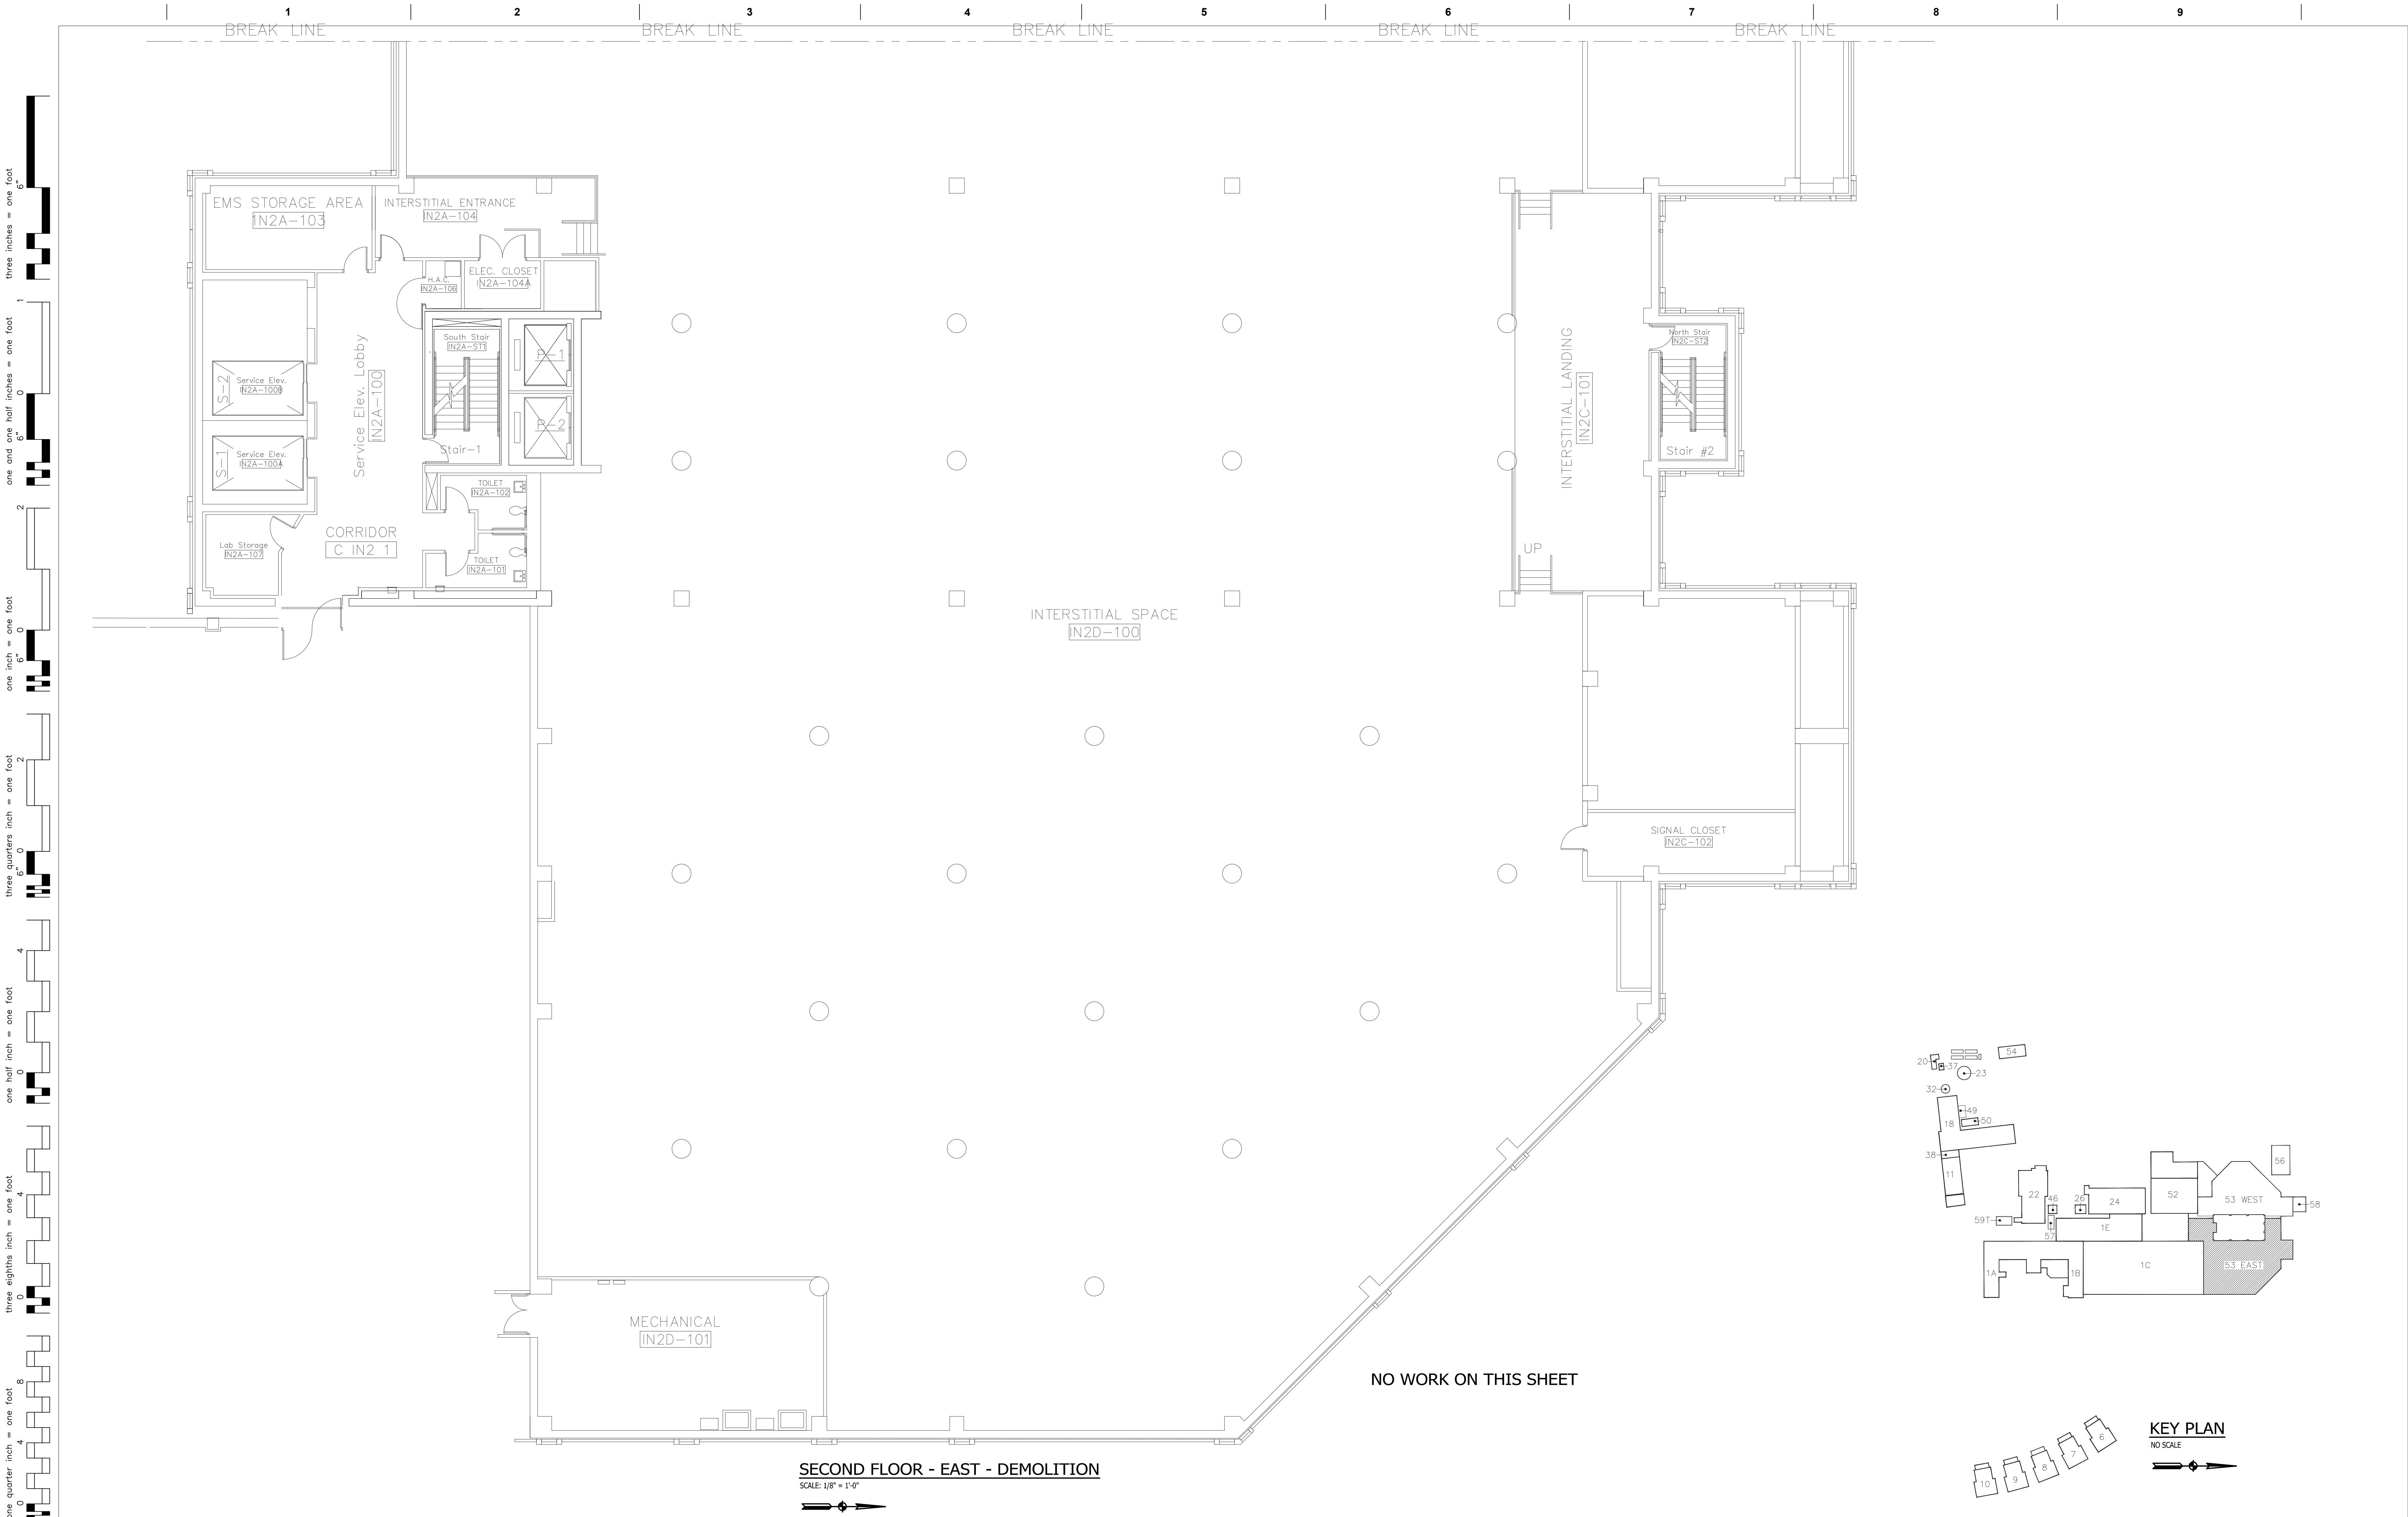

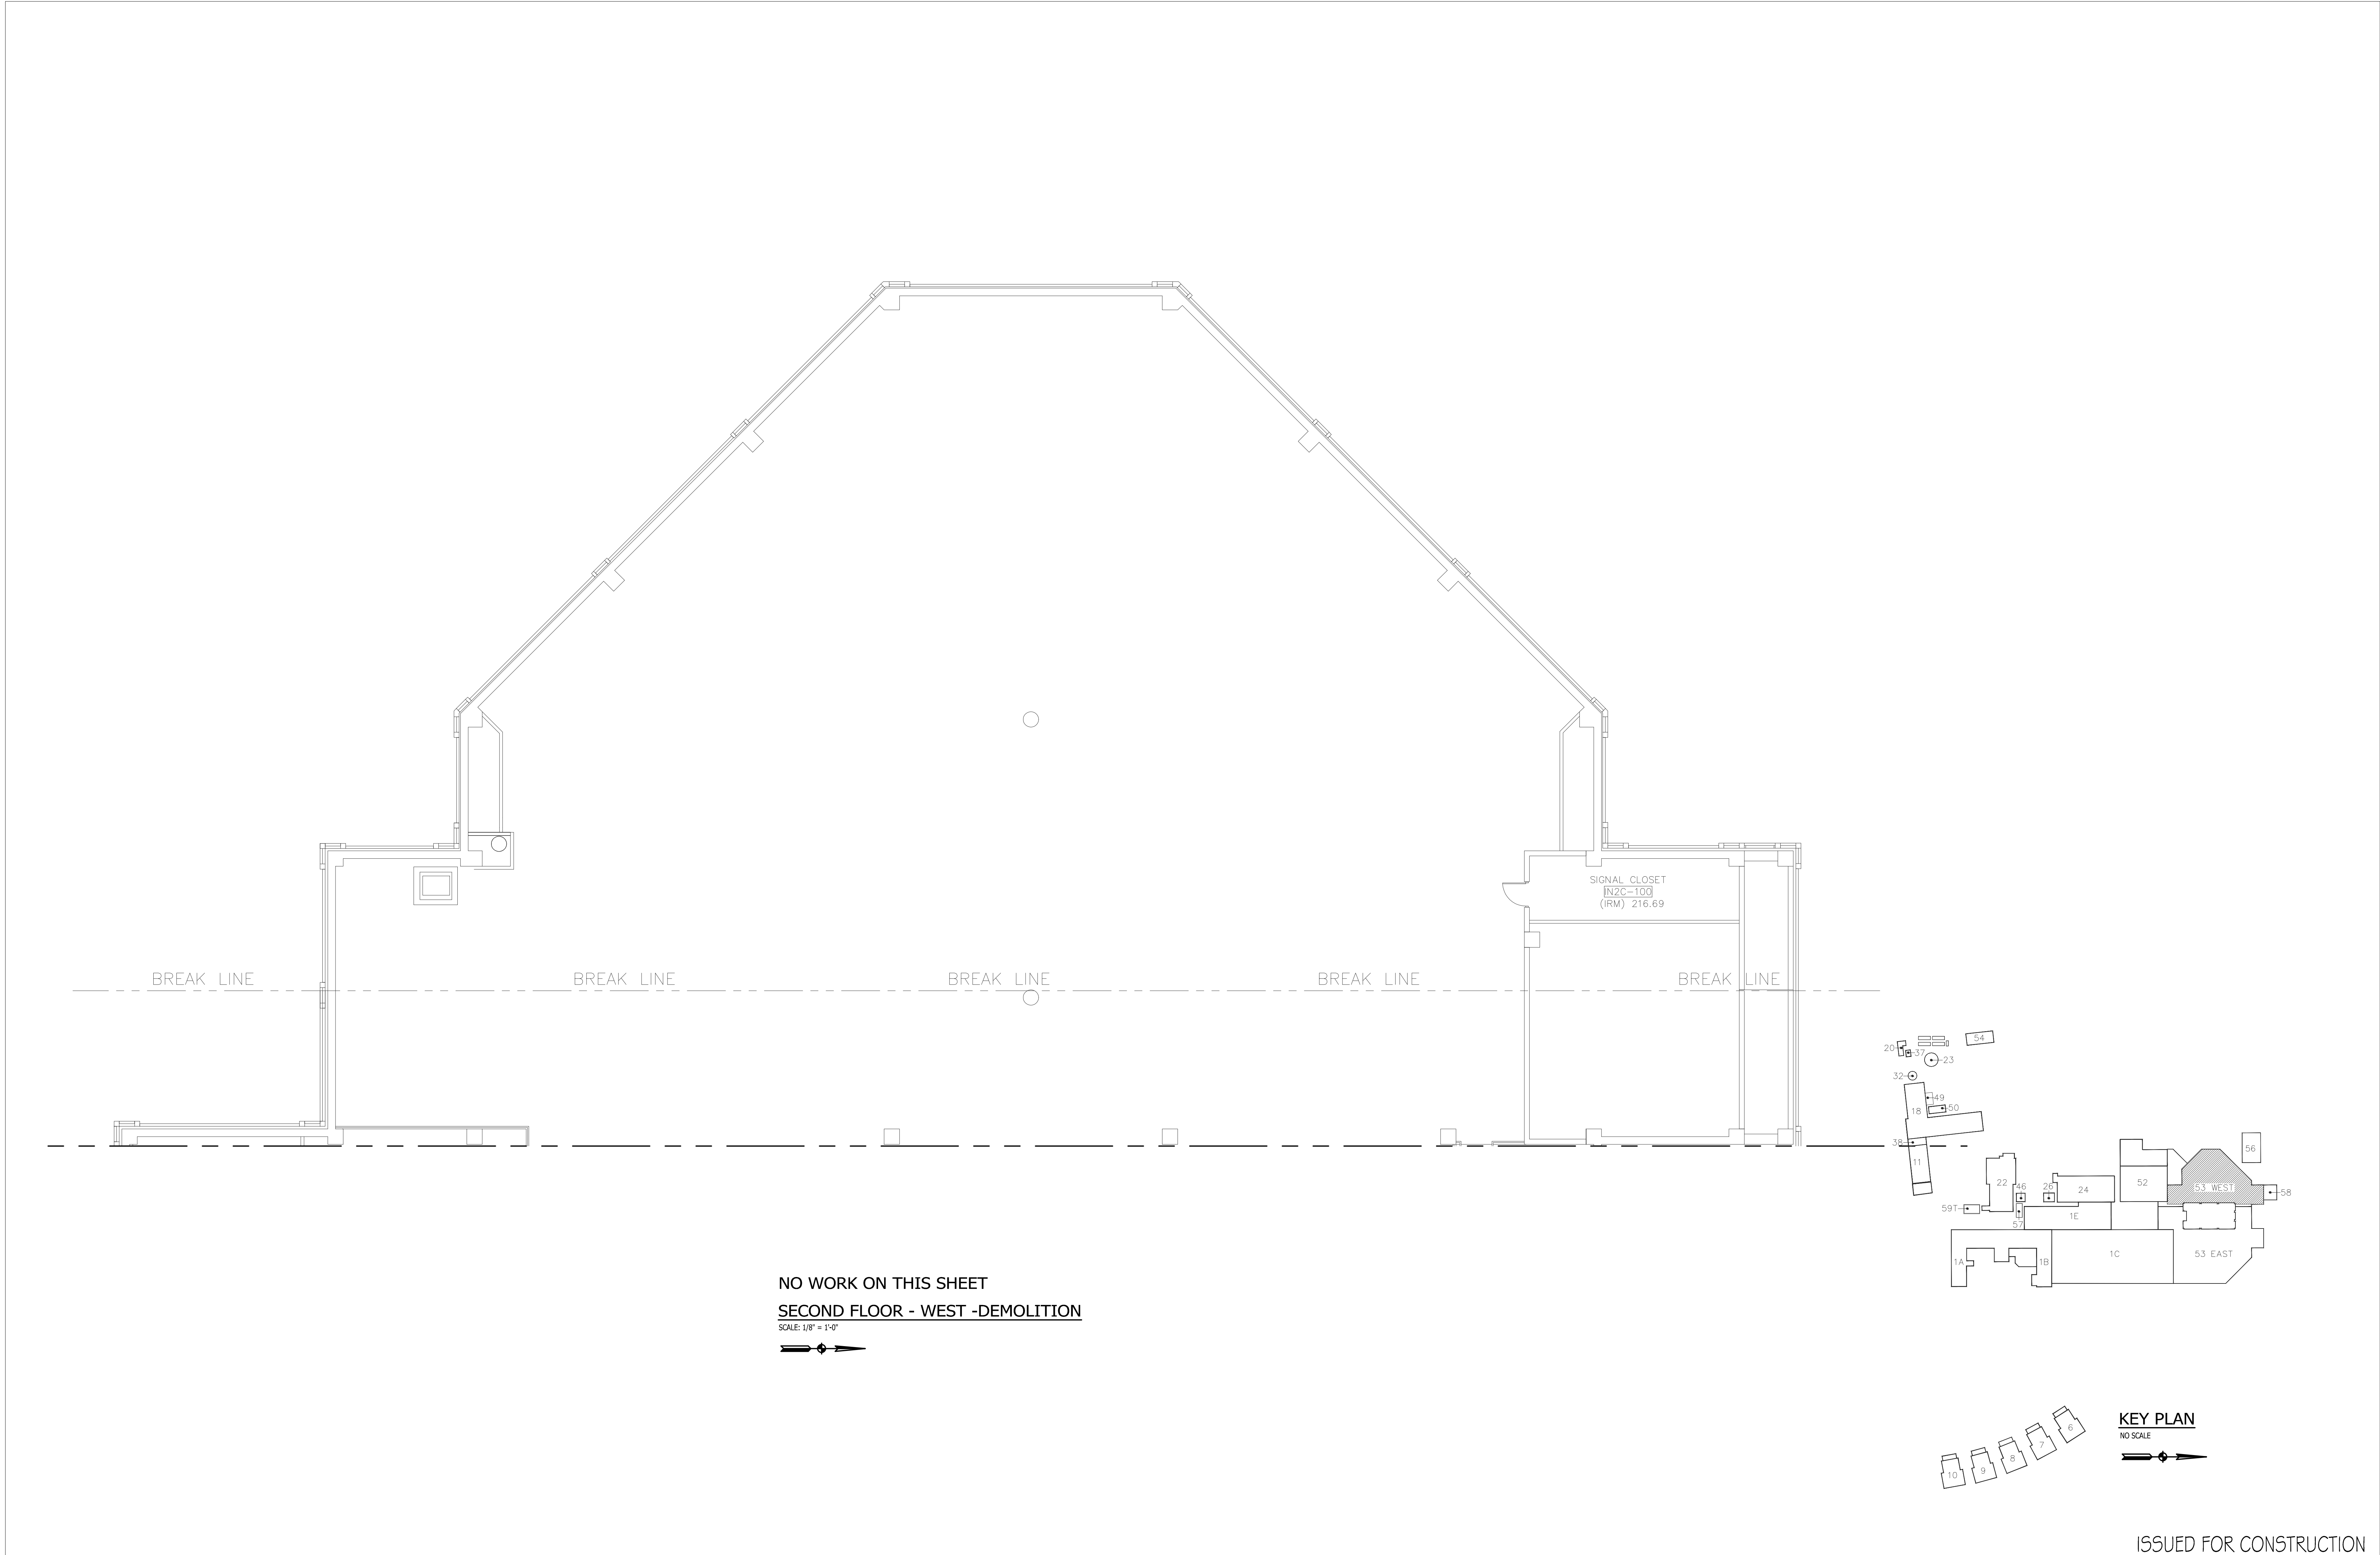

No.	Description	Date
Revisions		

CONSULTANTS:

K J W W
ENGINEERING CONSULTANTS
Experience you can build on.

PO BOX 9076, SUITE 104
ST. LOUIS, MISSOURI 63143
264-8410
FAX 314-665-1173
www.kjww.com

STRUCTURAL | MECHANICAL | ELECTRICAL
TECHNOLOGY | MEDICAL EQUIPMENT SOLUTIONS

ST. LOUIS, MO
Missouri State Capitalize of Authority: 000000000

ARCHITECTS/ENGINEERS:

303rd Engineering Group, LLC
A Service-Disabled Veteran-Owned Small Business

1935 ARDENIA STREET
ST. LOUIS, MO 63118
PHONE: (314) 564-3343
HTTP://WWW.3DENGINEERING.COM

Dept. of Veterans Affairs
Jack C. Montgomery
Medical Center
1011 Honor Height Drive
Muskogee, Oklahoma 74401

APPROVED:

APPROVED: President A.F.G.E. 2250

APPROVED: Energy Engineer

APPROVED: Medical Center Director

APPROVED:

APPROVED: Safety Manager

APPROVED:

APPROVED: Infection Control Nurse

APPROVED:

APPROVED: Industrial Hygienist

APPROVED: President A.F.G.E. 2250

APPROVED: Safety Manager

APPROVED: Infection Control Nurse

APPROVED: Chief of Staff

APPROVED: Associate Director

APPROVED: Chief of Engineering Service

Drawing Title:
**SECOND FLOOR -
WEST -DEMOLITION**

Scale:
AS SHOWN

Building Number:
53

Project Title:
**REPLACE
SURVEILLANCE
SYSTEM**

Approved: TWC - JCMVAMC	Checked By: DAVLAR	Drawn By: KEIEVE
-----------------------------------	------------------------------	----------------------------

Location:
**Jack C. Montgomery
VA Medical Center - Muskogee, OK**

Date:
08.23.13

Project No.
623.12.105

Drawing No.
53 DTY105

Dwg. 87 of 122

Department of
Veterans Affairs

