

# OEF/OIF CLINICAL EXPANSION PROJECT 259-12-C-0262

## INDEX OF DRAWINGS

CV1.0 COVER SHEET  
CV1.1 COVER SHEET - CLINIC  
CV1.2 COVER SHEET - WAREHOUSE

### CIVIL SHEETS

C-0 CIVIL NOTES, ABBREVIATIONS AND LEGEND  
C-1 CLINIC EXPANSION SITE DEMOLITION PLAN  
C-2 CLINIC EXPANSION SITE PLAN  
C-3 WAREHOUSE EXPANSION PROPOSED SITE  
C-4 DETAILS  
C-5 DETAILS

### ARCHITECTURAL SHEETS

LS-1 LIFE SAFETY PLAN  
D-1.0 DEMOLITION PLAN  
A-1.0 SUBFLOOR PLAN AND DETAILS  
A-1.1 ARCHITECTURAL PLAN  
A-1.2 DIMENSION PLAN  
A-1.3 EQUIPMENT / FURNISHING PLAN  
A-1.4 REFLECTED CEILING PLAN  
A-1.5 FINISH PLAN AND SCHEDULE  
A-1.6 BUILDING SHELL PLAN  
A-1.7 RAMP PLAN AND DETAILS  
A-2.0 ROOF PLAN  
A-3.0 EXTERIOR ELEVATIONS  
A-5.0 WALL SECTIONS AND DETAILS  
A-5.1 WALL SECTIONS AND DETAILS  
A-5.2 WALL SECTIONS AND DETAILS  
A-5.3 WALL SECTIONS AND DETAILS  
A-6.0 INTERIOR ELEVATIONS  
A-7.0 CASEWORK DETAILS  
A-8.0 WAREHOUSE DEMOLITION PLAN  
A-9.0 WAREHOUSE FIRST FLOOR PLAN  
A-9.1 WAREHOUSE MEZZANINE PLAN AND DETAILS  
A-10.0 WAREHOUSE EXTERIOR ELEVATIONS  
A-11.0 WAREHOUSE SECTIONS  
A-12.0 WAREHOUSE DETAILS

### STRUCTURAL SHEETS

S0.1 GENERAL NOTES  
S1.1 FOUNDATION PLAN  
S1.2 FOUNDATION PLAN AND GENERAL NOTES  
S2.1 ROOF FRAMING PLAN  
S2.2 MEZZANINE FRAMING PLAN AND DETAILS  
S3.1 MOMENT FRAMES AND DETAILS  
S5.1 DETAILS  
S5.2 DETAILS  
S5.3 DETAILS  
S5.4 TYPICAL DETAILS  
S5.5 TYPICAL DETAILS

### MECHANICAL SHEETS

M-0.0 MECHANICAL LEGENDS AND SCHEDULES  
M-0.1 MECHANICAL SCHEDULES  
M-0.2 MECHANICAL TEMPERATURE CONTROL SEQUENCES  
M-0.3 MECHANICAL DETAILS  
M-0.4 MECHANICAL DETAILS  
M-0.5 MECHANICAL HYDRONIC PIPING DIAGRAM  
M-1.0 CLINIC MECHANICAL DEMOLITION PLAN  
M-2.0 CLINIC MECHANICAL HVAC PLAN  
M-2.1 CLINIC MECHANICAL ROOF PLAN  
M-3.0 CLINIC MECHANICAL HYDRONIC PIPING PLAN  
M-4.0 CLINIC WASTE AND VENT PLUMBING PLAN  
M-4.1 CLINIC DOMESTIC WATER PLUMBING PLAN  
M-5.0 WAREHOUSE MECHANICAL DEMOLITION PLAN  
M-5.1 WAREHOUSE MECHANICAL REMODEL PLAN



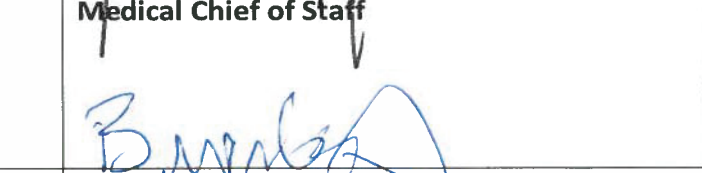
### FIRE SUPPRESSION SHEETS

FP1.1 CLINIC REMODEL FIRE SPRINKLER PLANS  
FP1.2 WAREHOUSE ADDITION FIRE SPRINKLER PLANS

### ELECTRICAL SHEETS


E0.1 ELECTRICAL LEGEND AND SCHEDULES  
E0.2 ONE-LINE DIAGRAM AND SCHEDULES  
E1.0 MAIN FLOOR ELECTRICAL DEMOLITION PLAN  
E2.0 MAIN FLOOR LIGHTING PLAN  
E3.0 MAIN FLOOR POWER PLAN  
E3.1 ROOF POWER PLAN  
E3.2 PARTIAL POWER AND I.T. PLAN  
E3.3 CRAWLSPACE ELECTRICAL PLAN  
E4.0 MAIN FLOOR SPECIAL SYSTEMS PLAN  
E4.1 SPECIAL SYSTEMS DETAILS  
E5.0 WAREHOUSE ELECTRICAL DEMOLITION PLAN  
E5.1 WAREHOUSE LIGHTING PLAN  
E5.2 WAREHOUSE POWER AND SPECIAL SYSTEMS PLAN  
E5.3 WAREHOUSE MEZZANINE ELECTRICAL PLAN AND DETAILS  
E5.4 WAREHOUSE ELECTRICAL LEGEND AND SCHEDULES

### APPROVED FOR CONSTRUCTION

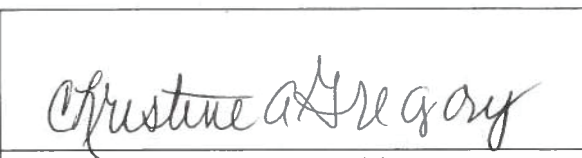 Director VA Montana Healthcare	 Medical Chief of Staff
 Associate Director VA Montana Healthcare	 Safety
 Chief FMS	 AFGE
 Construction Engineering	 Nail Teshome

### CONSTRUCTION DOCUMENTS


Drawing Title COVER SHEET	Project Title OEF/OIF CLINICAL EXPANSION	Project Number VA-259-12-C-0262	Office of Construction and Facilities Management
Approved Project Director CONSTRUCTION ENGINEER	Location FORT HARRISON, MONTANA	Building Number 154 & 170	
Date 12-4-13	Checked TDL	Drawn JJ	Department of Veterans Affairs
Drawing Number CV1.0	Dwg.1	of 75	

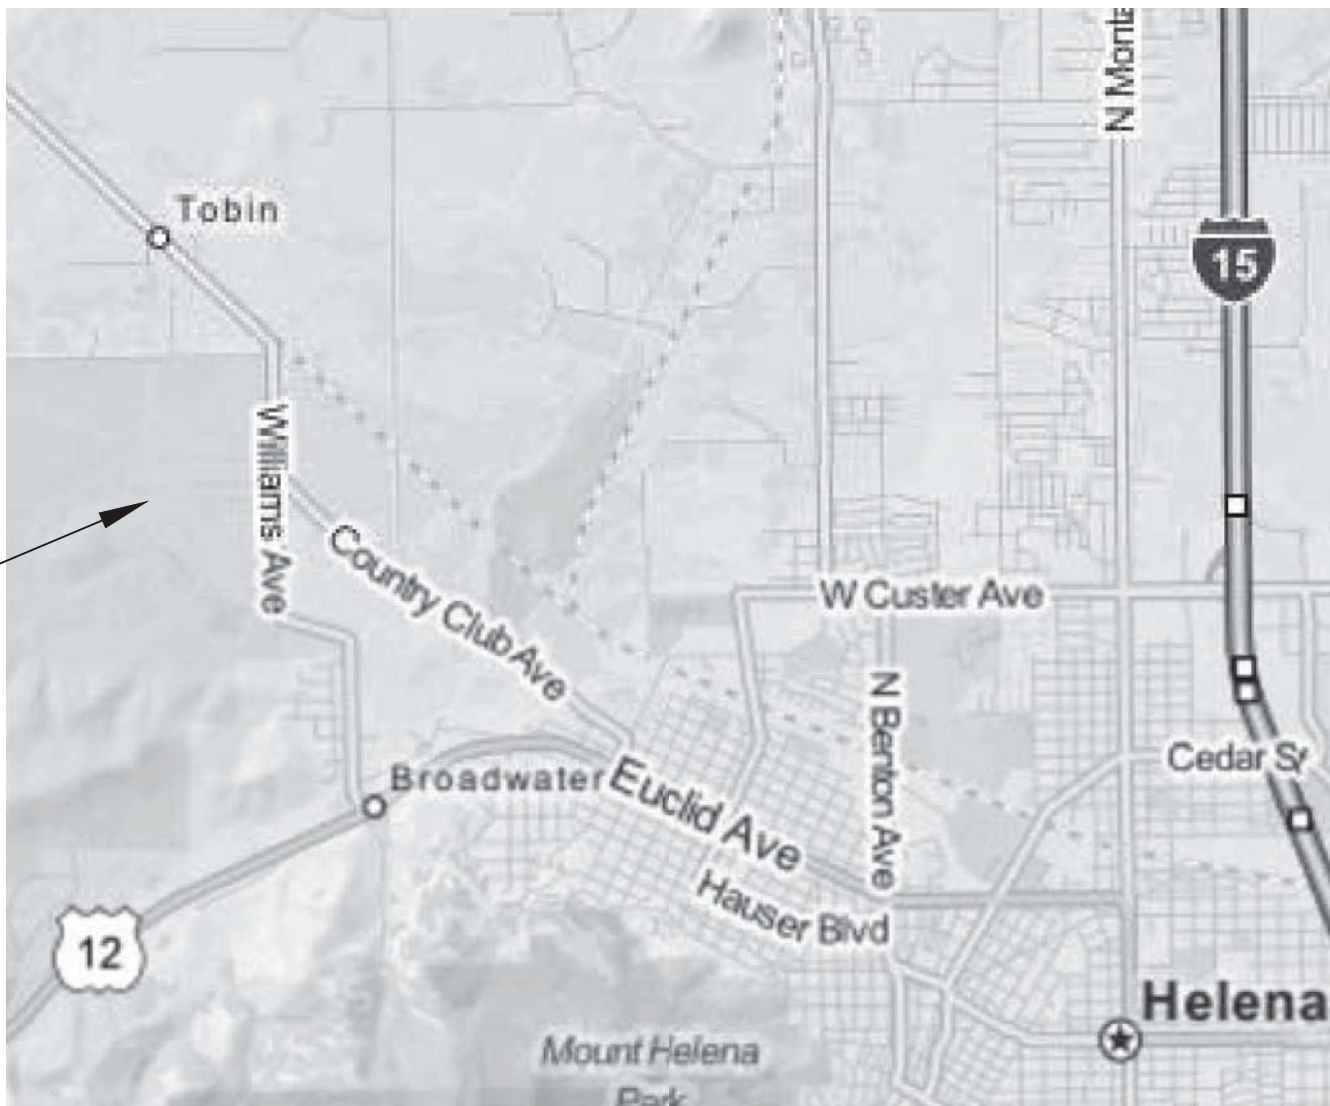

PROJECT LOCATION

AREA OF WAREHOUSE  
EXPANSION PROJECT

AREA OF CLINICAL  
EXPANSION PROJECT

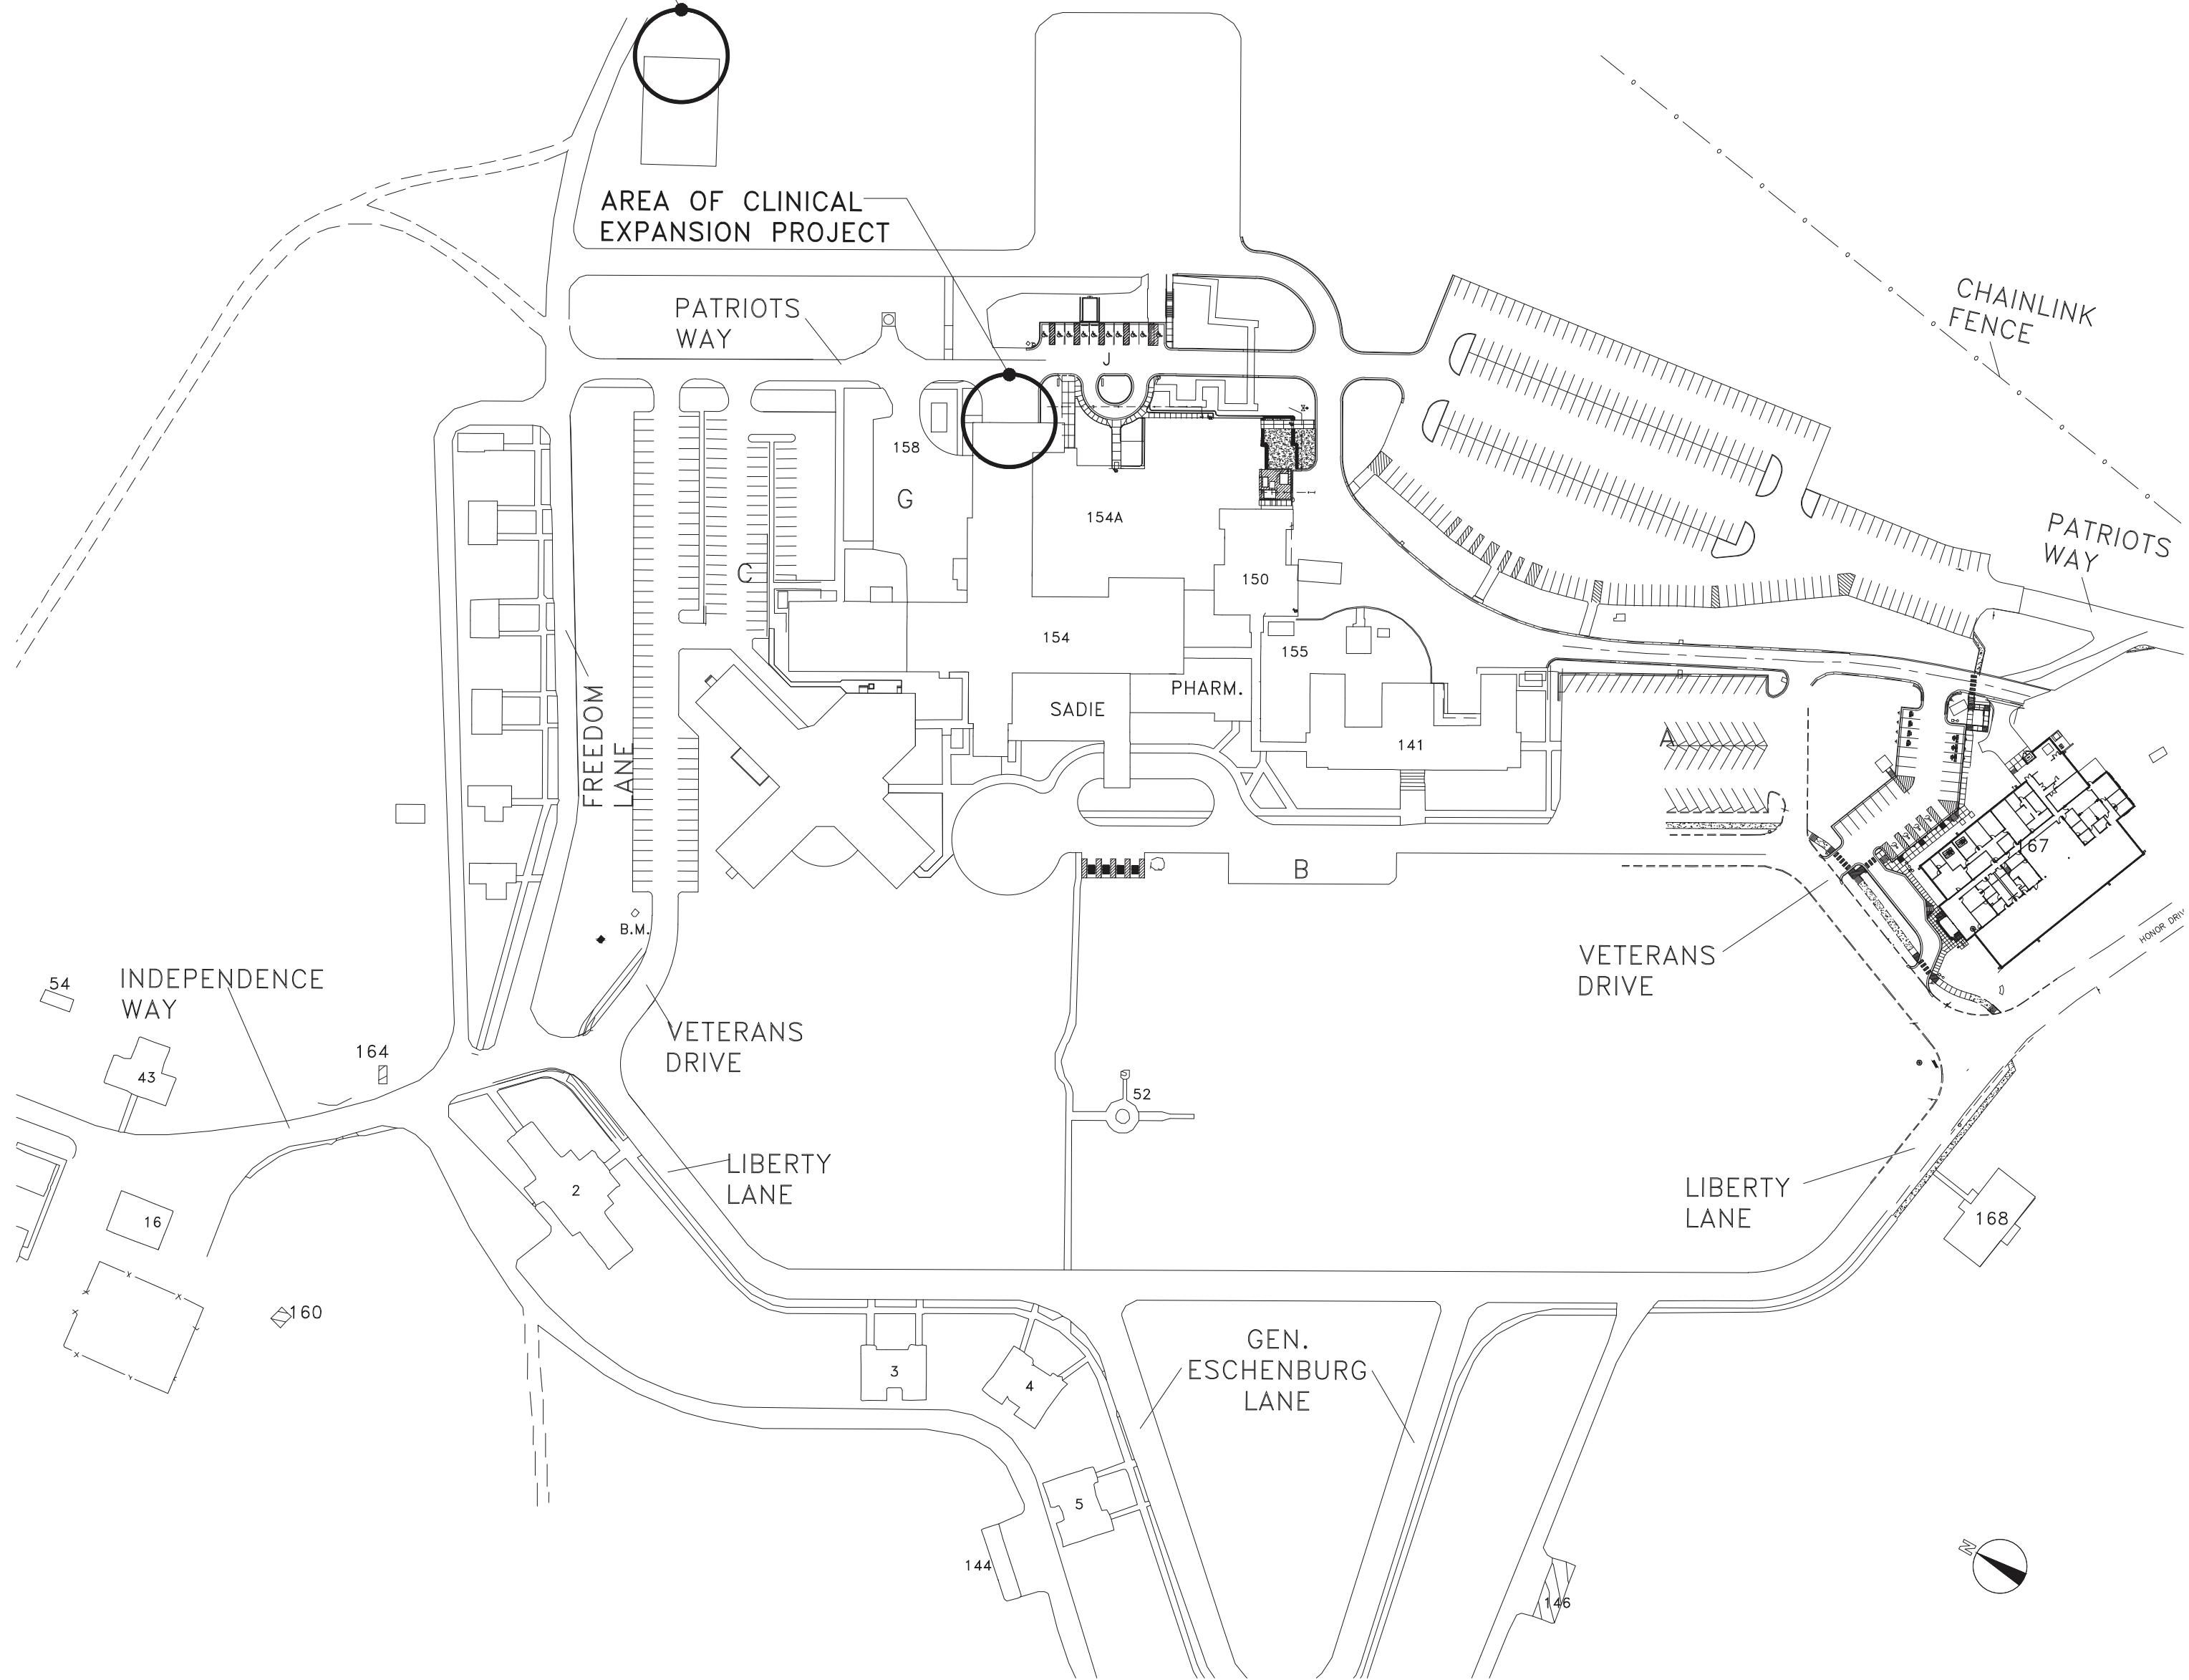

CONSULTANTS:

ARCHITECT/ENGINEERS:



Gray & Luckett  
Architecture and Engineering, PLLC  
A Service-Disabled Veteran-Owned Small Business  
1510 Wind River Drive, SE  
Huntsville, AL 35892-3939  
(256) 527-0342 (C)