


1 RISER DIAGRAM - EQUIPMENT BRANCH
SCHEMATIC

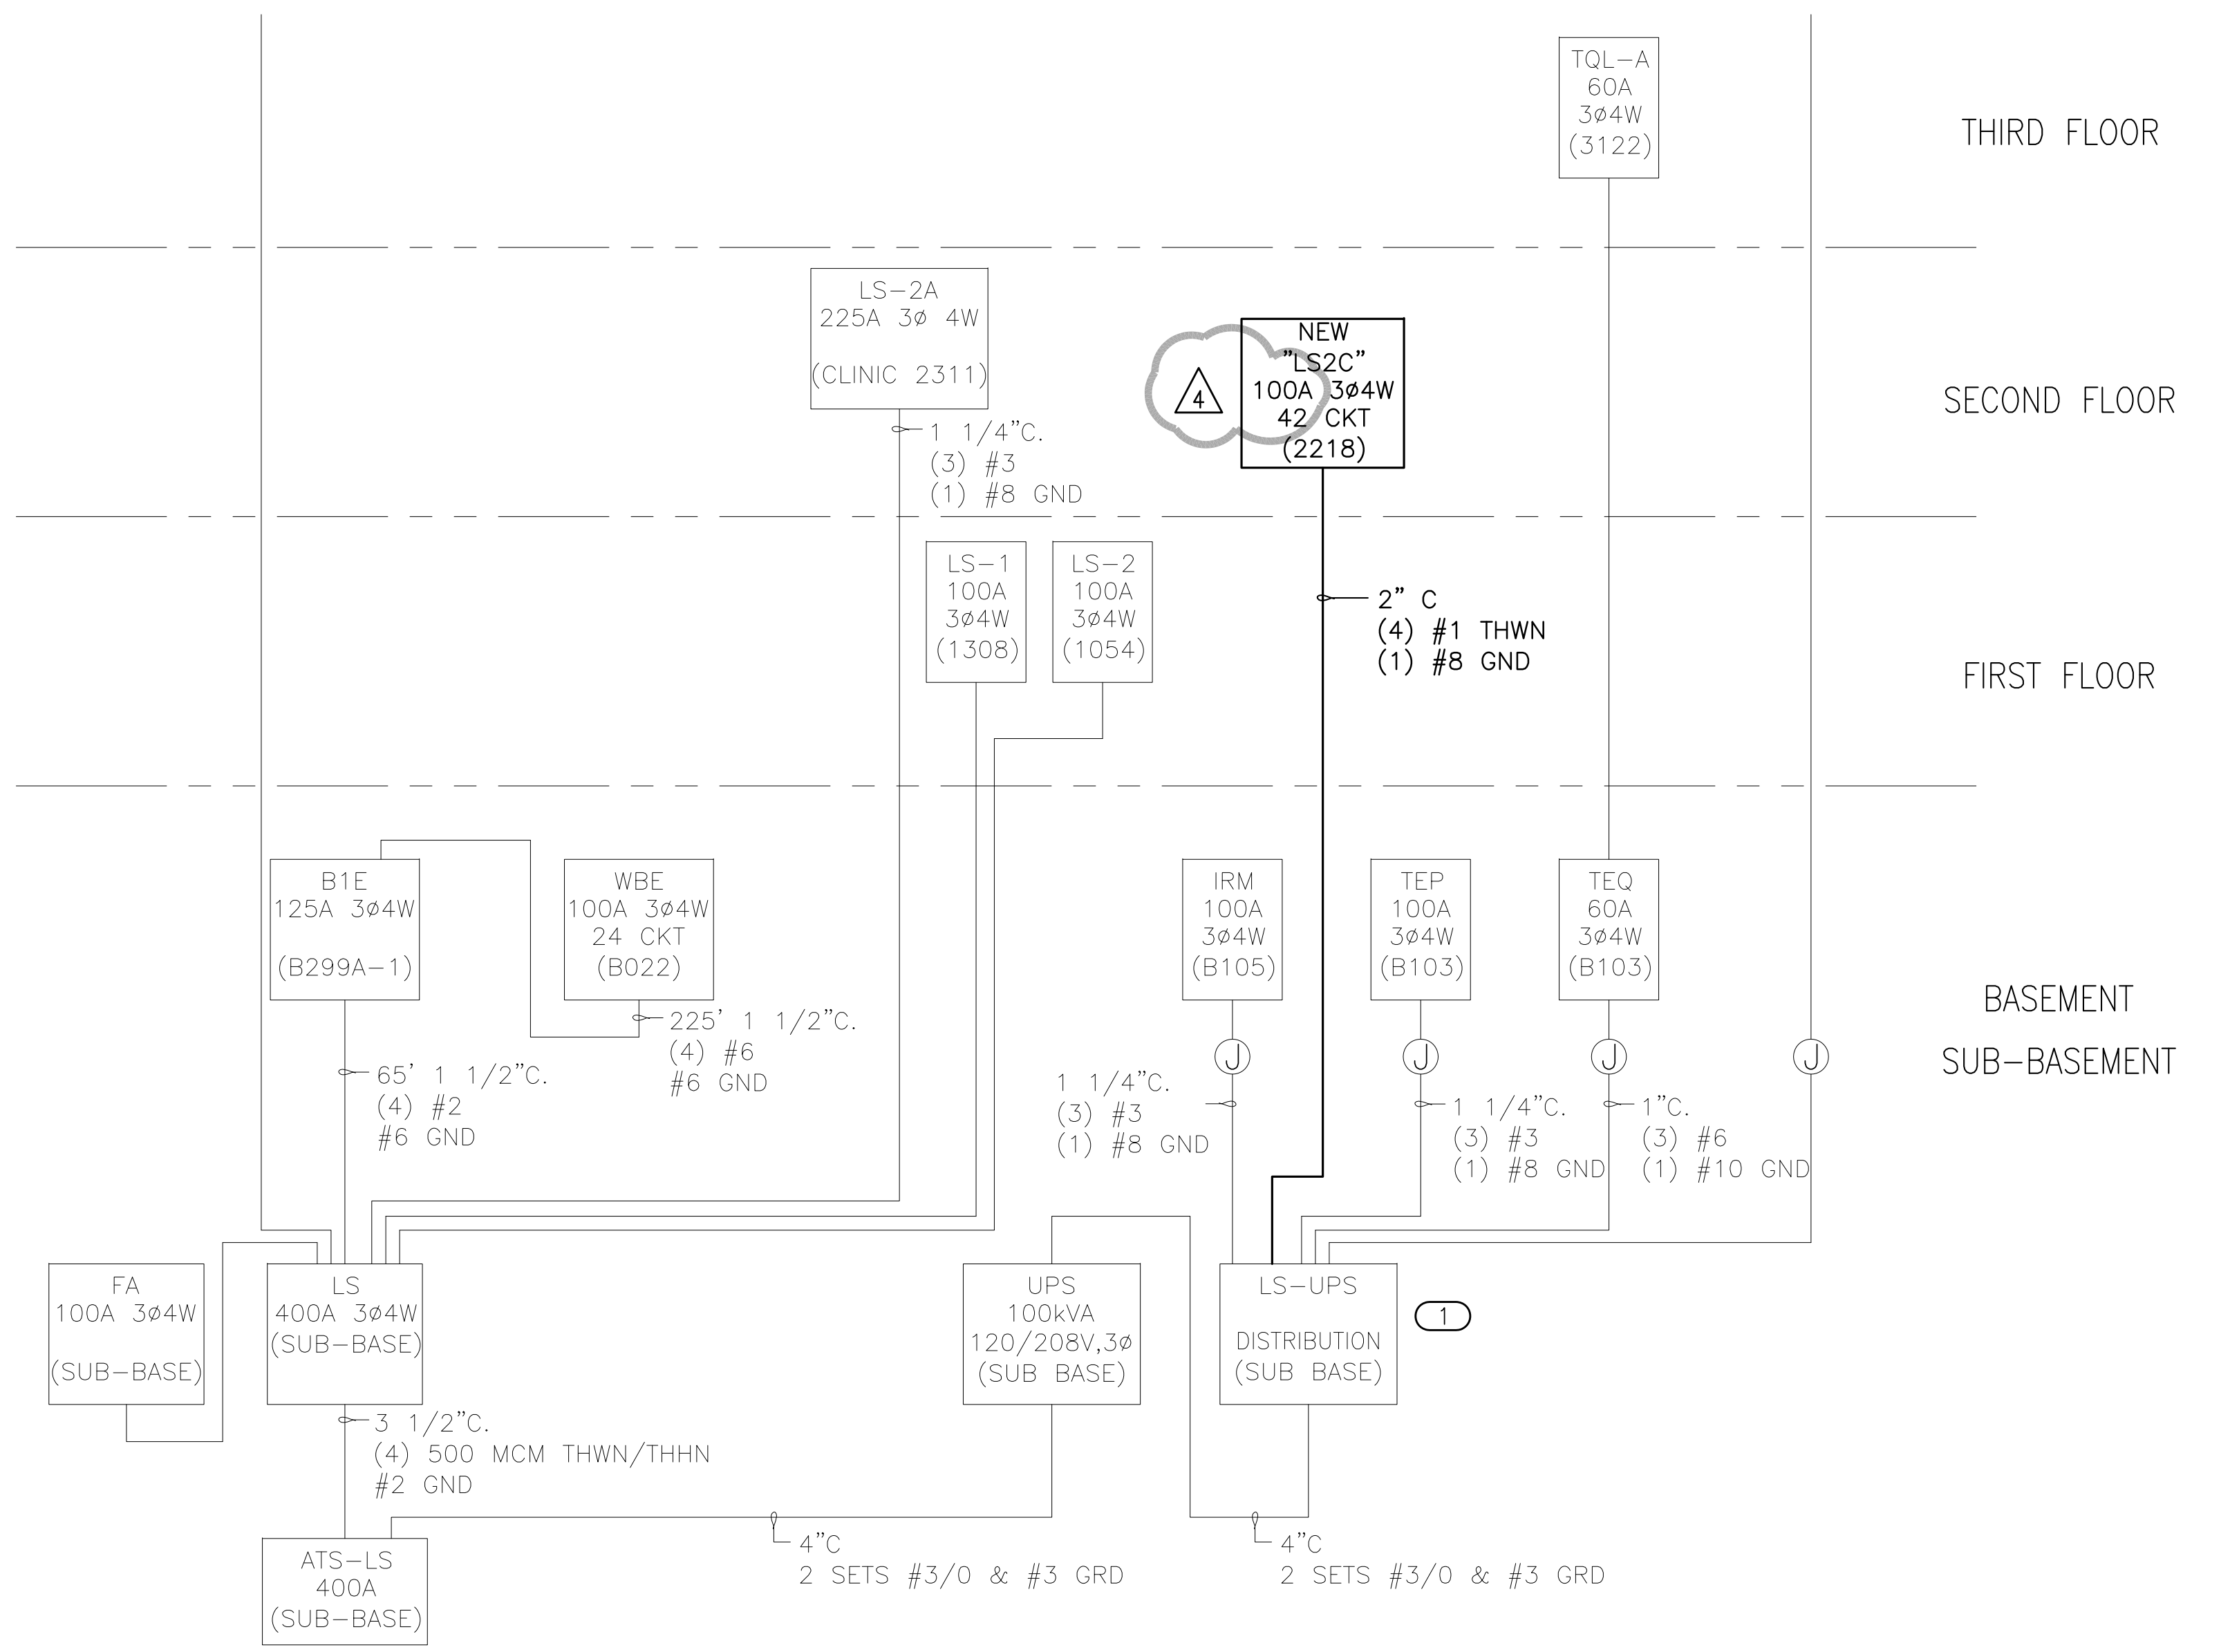

2 RISER DIAGRAM - LIFE SAFETY BRANCH
SCHEMATIC

KEYED NOTES		
1	PROVIDE NEW 100/3 BREAKER IN PANEL LS-UPS	
2	PROVIDE NEW 200/3 BREAKER IN PANEL EQ-5 (SQUARE D I-LINE).	

<div>ADDENDUM #411/03/2014</div> <div>ADDENDUM #210/27/2014</div> <div>100% Construction Documents7/15/2014</div> <div>Revisions:Date</div>	<div>CONSULTANTS:</div> <div><div><div>MEP ASSOCIATES, LLC</div><div>engineers consultants commissioning</div><div>MEP Associates, LLC 2720 Arbor Court Eau Claire, WI 54701</div><div>Phone: 715.832.5680 Fax: 715.832.5668 www.mepassociates.com</div><div>MEP PROJECT NO.: NW-12-05</div></div></div>	<div></div> <div>ARCHITECT/ENGINEERS:</div> <div><div>NORTHERN DESIGN WORKS</div><div>420 RAIL STREET</div><div>NEGAUNEE, MI 49866</div><div>PHONE: 906-475-6616</div><div>FAX: 906-475-6954</div><div>NDW PROJECT NUMBER: 1211</div></div>	<div>Drawing Title</div> <div>ELECTRICAL RISER DIAGRAM</div> <div>Approved: Project Director</div>	<div>Project Title</div> <div>EXPAND IMAGING</div> <div>Location</div> <div>IRON MOUNTAIN, MICHIGAN</div> <div>Date</div> <div>07/15/2014</div> <div>Checked</div> <div>SW</div> <div>Drawn</div> <div>LA</div>	<div>Project Number</div> <div>585-12-112</div> <div>Building Number</div> <div>1</div> <div>Drawing Number</div> <div>EY504</div> <div>Dwg. 111 of 121</div>	<div>Office of Construction and Facilities Management</div> <div>Department of Veterans Affairs</div>
---	--	---	--	---	---	---