


1 LEVEL 1 - AREA C1
1/4" = 1'-0"

NO	DESCRIPTION	DATE
0	100% SUBMITTAL	01/21/2014

ARCHITECTS/ENGINEERS:

Burns & McDonnell
SINCE 1898

9400 Ward Parkway
Kansas City, MO 64114
Phone: (816) 333-9400
Fax: (816) 822-3321
http://burnsmcd.com

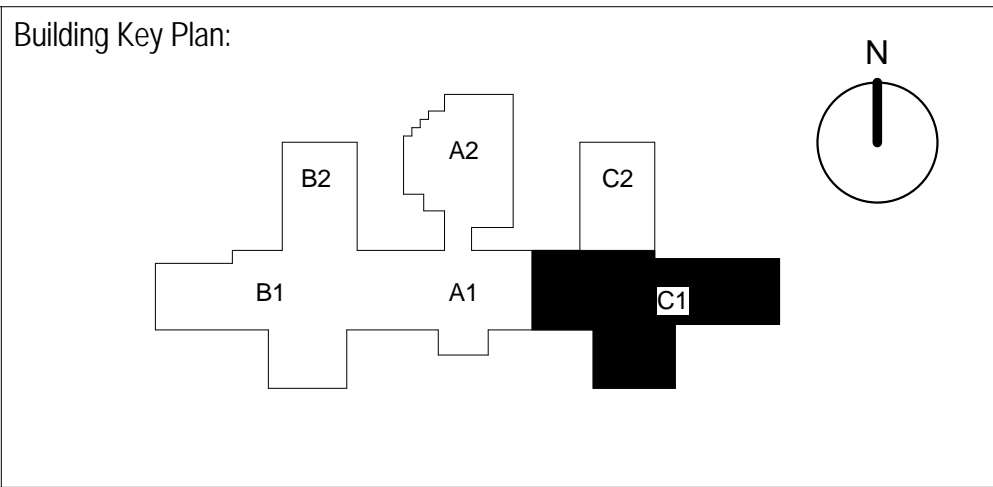

FACILITIES MANAGEMENT
FLOOR PLAN DRAWINGS

- FOR REFERENCE ONLY -
NOT FOR
CONSTRUCTION



**VA EASTERN KANSAS HEALTH
CARE SYSTEM**

Dwight D. Eisenhower VA Medical Center, Leavenworth
Colmery-O'Neil VA Medical Center, Topeka

Drawing Title:
LEVEL 1 - AREA C1

Scale:
1/4" = 1'-0"

Approved:

Project Title:
**VA RTLS
MENTAL HEALTH Svc.
GEROPSYCHIATRIC NURSING HOME**

Building Number:
4

Checked By:
AS

Drawn By:
TC

Location:
Colmery-O'Neil VA Medical Center,
Topeka

Date:
01/21/2014

Project No.
74344

Drawing No.
AE214

Dwg. Of

Department of
Veterans Affairs