

V/A B86 VCS STORE/OT HVAC REMODEL

HEALTHCARE
SYSTEM



SEPTEMBER 05, 2014

SHEET INDEX

SEPTEMBER 05, 2014
















SHEET INDEX

COVER AREA AND SITE MAPS AND SHEET INDEX
M1 – BASEMENT HVAC PIPING PLAN, DETAILS AND SCHEDULES
M2 – FIRST FLOOR HVAC PIPING PLAN

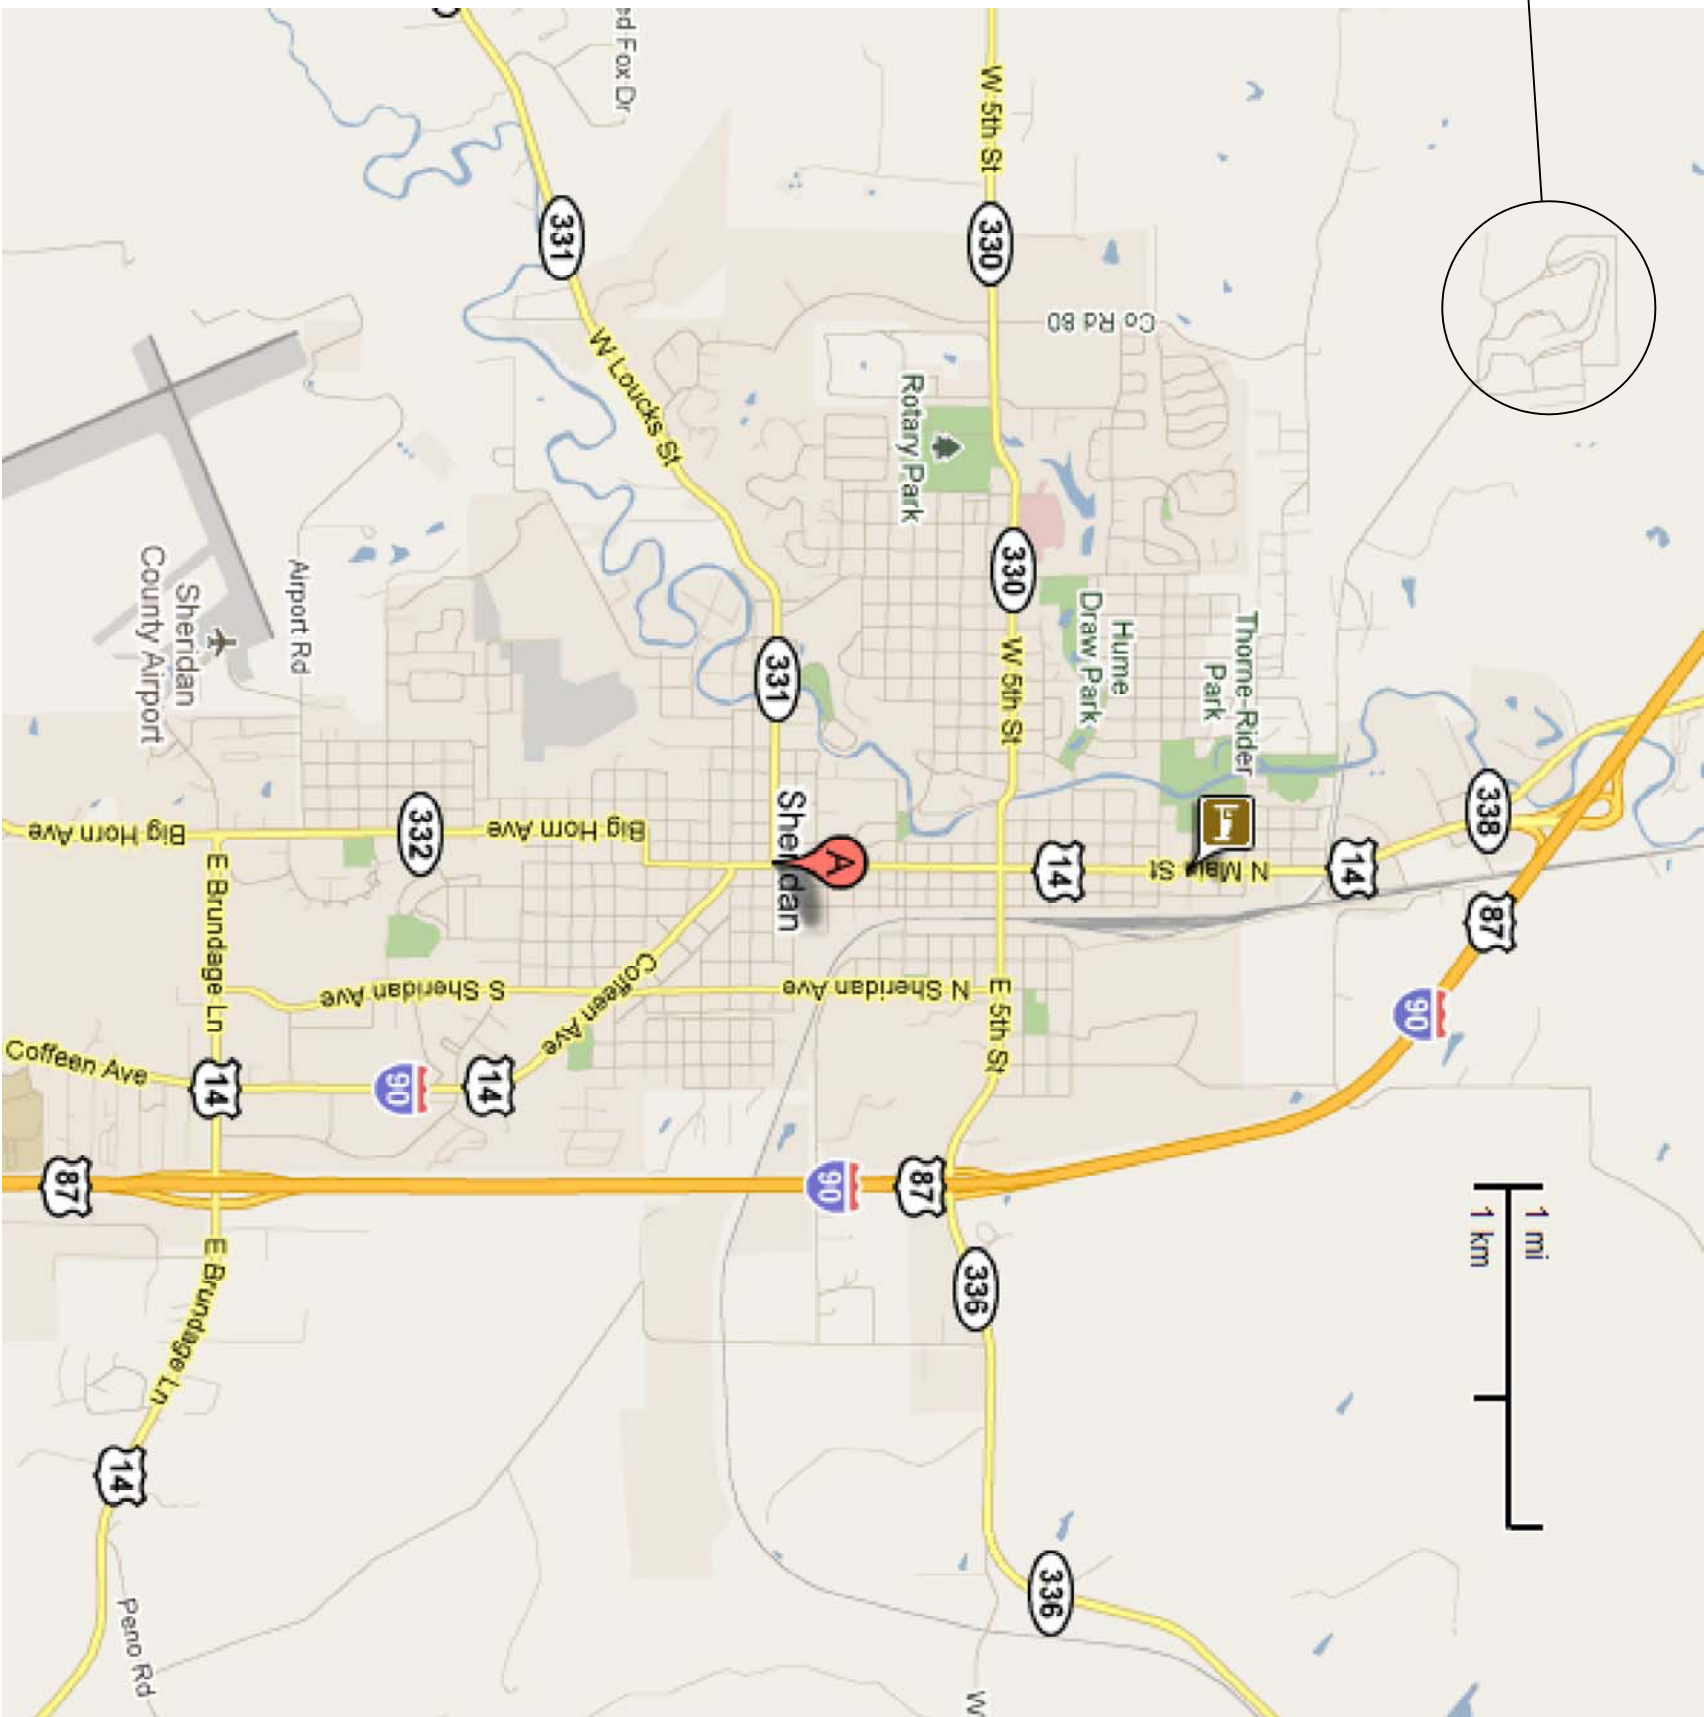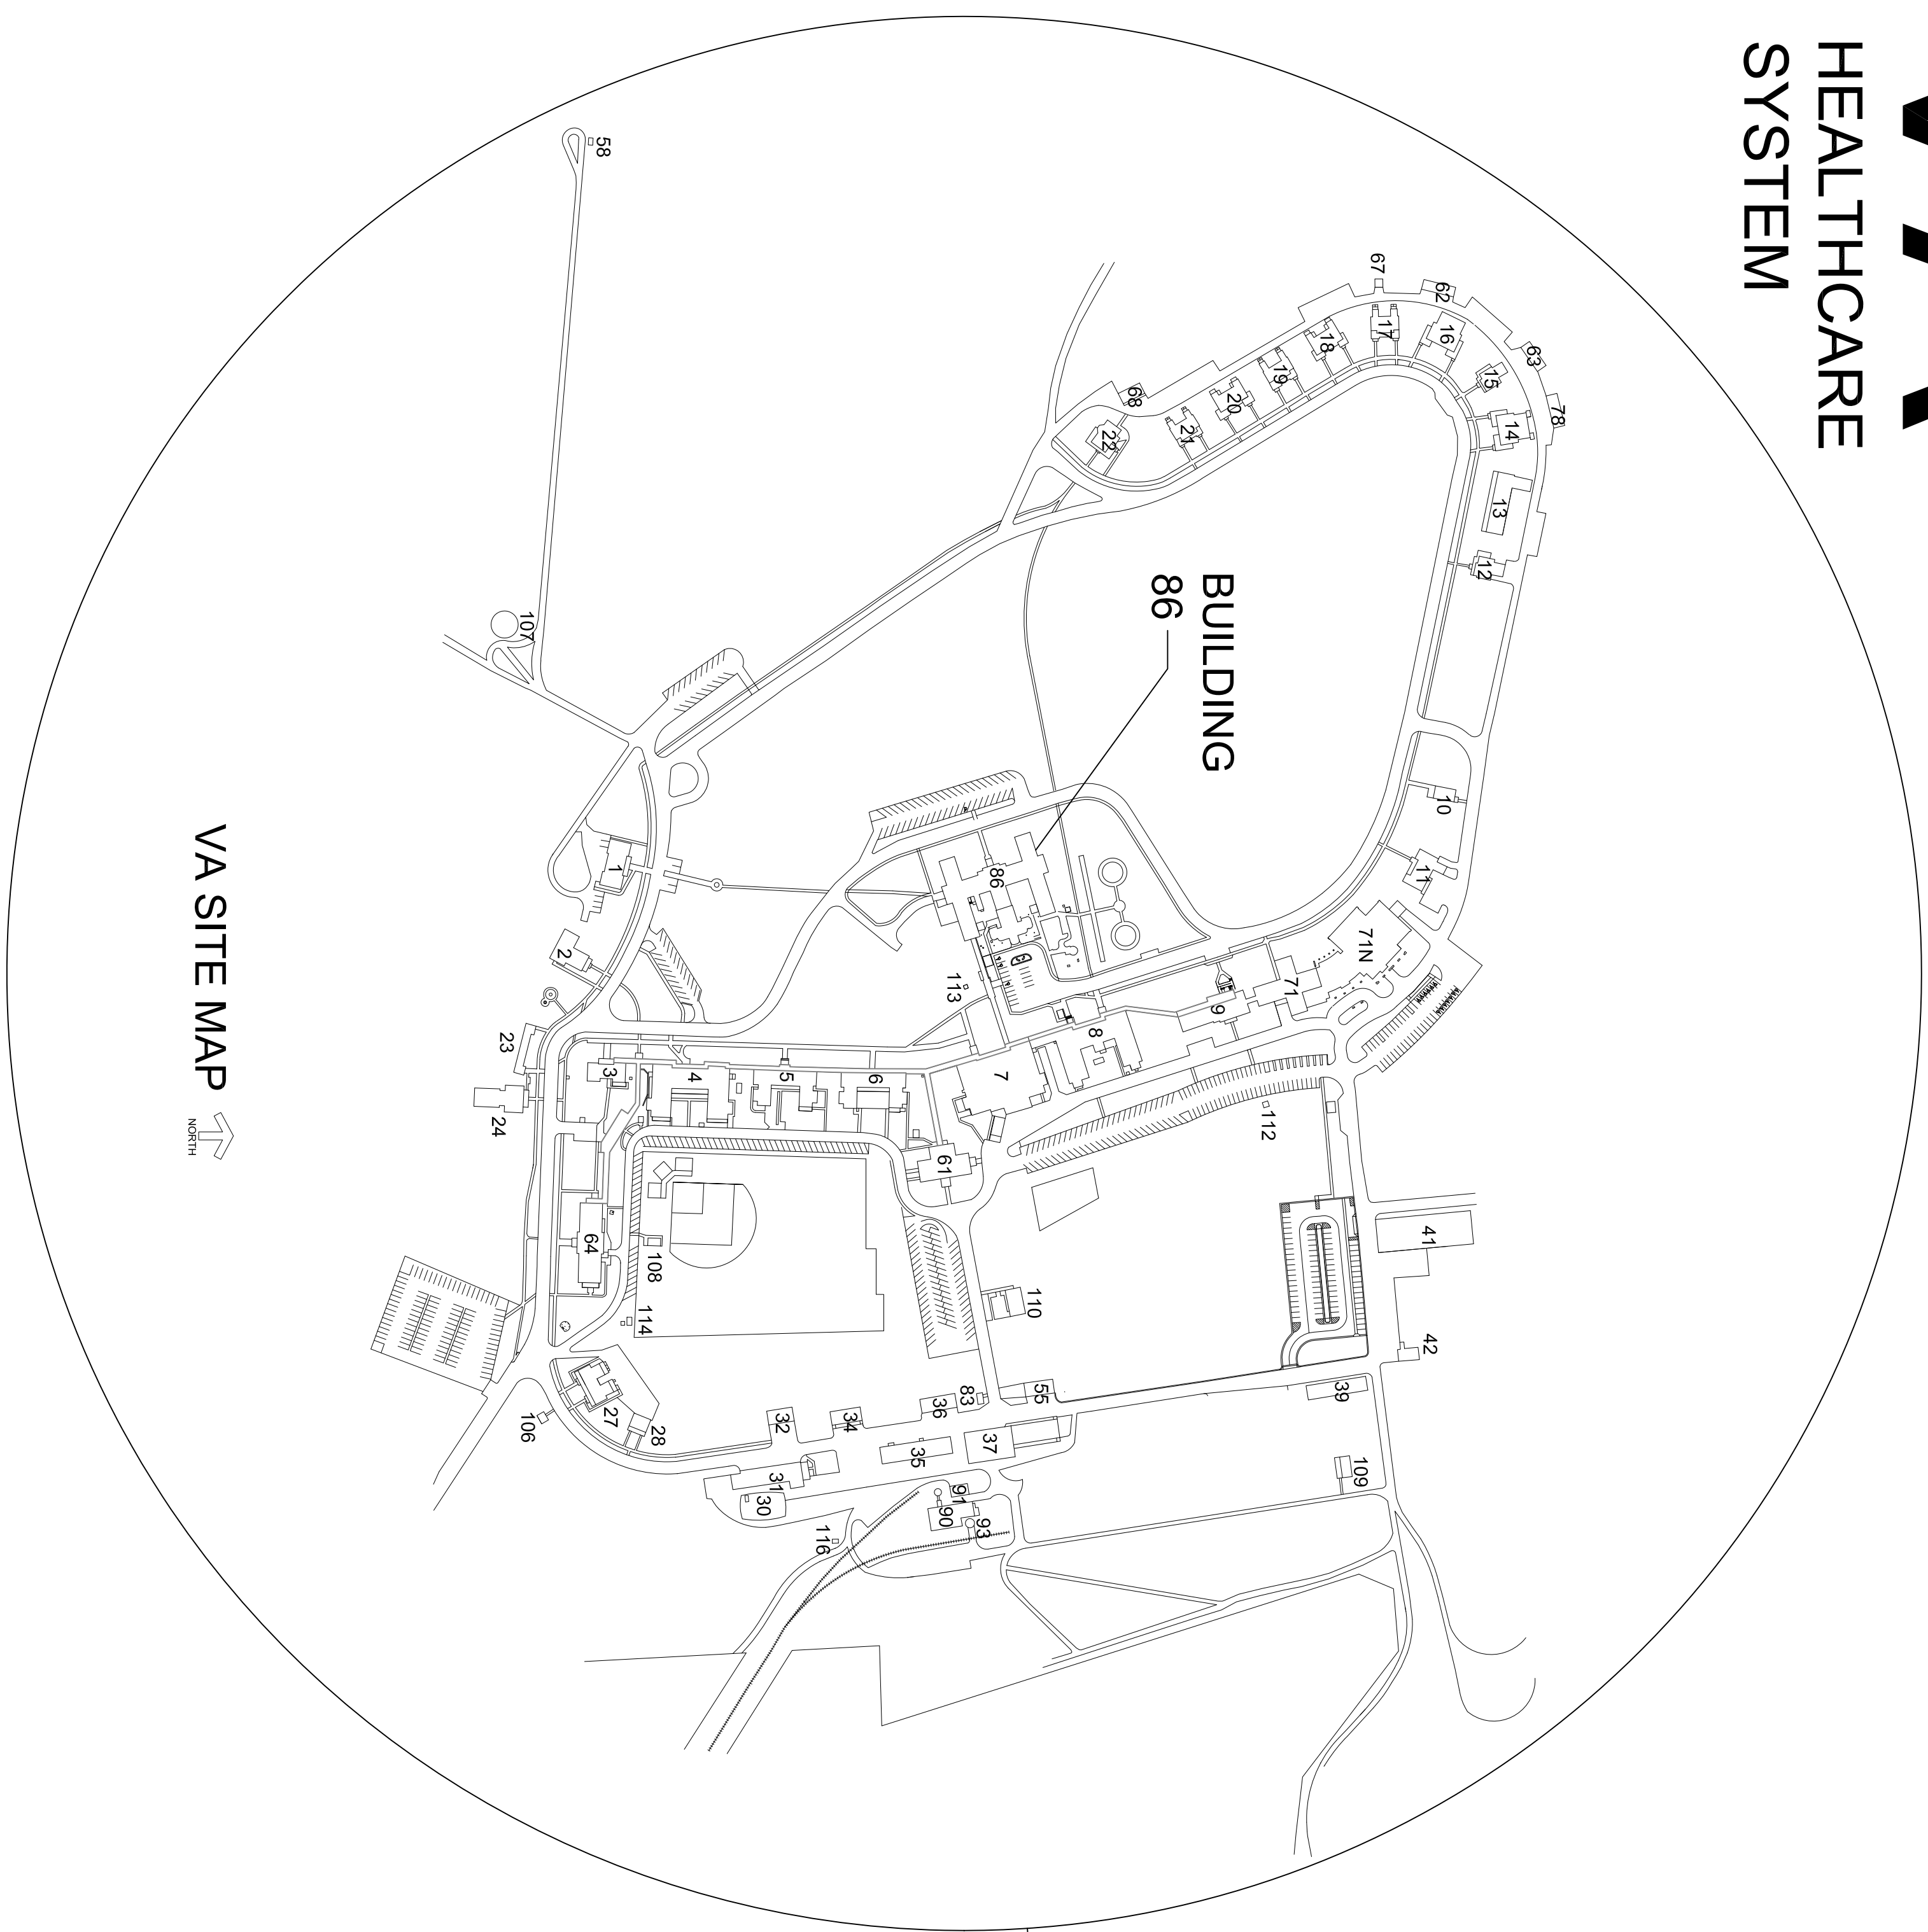

AREA MAP

[illegible]

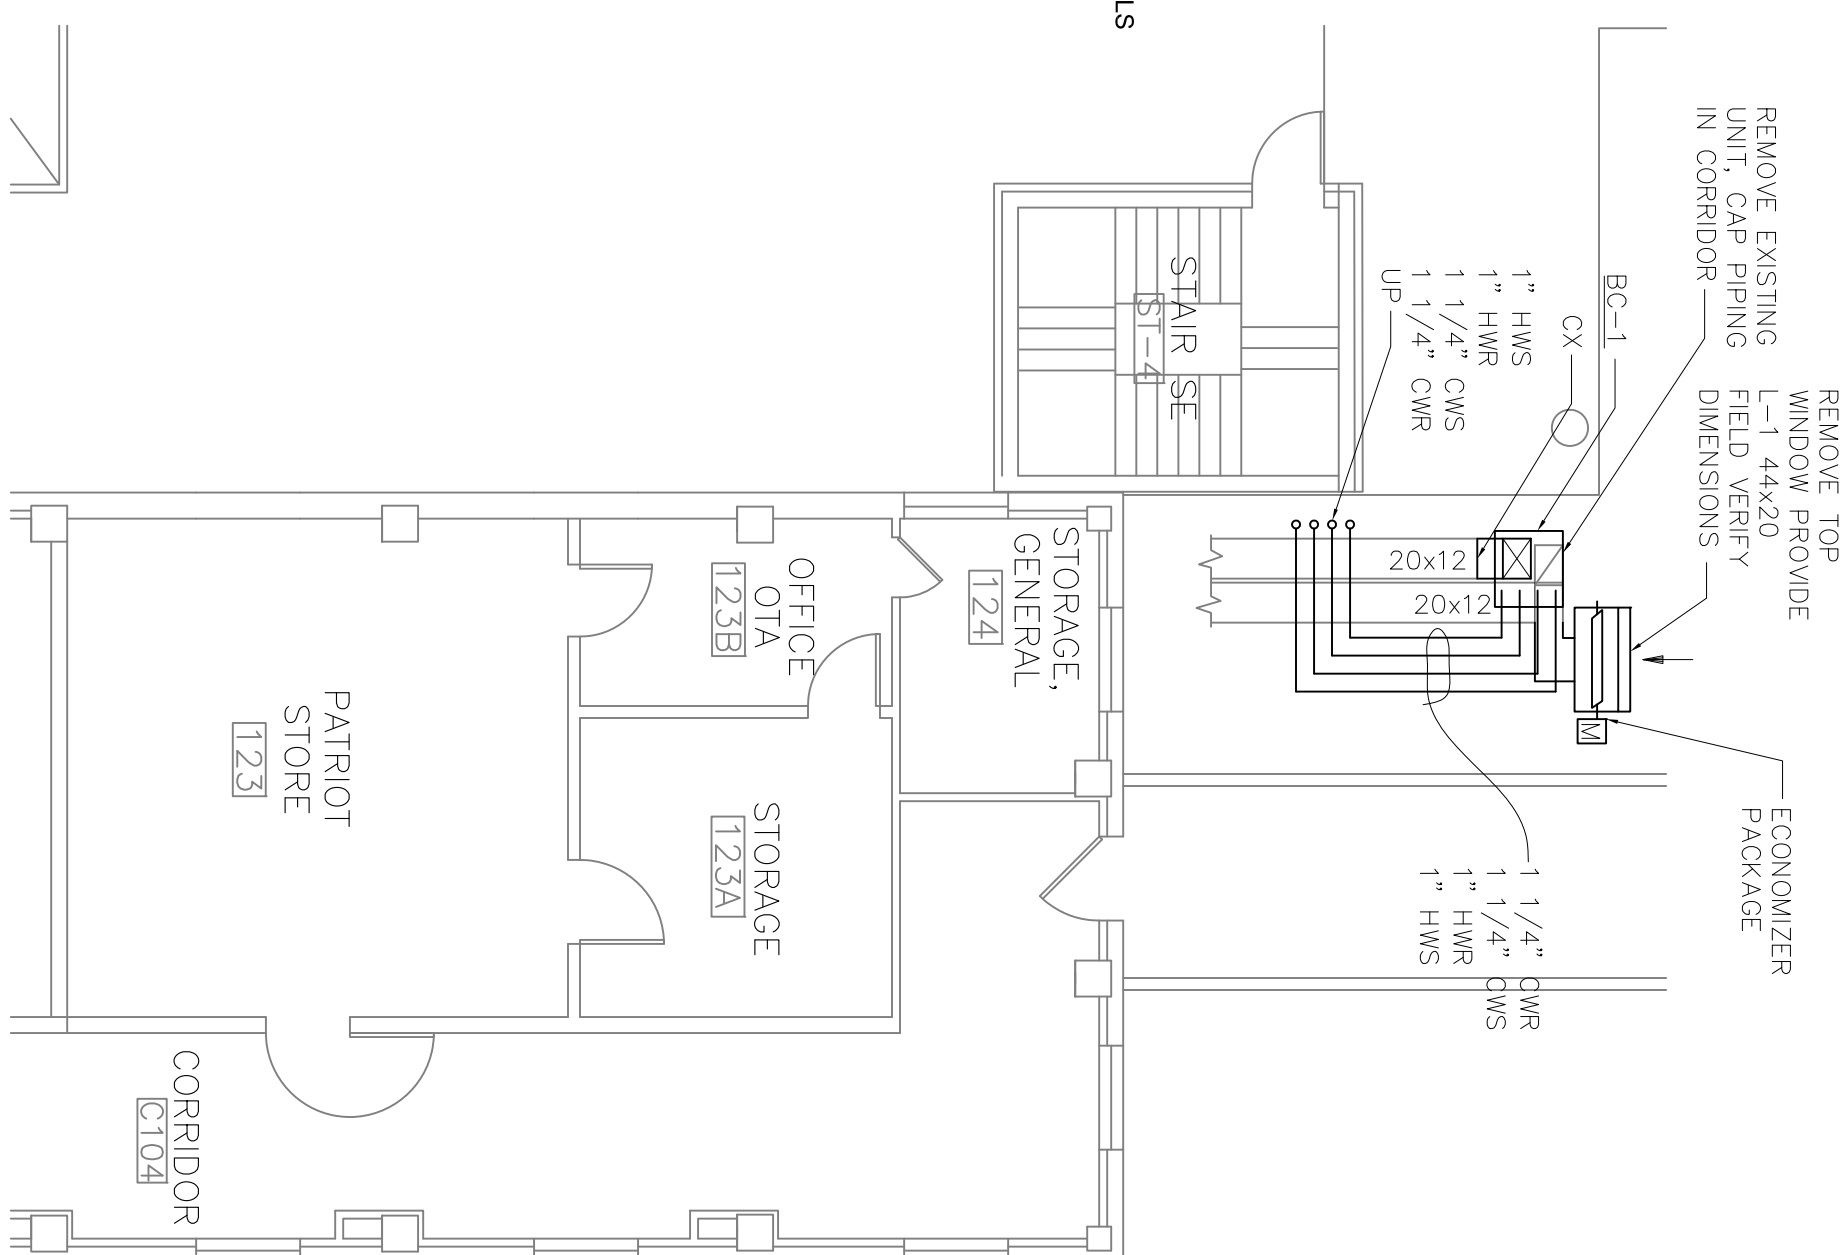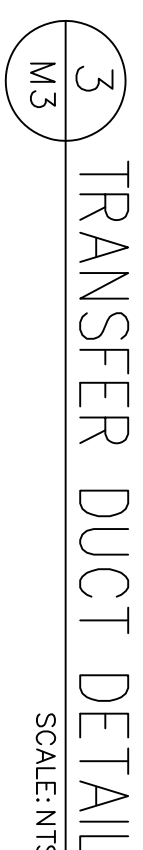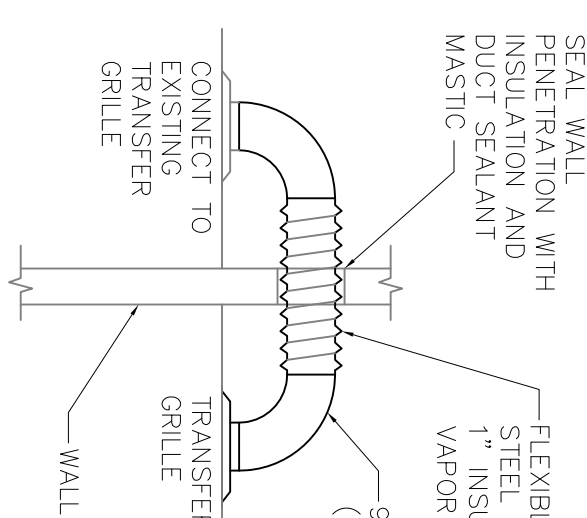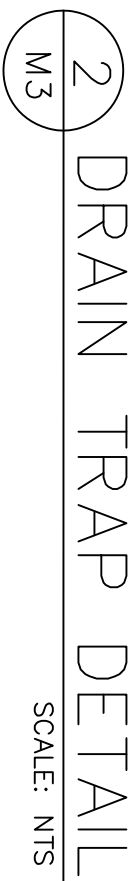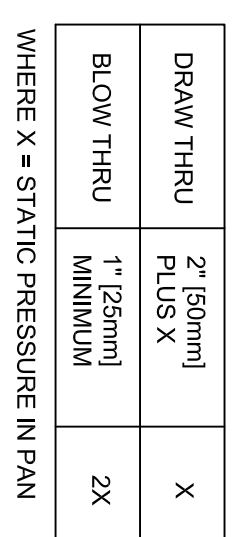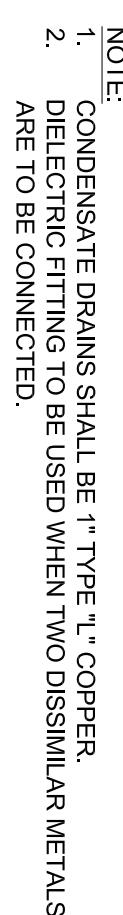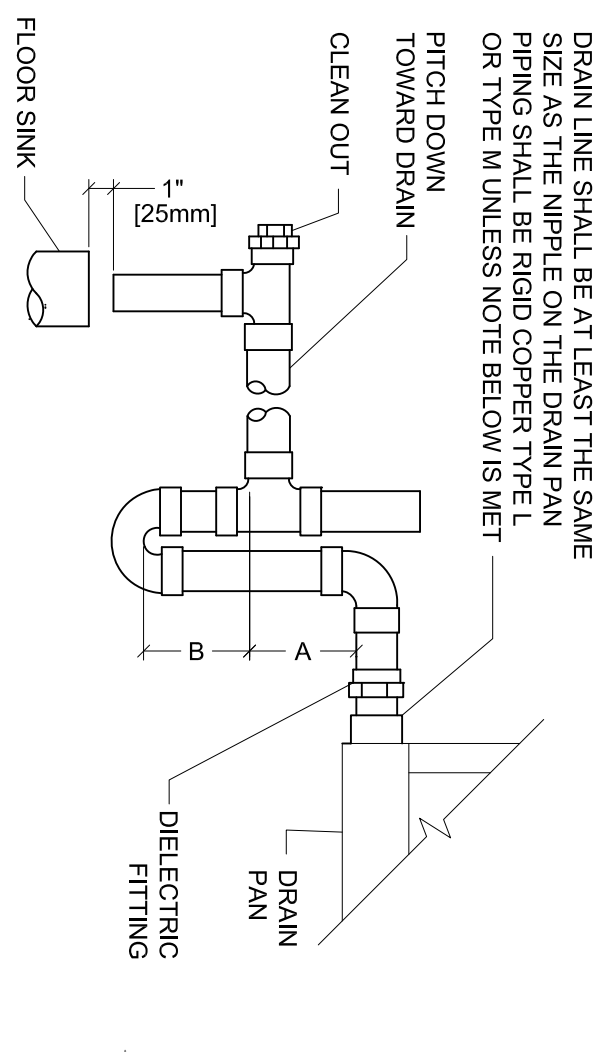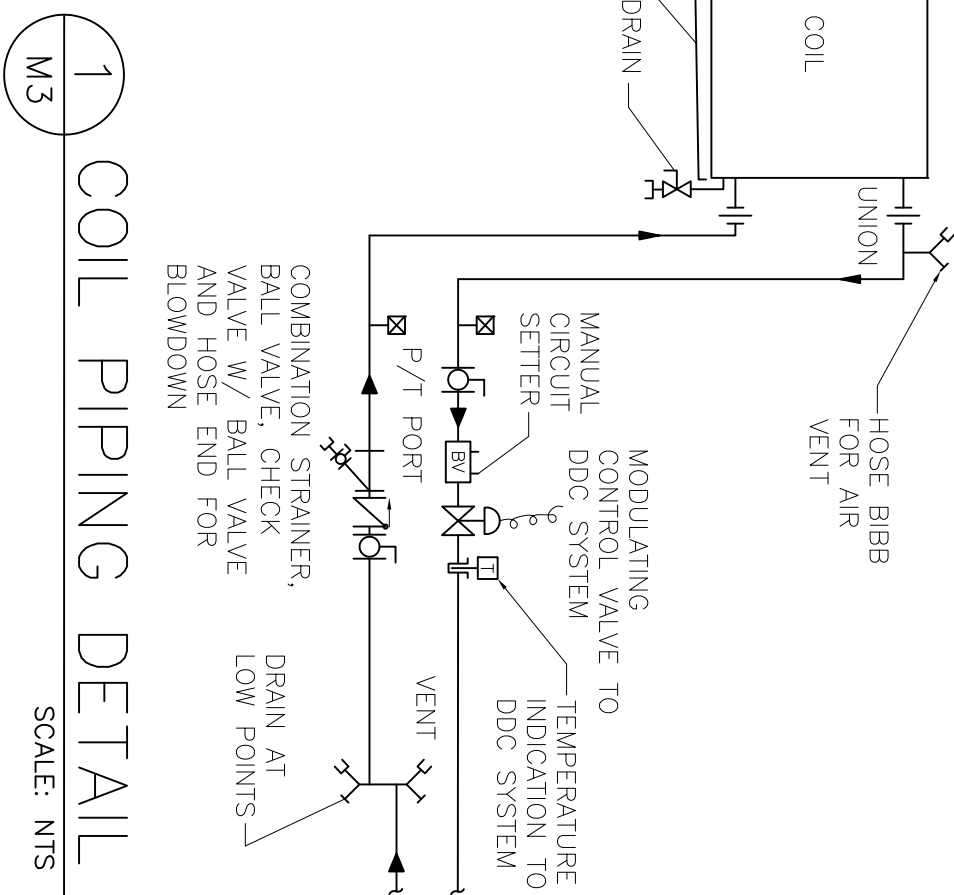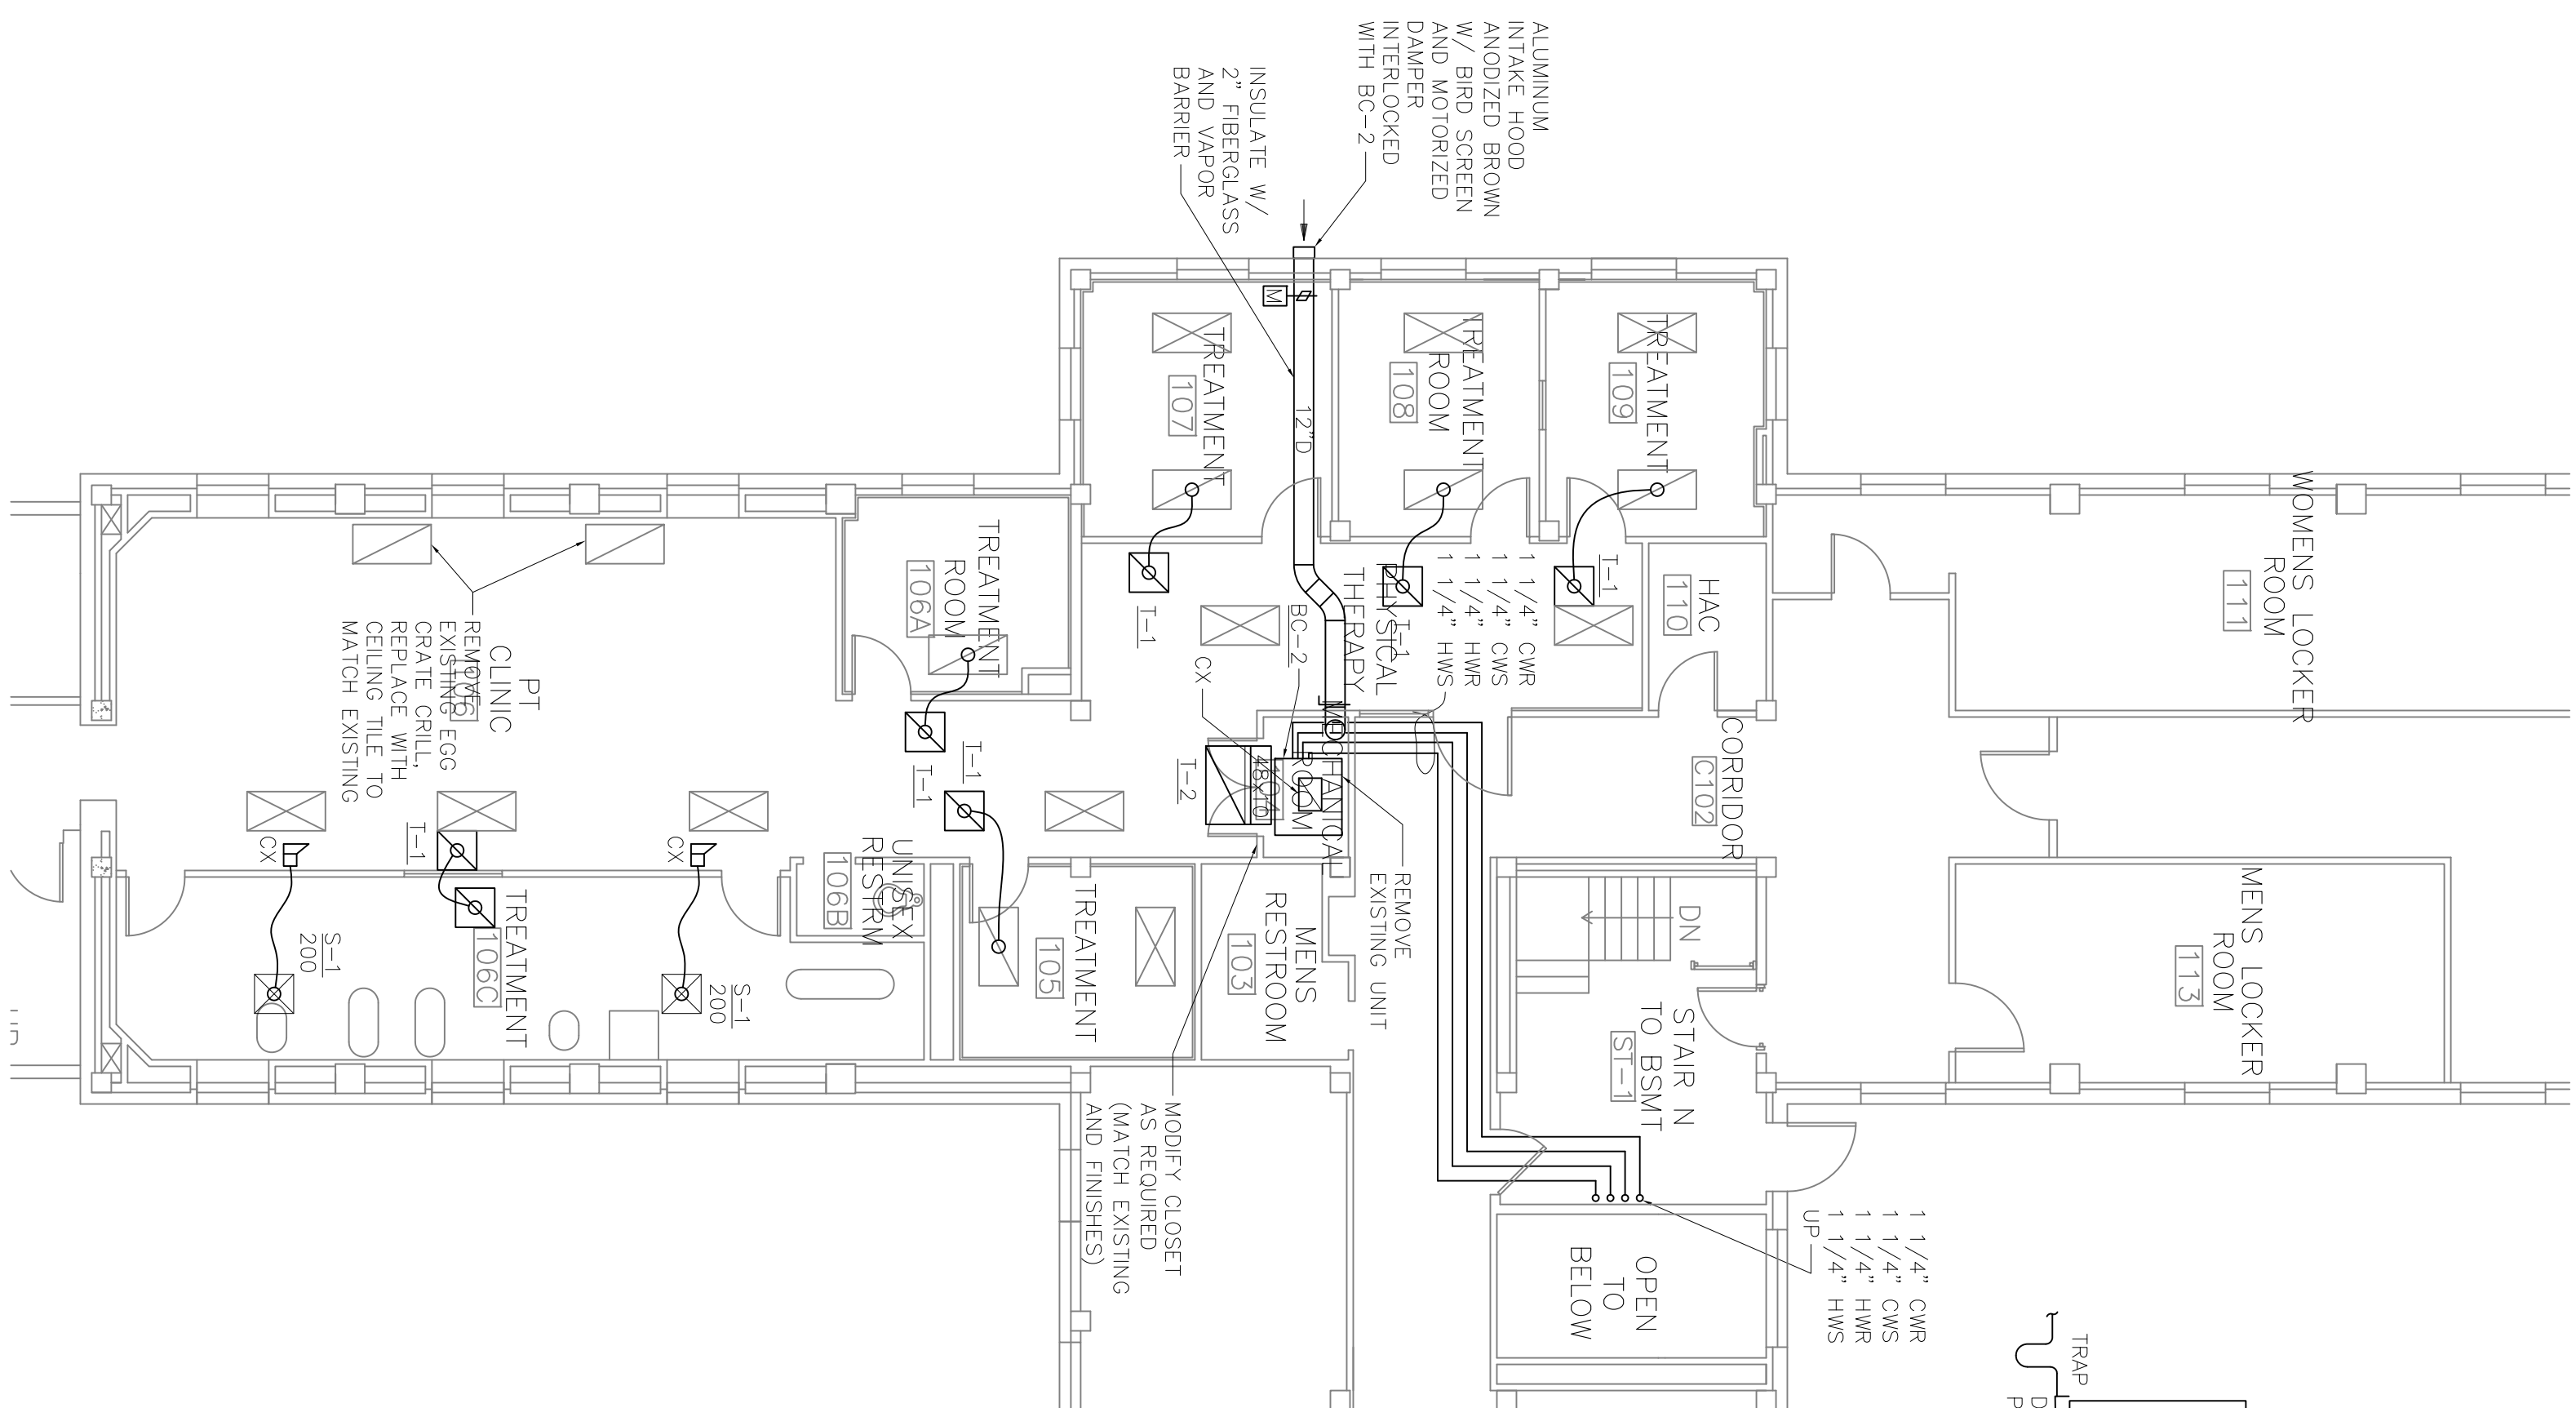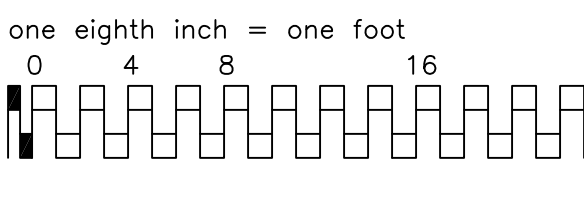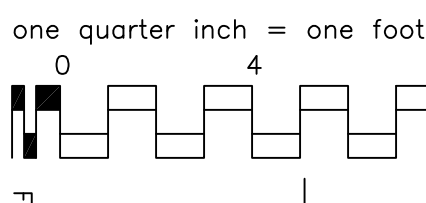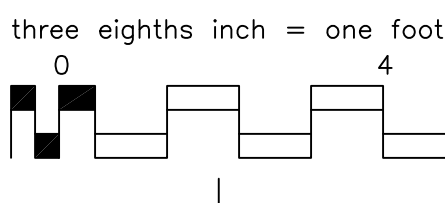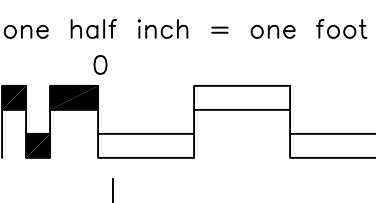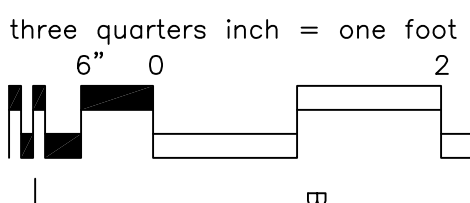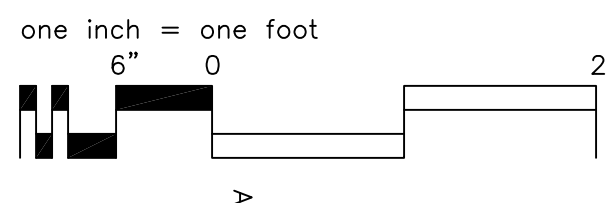



UPFLOW VERTICAL BLOWER COIL SCHEDULE																
TAG	MFCR.	MODEL	COOLING				HEATING				POWER	MCA	MOCF	NOTES		
			CFM	BTUH	GPM	EWT	LWT	CFM	BTUH	GPM					EWT	LWT
BC-1	TRANE	UCCAO03A	1,560	33,000	7	45	55	1,275	51,000	5	180	152	208/60/3	9.13	15	1.2,3.4
BC-2	TRANE	UCCAO06A	2,640	53,000	12	45	55	2,225	89,000	9	180	158	208/60/3	9.13	15	1.2,3.4

- 1) CONTROL SHALL BAY ROOM TEMPERATURE SENSOR AND TRANE TRACER FRONT END. PROVIDE ECONOMIZER CONTROLS ON B-C-1.
- 2) COOLING WATER SHALL BE 25% PROPYLENE GLYCOL
- 3) HEATING WATER SHALL BE 30% PROPYLENE GLYCOL
- 4) PROVIDE REMOTE 2" FILTER BOX WITH SEALED, MINVED, LATCHING COVER.
B-1=24x20 MIN., B-2=24x32 MIN. PROVIDE MERV 8 FILTERS.

LOUVER SCHEDULE

DIFFUSER AND GRILLE SCHEDULE

Project Number 666-15-03S		Building Number 86		Office of Facilities Management VA Department of Veterans Affairs Seaside
Project Title B86 VCS STORE / PT		Drawing Number M1		
Architect/Engineers:		Drawing Title BASEMENT FLOOR HVAC REMODEL PLAN		
CONSULTANTS:		Approved Project Director SEAN SALTZMAN		
Location SHERIDAN, WY		Checked WELTY	Drawn LAS	Date SEP 05, 2014
Drawing Number M1		Dwg 2 of 3		
Revisions:		Initials		Date

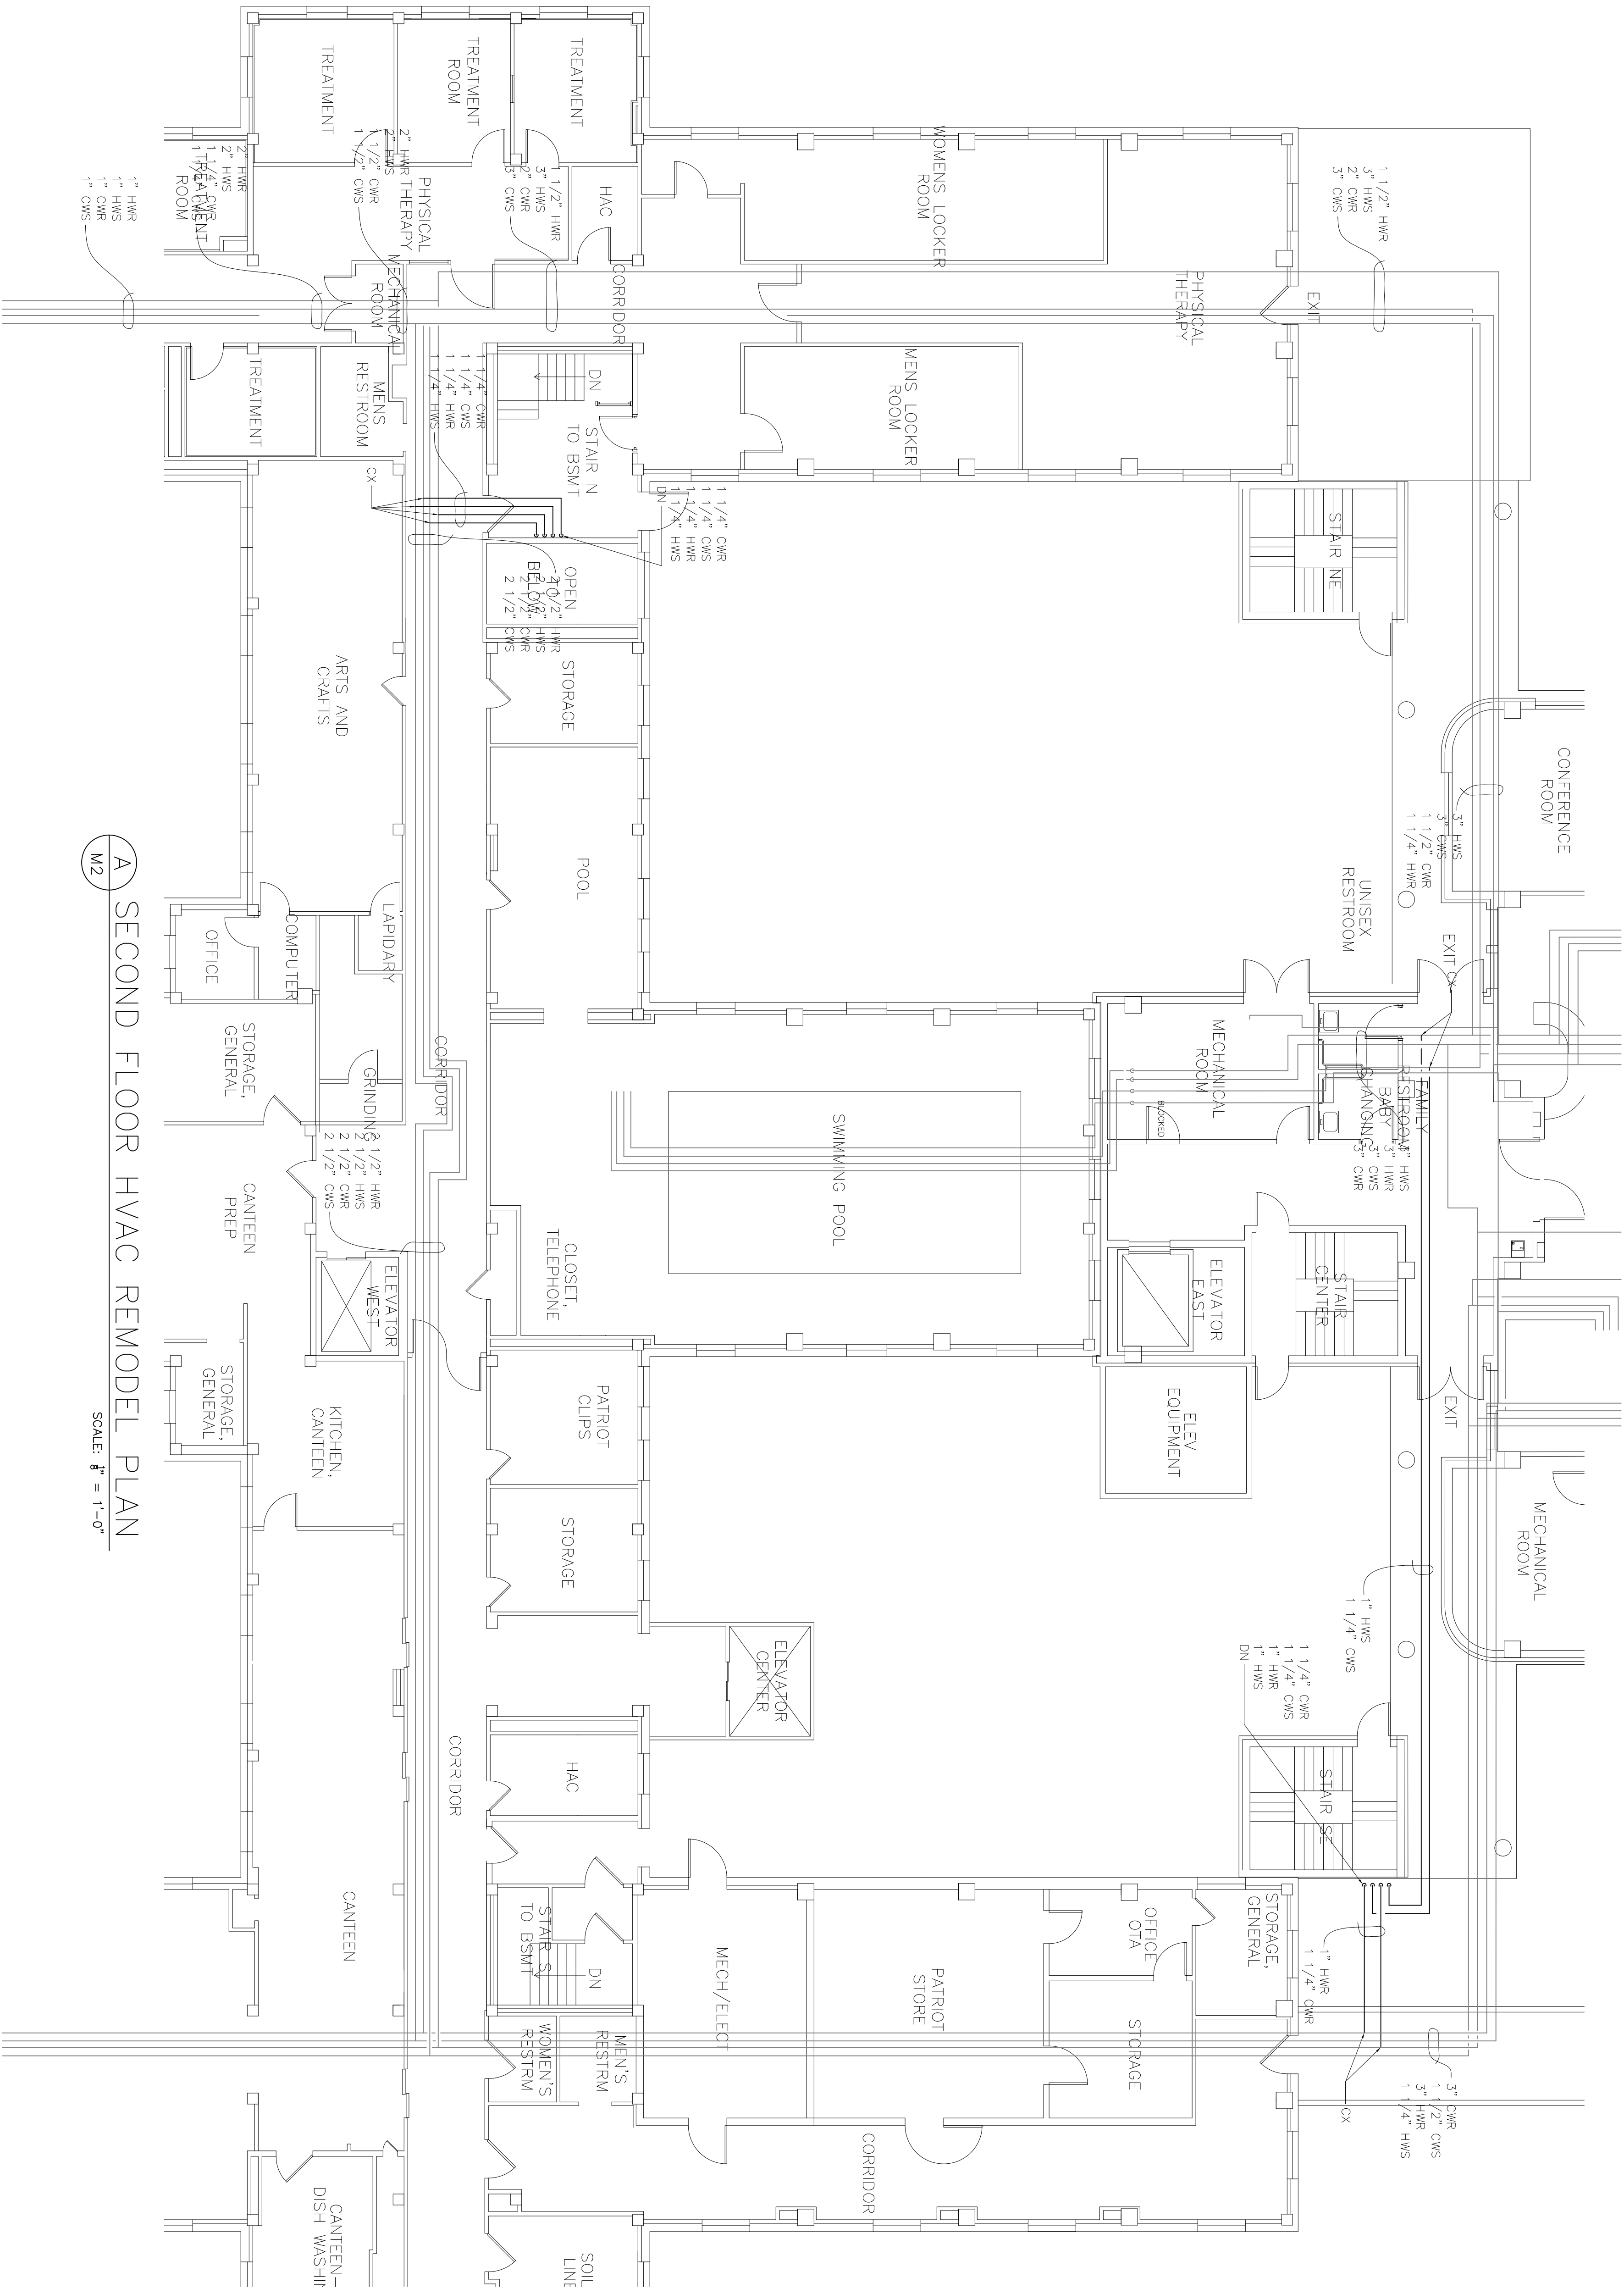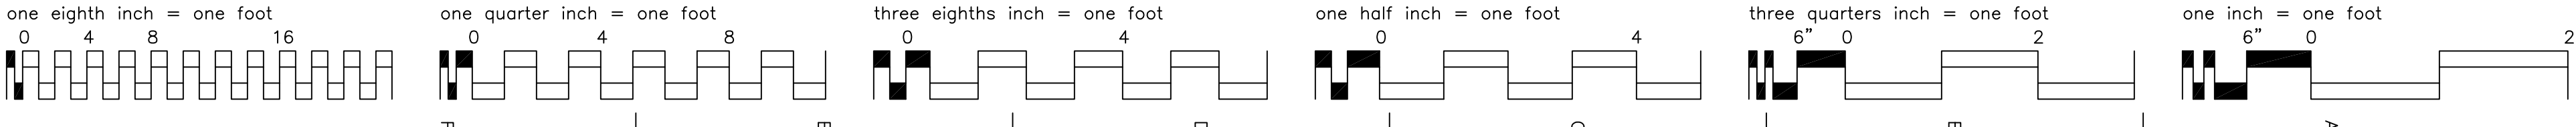

A SECOND FLOOR HVAC REMODEL PLAN
M2

SCALE: 1/8" = 1'-0"

Revisions:		Initials		Date	
CONSULTANTS:					
ARCHITECT/ENGINEERS:					
Drawing Title			Project Title		
1ST FLOOR HVAC REMODEL PLAN			B86 VCS STORE / PT HVAC REMODEL		
Approved Project Director			Location		
SEAN SALTZMAN			SHERIDAN, WY		
Date			Checked		
SEP 05, 2014			WELTY		
Drawn			LAS		
Dwg. 3 of 3			Drawing Number		
M2			666-15-03S		
Building Number			86		
Office of Facilities Management			V/A Department of Veterans Affairs		