


CONSTRUCT BACKUP WATER SYSTEM


PROJECT 589A7-12-127

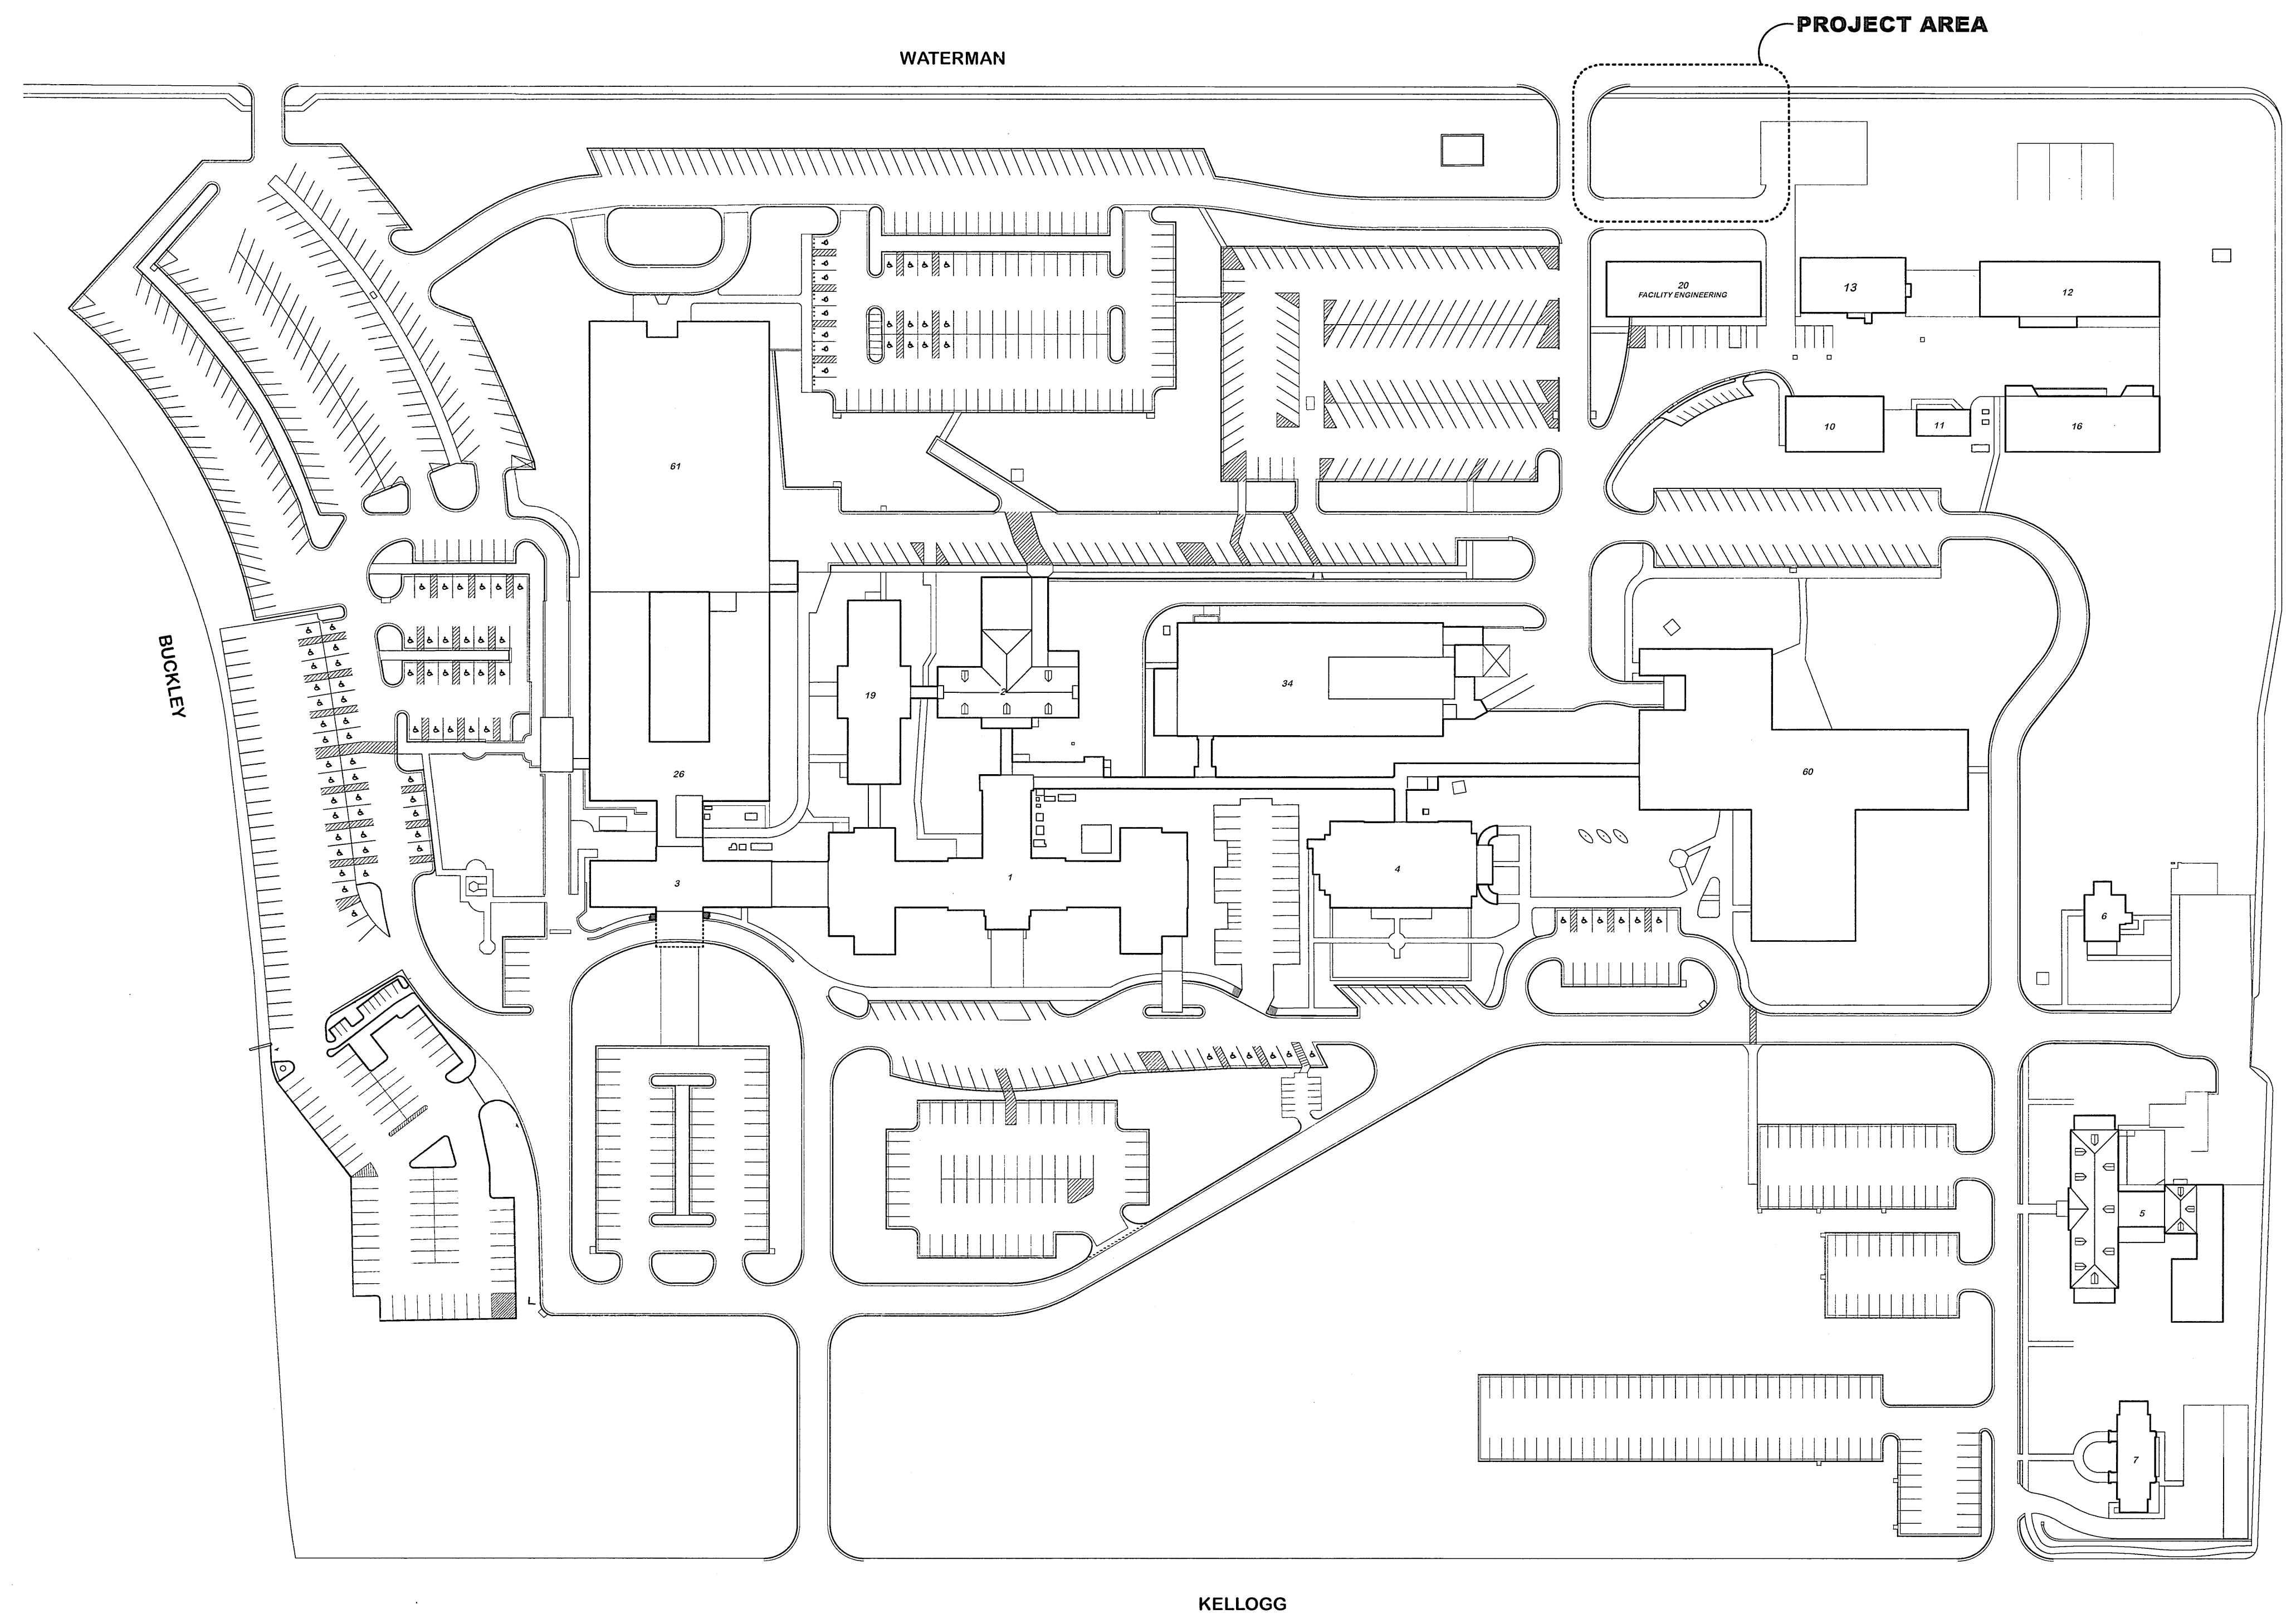

WICHITA VAM&ROC CAMPUS PLAN

SHEET INDEX

G100	TITLE SHEET, CAMPUS PLAN, GENERAL NOTES
C100	SITE LAYOUT PLAN
C101	SITE GRADING PLAN
C102	PUMP PIT DETAIL
C103	TANK INSTALLATION DETAIL
A100	PUMPHOUSE PLANS, ELEVATIONS AND SECTIONS
S100	PUMPHOUSE STRUCTURAL
E100	ELECTRICAL

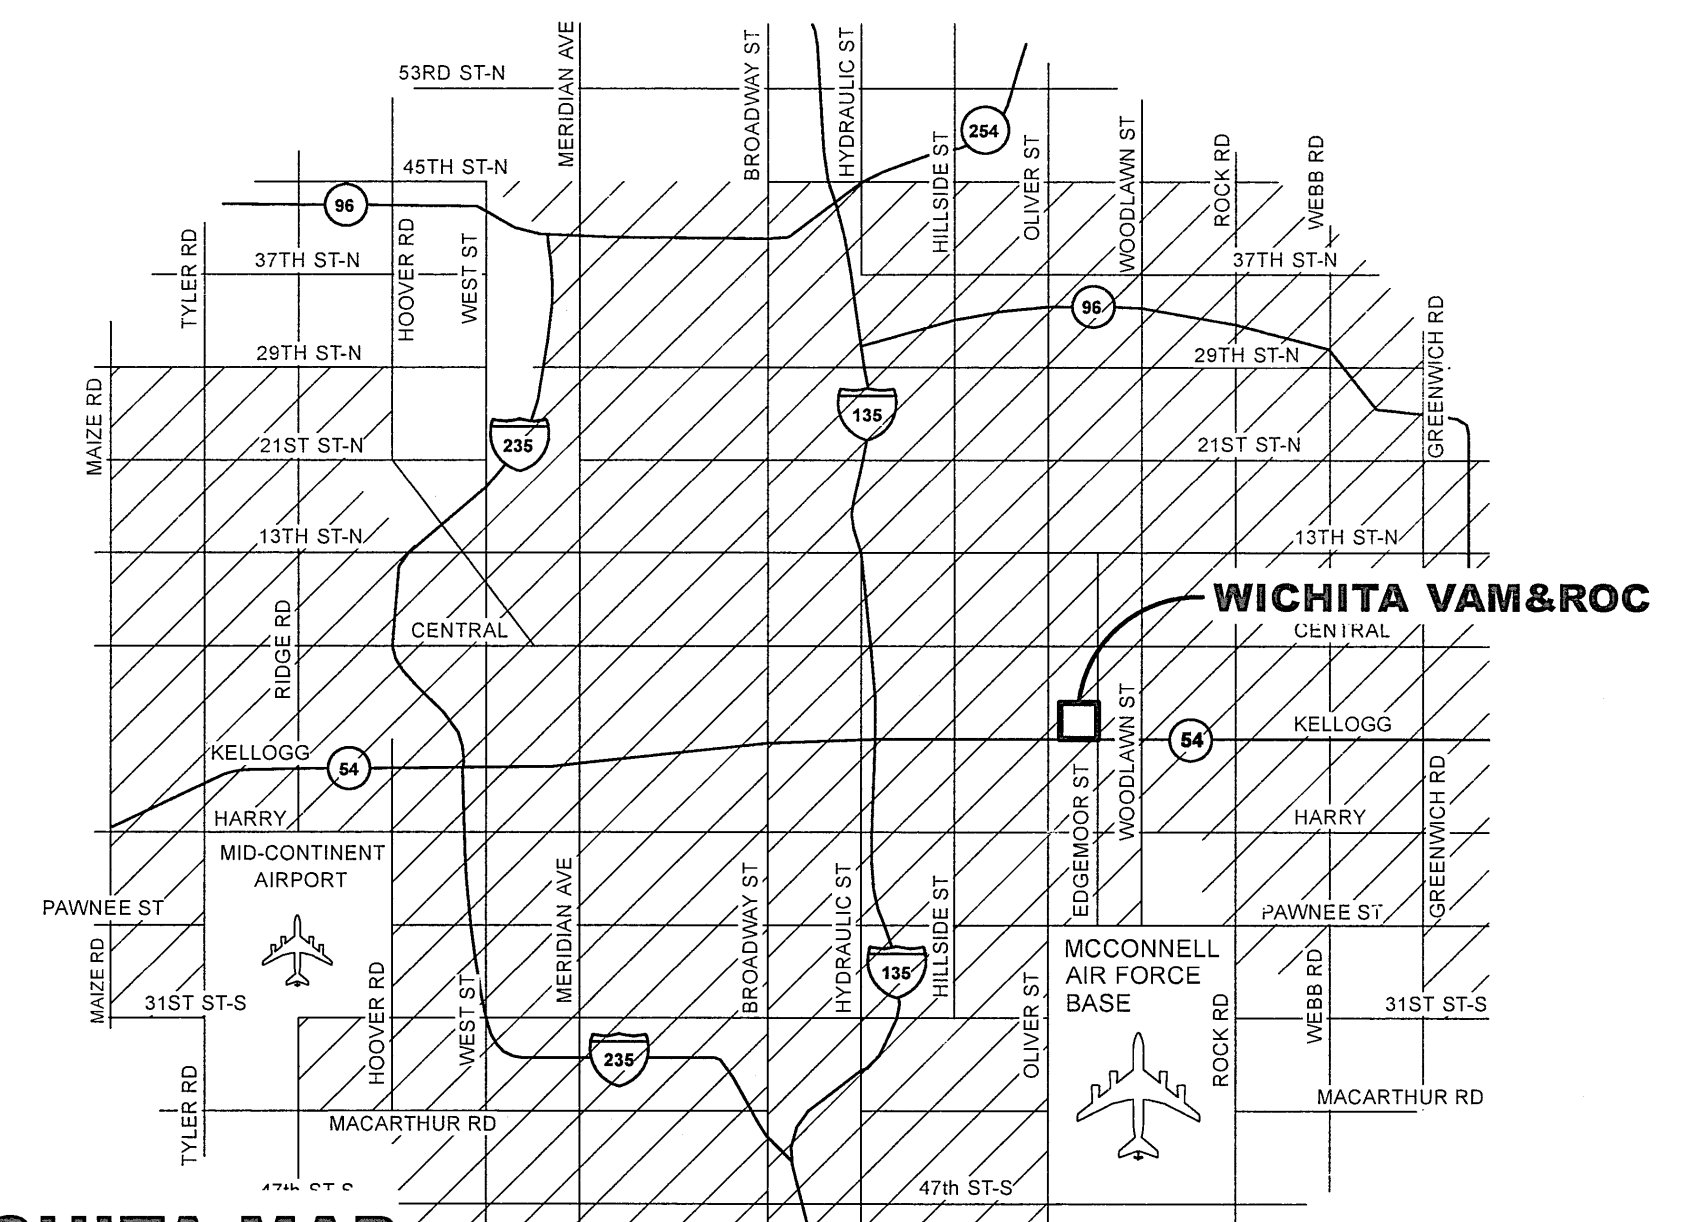

WICHITA MAP
NO SCALE

REVISIONS		DATE						ACTING MEDICAL CENTER DIRECTOR VICKI G. BONDIE, MBA, PMP MEDICAL CENTER ASSOCIATE DIRECTOR		LARRY HARDESTY OR DONALD ALLEN SAFETY MANAGER 		PROJECT TITLE CONSTRUCT BACKUP WATER SYSTEM		PROJECT NUMBER 589A7-12-127		Office of Facilities Management 			
								RAMZY HARB FACILITIES MANAGEMENT SERVICE DIRECTOR 				LOCATION WICHITA VAM&ROC 5500 E KELLOGG		BUILDING NUMBERS					
												ISSUE DATE 6-20-2014		CHECKED R.B.K.				DRAWN R.M.C.	
														DRAWING NUMBER G100		DWG 1 OF 8			