



UTILITY LEGEND (EXISTING)

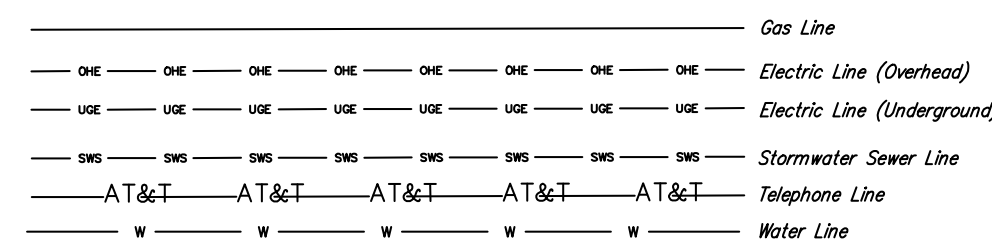

UTILITY LEGEND (PROPOSED)

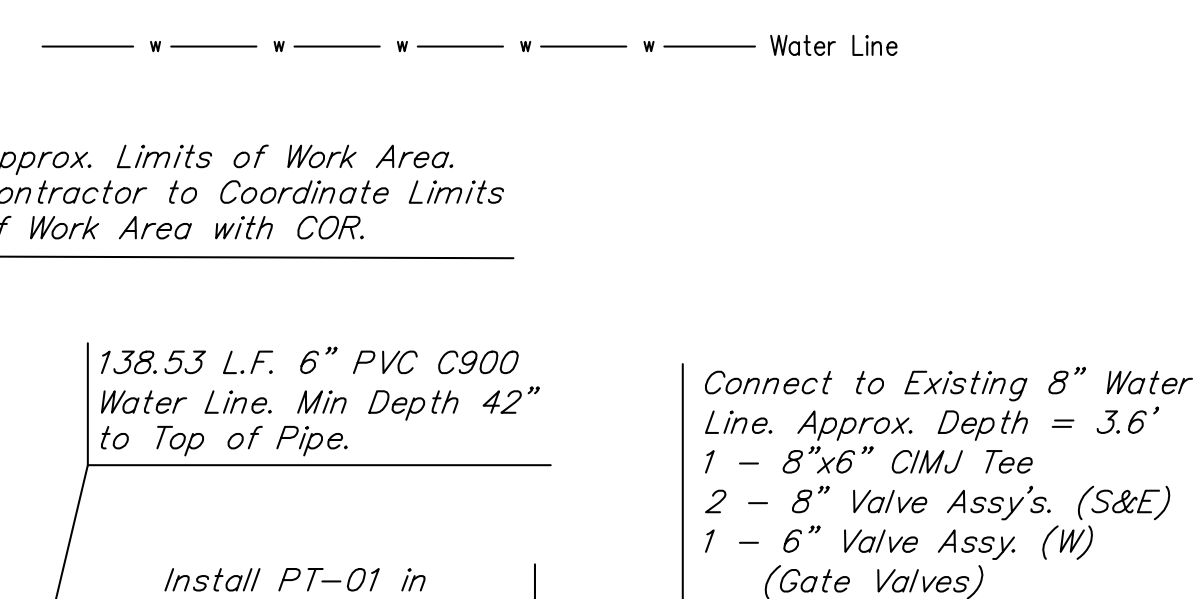


UTILITY NOTES


- Contractor shall be required to provide notice to Kansas One Call at 888-2470 a minimum of two (2) working days prior to any excavation or work adjacent to utilities.
- The Contractor must notify the following in case of an emergency:
Kansas Gas Service (Gas).....1-888-482-4950
Aquila Energy (Gas).....1-800-303-0357
Westor Energy (Electric).....383-8650
Cox Communications (Cablevision).....262-4270
AT&T (Phone).....268-2759
City of Wichita Water Dept. (Water).....268-4563 or 268-4908
City of Wichita Sewer Maint. (San. Sewer).....268-4024 or 262-6000
City of Wichita Storm Sewer Maint. (Storm Sewer).....268-4090
City of Wichita Traffic Maint. (Traffic Control).....268-4034 or 268-4203
- Existing utilities and their locations, as shown on the plans, represent the best information obtainable for design. Location information has been obtained from the various utility companies and is either from company record drawings or company provided field locations. The Contractor will be required to work around existing utilities which do not conflict with proposed construction.
- The Contractor shall provide temporary construction fence as directed by COR.
- The Contractor shall coordinate limits of work area with COR.
- The Contractor shall verify all utility locations prior to construction of this project.
- Contractor shall be responsible for coordination of all utility service connections.
- All Concrete Damaged Due to Construction shall be Saw Cut, Removed and Replaced by Contractor.

SITE UTILITY PLAN

Scale 1"= 20'-0"

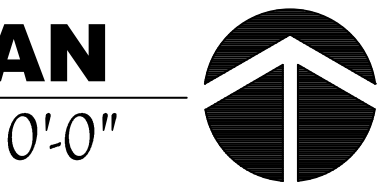


Baughman Company, P.A.
315 Ellis, Wichita, KS 67211
P316.262.1271 F316.262.0149

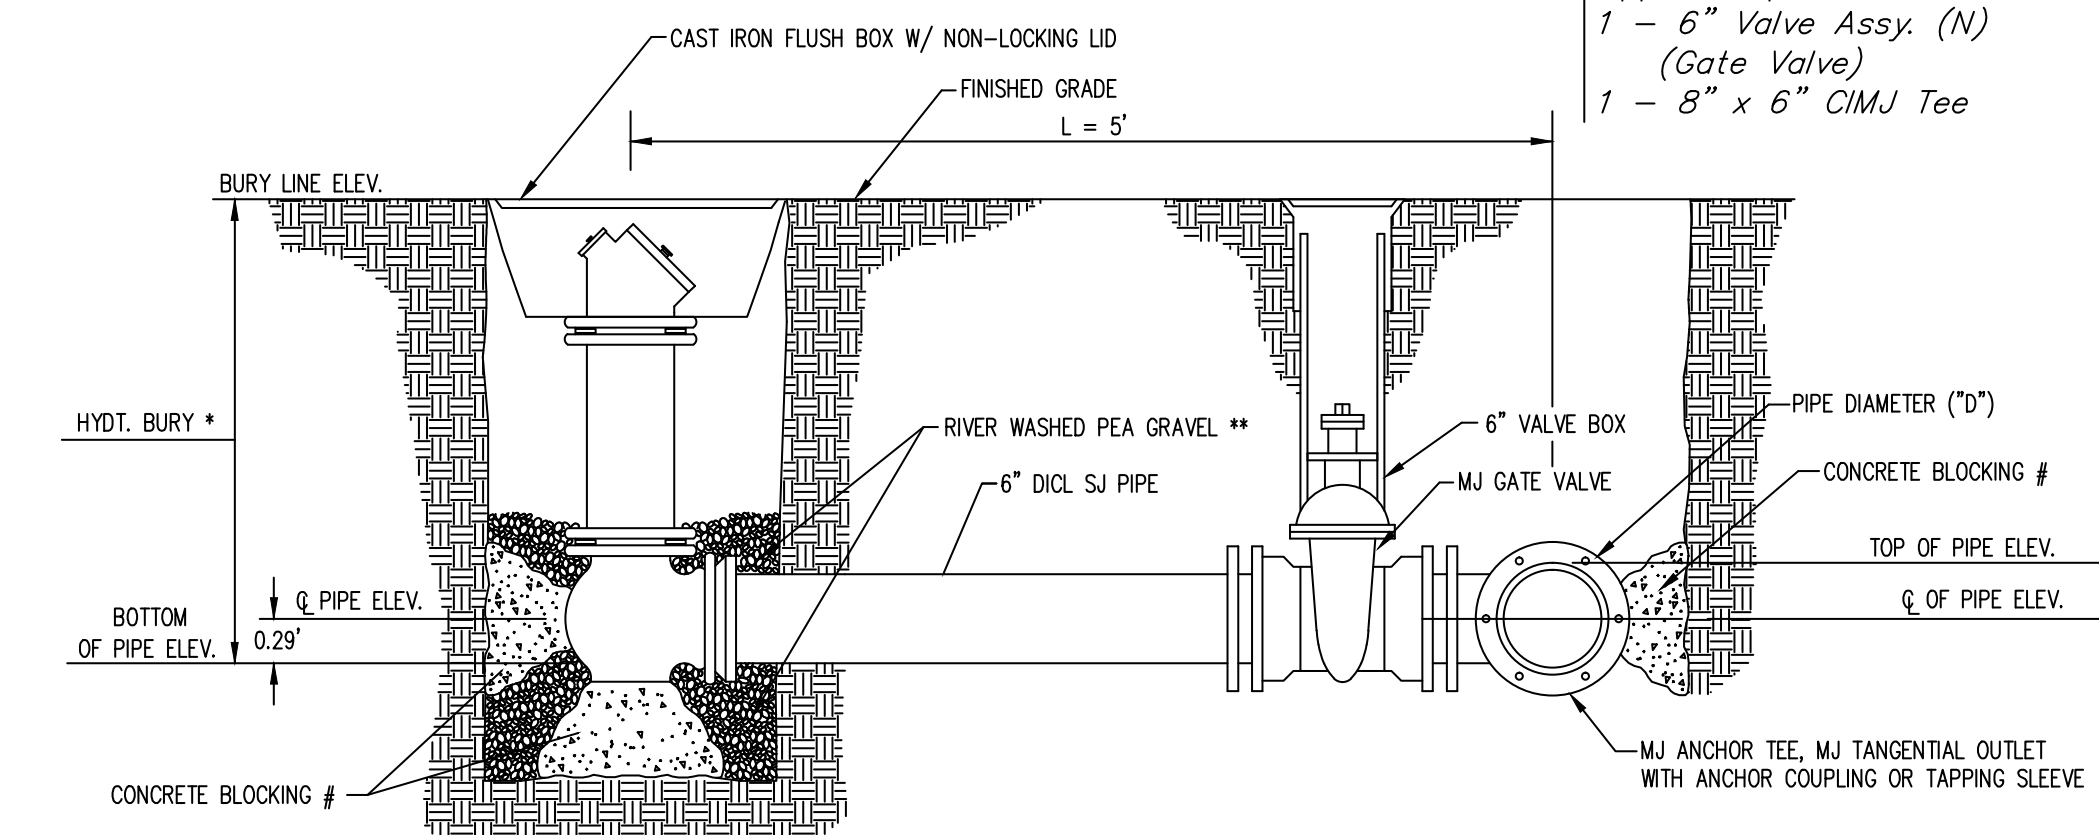

VALVE BOX DETAIL

NOTE: ONE VALVE STEM EXTENSION FOR EACH VALVE BURIED GREATER THAN 5'.

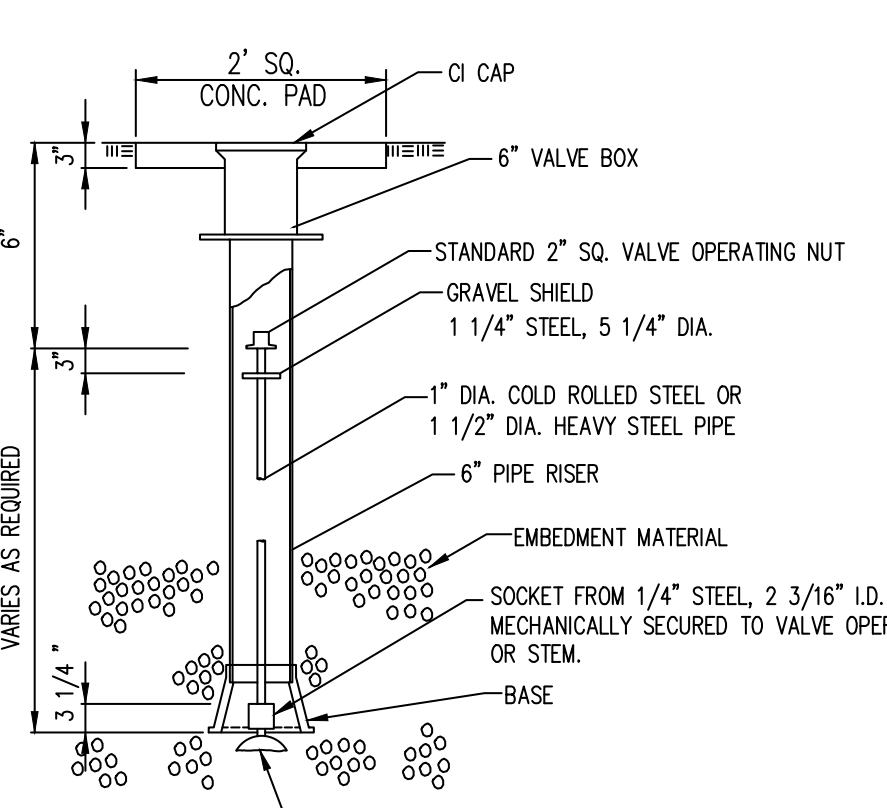

BLDG. LOCATION & ORIENTATION CHANGES
REVISIONS

4-1-13
DATE



PROJECT TITLE
CONSTRUCT BACKUP WATER SYSTEM

PROJECT NUMBER
589A7-12-127

BUILDING NUMBERS

DRAWING NUMBER
C101

DWG 3 OF 8

LOCATION
WICHITA VAM&ROC
5500 E KELLOGG

ISSUE DATE
6-20-2014

CHECKED
R.B.K.

DRAWN
R.M.C.

Office of
Facilities
Management

