

Revisions	Date

CONSULTANTS:


ARCHITECT/ENGINEERS:

Drawing Title	Project Title	Project Number
REFLECTED CEILING PLAN	Engineering Building 3 renovation	662-15-001
Approved Project Director	Location	Building Number
	4153 Clement Street San Francisco CA 94121	3
	Date	Dwg. 4 of 6
	10/30/2014	
	Checked	Drawn
		E. Taylor

Office of Construction and Facilities Management

Department of Veterans Affairs

4 REFLECTED CEILING PLAN
1/8" = 1'-0"

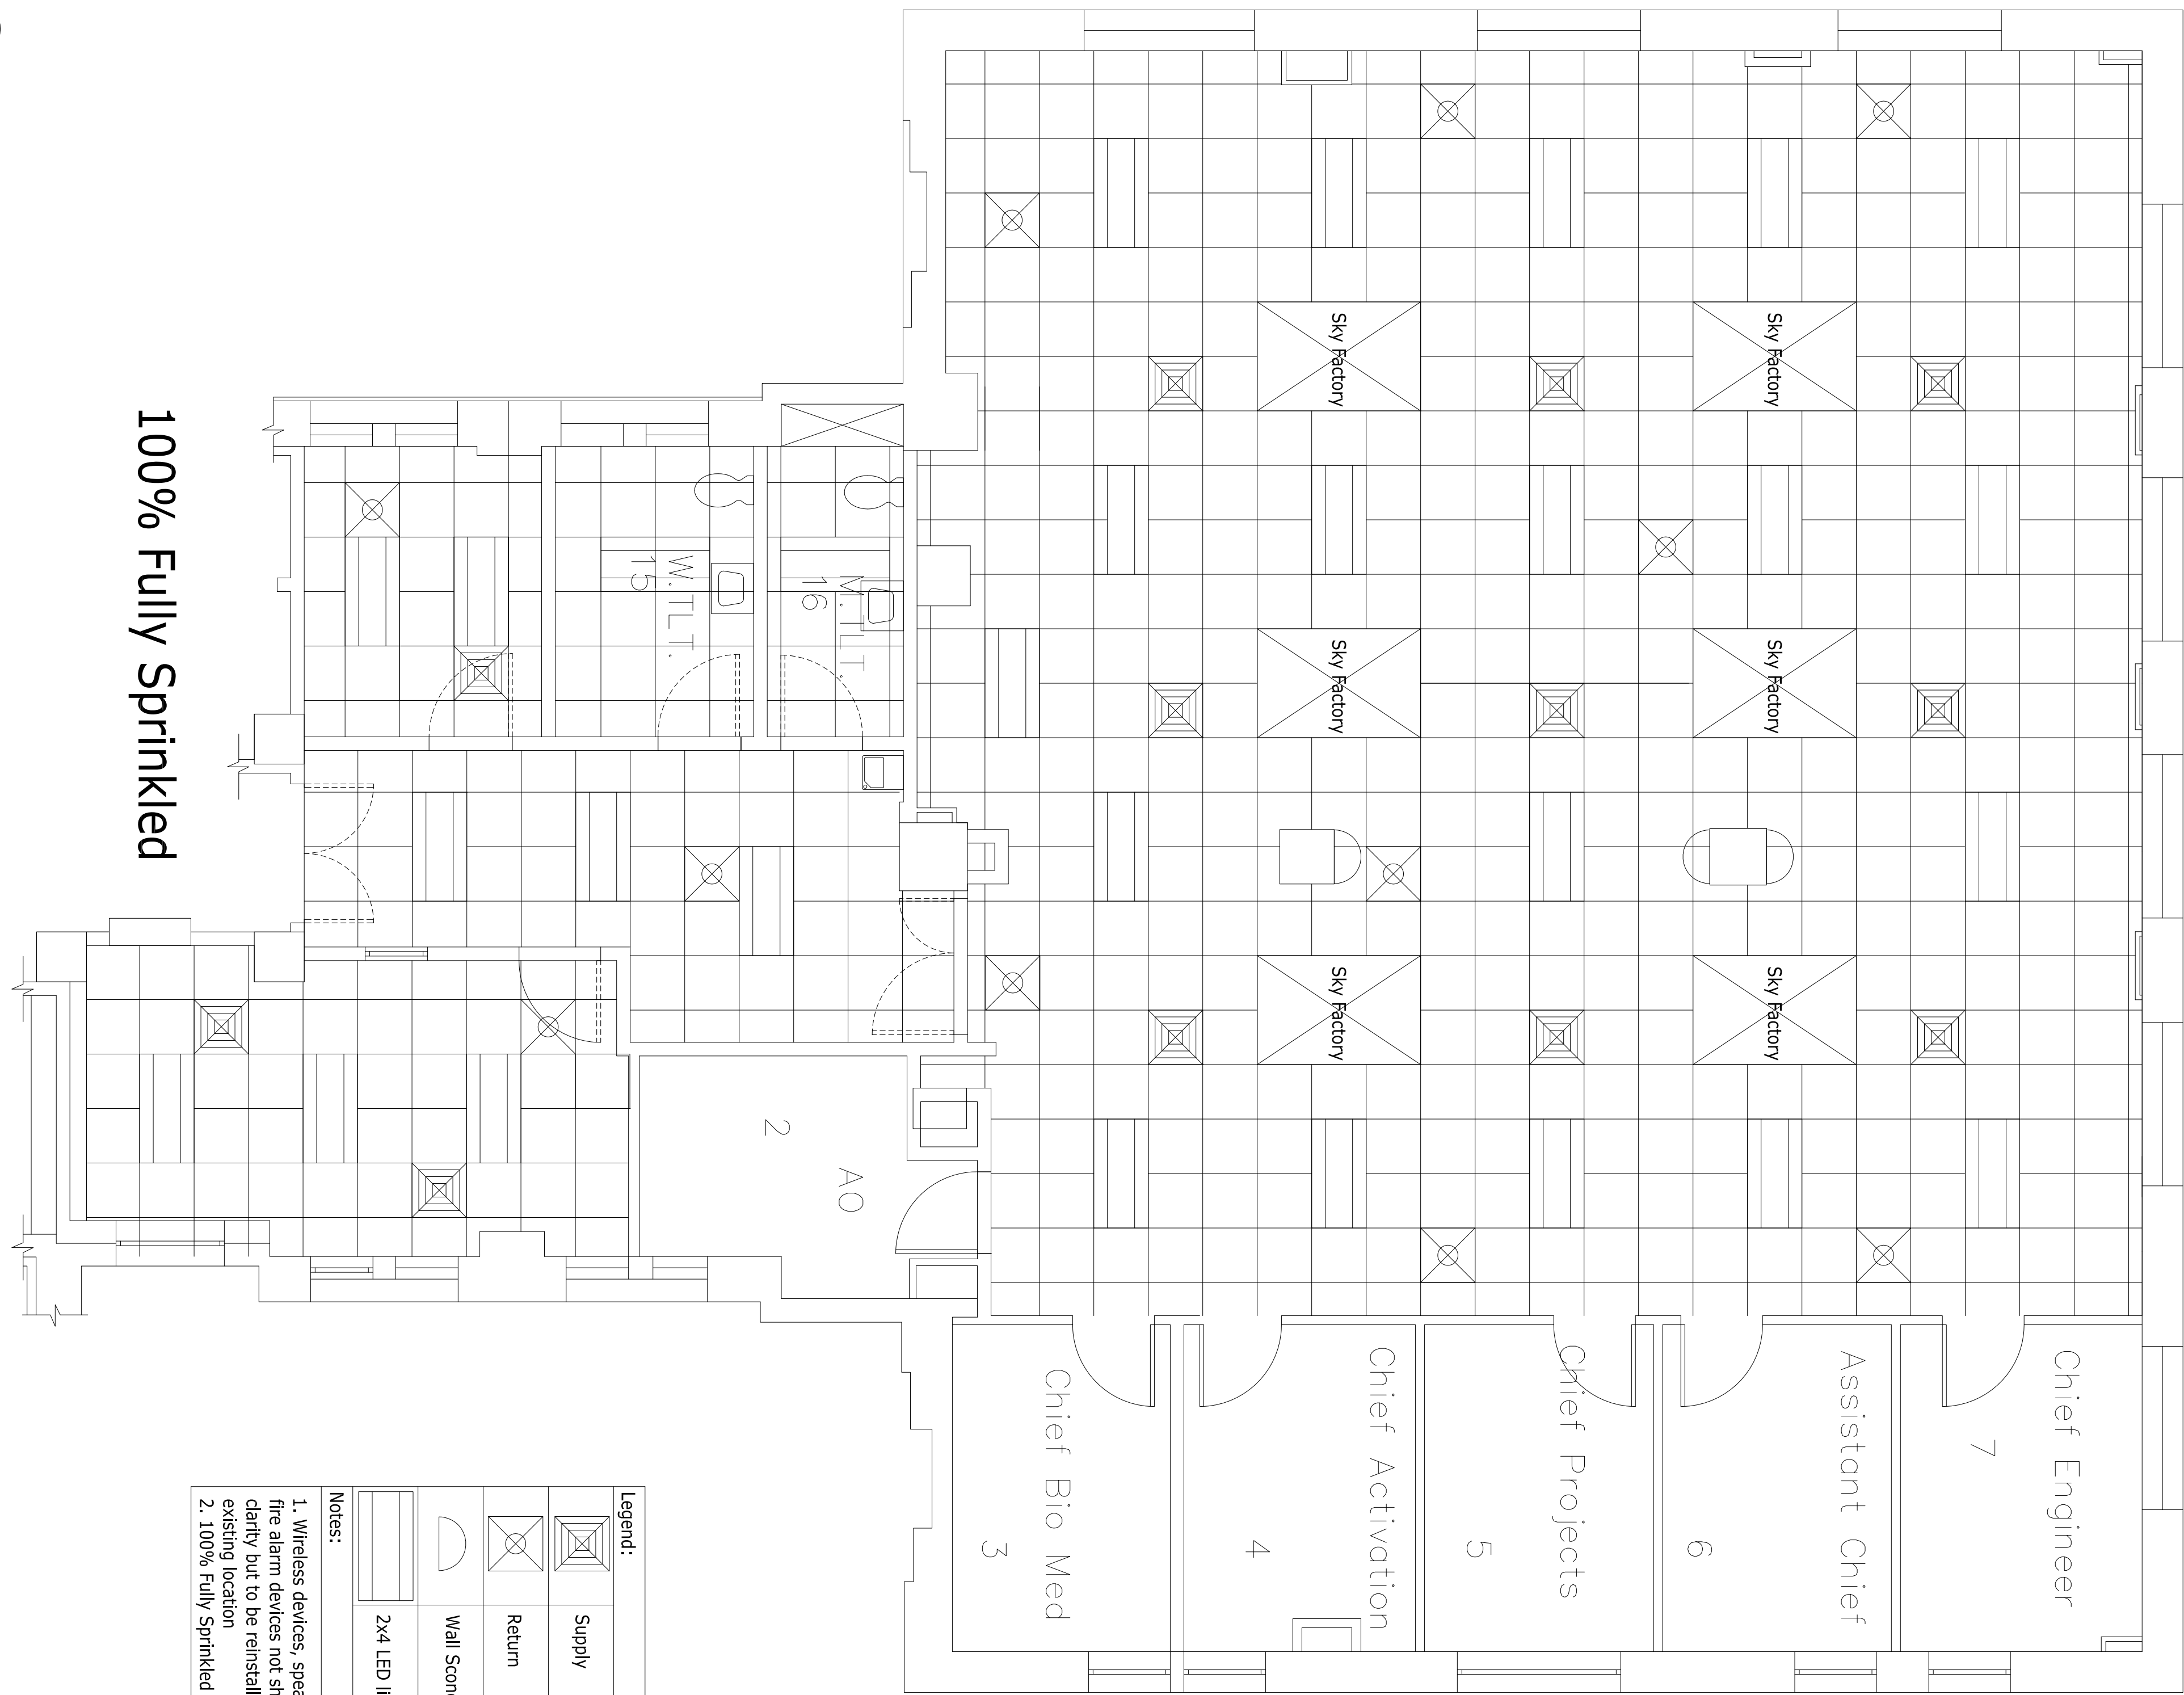

Legend:

	Supply
	Return
	Wall Sconce
	2x4 LED light fixture

Notes:

1. Wireless devices, speakers, and fire alarm devices not shown for ceiling, but to be reinstalled in ceiling.

2. 100% Fully Sprinkled