

Revision	Date

CONSULTANTS:

ARCHITECT/ENGINEERS:

Drawing Title
ELECTRICAL AND DATA PLAN

Project Title
Engineering Building 3 Renovation

Project Number
662-15-001


Building Number
3

Drawing Number
Dwg. 5 of 6

Office of Construction and Facilities Management

Department of Veterans Affairs

5 ELECTRICAL AND DATA PLAN

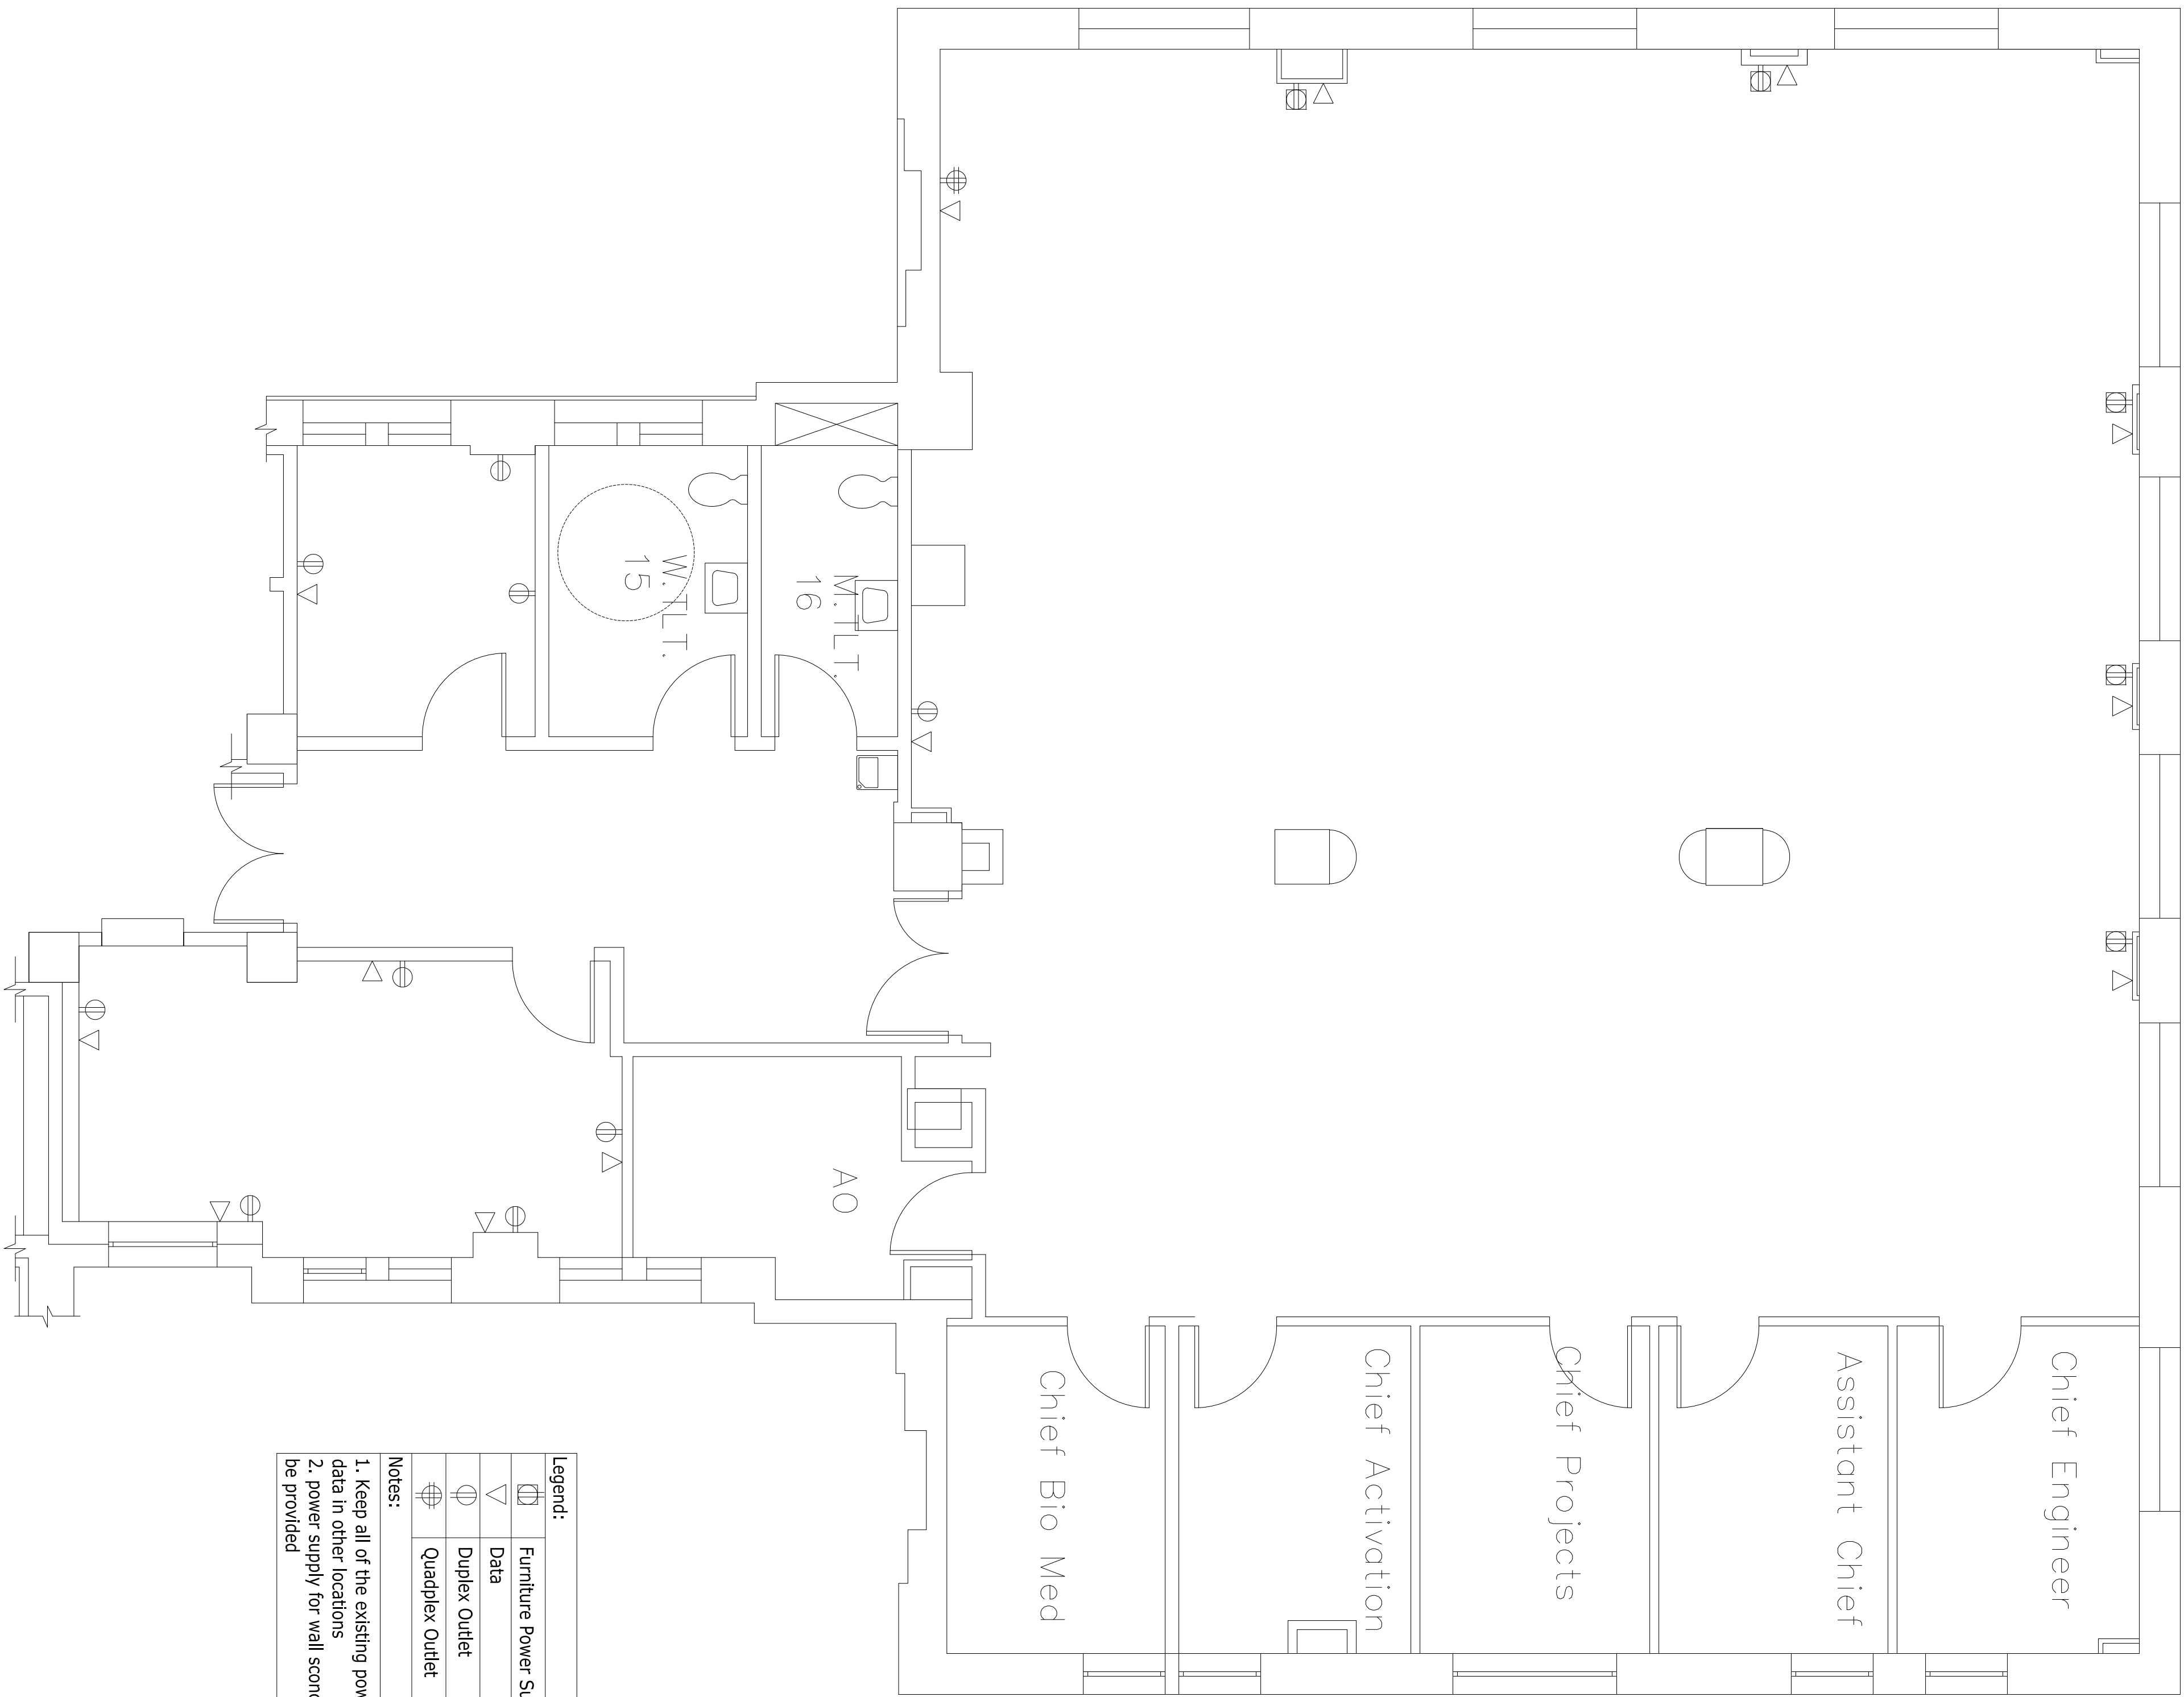

Legend:	
	Furniture Power Supply 20 Amp
	Data
	Duplex Outlet
	Quadplex Outlet
Notes:	
1. Keep all of the existing power and data in their location.	
2. power supply for wall sconce must be provided	

Scale: 1/4"=1'-0"