


CLOSED CIRCUIT (CCTV) INDIVIDUAL CAMERA REQUIREMENTS SCHEDULE

CAM #	PLAN REF	CAM TYPE	ROUGH-IN NOTES	MOUNTING HEIGHT	FIELD OF VIEW	ALARM FUNCTIONALITY	REFERENCE DETAILS	NOTES
53.1	53 TY100	1		CEILING	SERVICE ELEVATOR LOBBY 6A-100A		600TY300	
53.2	53 TY100	1		CEILING	VAULT B B-101		600TY300	
53.3	53 TY100	1		CEILING	CORRIDOR C B 1		600TY300	
53.4	53 TY100	1		CEILING	CORRIDOR C B 3		600TY300	
53.5	53 TY100	1		CEILING	INPATIENT PHARMACY 6B-100		600TY300	
53.6	53 TY100	3		CEILING	12 CL		600TY300	
53.7	53 TY100	1		CEILING	CORRIDOR C B 3		600TY300	
53.8	53 TY101	1		10' CL	SERVICE ELEVATOR LOBBY 6A-101		600TY300	
53.9	53 TY102	1		CEILING	ELEVATOR LOBBY 1A-100B		600TY300	
53.10	53 TY102	1		CEILING	CORRIDOR C 1 1		600TY300	
53.11	53 TY102	1		CEILING	CORRIDOR C 1 11		600TY300	
53.12	53 TY102	1		CEILING	ER WAITING ID-132		600TY300	
53.13	53 TY102	1		CEILING	AOD CHECK IN ID-129		600TY300	
53.14	53 TY102	1		CEILING	ELEVATOR LOBBY 1A-100A		600TY300	
53.15	53 TY102	1		CEILING	INFORMATION AREA 1A-110/LOBBY 1A-100		600TY300	
53.16	53 TY102	1		CEILING	LOBBY 1A-100		600TY300	
53.17	53 TY102	1		CEILING	ENTRY VESTIBULE ID-120		600TY300	
53.18	53 TY103	1		CEILING	OFFICE 112/112A		600TY300	
53.19	53 TY103	1		CEILING	CORRIDOR C 1 3		600TY300	
53.20	53 TY103	1		CEILING	CORRIDOR C 1 8		600TY300	
53.21	53 TY103	1		CEILING	CLERICAL 1B-142/1B-133		600TY300	
53.22	53 TY103	1		CEILING	CLERICAL 1B-142/1B-133		600TY300	
53.23	53 TY104	1		10' CL	SERVICE ELEVATOR LOBBY 10A-100		600TY300	
53.24	53 TY106	1		CEILING	ELEVATOR LOBBY 3A-100B		600TY300	
53.25	53 TY106	1		CEILING	ELEVATOR LOBBY 3A-100A		600TY300	
53.26	53 TY106	1		CEILING	CORRIDOR C 1 7		600TY300	
53.27	53 TY106	1		CEILING	CORRIDOR C 1 2		600TY300	
53.28	53 TY106	1		CEILING	CORRIDOR C 3 13		600TY300	
53.29	53 TY106	1		CEILING	CORRIDOR C 3 14		600TY300	
53.30	53 TY106	1		CEILING	CORRIDOR C 3 14		600TY300	
53.31	53 TY106	1		CEILING	CORRIDOR C 3 18		600TY300	
53.32	53 TY106	1		CEILING	WAITING ROOM 3D-179		600TY300	
53.33	53 TY107	1		CEILING	WAITING AREA 3D-166		600TY300	
53.34	53 TY107	1		CEILING	CONTROL CENTER 3B-126/CORR C 34		600TY300	
53.35	53 TY110	1		CEILING	CONTROL CENTER 3B-126/CORR C 38		600TY300	
53.36	53 TY110	1		CEILING	ELEVATOR LOBBY 4A-100B		600TY300	
53.37	53 TY110	1		CEILING	ELEVATOR LOBBY 4A-100A		600TY300	
53.38	53 TY110	1		CEILING	CORRIDOR C 4 1 17		600TY300	
53.39	53 TY110	1		CEILING	DAYROOM 4D-122		600TY300	
53.40	53 TY110	1		CEILING	CORRIDOR C 4 1 2		600TY300	
53.41	53 TY110	1		CEILING	CORRIDOR C 4 1 4		600TY300	
53.42	53 TY111	1		CEILING	WARD CLERK 4D-132A		600TY300	
53.43	53 TY111	1		CEILING	CORRIDOR C 4 4		600TY300	
53.44	53 TY111	1		CEILING	WARD CLERK 4B-172A		600TY300	
53.45	53 TY111	1		CEILING	WARD CLERK 4B-172A		600TY300	
53.46	53 TY111	1		CEILING	CORRIDOR C 4 5		600TY300	
53.47	53 TY111	1		CEILING	CORRIDOR C 4 5		600TY300	
53.48	53 TY114	1		CEILING	ELEVATOR LOBBY		600TY300	
53.49	53 TY114	1		CEILING	ELEVATOR LOBBY		600TY300	
53.50	53 TY114	1		CEILING	CORRIDOR		600TY300	
53.51	53 TY114	1		CEILING	ROOM 50-146		600TY300	
53.52	53 TY114	1		CEILING	ROOM 50-146		600TY300	
53.53	53 TY114	1		CEILING	CORRIDOR		600TY300	
53.54	53 TY114	1		CEILING	CORRIDOR		600TY300	
53.55	53 TY114	1		CEILING	CORRIDOR		600TY300	
53.56	53 TY114	1		CEILING	CORRIDOR		600TY300	
53.57	53 TY114	1		CEILING	ROOM 50-122		600TY300	
53.58	53 TY114	1		CEILING	PATIENT LOUNGE		600TY300	
53.59	53 TY114	1		CEILING	CORRIDOR		600TY300	
53.60	53 TY114	1		CEILING	PATIENT LOUNGE 9B-124		600TY300	
53.61	53 TY114	1		CEILING	ROOM 50-122		600TY300	
53.62	53 TY115	1		CEILING	CORRIDOR C 5 8		600TY300	
53.63	53 TY115	1		CEILING	CORRIDOR C 5 4		600TY300	
53.64	53 TY115	1		CEILING	CENTRAL DINING 9B-123		600TY300	
53.65	53 TY115	1		CEILING	CORRIDOR C 5 5		600TY300	
53.66	53 TY115	1		CEILING	PATIENT LOUNGE 9B-124		600TY300	
53.67	53 TY115	1		CEILING	PATIENT LOUNGE 9B-124		600TY300	
53.68	53 TY115	4		CEILING	ROOF		600TY300	
53.69	53 TY115	4		CEILING	ROOF		600TY300	
53.70	53 TY115	4		CEILING	ROOF		600TY300	
53.71	53 TY108	3		19'	COURTYARD		600TY300	
53.72	53 TY110	1		CEILING	CORRIDOR C 9		600TY300	
53.73	53 TY110	1		CEILING	CORRIDOR C 9		600TY300	
53.74	53 TY114	1		CEILING	CORRIDOR C 5 10		600TY300	
53.75	53 TY114	1		CEILING	CORRIDOR C 5 10		600TY300	
53.76	53 TY106	1		CEILING	CORRIDOR C 3 12		600TY300	
53.77	53 TY102	1		CEILING	CORRIDOR		600TY300	
53.78	53 TY114	1		CEILING	ELEVATOR LOBBY		600TY300	
53.79	53 TY102	1		CEILING	CORRIDOR ID-100		600TY300	
PL1.1	00TY001	4		PENDANT	ENTRANCES GENERAL PARKING		400TY300	2
PL1.2	00TY001	4		PENDANT	PARKING		400TY300	2
PL1.4.1	00TY001	4		PENDANT	ENTRANCE GENERAL PARKING		400TY300	2
PL1.4.2	00TY001	4		PENDANT	PARKING		400TY300	2
PL1.4.3	00TY001	4		PENDANT	PARKING		400TY300	2

NOTES:
 1. CAMERAS LISTED ABOVE WITHOUT ROUGH-IN REQUIREMENTS DOES NOT MEAN THAT NO ROUGH-IN IS REQUIRED. IF NONE IS NOTED, FOLLOW MANUFACTURER'S RECOMMENDED REQUIREMENTS.
 2. DEDUCT ALTERNATE #2. SEE BID FORM.

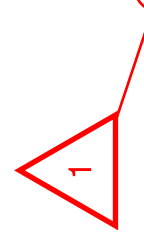

CONSULTANTS:

ARCHITECTS/ENGINEERS:

ISSUED FOR CONSTRUCTION

Date: 08.23.13
 Project No. 623.12.105
 Drawing No. 00 TY501
 Dwg. 34 of 122

REPLACE SURVEILLANCE SYSTEM

Approved: TWC - JOIMVAMC
 Checked By: DAVLAR KEIEVE
 Location: Jack C. Montgomery
 VA Medical Center - Muskogee, OK

TECHNOLOGY SCHEDULES

Scale: AS SHOWN
 Building Number: SITE

APPROVED

APPROVED

APPROVED

APPROVED

APPROVED/President, A.F.G.E. 6250

APPROVED/Associate Director

APPROVED/Chief of Staff

APPROVED/Chief of Engineering Service

APPROVED

APPROVED

APPROVED

APPROVED

APPROVED/Energy Engineer

APPROVED/Safety Manager

APPROVED/Infection Control Nurse

APPROVED/Industrial Hygienist

APPROVED

APPROVED

APPROVED

APPROVED

APPROVED/Medical Center Director

APPROVED/Associate Director

APPROVED/Chief of Staff

APPROVED/Chief of Engineering Service

CONSULTANTS:

ARCHITECTS/ENGINEERS:

Dept. of Veterans Affairs
Jack C. Montgomery
Medical Center
1011 Honor Height Drive
Muskogee, Oklahoma 74401


REVISIONS:

No.	Description	Date
1	ADDENDUM #1	11/17/14

ORIGINAL SIZE OF SHEET IS 36" X 42"

PRINTED ON: August 21, 2013

VA FORM 08-6231

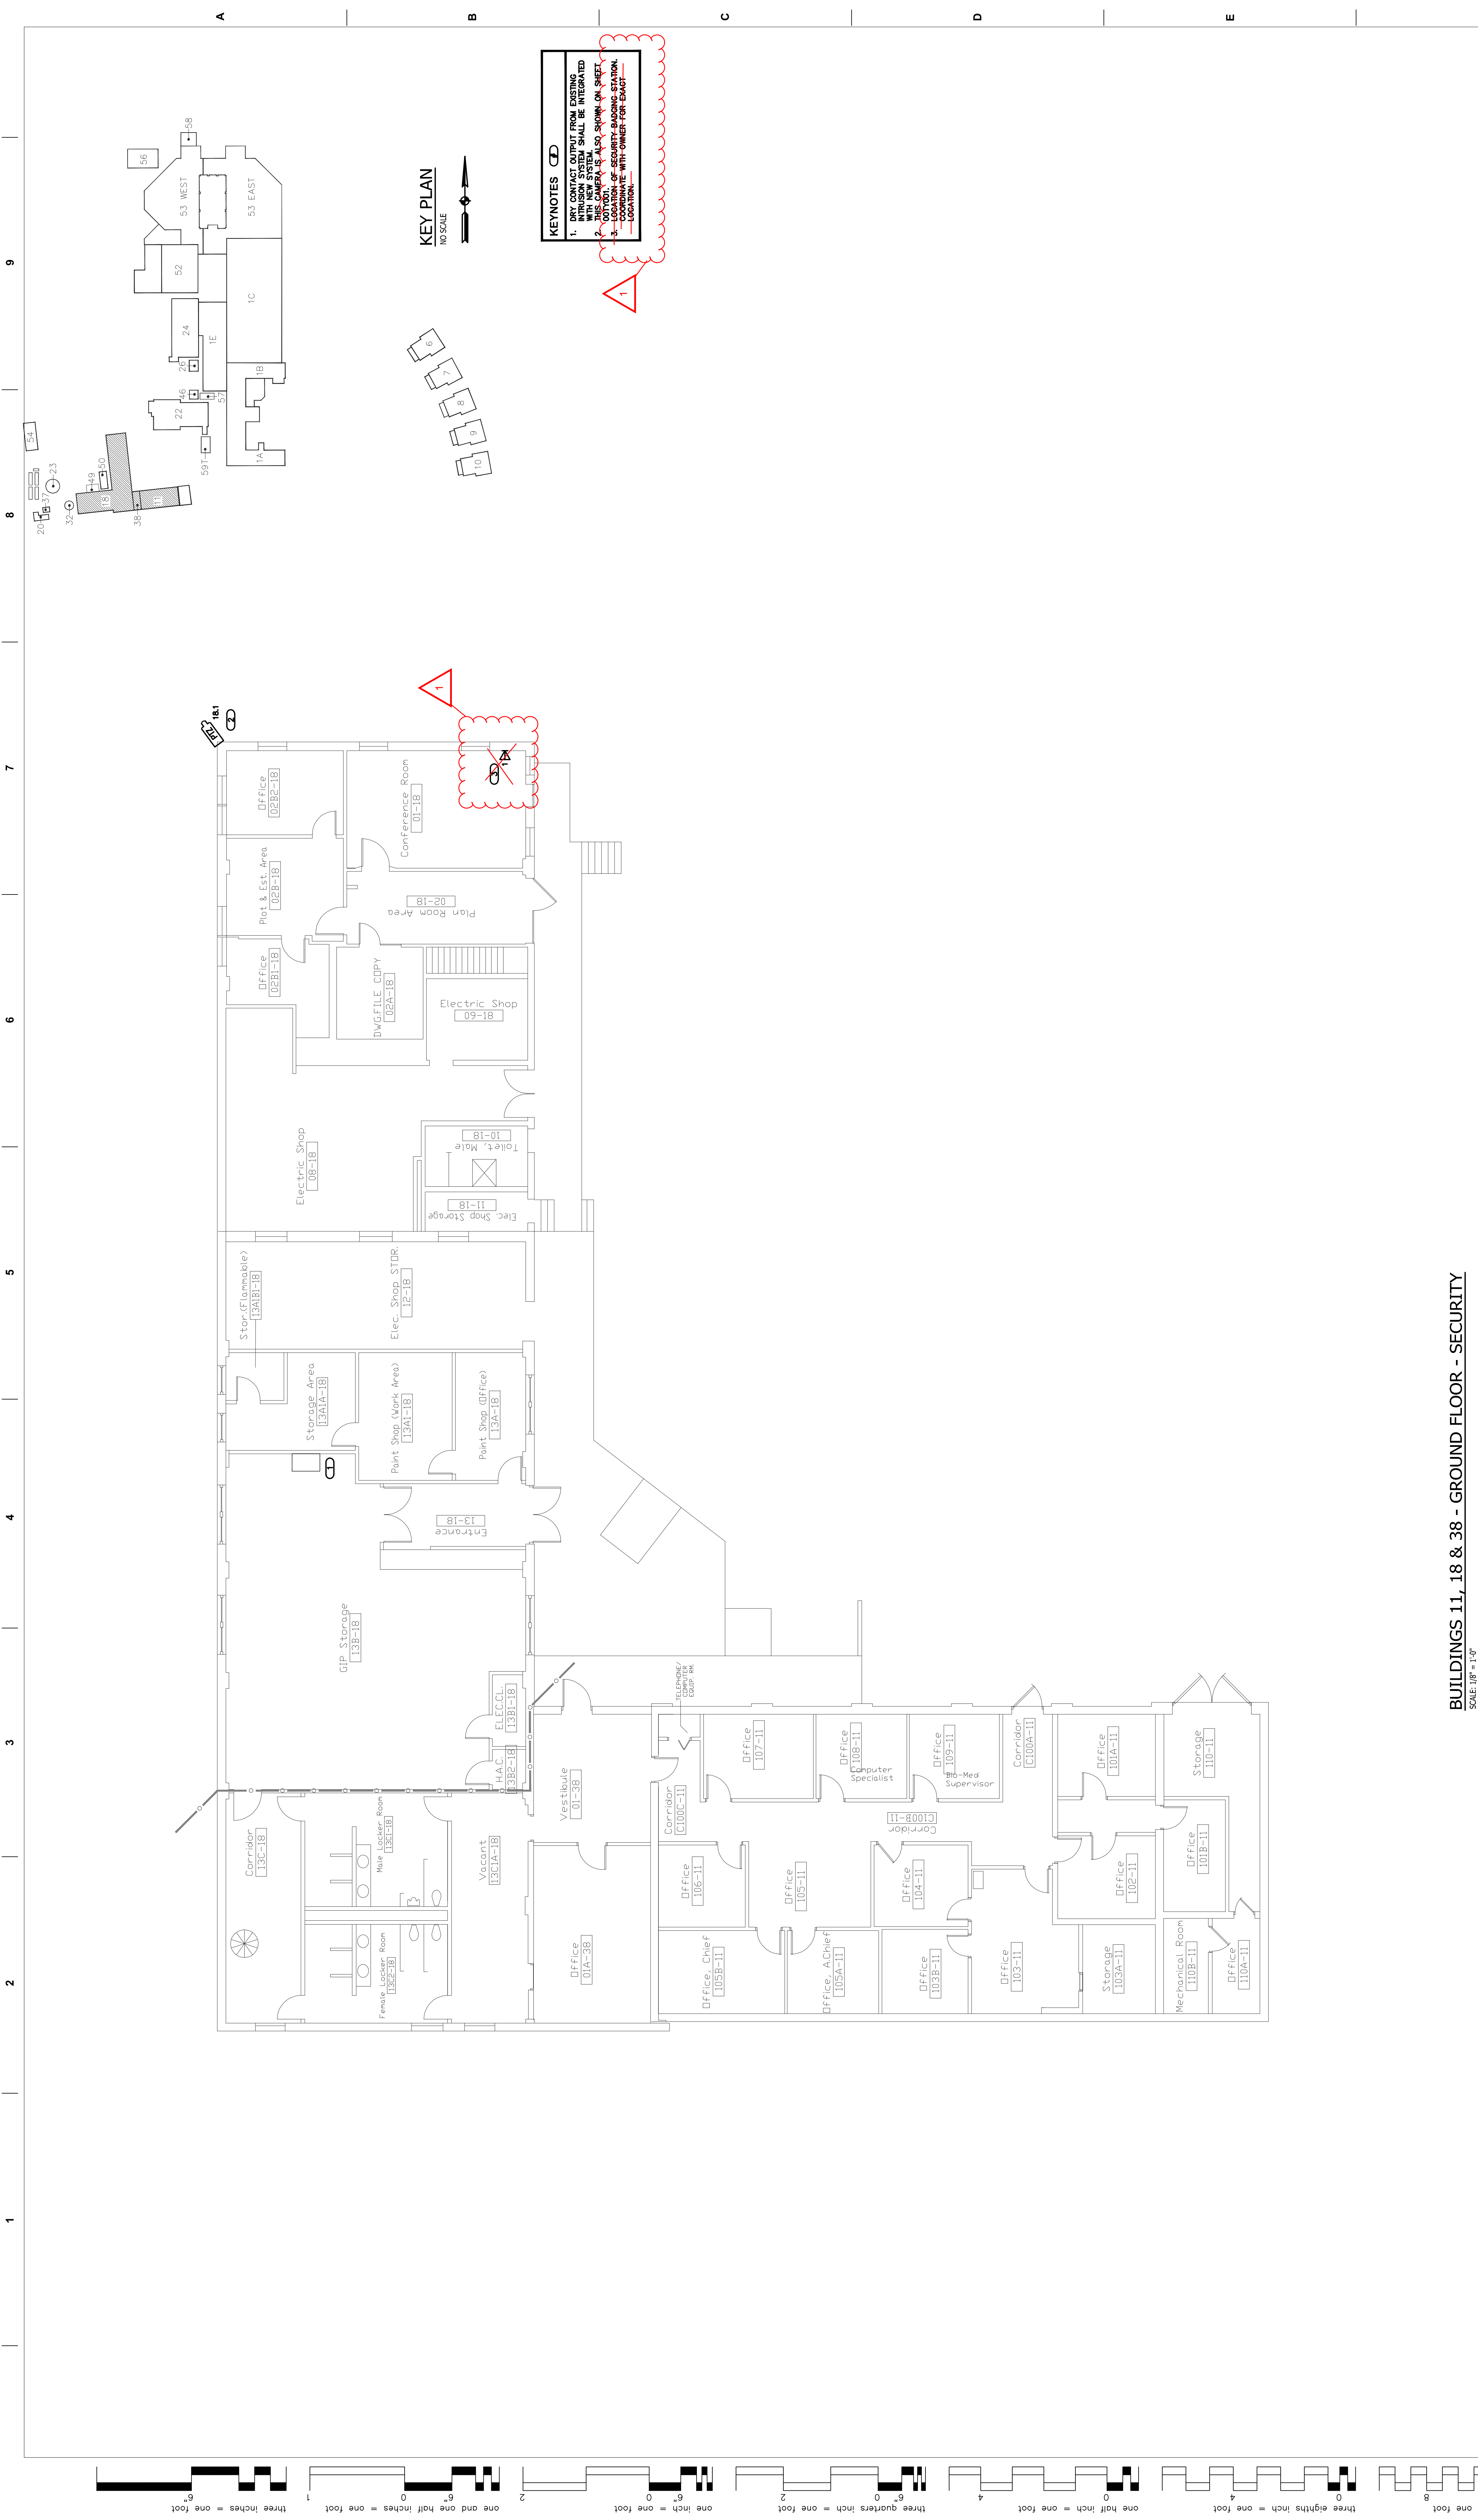

KEYNOTES

1. ANY CONTACT OUTPUT FROM EXISTING INTRUSION SYSTEM SHALL BE INTEGRATED WITH THE NEW SYSTEM.
2. THE CAMERA IS ALSO SHOWN ON SHEET 11-18-38-01.
3. LOCATION OF SECURITY-BANDING STATION COORDINATE WITH OWNER FOR EXACT LOCATION.

KEY PLAN
NO SCALE

BUILDINGS 11, 18 & 38 - GROUND FLOOR - SECURITY
SCALE: RF = 1/4"

No.	Description	Date
1	ADDENDUM #1	11/17/14

Revisions

CONSULTANTS:
K&W CONSULTANTS
 27702E, MUSKOGEE, OKLAHOMA 74401
 (405) 444-1414
STRUCTURAL, MECHANICAL, ELECTRICAL, PLUMBING, AND HVAC SOLUTIONS
 www.kandw.com

ARCHITECTS/ENGINEERS:
303rd Engineering Group, LLC
 Former - Disabled Veterans-Owned Small Business
 1011 Honor Height Drive
 Muskogee, Oklahoma 74401
 www.303rdeng.com

Dept. of Veterans Affairs
 Jack C. Montgomery
 Medical Center
 1011 Honor Height Drive
 Muskogee, Oklahoma 74401

APPROVED	APPROVED/President AF.GE. 2250	APPROVED/Energy Engineer	APPROVED/Medical Center Director
APPROVED	APPROVED	APPROVED/Safety Manager	APPROVED/Associate Director
APPROVED	APPROVED	APPROVED/Infection Control Nurse	APPROVED/Chief of Staff
APPROVED	APPROVED	APPROVED/Industrial Hygienist	APPROVED/Chief of Engineering Service

Drawing Title:
GROUND FLOOR PLAN

Scale:
AS SHOWN

Building Number:
11 & 18 & 38

Project Title:
REPLACE SURVEILLANCE SYSTEM

Date:
08.23.13

Project No.:
623.12.105

Approved:
TWC - JCM/VAMC

Checked By:
DAVLAR

Drawn By:
KEIEVE

Location:
Jack C. Montgomery
VA Medical Center - Muskogee, OK

ISSUED FOR CONSTRUCTION

Drawing No.:
11 18 38 TY102

Dept. No.:
70 or 122

Department of Veterans Affairs

