


PROJECT LOCATION

MALCOM RANDALL VETERANS
ADMINISTRATION MEDICAL CENTER
GAINESVILLE, FLORIDA

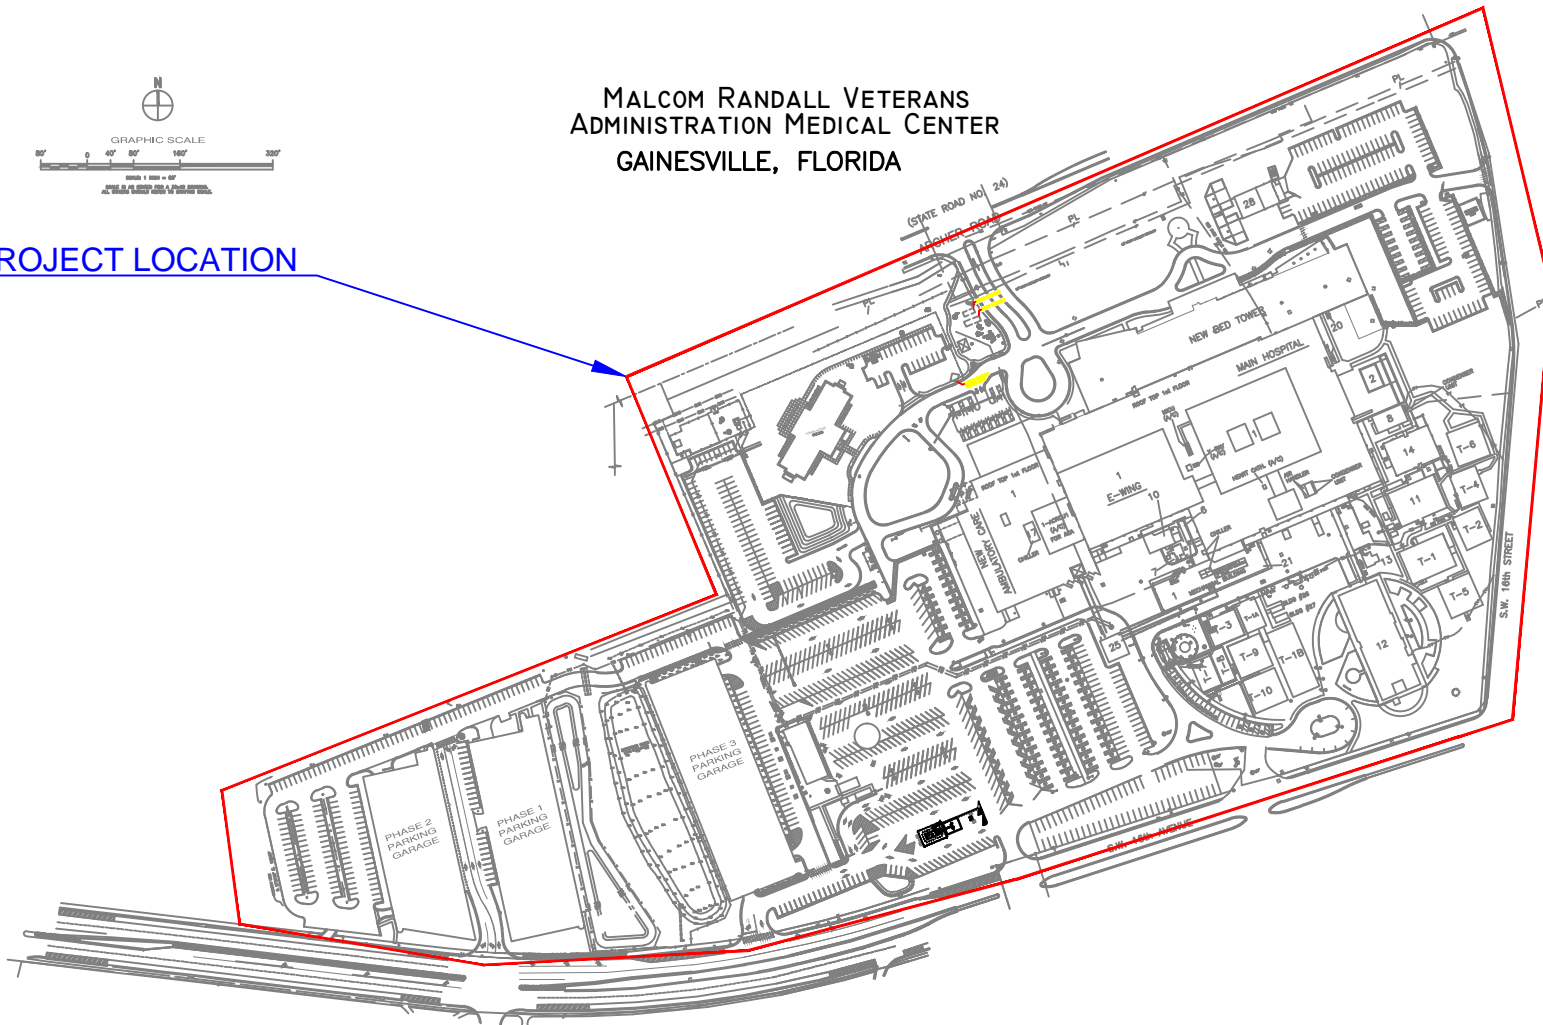

<div>Revisions</div> <div>Date</div> <div>Sheet</div>		<div>Approved:</div> <div>Facilities Management Services</div>		<div>Drawing No.</div> <div>Malcom Randall VA Medical Center Site Plan</div>		<div>Project No.</div> <div>RENOVATE IRRIGATION SYSTEM</div>		<div>Date</div> <div>May 29, 2012</div>	
								<div>Project No.</div> <div>573-13-604</div>	
				<div>Approved: Chief, Facilities Management Services</div>		<div>Building Number</div> <div>NONE</div>		<div>Checked</div> <div>SSH</div>	
				<div>Approved: Services Director</div>		<div>Drawn</div> <div>RDY</div>		<div>Drawn By</div> <div>Malcom Randall VA Medical Center</div>	
								<div>DWG.</div> <div>OF</div>	



Office of Facilities

Department of Veterans Affairs