




GENERAL NOTES

- 1 PROVIDE INFECTION CONTROL MEASURES PER FAYETTEVILLE VAMC REQUIREMENTS DURING ALL WORK IN THIS AREA.
- 2 REFER TO MECHANICAL PLANS FOR COORDINATION.

KEY#

NOTES

1. CONNECT TO EXISTING DOMESTIC COLD WATER LINE WITH NEW 1/2" PIPE AND ROUTE TO CSG-3. COORDINATE WITH MECHANICAL CONTRACTOR FOR CONNECTION TO CSG-3.
2. CONNECT TO EXISTING 3" DCW LINE AFTER THE SHUT OFF VALVE WITH 1/2" LINE AND ROUTE THROUGH EXISTING PIPE CHASE ROOF OPENING OUT TO CSG-14 ON ROOF.
3. ROUTE 1/2" WATER LINE UP FROM SECOND FLOOR TO CSG-14. SEAL PENETRATION OF ROOF CURB WATER TIGHT. COORDINATE WITH MECHANICAL CONTRACTOR FOR ROUTING AND FINAL CONNECTIONS. PROVIDE HEAT TRACE FOR ANY OUTDOOR PIPING AND CIRCUIT WITH OTHER PIPES. COORDINATE WITH MECHANICAL CONTRACTOR.

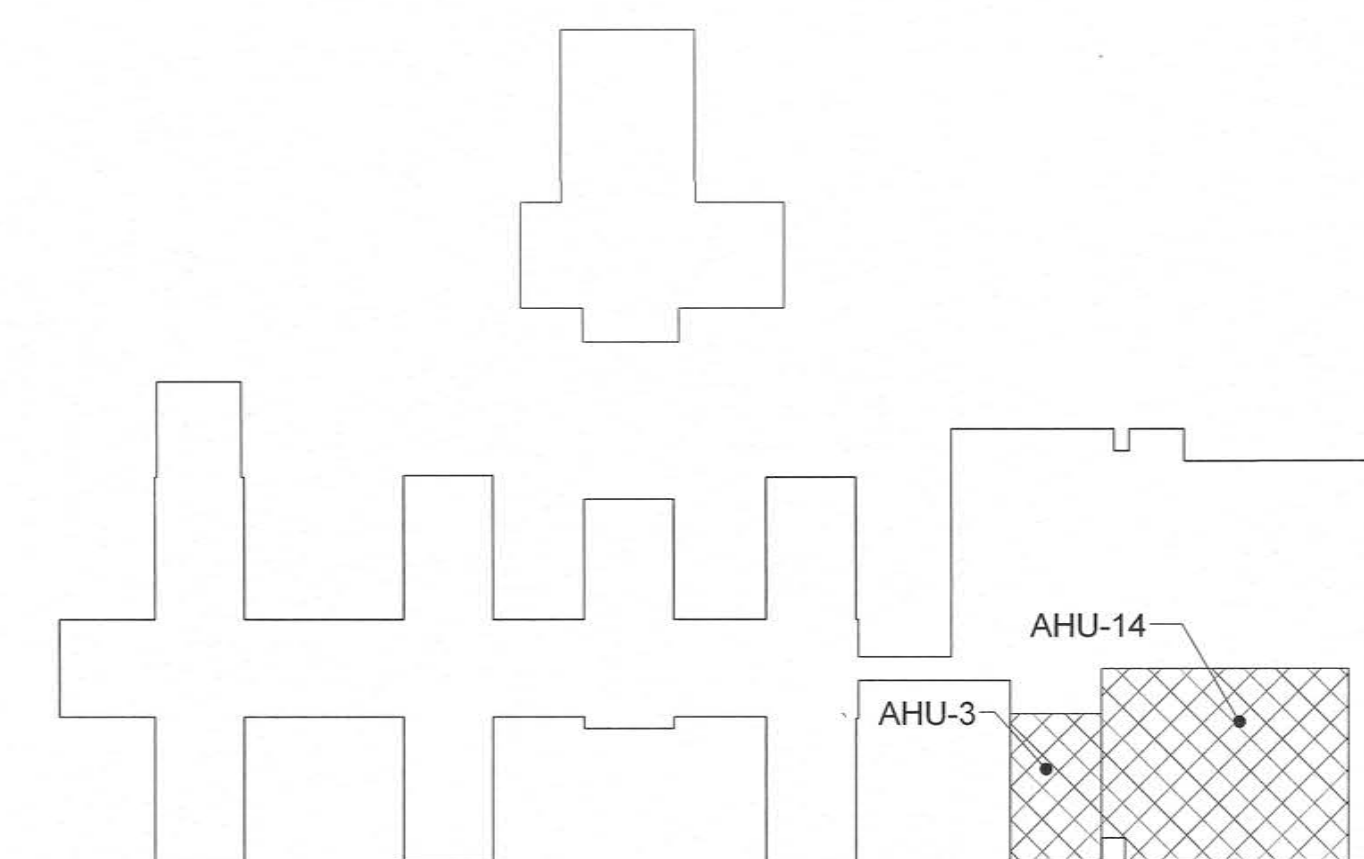

BUILDING 1 & 3 KEY PLAN

100% CONSTRUCTION DOCUMENTS

		CONSULTANTS:				PROJECT MANAGER:		Project Number 2013121		Scale As indicated		Drawing Title PLUMBING PLANS AHU-3 & 14		Project Title REPLACE AIR HANDLING UNITS 3, 14, & 34		VA Project Number 246-13-C-0106		Office of Facilities Management			
						 Raleigh, NC Indianapolis, IN Philadelphia, PA Fort Collins, CO Virginia Beach, VA (919) 858-7420 www.acg-pa.com NC License # C-1848						Approved: Project Director		Location 2300 RAMSEY STREET, FAYETTEVILLE, NC 28301		Building Number 1 AND 3					
Amended Per Owner's Comments No Rev Clouds		10/17/2014												Drawing Number P-101							
Revisions		Date												Date 08/28/2014		Checked DJR		Drawn SPG		Dwg. 3 of 18	