



GENERAL NOTES: (THIS SHEET ONLY)

 

 
1. ALL WORK WITH FIRE ALARM SYSTEM SHALL BE COORDINATED AND SCHEDULED WITH HOSPITAL PRIOR TO COMMENCING WORK.

- KEYED NOTES: (THIS SHEET ONLY)
- ① RELOCATE EXISTING SPECIAL SYSTEM DEVICES IN EXISTING CORRIDOR CEILING.
- ② RELOCATE EXISTING SPECIAL SYSTEM DEVICES IN CEILING IN THIS SPACE AS REQUIRED.

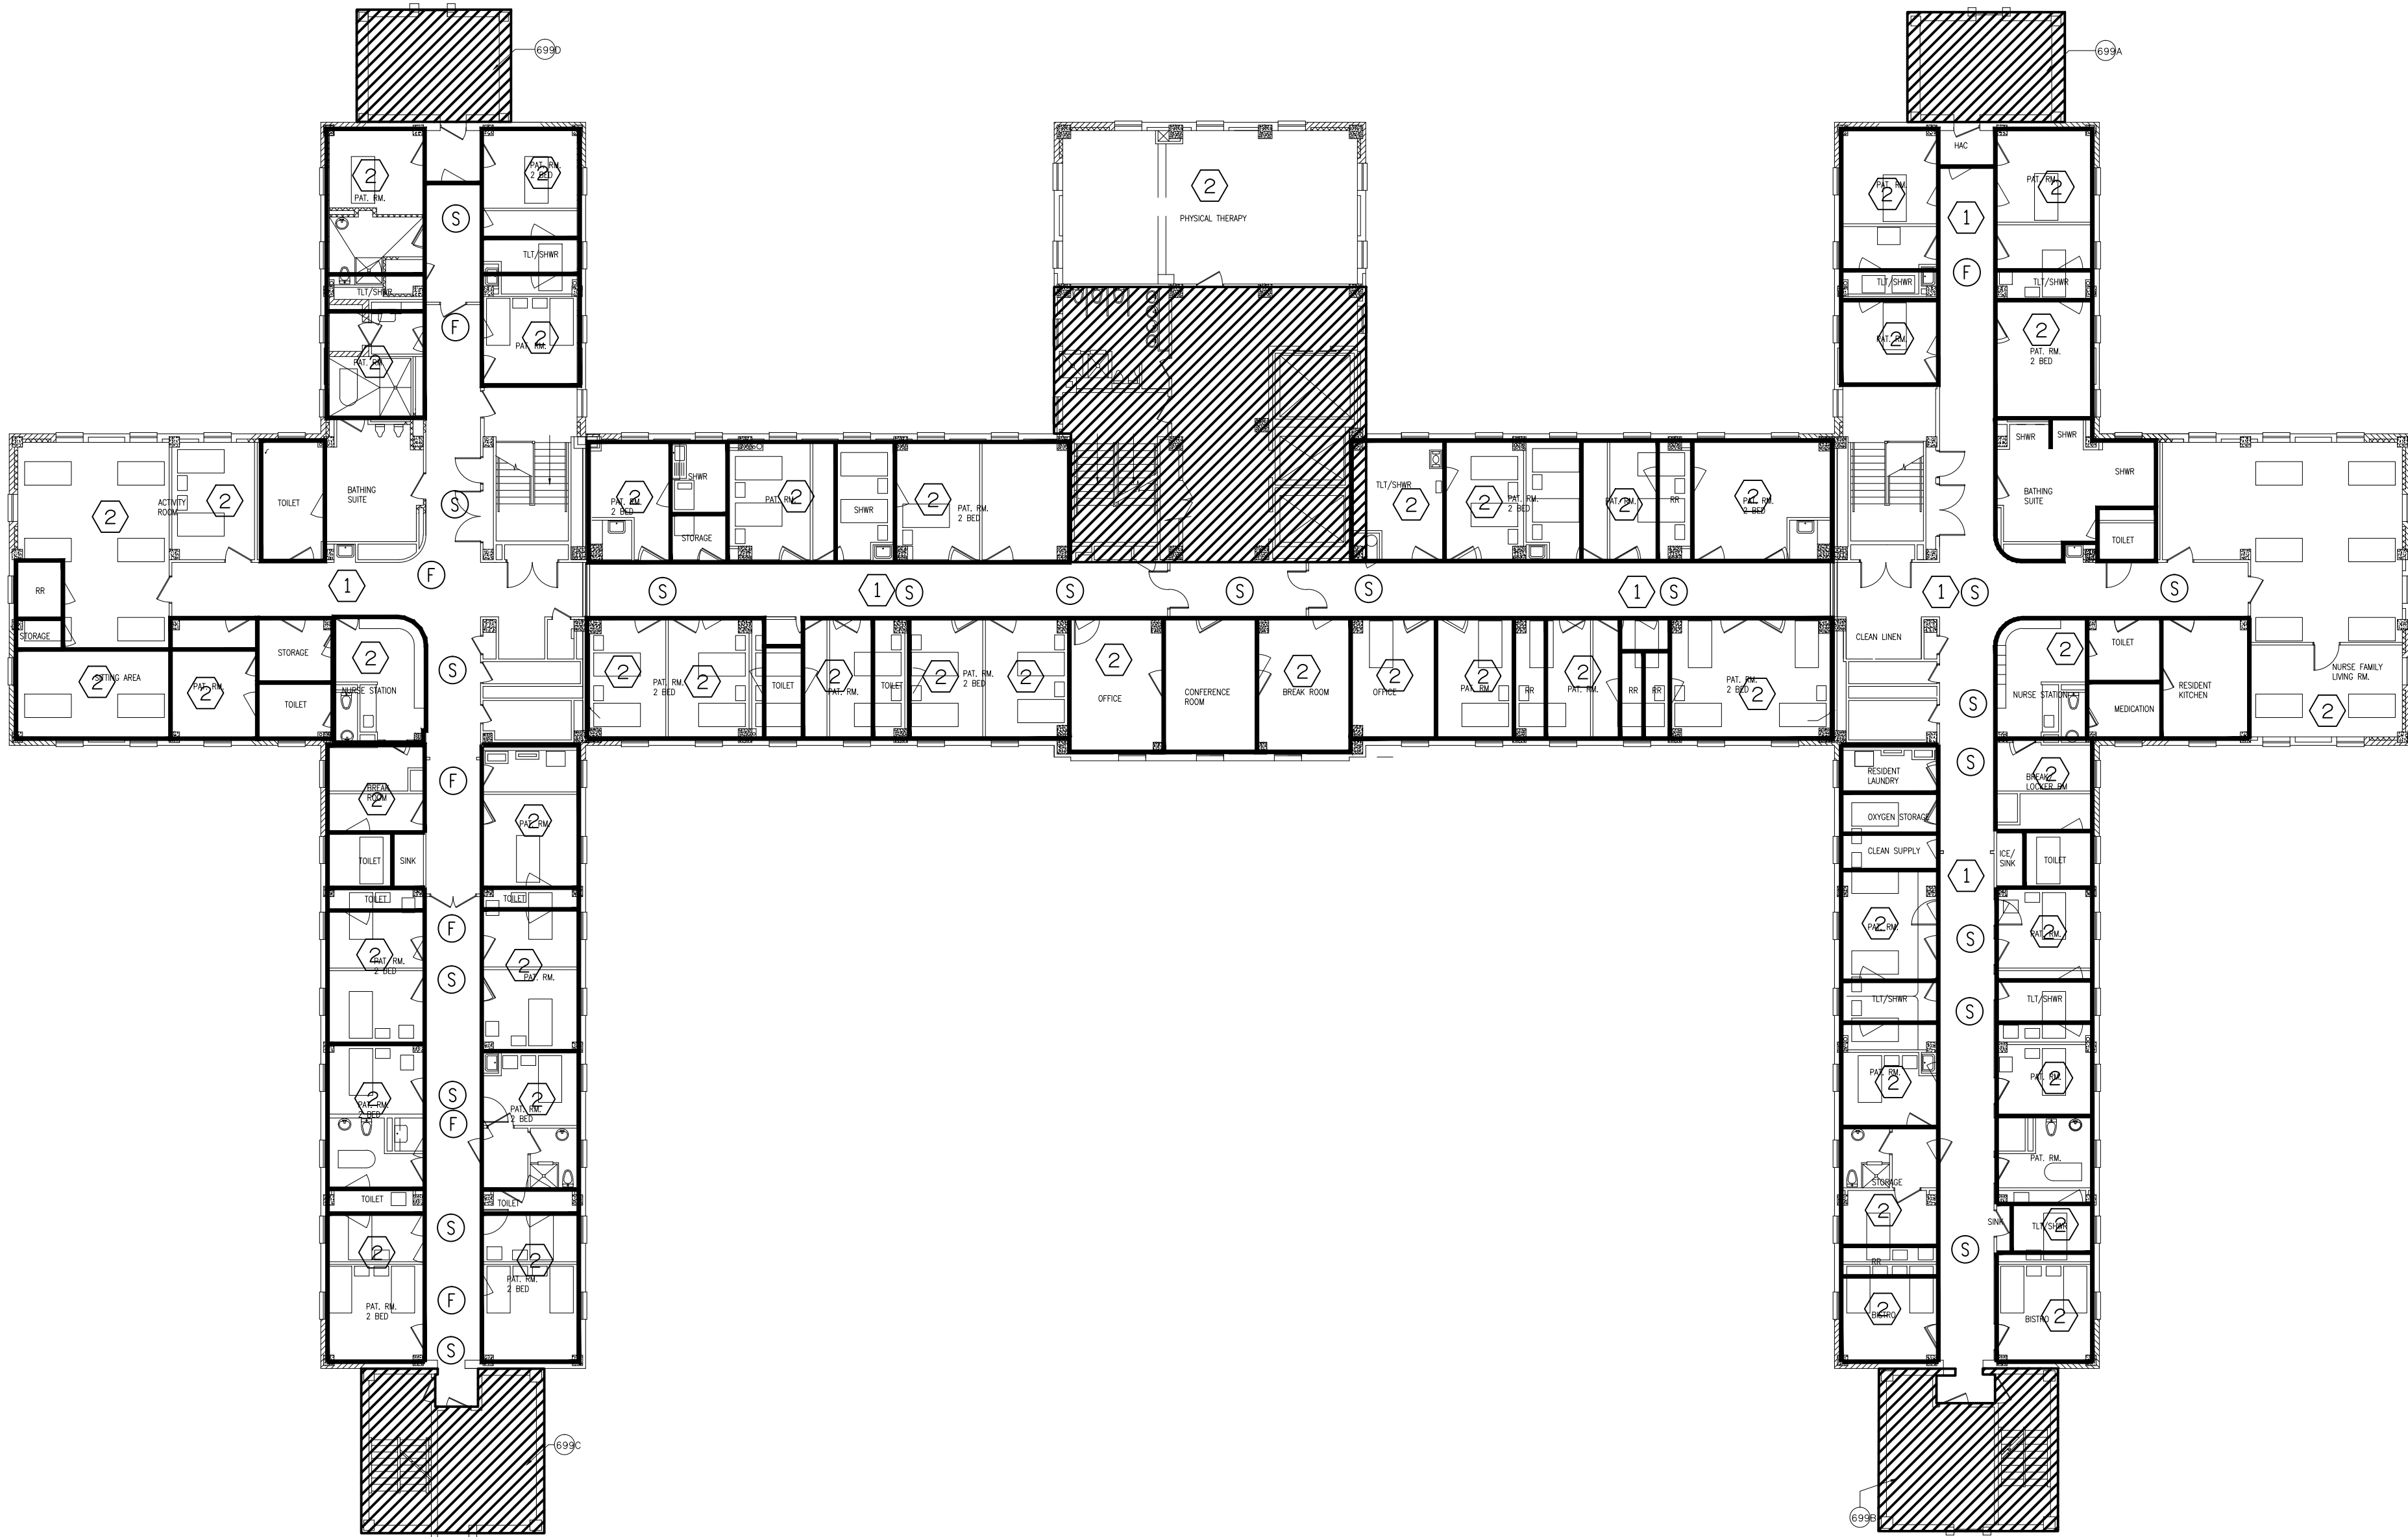

1 BLDG. 11 - 6TH FLR.
SCALE: 1/16" = 1'-0"

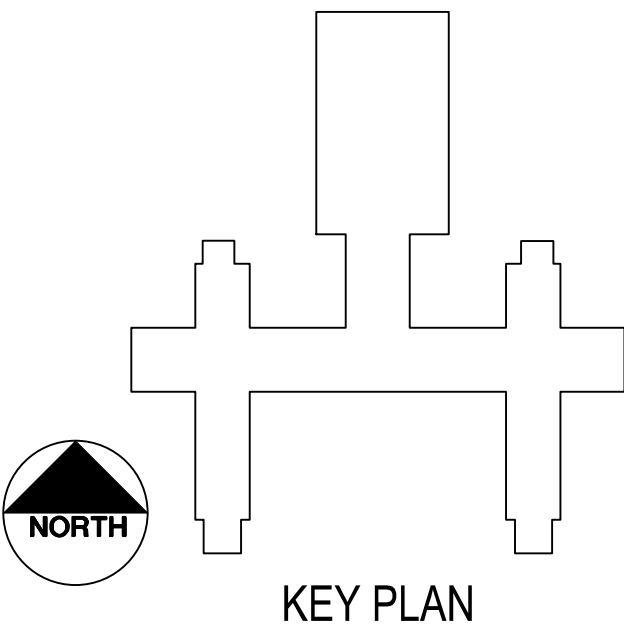

		CONSULTANTS:	<div><div>Goetting</div><div>Goetting & Associates, Inc. 12710 Research Blvd., Suite 355 Austin, Texas 78759 512/416-1654 FAX: 512/416-7547</div></div>	<div><div>ADRIAN LOZANO 64720 STATE OF TEXAS EXPIRES 09/15/13</div><div>TTG GOETTING, INC. P-903</div><div>07-15-13</div></div>	ARCHITECT/ENGINEERS:	<div><div>RH SHACKELFORD, INC SDVOSS</div></div>	Approved: Assistant Director	Approved: Chief of Staff	Approved: Chief, Engineering	Drawing Title ELECTRICAL NEW WORK BUILDING 11 - SIXTH FLOOR AUXILIARY SYSTEMS	Project Name KD AIR HANDLER REPLACEMENT (AHU) PROJECT - PHASE II	Project Number 671A4-09-119	Office of Construction and Facilities Management	
Revisions:							Approved: Service Chief	Approved: Service Chief	Approved: Service Chief					Date 09/13/12
		DATE		DESCRIPTION		Approved: Chief, Bio-Med	Approved: Chief, EMS	Approved: Chief, Infection Control	Location Kernville Veterans Hospital Veterans Affairs 2600 Memorial Blvd. Kernville, TX 78028	Building Number	Checked RTO	Drawn RTO	Drawing Number 11-EY104	Dwg. of
						Approved: Chief, IT	Approved: Chief, M&O	Approved: Chief, Police						
		DATE		DESCRIPTION		Approved: Chief, Safety	Approved: Chief	Approved: Chief						