


# CORRECT RETROCOMMISSIONING DEFICEIENCIES AND UPGRADE HVAC CONTROLS

Bldg #	Function
1	Hospital
2	
3	
4	
5	Administrative
	A&MM Admin
	Recreation Therapy
	Credit Union
6	Administrative
	Police & Security
	Environmental Mgt
	DSS
	ITS Training
	Teleconferencing
7	Warehouse
8	Administrative
	Engineering
9	Boiler/Chiller Plant
10	Smokestack
11	Water Tower
12	Administrative
	Engineering
13	Laundry
14	Incinerator
18	Carport
20	Nursing Home
22	Warehouse
24	Electric Switch
25	Fuel Storage
32	Shelter
33	Telephone Switch
34	ITS
35	Administrative
36	Administrative
37	Recreation/administrative

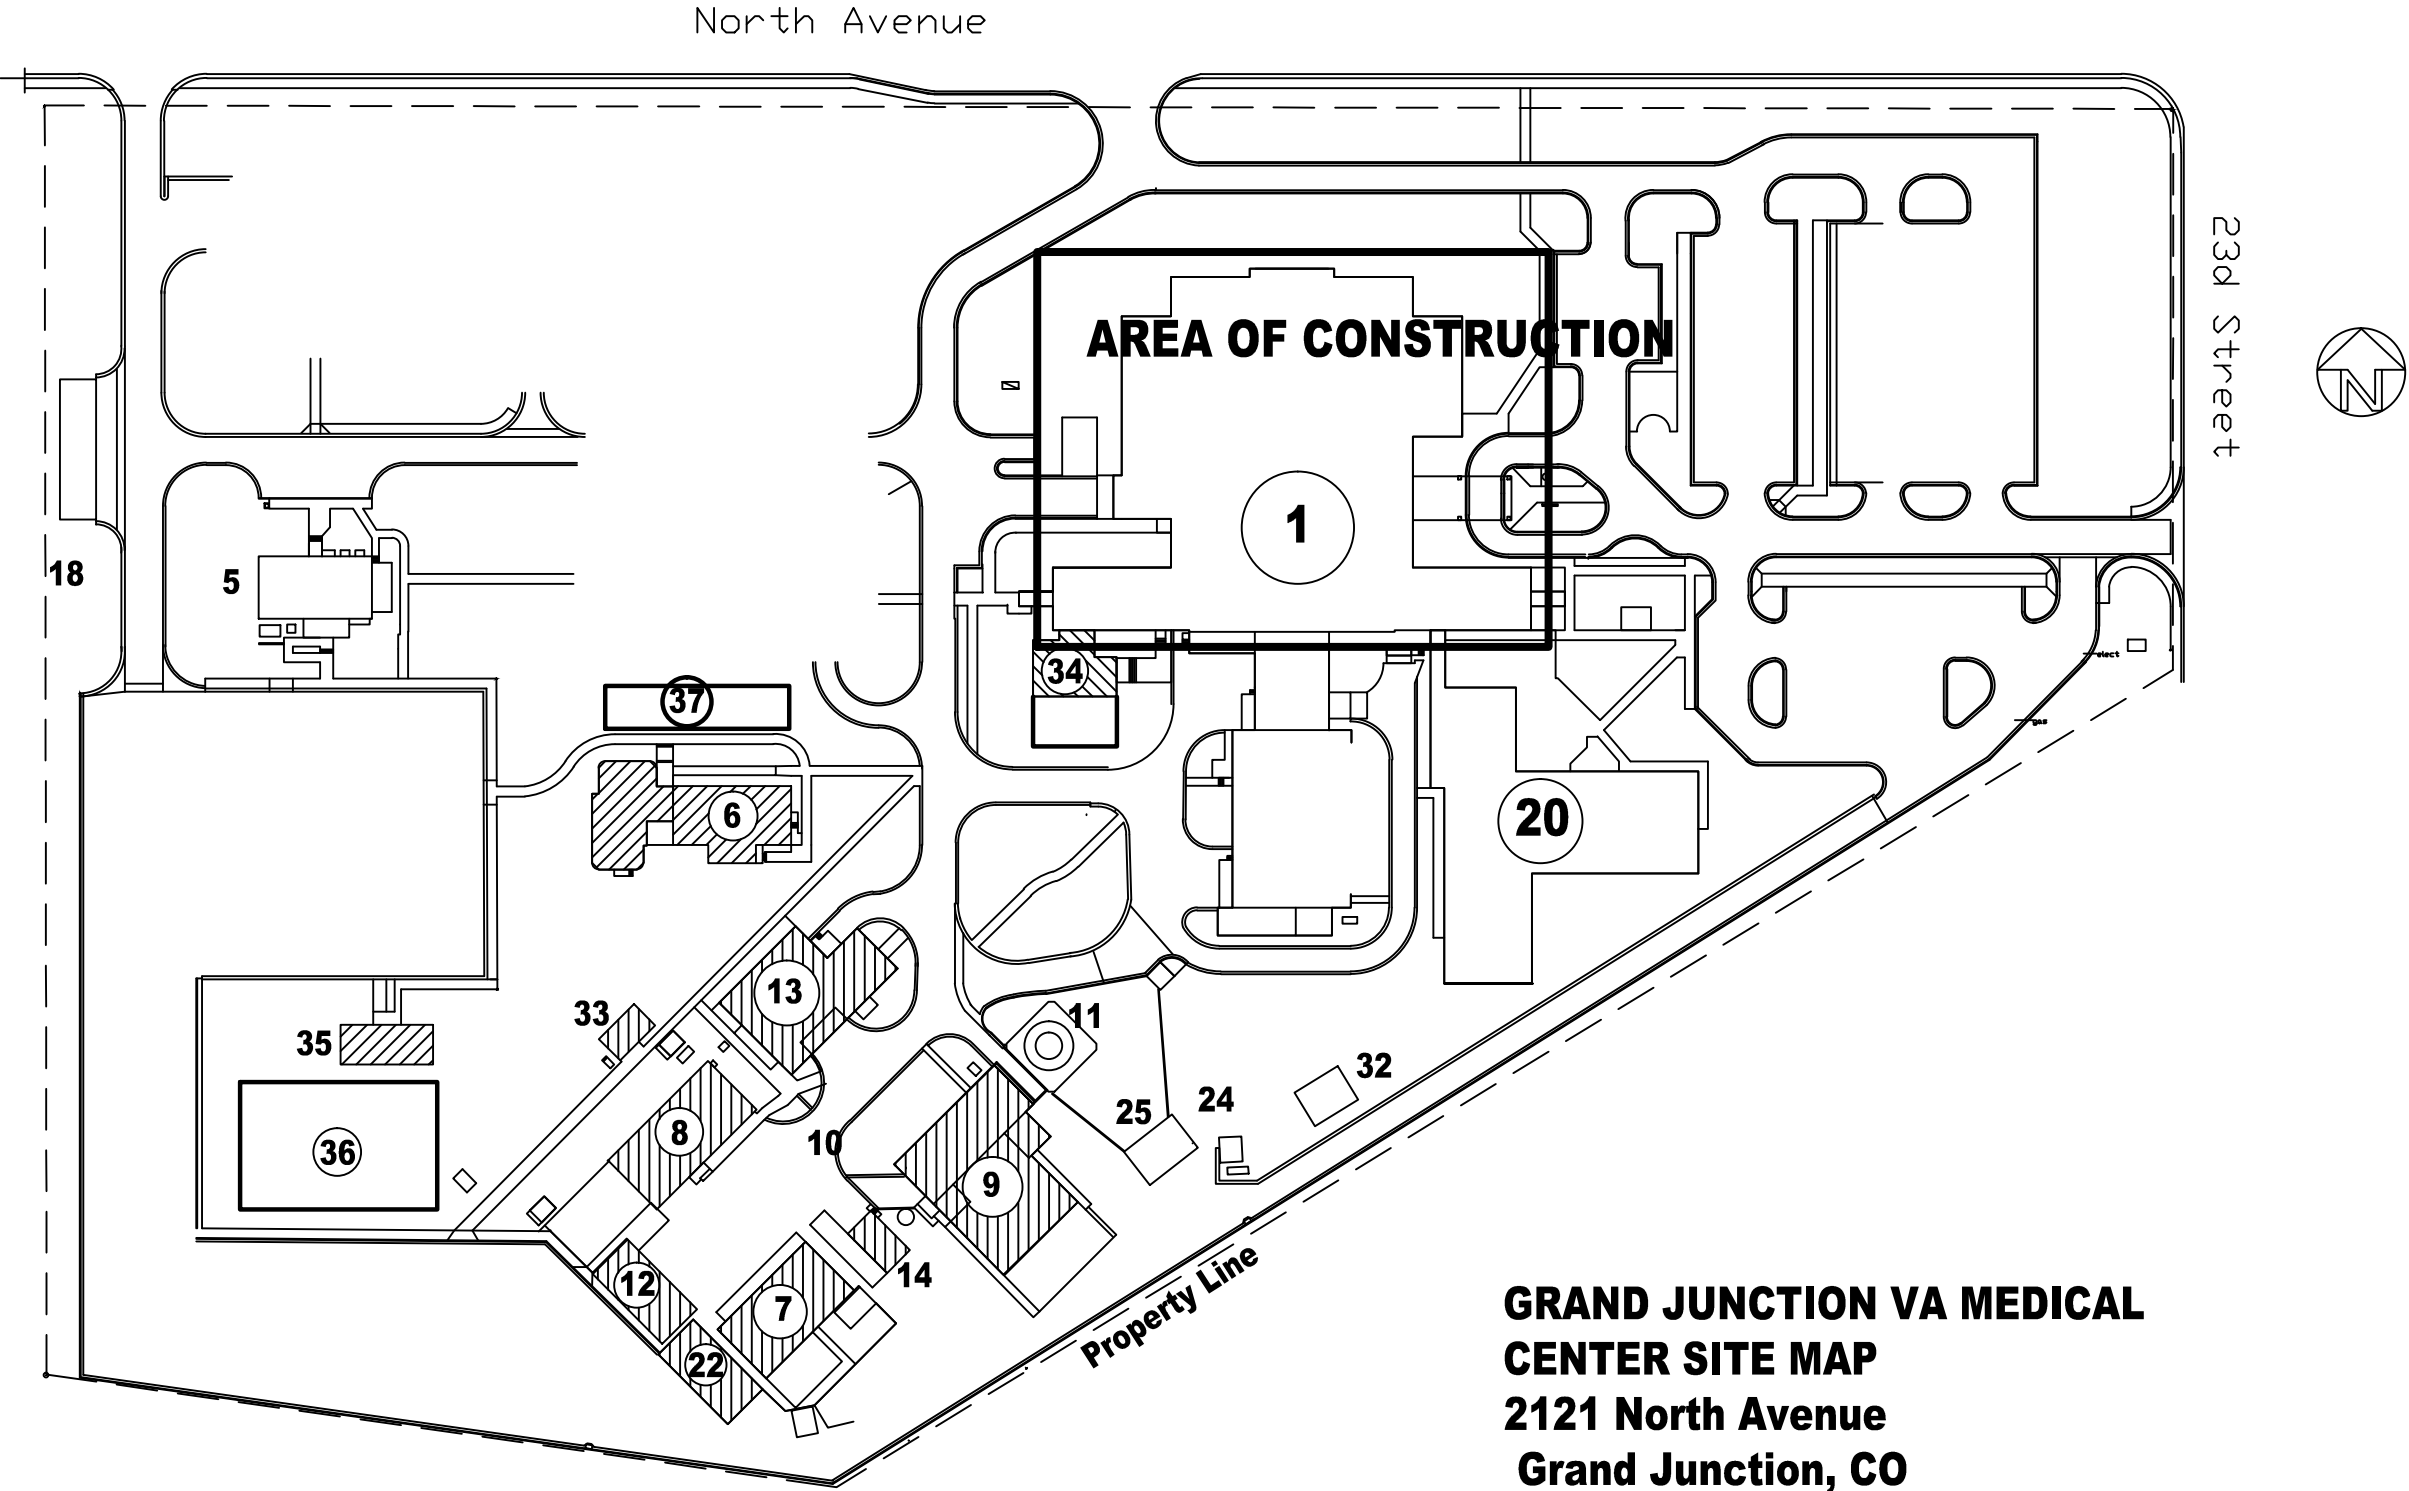

**GRAND JUNCTION VA MEDICAL  
CENTER SITE MAP  
2121 North Avenue  
Grand Junction, CO  
Site Plan**

Scale 1" = 100' 0"