



## KEY PLAN

SCALE: 1" = 40'-0"

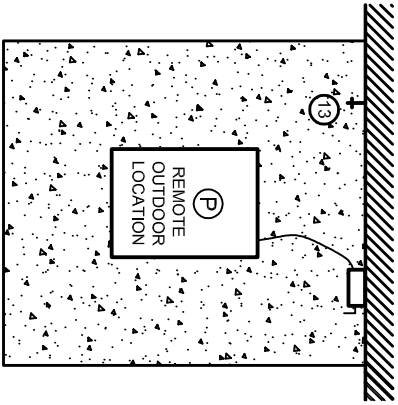

## CHILLER PLAN

SCALE: NONE

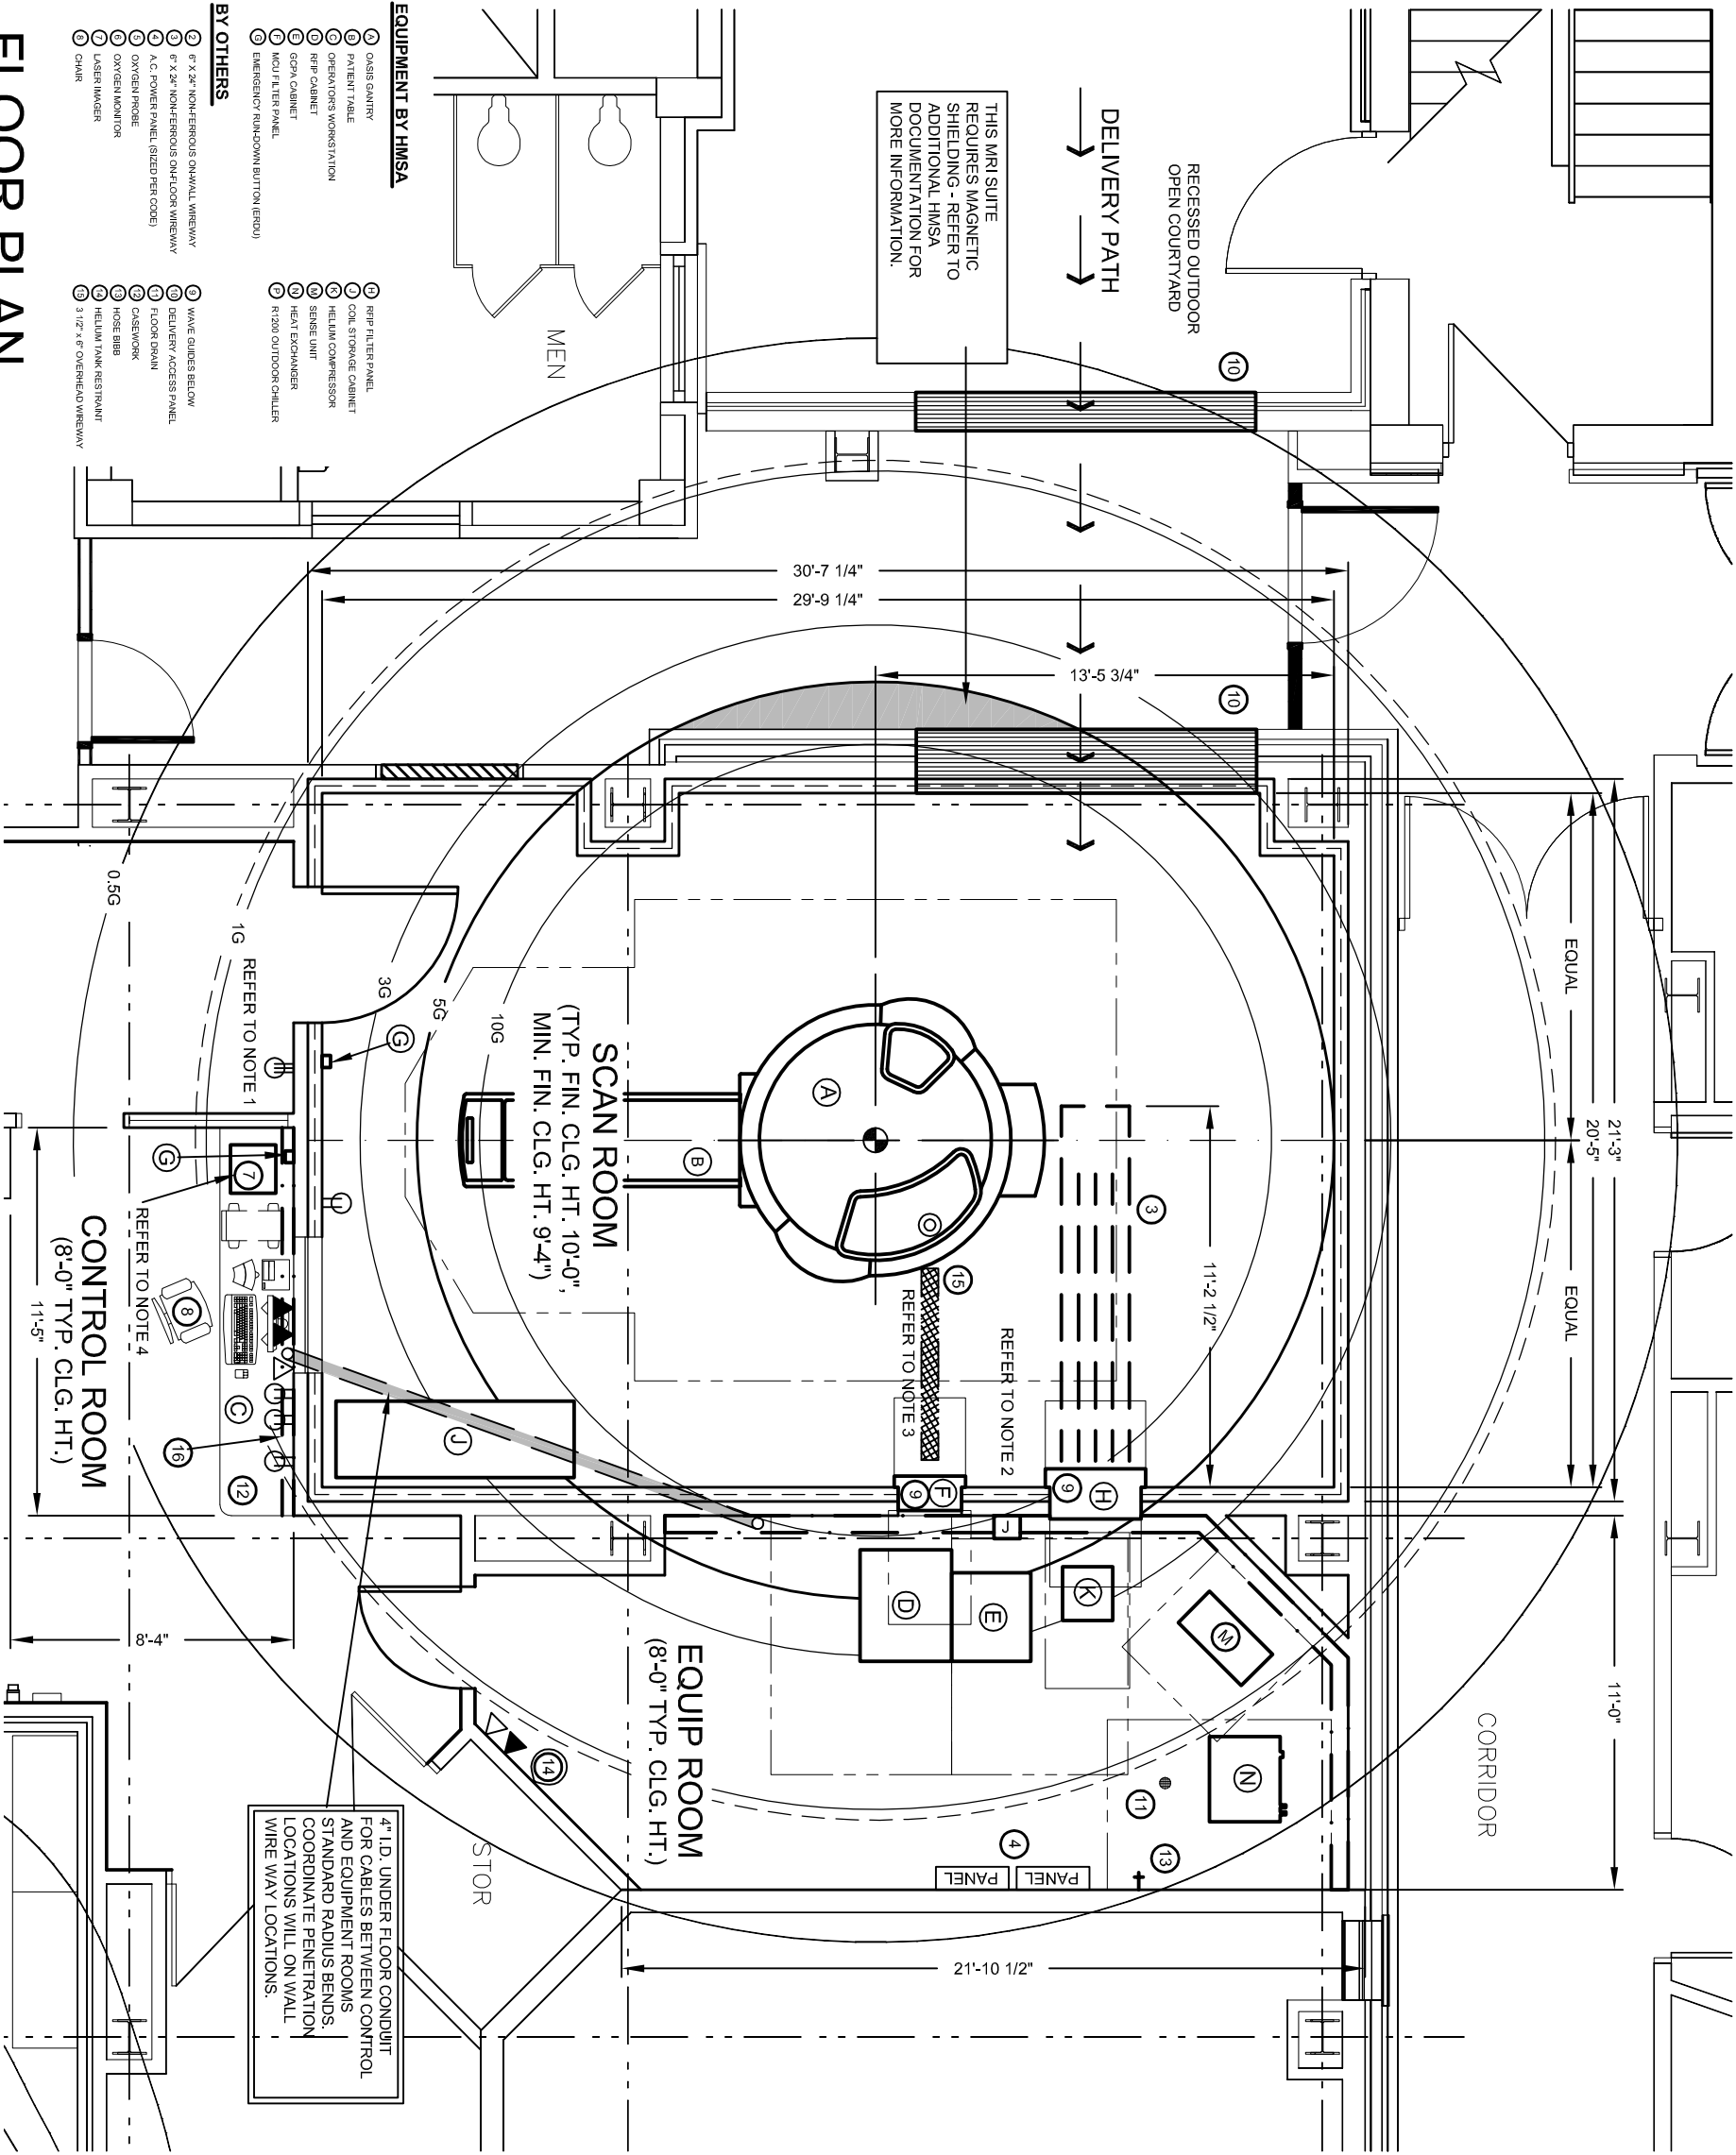

### EQUIPMENT BY HMSA

- 1 OASIS Gantry
- 2 Patient Table
- 3 Operators Workstation
- 4 RFP Cabinet
- 5 RFP Cabinet
- 6 RFP Cabinet
- 7 Emergency Run-down Button (ERBU)
- 8 RFP Filter Panel
- 9 Cool Storage Cabinet
- 10 Helium Compressor
- 11 SENSE Unit
- 12 Heat Exchanger
- 13 R-1200 Outdoor Chiller

### BY OTHERS

- 14 7' x 24" Non-Hermetic On-Wall Wireway
- 15 7' x 24" Non-Hermetic On-Floor Wireway
- 16 A.C. Power Panel (Sized Per Code)
- 17 Oxygen Probe
- 18 Oxygen Monitor
- 19 Laser Imager
- 20 Chair
- 21 Wave Guides Below
- 22 Delivery Access Panel
- 23 Floor Drain
- 24 Casework
- 25 Hose Bibb
- 26 Helium Tank Restraint
- 27 3 1/2" x 8" Overhead Wireway

## FLOOR PLAN

SCALE: 3/16"=1'-0"

CONTRACTOR TO VERIFY  
DIMENSIONS &  
CONDITIONS AT THE BUILDING

PRELIMINARY

NOT FOR CONSTRUCTION

**HITACHI**  
Inspire the Next

HITACHI MEDICAL SYSTEMS, AMERICA  
1959 SUMMIT COMMERCE PARK TWINSBURG, OH 44087-2371  
(800) 800-3106 WWW.HITACHIMED.COM

OASIS SITE PLAN PROPOSAL FOR:  
VA Health System of the Ozarks  
FAYETTEVILLE, AR

DATE: 11-18-14 DRAWN BY: T.J.P.  
SCALE: AS NOTED  
FOR DISCUSSION  
PURPOSES ONLY  
CONSULT SITE PLANNING PRIOR TO  
PREPARATION OF CONSTRUCTION  
DOCUMENTS