


PLUMBING GENERAL NOTES:

- CLOSE COOPERATION AND COOPERATION SHALL BE MAINTAINED BETWEEN TRADES WITH REGARD TO PLUMBING, FIRE PROTECTION, HVAC AND ELECTRICAL PLANS.
- PROG. TO THE START OF ANY WORK UNDER THIS CONTRACT. USE SITE SURVEY, SEE ELEVATION IS RELATED OR CONNECTED.
- CUT WALLS, FLOORS OR CEILINGS AS REQUIRED TO INSTALL NEW PIPING. PROVIDE ALL CEILING IMPACTS BY THE CONSTRUCTION WILL BE RETURNED TO PREVIOUS CONDITION WITH ALL SHOWN FINISHES.
- ALL NEW PIPING SHALL BE COORDINATED WITH EXISTING CONDITIONS.
- WVAC ENGINEERING PERSONNEL MUST HAVE ACCESS TO THE SERVICE ROOM AT ALL TIMES.
- MEDICAL GAS SYSTEM SHALL BE CERTIFIED PER SPECIFICATIONS.
- PPING IDENTIFICATION. REFERENCE VIA SPECIFICATION. DENSITY PAINTING SCHEDULE ON THE APPROPRIATE DRAWING. EVERY PIPE SHALL BE IDENTIFIED PER THE SPECIFICATION.
- LABEL ALL VALVES WITH ENGRAVED BRASS TAG WITH BUILDING NUMBER, SERVICE AND VALVE NUMBER. ATTACH TAG WITH A BRASS CHAIN. PROVIDE VALVE TAGS ON POLYETHYLENE GLASSER.
- USE BALL VALVES IN COPPER LINES PER SPECIFICATIONS.
- COPPER TUBE SHALL BE USED PER SPECIFICATIONS.
- ALL VALVES SHALL BE INSTALLED IN AN ACCESSIBLE LOCATION WITH A MINIMUM OF TWO FEET OF CLEARANCE FOR SERVICE.
- COMPLETE LAYOUT DRAWINGS SHALL BE REQUIRED BY PARAGRAPH, SUBMITTALS. CONSTRUCTION WORK SHALL NOT START ON ANY SYSTEM UNTIL THE LAYOUT DRAWINGS HAVE BEEN APPROVED.
- COORDINATE LOCATION OF FLOOR DRAIN AND HOSE BIBS WITH HIRE EQUIPMENT MANUFACTURER.
- PROVIDE WATER HAMMER ARRESTORS ON HOT AND COLD WATER SUPPLIES TO FIXTURES AS SHOWN ON DRAWINGS.
- ALL SUPPLIES SHALL BE PROVIDED WITH A HIGH-EAR COUPLING EQUAL TO WELTER NO. 1000. 1/2" 3/4" OR 1" SIZE AT THE WALL ANCHORED TO CROSS-MEMBER SUPPORT. BE ONE THE EXISTING ROOM SPACE TO ASSURE NO PIPE PENETRATES WITHIN WALL CAVITY.
- ALL FLOOR DRAINS SHALL BE PROVIDED WITH DEEP-SEAL TYPE TRAP WITH NOT LESS THAN 10" MINIMUM DEPTH. TRAP SHALL BE PROVIDED WITH A TRAP PRIMER TO CONNECTION ON FLOOR DRAIN. INSTALL TRAP PRIMER ABOVE ACCESSIBLE CEILING.


PLUMBING LEGEND

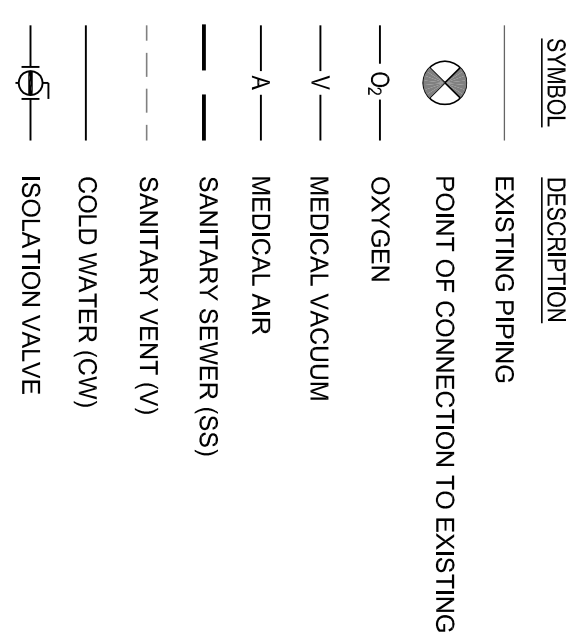

2 PLUMBING DRAIN RISER

P101


Scale: N.T.S.

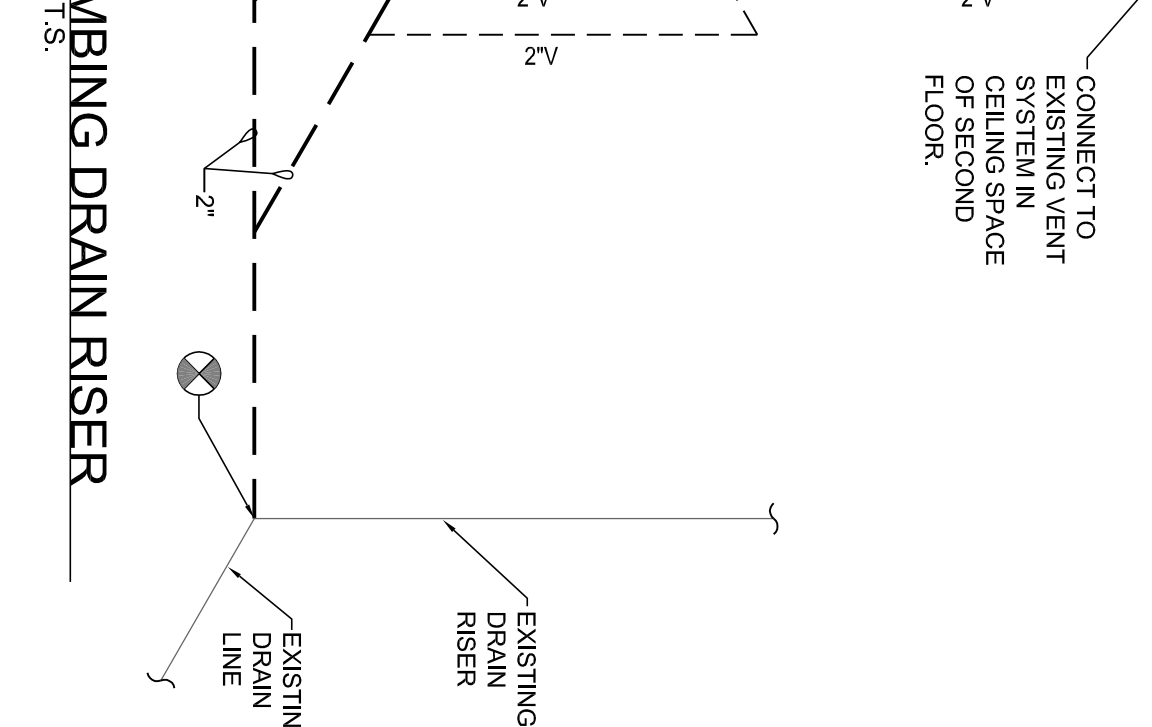

3 MECHANICAL MAKE-UP WATER RPZ

P101


Scale: N.T.S.

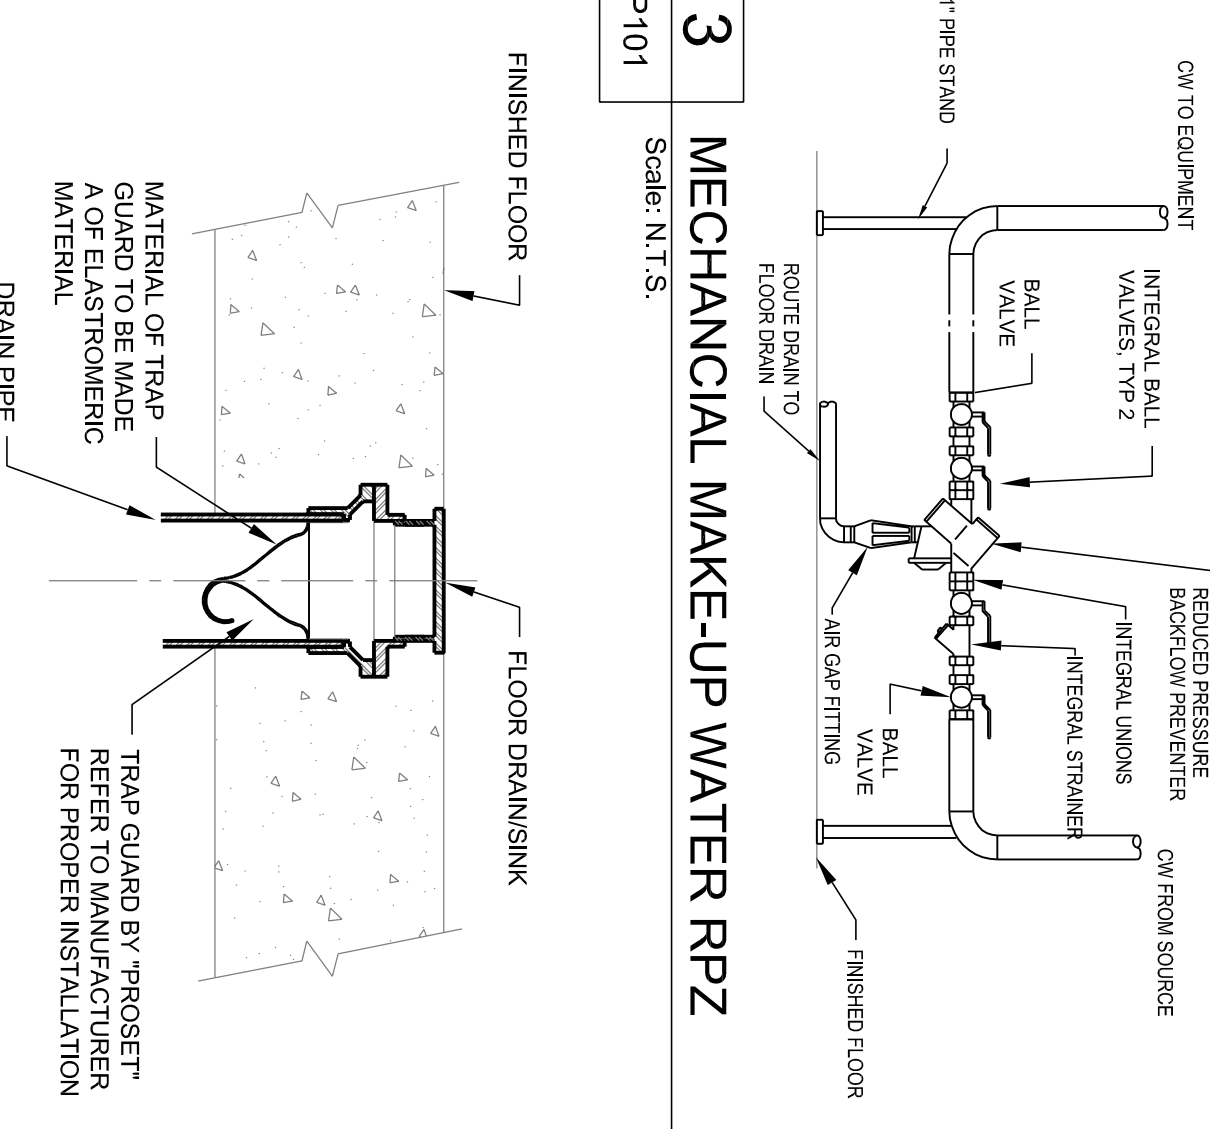

4 TRAP-GUARD DETAIL

P101

Scale: N.T.S.

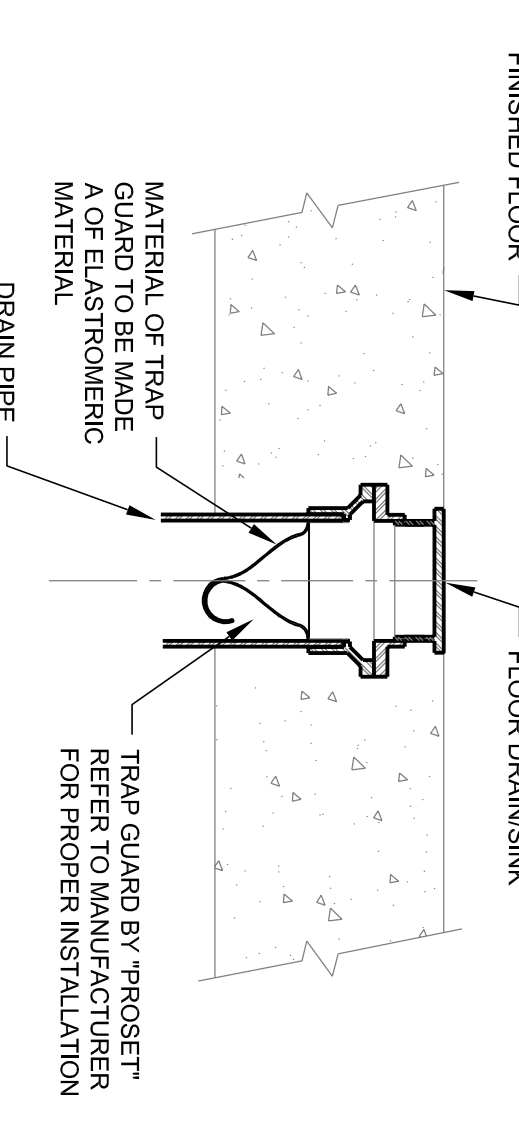

PLUMBING KEYED NOTES:

- FLOOR DRAIN SHALL BE LOCATED LEVEL WITH THE TOP OF THE ELEVATED FLOOR SYSTEM.
- FLOOR DRAIN SHALL BE LOCATED BELOW THE ELEVATED FLOOR SYSTEM.
- SUPPLEMENTAL MAKE-UP WATER. REFER TO MECHANICAL PLANS FOR CONTINUATION.

WATER HAMMER ARRESTOR SCHEDULE

ITEM	FIXTURE	DESCRIPTION	SIZE	COLD	HOT
WCO-1	FLOOR DRAIN	PROVIDE "T" W/ AMCO OR FABRICATED EQUAL MEDICAL GAS CHUTE. PROVIDE ONE MEDICAL AIR, ONE MEDICAL OXYGEN, ONE MEDICAL VACUUM OUTLET AND ONE SLIDE.	AS NOTED	AS NOTED	AS NOTED

ITEM	FIXTURE	DESCRIPTION	SIZE	COLD	HOT
WCO-1	FLOOR DRAIN	PROVIDE "T" W/ AMCO OR FABRICATED EQUAL MEDICAL GAS CHUTE. PROVIDE ONE MEDICAL AIR, ONE MEDICAL OXYGEN, ONE MEDICAL VACUUM OUTLET AND ONE SLIDE.	AS NOTED	AS NOTED	AS NOTED

ITEM	FIXTURE	DESCRIPTION	SIZE	COLD	HOT
WCO-1	FLOOR DRAIN	PROVIDE "T" W/ AMCO OR FABRICATED EQUAL MEDICAL GAS CHUTE. PROVIDE ONE MEDICAL AIR, ONE MEDICAL OXYGEN, ONE MEDICAL VACUUM OUTLET AND ONE SLIDE.	AS NOTED	AS NOTED	AS NOTED


SITE PREP FOR MAGNETIC RESONANCE IMAGING EQUIPMENT

P101


Scale: N.T.S.



CONSULTANTS:	Structural Engineer: Bob D. Campbell & Co. 4338 Bellevue Kansas City, MO 64111	MEP Engineer: TME, Inc. 2039 N. Green Acres Road Fayetteville, AR 72703	Associate Architect: SPURJ Design One Santa Fe Plaza, Suite 101 Oklahoma City, OK 73102	Cost Estimating: CMR 5201 Johnson Dr., Suite 330 Mission, KS 66205
--------------	--	---	---	--

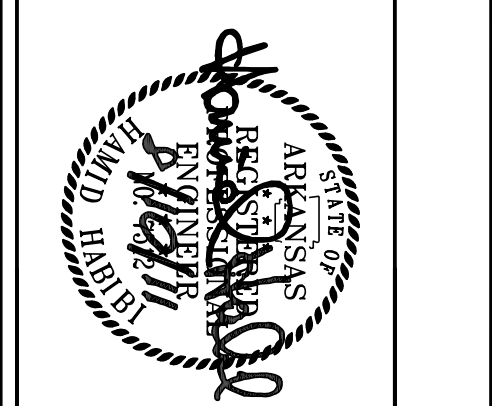

ARCHITECT: RAD-Planning RADIOLOGY PLANNING 802 Broadway, 8th Floor Kansas City, MO 64108 816.472.7722 www.RAD-Planning.com

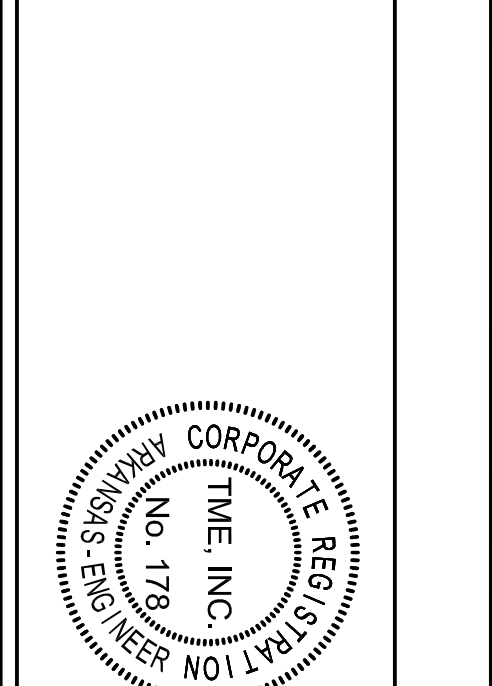

Drawing Title	New Plan First Floor Plumbing
Approved: Project Director	

Project Title	SITE PREP FOR MAGNETIC RESONANCE IMAGING EQUIPMENT
Project Number	564-10-101
Building Number	2
Drawing Number	P101

Office of Facilities Management Department of Veterans Affairs