



FIRE SUPPRESSION SYSTEM LEGEND


- TS TAMPER SWITCH
- FDC FIRE DEPARTMENT CONNECTION
- SPRINKLER MAINS
- SLOPE PIPE IN THIS DIRECTION
- DIRECTION OF WATER FLOW
- ORDINARY HAZARD GROUP 1 CLASSIFICATION

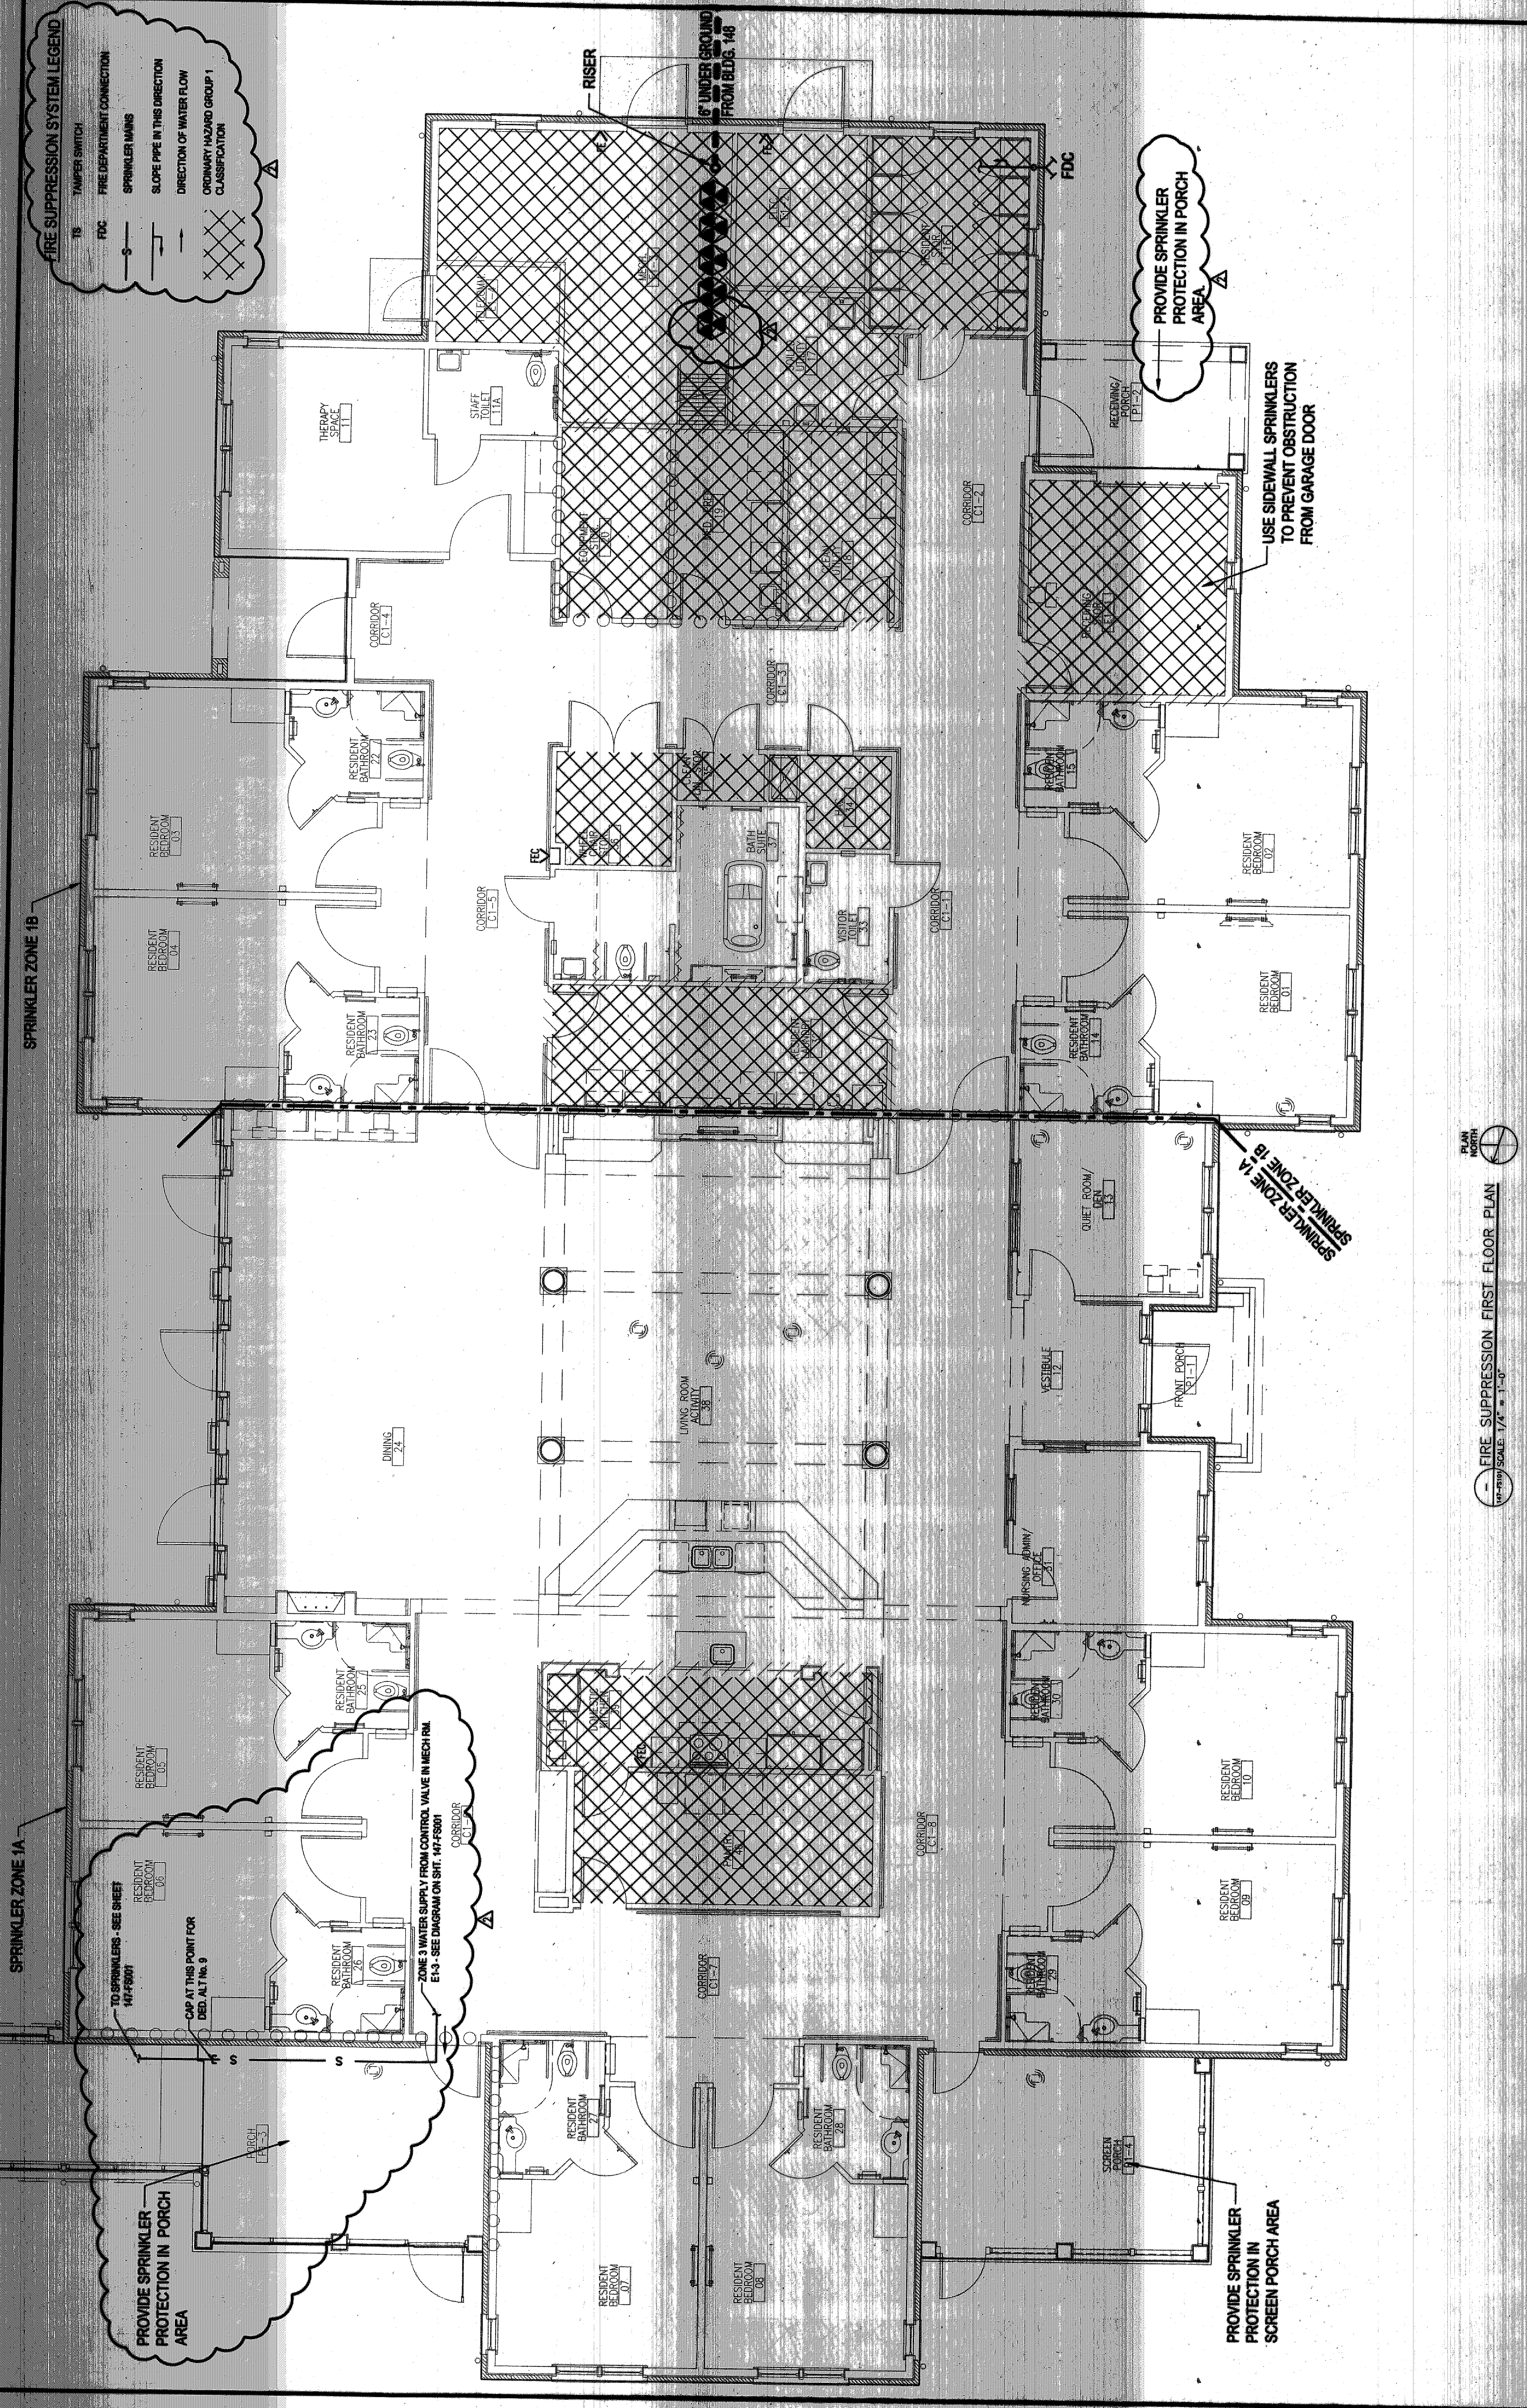

PLAN NORTH
 FIRE SUPPRESSION FIRST FLOOR PLAN
 1/4" = 1'-0"

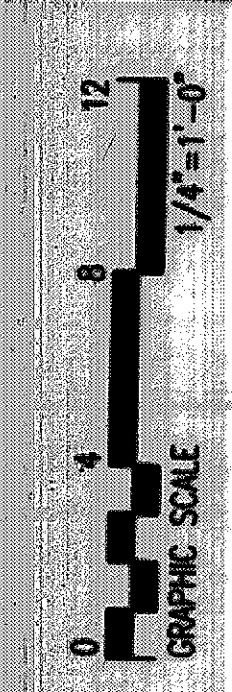

Revision No. 2 03/07/15		Project Title OF/OEF COTTAGE		Date 12 05 2014		Veterans Administration	
Drawings 1/4" = 1'-0"		Project No. 679-CSH-311		Project No. 679-CSH-311		File Name 147-FS01	
Building Number 147		Checked JACD		Drawn BRT		Location VAMC - TUSCALOOSA, ALABAMA	
Approved [Signature]		Building Number 147		Checked JACD		Drawn BRT	
Approved [Signature]		Building Number 147		Checked JACD		Drawn BRT	
Approved [Signature]		Building Number 147		Checked JACD		Drawn BRT	

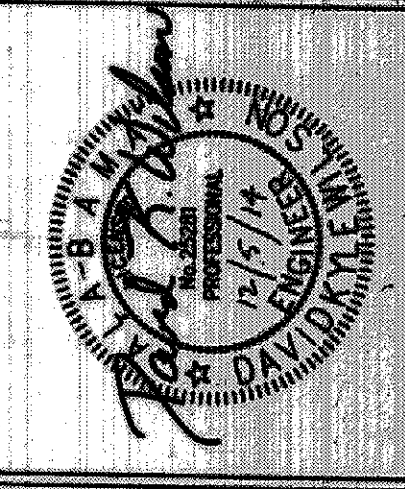

2101 Magnolia Avenue South, Suite 100
 Birmingham, Alabama 35205
 Telephone: (205)254-9100 Fax: (205)254-9144
 3047 Carter Hill Road
 Montgomery, Alabama 36111-0006
 Telephone: (334)263-6481 Fax: (334)264-4509

SHERLOCK SMITH & ADAMS
 ARCHITECTS / ENGINEERS