



three inches = one foot
one and one half inches = one foot
one inch = one foot
three quarters inch = one foot
one half inch = one foot
three eighths inch = one foot
one quarter inch = one foot
one eighth inch = one foot

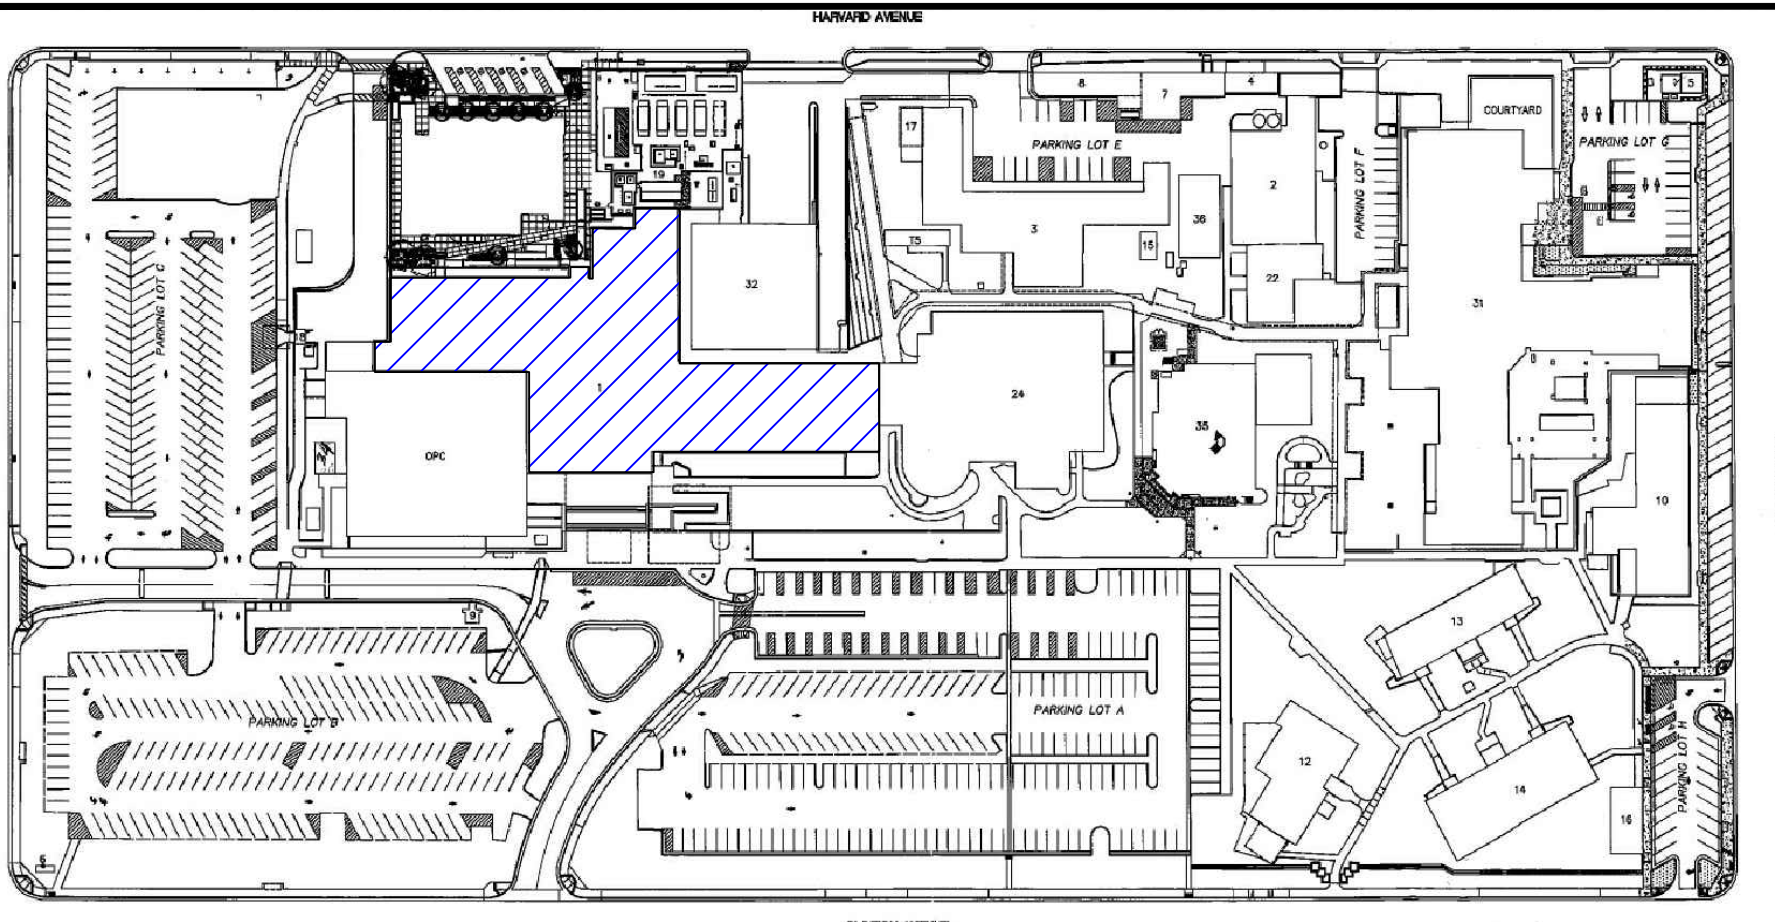

VICINITY MAP

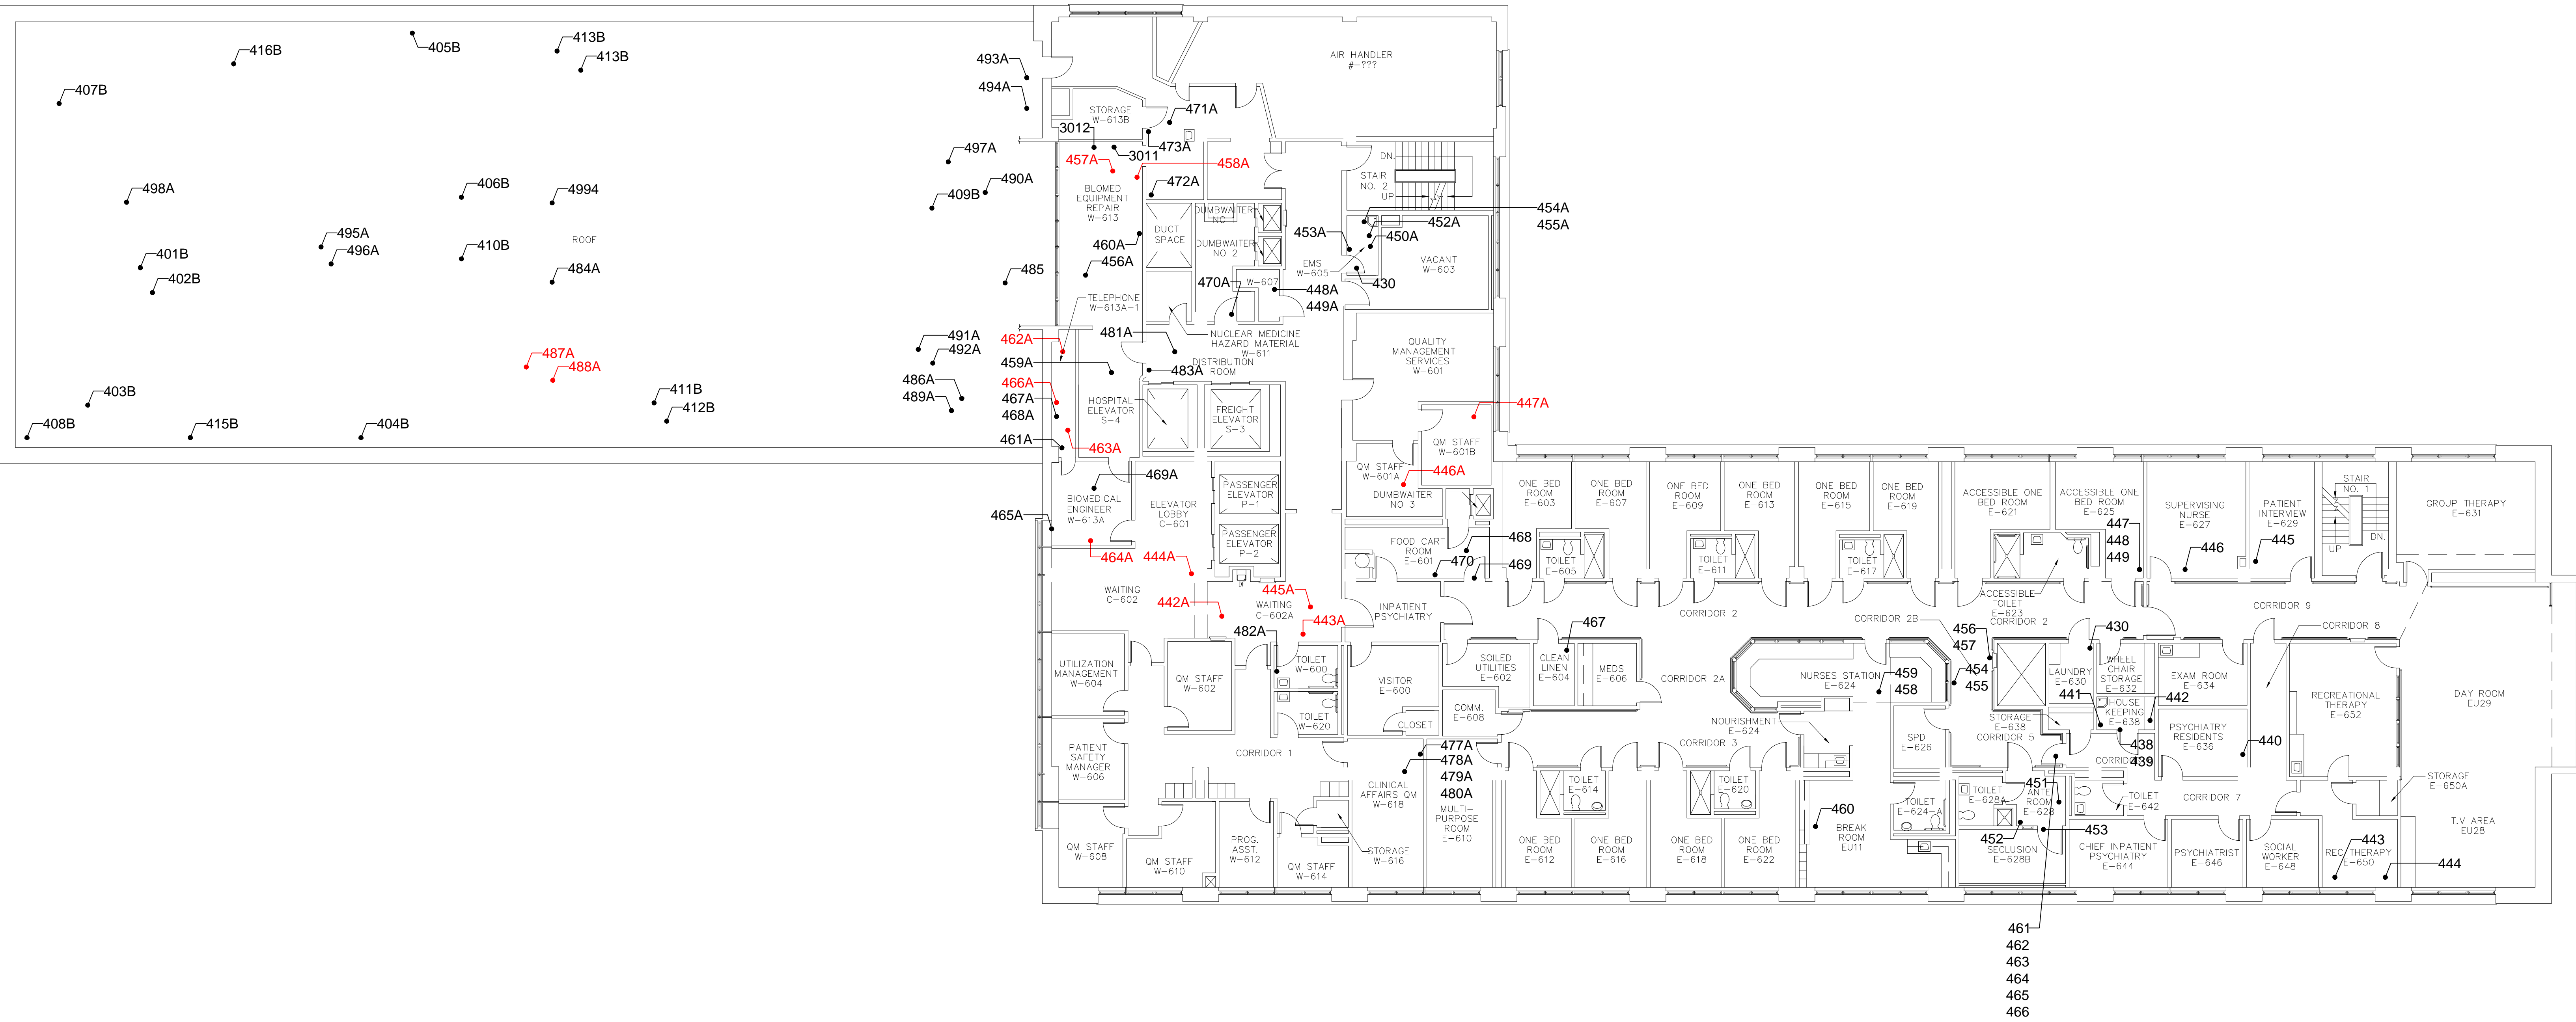

LEGEND

- 3XXX = SAMPLE POSITIVE FOR ACM (10/18/12)
- 3XXX = NON ACM SAMPLE LOCATION (10/18/12)
- 4XX = SAMPLE POSITIVE FOR ACM (10/2/12)
- 4XX = NON ACM SAMPLE LOCATION (10/2/12)
- 4XXX = SAMPLE POSITIVE FOR ACM (10/2/12)
- 4XXX = NON ACM SAMPLE LOCATION (10/2/12)

CONSULTANTS:		ARCHITECT/ENGINEERS:		Drawing Title	Project Title	Project Number	Office of Construction and Facilities Management Department of Veterans Affairs	
MILLENNIUM CONSULTING ASSOCIATES A MECA Consulting, Inc. Company		Indus Systems, Inc. 2352, Main Street, Concord MA 01742 Tel: 978-461-0555 www.indus-systems.com		SIXTH FLOOR PLAN SAMPLE LOCATIONS	ASBESTOS SURVEY VA FRESNO	261-12-J-2610		
Revisions		Date		Approved Project Director	Location	Drawing Number	Dwg. 8 of 10	
					VAMC FRESNO CALIFORNIA			
					Date	Checked	Drawn	
					11/5/12	KM	JR3	