


SYMBOL	DESCRIPTION
	RED LINE
	GREEN LINE
	BLUE LINE
	PURPLE LINE
	RED LINE WITH CROSS
	GREEN LINE WITH CROSS
	BLUE LINE WITH CROSS
	PURPLE LINE WITH CROSS
	RED LINE WITH CIRCLE
	GREEN LINE WITH CIRCLE
	BLUE LINE WITH CIRCLE
	PURPLE LINE WITH CIRCLE
	RED LINE WITH SQUARE
	GREEN LINE WITH SQUARE
	BLUE LINE WITH SQUARE
	PURPLE LINE WITH SQUARE
	RED LINE WITH TRIANGLE
	GREEN LINE WITH TRIANGLE
	BLUE LINE WITH TRIANGLE
	PURPLE LINE WITH TRIANGLE
	RED LINE WITH DIAMOND
	GREEN LINE WITH DIAMOND
	BLUE LINE WITH DIAMOND
	PURPLE LINE WITH DIAMOND
	RED LINE WITH STAR
	GREEN LINE WITH STAR
	BLUE LINE WITH STAR
	PURPLE LINE WITH STAR
	RED LINE WITH CIRCLE AND CROSS
	GREEN LINE WITH CIRCLE AND CROSS
	BLUE LINE WITH CIRCLE AND CROSS
	PURPLE LINE WITH CIRCLE AND CROSS
	RED LINE WITH SQUARE AND CROSS
	GREEN LINE WITH SQUARE AND CROSS
	BLUE LINE WITH SQUARE AND CROSS
	PURPLE LINE WITH SQUARE AND CROSS
	RED LINE WITH TRIANGLE AND CROSS
	GREEN LINE WITH TRIANGLE AND CROSS
	BLUE LINE WITH TRIANGLE AND CROSS
	PURPLE LINE WITH TRIANGLE AND CROSS
	RED LINE WITH DIAMOND AND CROSS
	GREEN LINE WITH DIAMOND AND CROSS
	BLUE LINE WITH DIAMOND AND CROSS
	PURPLE LINE WITH DIAMOND AND CROSS
	RED LINE WITH STAR AND CROSS
	GREEN LINE WITH STAR AND CROSS
	BLUE LINE WITH STAR AND CROSS
	PURPLE LINE WITH STAR AND CROSS

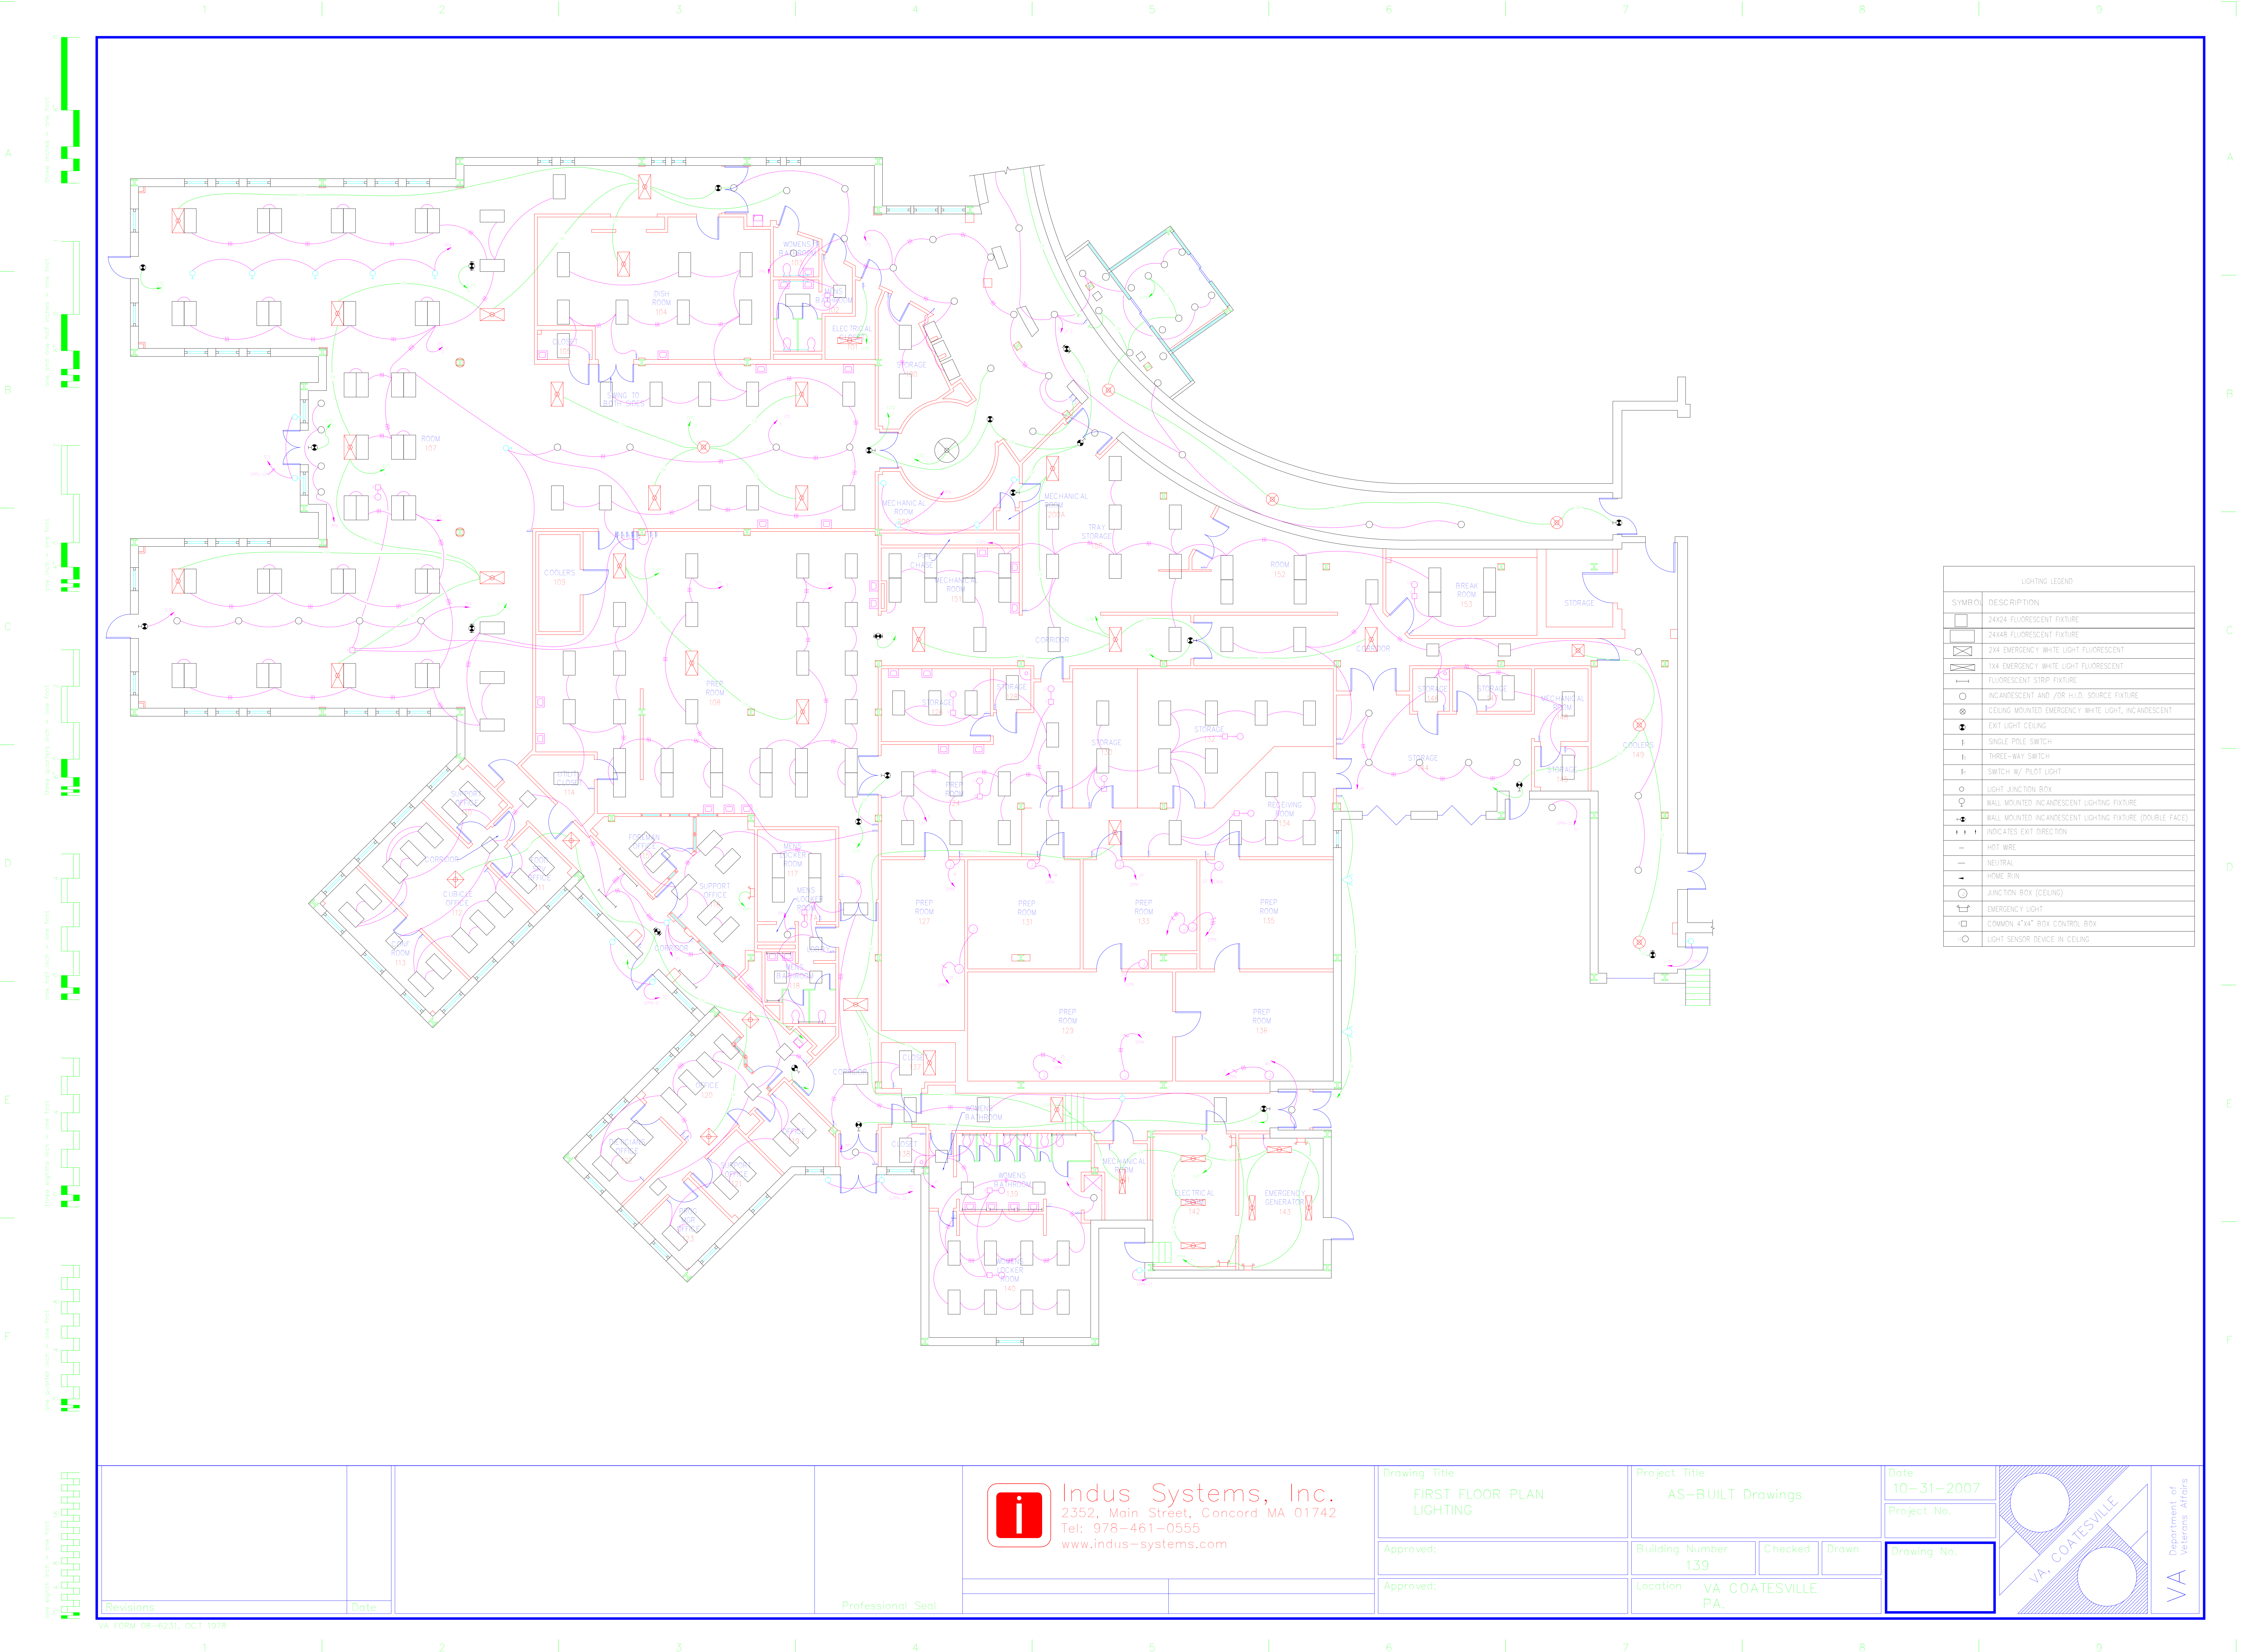

LIGHTING LEGEND	
SYMBOL	DESCRIPTION
	24X24 FLUORESCENT FIXTURE
	24X48 FLUORESCENT FIXTURE
	2X4 EMERGENCY WHITE LIGHT FLUORESCENT
	1X4 EMERGENCY WHITE LIGHT FLUORESCENT
	FLUORESCENT STRIP FIXTURE
	INCANDESCENT AND /OR HLD. SOURCE FIXTURE
	CEILING MOUNTED EMERGENCY WHITE LIGHT, INCANDESCENT
	EXIT LIGHT CEILING
	SINGLE POLE SWITCH
	THREE-WAY SWITCH
	SWITCH W/ PILOT LIGHT
	LIGHT JUNCTION BOX
	WALL MOUNTED INCANDESCENT LIGHTING FIXTURE
	WALL MOUNTED INCANDESCENT LIGHTING FIXTURE (DOUBLE FACE)
	INDICATES EXIT DIRECTION
	HOT WIRE
	NEUTRAL
	HOME RUN
	JUNCTION BOX (CEILING)
	EMERGENCY LIGHT
	COMMON 4'X4' BOX CONTROL BOX
	LIGHT SENSOR DEVICE IN CEILING

Revisions		Date	Professional Seal		Drawing Title FIRST FLOOR PLAN LIGHTING		Project Title AS-BUILT Drawings		Date 10-31-2007		Department of Veterans Affairs VA
					Approved:		Building Number 139	Checked	Drawn		
					Approved:		Location VA COATESVILLE PA.	Drawing No.			