


three inches = one foot
one and one half inches = one foot
one inch = one foot
three quarters inch = one foot
one half inch = one foot
three eighths inch = one foot
one quarter inch = one foot
one eighth inch = one foot

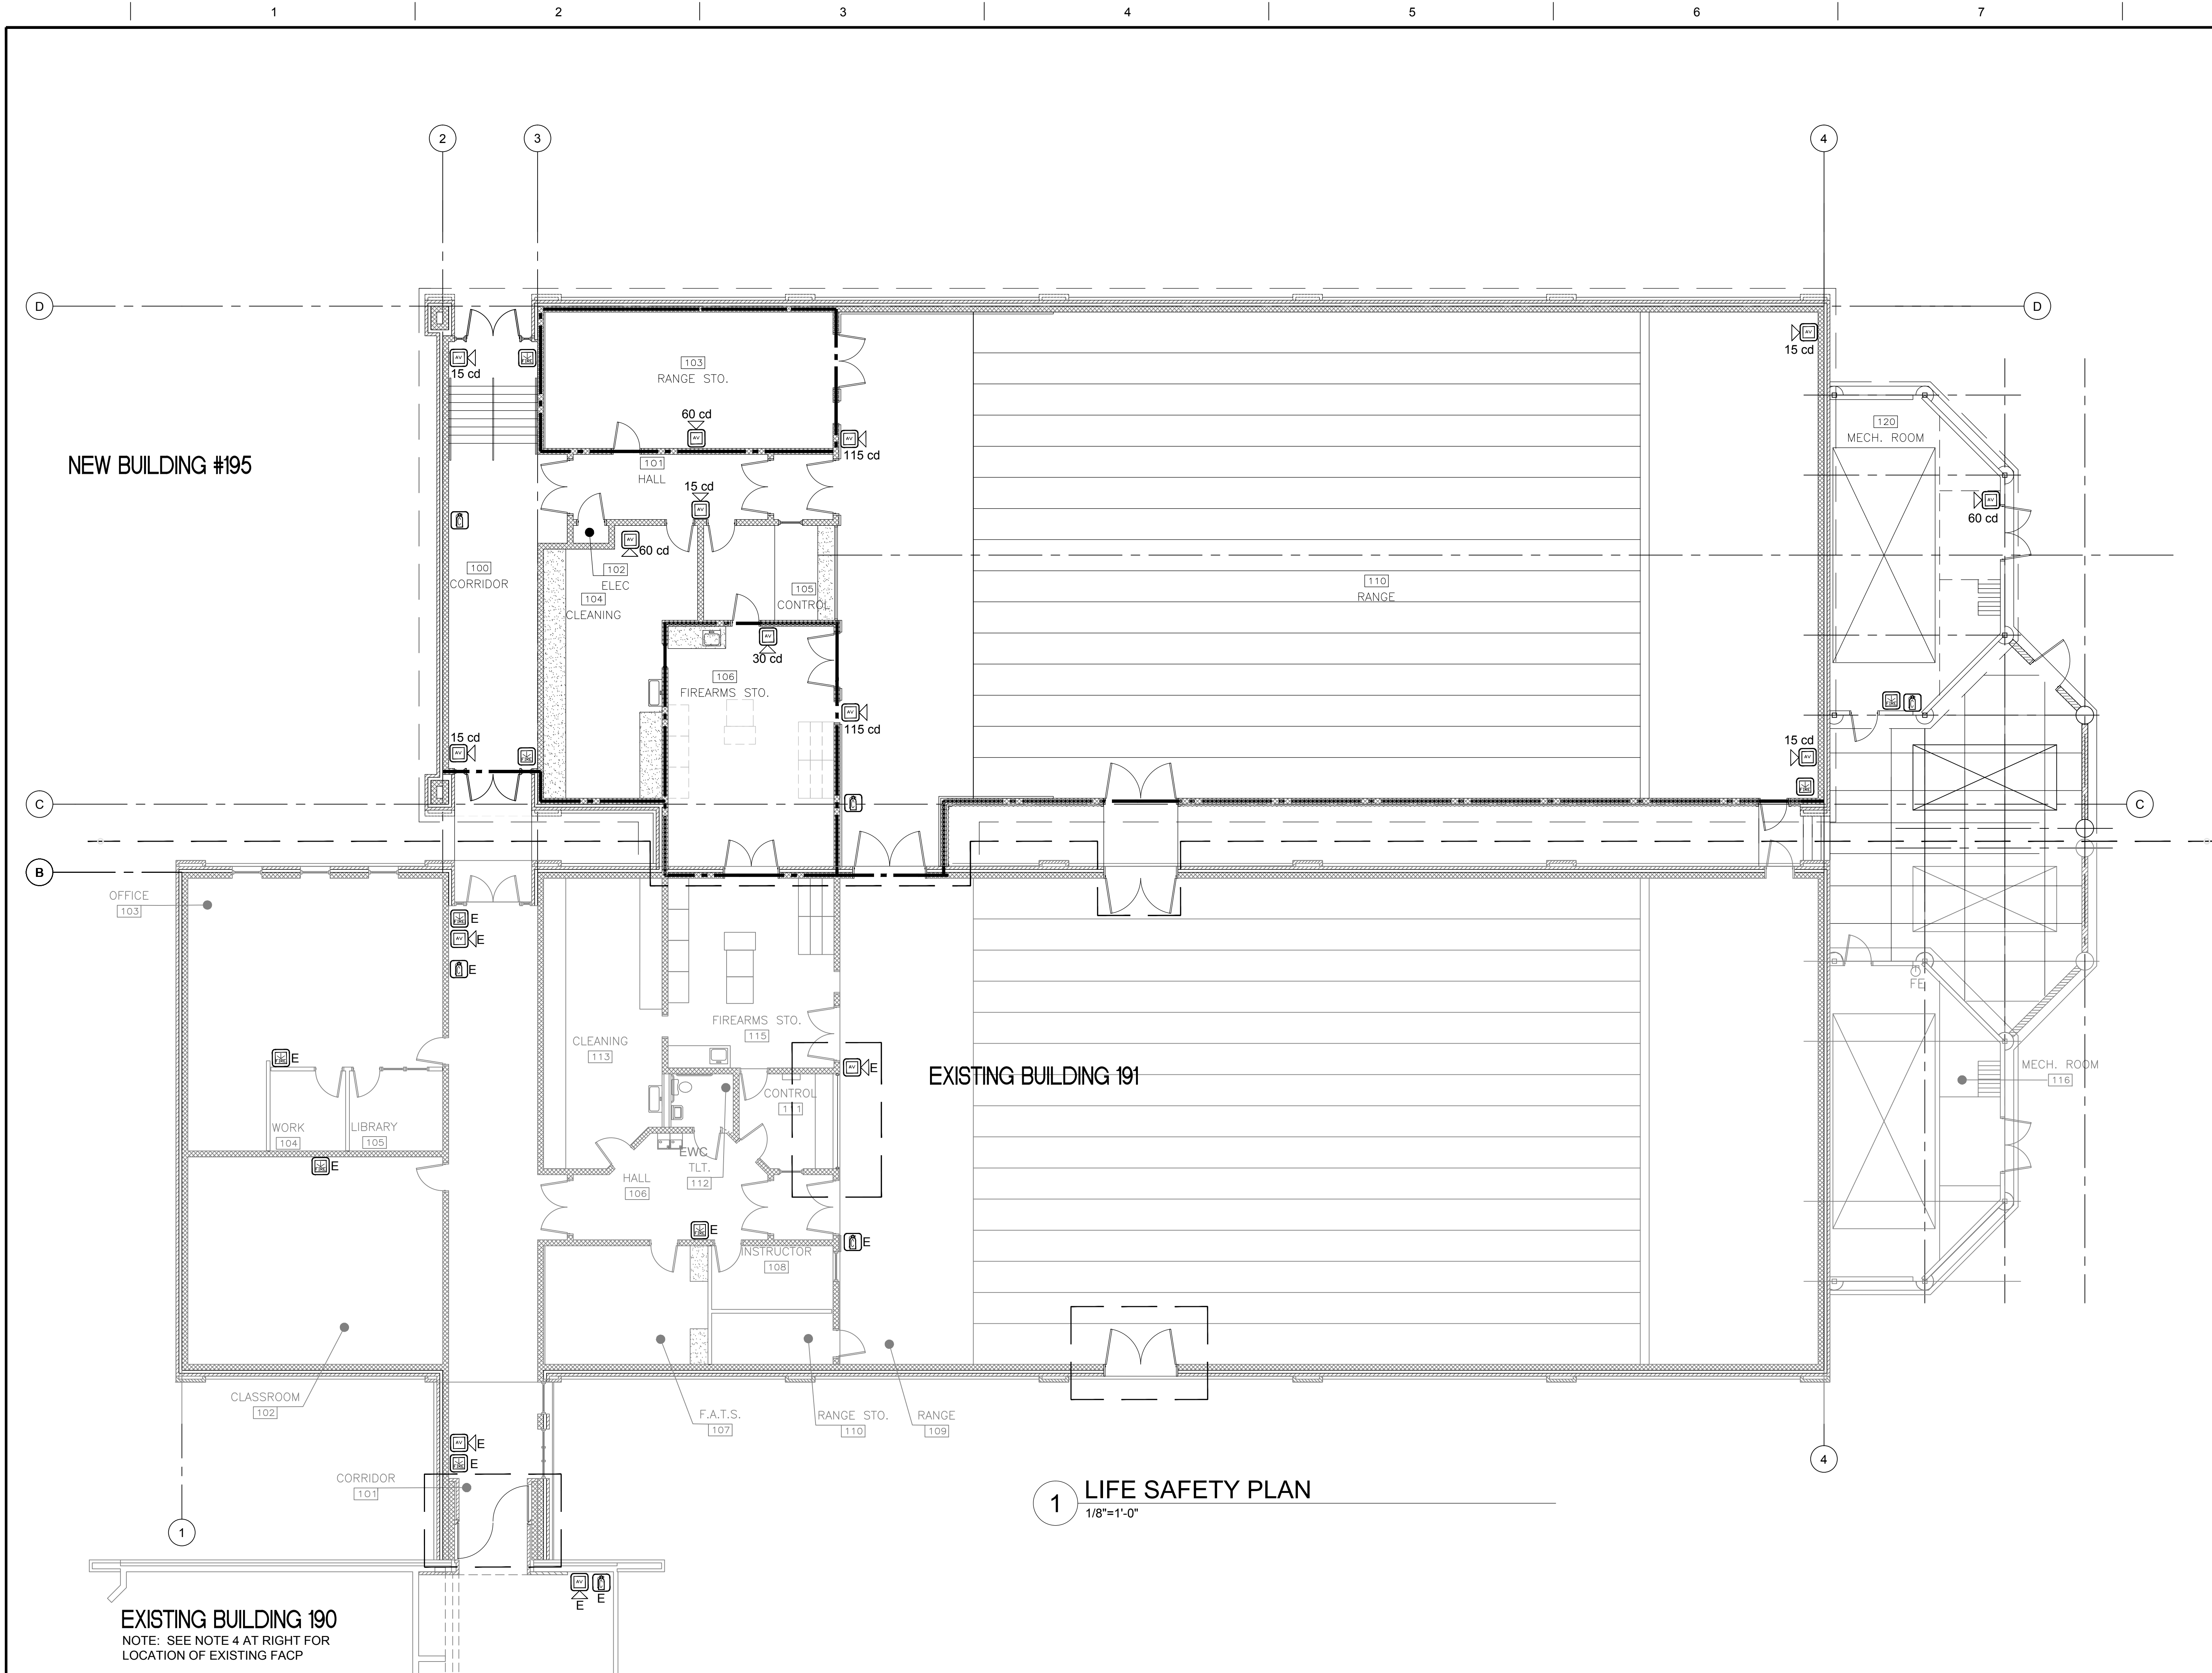

LEGEND

FIRE EXTINGUISHER

FIRE ALARM PULL STATION

AUDIO VISUAL DEVICE

E

DENOTES EXISTING

CODES

APPLICABLE CODES (LATEST EDITIONS):
INTERNATIONAL FIRE CODE
ADA AND ABA ACCESSIBILITY GUIDELINES
NFPA 101 LIFE SAFETY CODE
NFPA 72 NATIONAL FIRE ALARM AND SIGNALING CODE

- FIRE ALARM NOTES
1.

ALL WORK SHALL BE IN ACCORDANCE WITH THE VA FIRE PROTECTION DESIGN GUIDE AND NFPA 72.
2.

EXTEND THE EXISTING FIRE ALARM SYSTEM WHICH COVERS BUILDINGS 190 AND 191 INTO THE NEW BUILDING 195. PROVIDE DEVICES AS SHOWN.
3.

CIRCUITS SHALL BE CLASS B.
4.

THE EXISTING FACP IS LOCATED JUST OUTSIDE ROOM 216 ON THE SECOND FLOOR OF BUILDING 190. PROGRAM THE EXISTING SYSTEM FOR THE NEW DEVICES.
5.

ALL NEW FIRE ALARM DEVICES AND EQUIPMENT SHALL BE EDWARDS EST TO MATCH EXISTING.
6.

EXISTING FIRE ALARM SYSTEM OUTAGES SHALL BE KEPT TO A MINIMUM AND COORDINATED WITH THE COR 48 HOURS IN ADVANCE OF ANY OUTAGE. THE SYSTEM SHALL BE PLACED IN SERVICE AT THE END OF EACH WORK DAY OR THE CONTRACTOR SHALL PROVIDE A ROVING FIRE WATCH 24 HRS A DAY UNTIL THE OUTAGE IS COMPLETE.
7.

THE CONTRACTOR IS RESPONSIBLE FOR VERIFYING THE LOCATION OF ANY EXISTING DEVICES SHOWN.
8.

NO FIRE ALARM DEVICES ARE TO BE LOCATED DOWN RANGE OF THE SHOOTERS FIRING STATIONS WITHIN THE FIRING RANGE.

1 LIFE SAFETY PLAN
1/8"=1'-0"

0 4' 8' 16'

SCALE: 1/8" = 1'-0"

PLAN NORTH

TRUE NORTH

CONSTRUCTION DOCUMENTS
UNSPRINKLERED

CONSULTANTS:		ARCHITECT/ENGINEERS:		Drawing Title FIRE PROTECTION PLAN	Project Title LETC FIRING RANGE SITE ADAPTATION	Project Number 598-12-207	CENTRAL ARKANSAS VETERANS AFFAIRS HEALTHCARE SYSTEM
				Approved: Project Director	Location NORTH LITTLE ROCK, ARKANSAS	Building Number 195	
Revisions:		Date		Date 10-10-2014	Checked MADDY	Drawn MADDY	
Date		Date		Date		FP001	Department of Veterans Affairs
Date		Date		Date		Dwg. 58 of 58	