


GENERAL NOTES:

- A. ALL EXISTING PNEUMATIC THERMOSTATS IN SCOPE OF WORK AREAS SHALL BE REPLACED WITH NEW WIRELESS PNEUMATIC THERMOSTATS (WPTs). LOCATIONS INDICATED ON PLANS ARE APPROXIMATE AND SHALL BE FIELD VERIFIED FOR EXACT LOCATION, VENTURING HEIGHT, AND ACCESSIBILITY.
- B. ACCESS TO ROOMS SHALL BE SCHEDULED WITH VA CORP AND DEPARTMENT STAFF. SUBMIT PROPOSED SCHEDULE TO VA FOR REVIEW WITHIN 10 BUSINESS DAYS OF NOTICE TO PROCEED. AREAS CONSIDERED CRITICAL, OR LIMITED AVAILABILITY SHALL BE COORDINATED WITH THE VA DURING THE DEVELOPMENT OF THE SCHEDULE.
- C. FINAL QUANTITIES AND LOCATIONS OF WIRELESS REPEATERS SHALL BE DETERMINED BY THE CONTRACTOR AND VENDOR IN ORDER TO GUARANTEE A FULLY FUNCTIONAL SYSTEM.
- D. CONTRACTOR SHALL IDENTIFY THE TYPE OF EACH PNEUMATIC THERMOSTAT (i.e. DIRECT, REVERSE-ACTING, OTHER) AND REPLACE WITH THE CORRECT TYPE WIRELESS PNEUMATIC THERMOSTAT (WPT).
- E. REFER TO ELECTRICAL PLANS FOR ADDITIONAL INFORMATION.

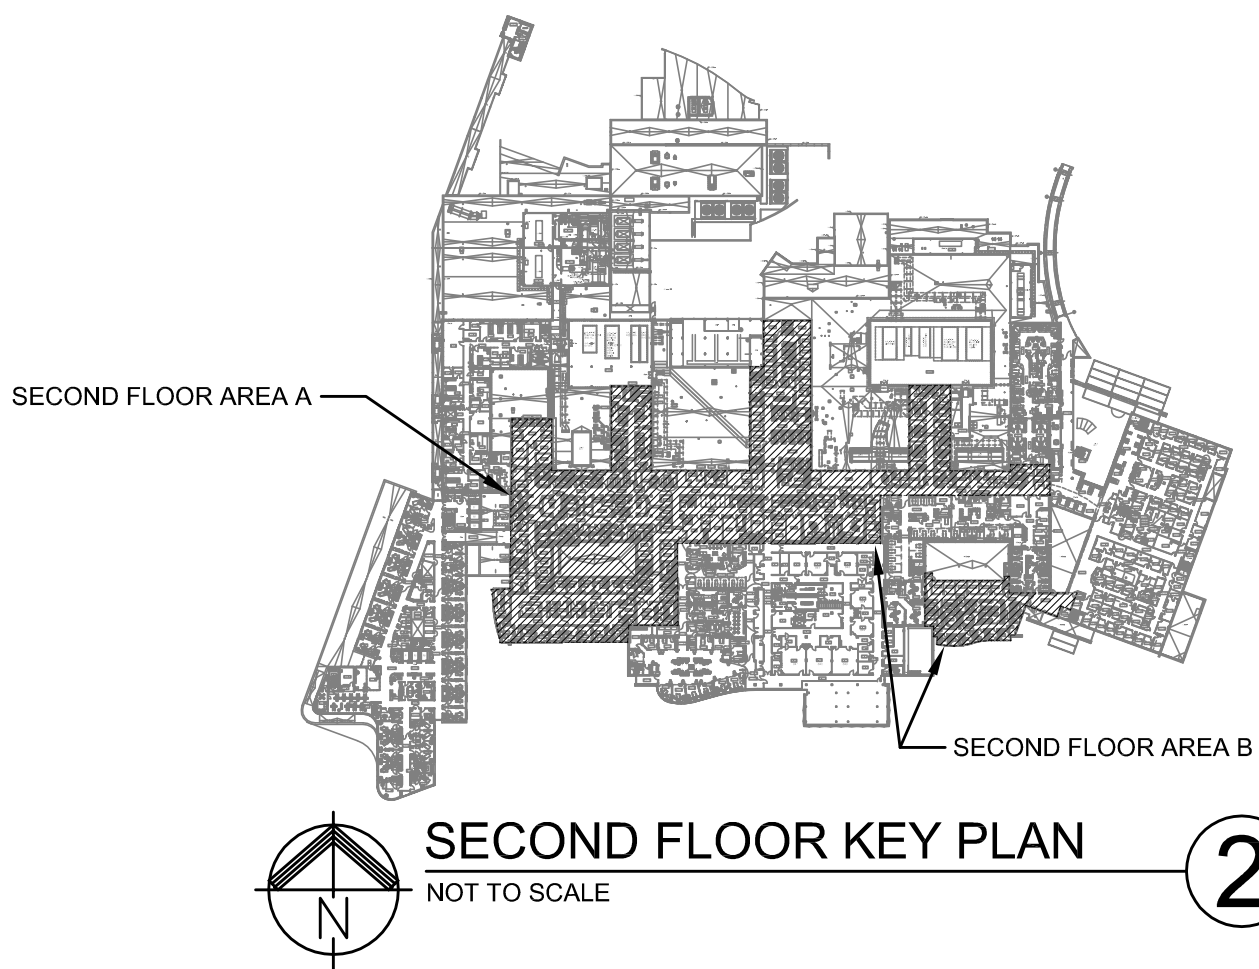

PARTIAL SECOND FLOOR PLAN - AREA A
SCALE: 1/16" = 1'0"

①

Bid Issue	03-30-15
Revisions:	Date



**FREDRICK, FREDRICK & HELLER
ENGINEERS, INC.**
672 EAST ROYALTON ROAD
BROADVIEW HTS., OHIO 44147
TEL. (440) 546-9696
FAX: (440) 546-9699

Approved: Project Director

Location

Drawn	LDH
-------	-----

Drawing Number

**Office of
Facilities
Management**



FULLY SPRINKLERED