


FOURTH FLOOR PLAN


SCALE: 1/16" = 1'0"



0' 8' 16' 32' 64'

DEDUCT ALTERNATE 2 NOTES:

- A. IF DEDUCT ALTERNATE 2 IS ACCEPTED, THIS DRAWING SHALL SUPERSEDE DRAWING 1-ME6.
- B. DEDUCT ALTERNATE 2 WILL RESULT IN ZERO WPT'S TO BE INSTALLED ON THE FOURTH FLOOR.

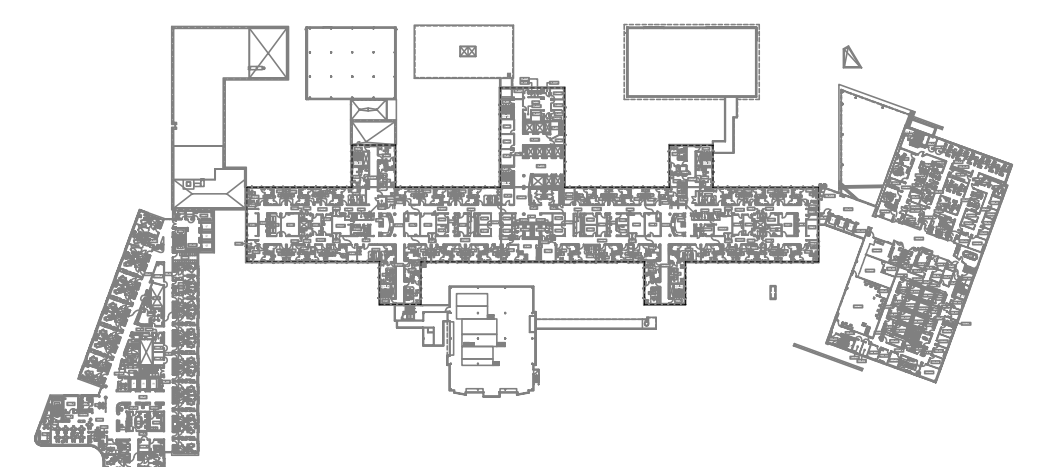

 **FOURTH FLOOR KEY PLAN**
NOT TO SCALE

FOR CONSTRUCTION

Bid Issue	03-30-15
Revisions:	Date

CONSULTANTS:

**ARCHITECT/ENGINEER:**

**FREDRICK, FREDRICK & HELLER
ENGINEERS, INC.**
672 EAST RAYLTON ROAD
BROADVIEW HTS., OHIO 44147
TEL: (440) 546-9898
FAX: (440) 546-9899

Drawing Title
**DEDUCT ALTERNATE 2
FOURTH FLOOR PLAN**

Approved: Project Director

Project Title

**CONVERT PNEUMATIC
VAV BOXES TO DDC
CONTROL**

Location	

Date _____

Checked	
---------	--

Drawn	1.74
-------	------

Project Number
541-15-202

Building Number	1
-----------------	---

	Drawing Number

1-ME6-ALT

**Office of
Facilities
Management**

