

DRAWING INDEX

GENERAL DRAWINGS

GI000	COVER SHEET
GI001	DRAWING INDEX

CIVIL DRAWINGS

C001	LEGENDS, NOTES AND OVERALL PLAN
CD101	EXISTING CONDITIONS AND DEMOLITION PLAN
CI101	SITE LAYOUT PLAN


STRUCTURAL DRAWINGS

SB101 FOUNDATION PLANS


ELECTRICAL DRAWINGS

E001	ELECTRICAL LEGEND, NOTES, DIAGRAMS, AND DETAILS
ES101	PARTIAL SITE PLAN, ENLARGED PLANS AND NOTES - POWER
EP401	EXTERIOR EQUIPMENT PLAN AND ELEVATIONS


VICINITY MAP

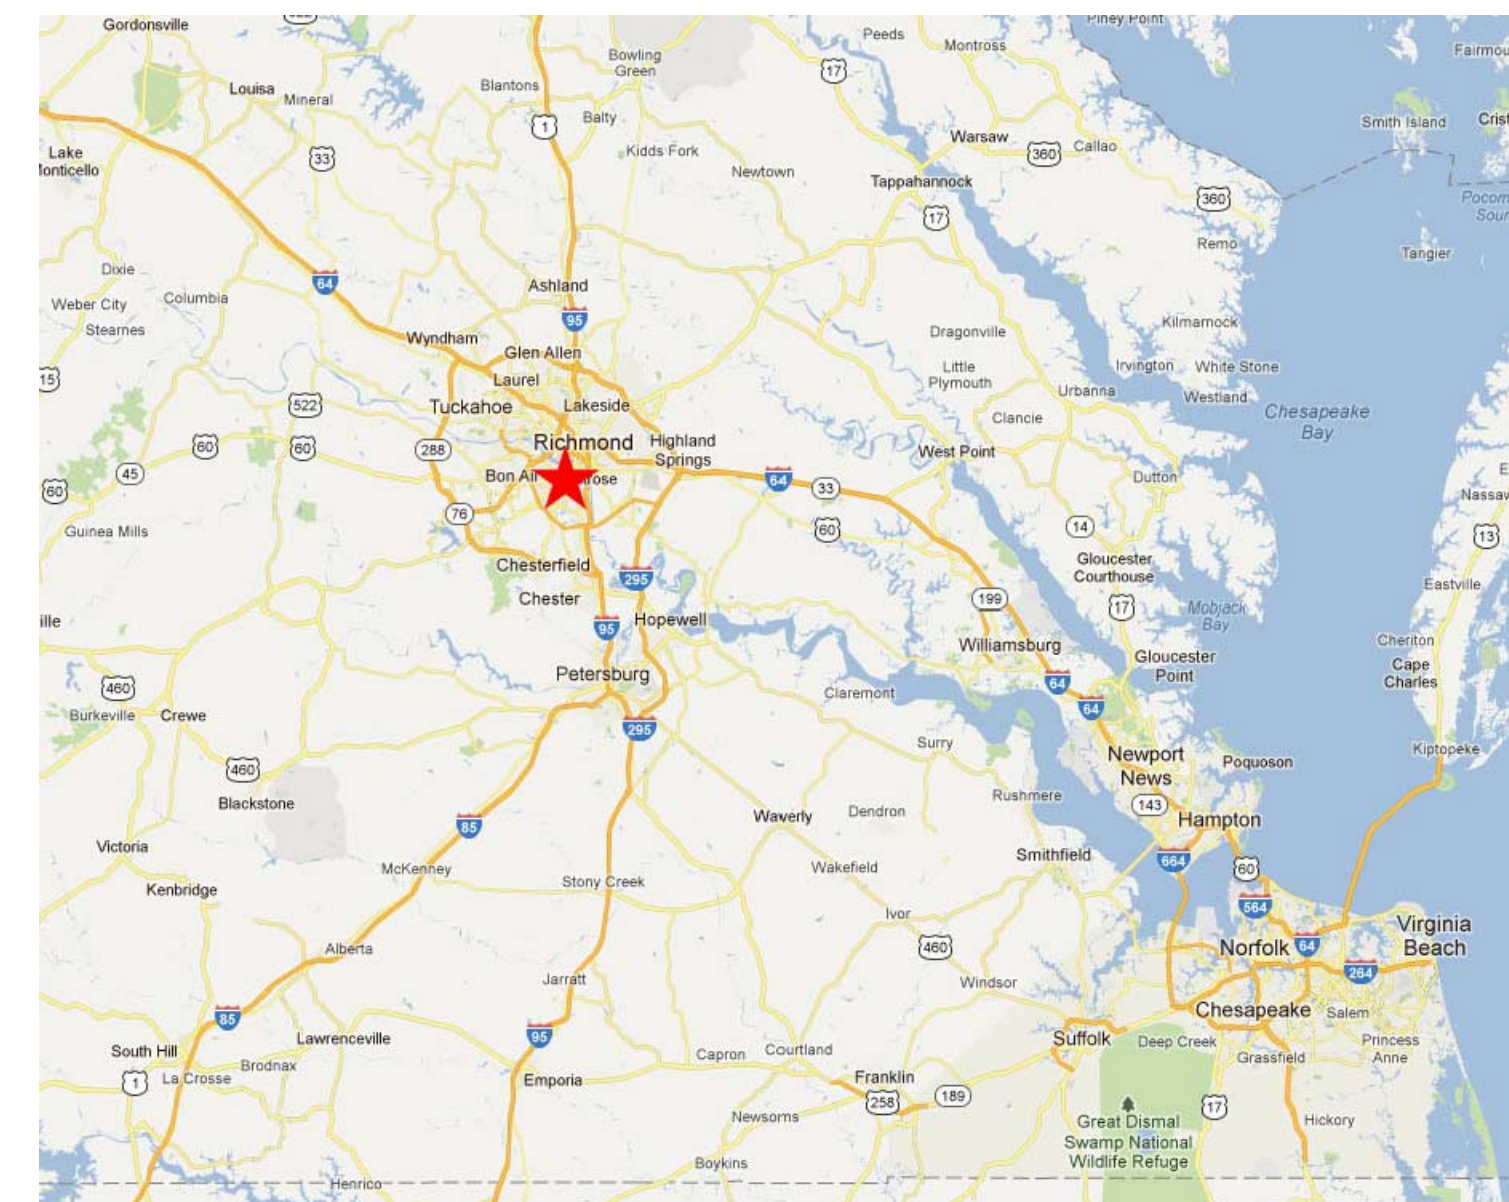

LOCATION MAP

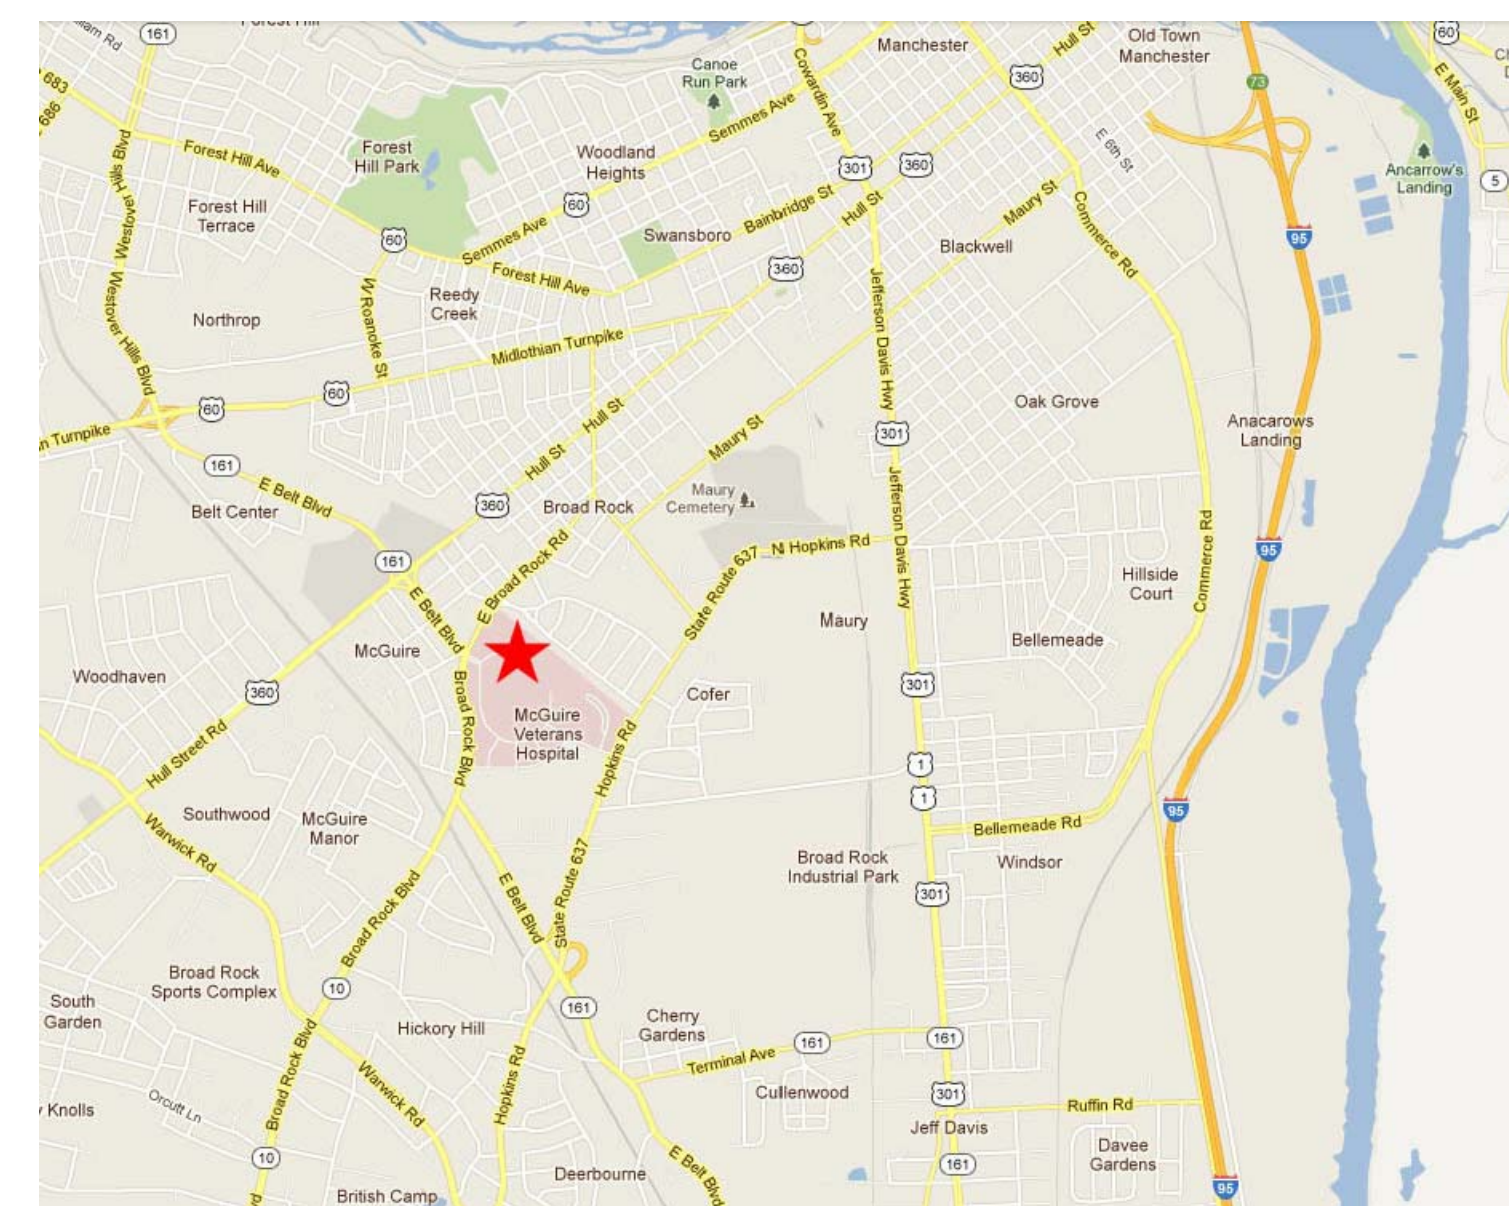

KEY PLAN

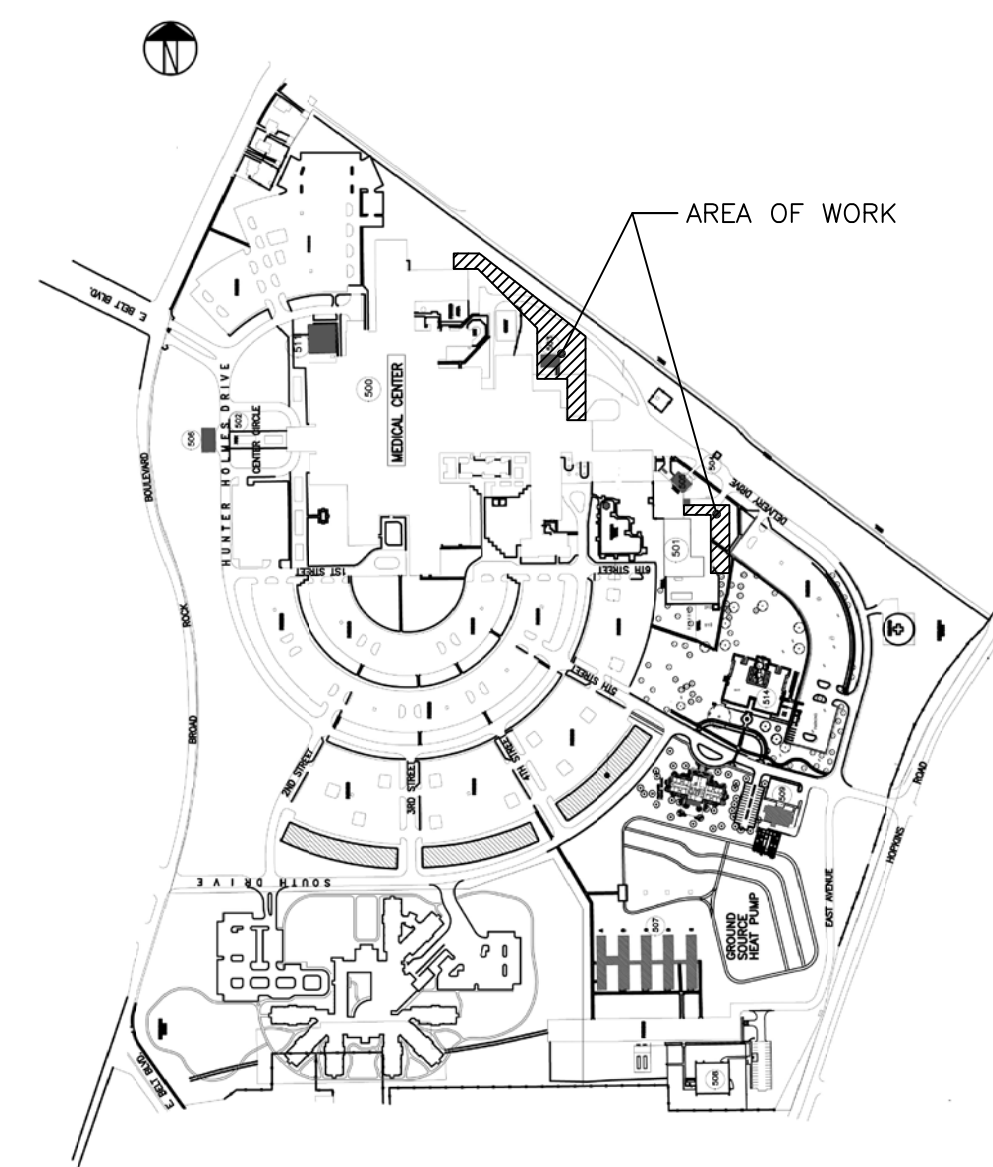

STATEMENT OF BID ITEM(S)

A. Bid ITEM 1 (BASE BID): All work inclusive of all bid alternates as indicated on the drawings and specifications for all phases of the project..

Work includes general construction, roads, walks, grading, mechanical and electrical work, utility systems, necessary removal of existing structures, construction and certain other items as follows:

Install two 13.2 kv generators in a sound attenuating enclosure with base mounted fuel tanks, and associated switchgear in accordance with construction documents dated November 25, 2014. CONTRACT COMPLETION TIME: 270 CALENDAR DAYS

1	ADDENDUM 1 - REVISED SWITCHGEAR & ENCLOSURE	04.22.15
Revisions:		Date

CONSULTANT ENGINEER:
CLARK•NEXSEN
Architecture & Engineering
6160 KEMPSVILLE CIRCLE
NORFOLK, VIRGINIA 23502
757-455-5800 FAX 757-455-5638
WWW.CLARKNEXSEN.COM

SEAL:

ARCHITECT:



123 BRUTON COURT, SUITE 100
CHESAPEAKE, VA 23322
PHONE: 757.389.5518

Drawing Title	DRAWING INDEX
---------------	---------------

Approved: Project Director

Project Title	Upgrade Generators HH McGuire VA Medical Center
---------------	--

Project Number	652-14-103
Building Number	501

Location	Richmond, Virginia
----------	--------------------

Date
11.25.14
FOR CONSTRUCTION

☐ Check

Drawn

Drawing Number

G100

Dwg. 2 of

Office of
Construction
and Facilities
Management

