


TITLE PAGE

Project 506-15-121 "Conduct Site Preparations for Modular Buildings"

Project Location

Ann Arbor VA Medical Center
Ann Arbor, Michigan

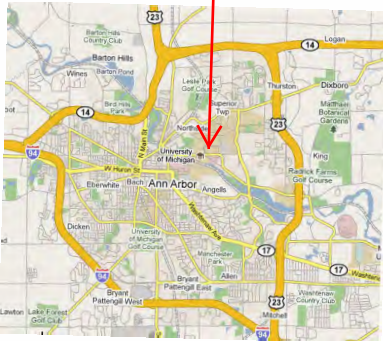

LEGEND:

- = Section corner
- ☐ = Catchbasin
- ⊙ = Storm Manhole
- ⊖ = Flattop Catchbasin
- ⊙ = Sanitary Manhole
- ⊙ = Sanitary Cleanout
- ⊙ = Hydrant
- ⊙ = Water Valve
- ⊙ = Water Meter
- ⊙ = Water Manhole
- ⊙ = Well
- ⊙ = Gas Valve
- ⊙ = Gas Meter
- ⊙ = Sign
- ⊙ = Mailbox
- ⊙ = Soil Boring
- ⊙ = Electric Meter
- ⊙ = Electric Manhole
- ⊙ = Transformer
- ⊙ = Utility Pole
- ⊙ = Guy Pole
- ⊙ = Guy Wire
- ⊙ = Light Pole
- ⊙ = Telephone Manhole
- ⊙ = Telephone Pedestal
- ⊙ = AC Unit
- ⊙ = Post
- ⊙ = Monitoring Well
- ⊙ = Traffic Control Manhole
- ⊙ = Geothermal Manhole
- ⊙ = Fiber Optic Manhole
- ⊙ = Fiber Optic Manhole
- ⊙ = Test hole

- = E.O.I. END OF INFORMATION
- E — = U.G. ELECTRIC
- FO — = U.G. FIBER OPTIC
- = U.G. IRRIGATION
- G — = U.G. GAS
- SL — = U.G. STREET LIGHT
- T — = U.G. TELEPHONE
- UE — = U.G. TRAFFIC SIGNAL
- = U.G. UNKNOWN
- W — = U.G. WATER
- = U.G. STEAM
- = U.G. TUNNEL
- R — = U.G. STORM
- S — = U.G. SANITARY
- = U.G. OXYGEN LINE
- = U.G. FUEL LINE

PROJECT NO.	
506-15-121	
DATE:	10-27-2014
SCALE:	1" = 50'
BY:	kv
DWG:	


West Temporary
Modular Office Unit
Site Plan
Jeff Miller FMS



Department of
Veterans Affairs

VA Ann Arbor HealthCare System
Office of Construction and
Facilities Management

REVISIONS		DATE
1	Name Change	11/12/14
2	Add Legend	3/19/15
3		
4		

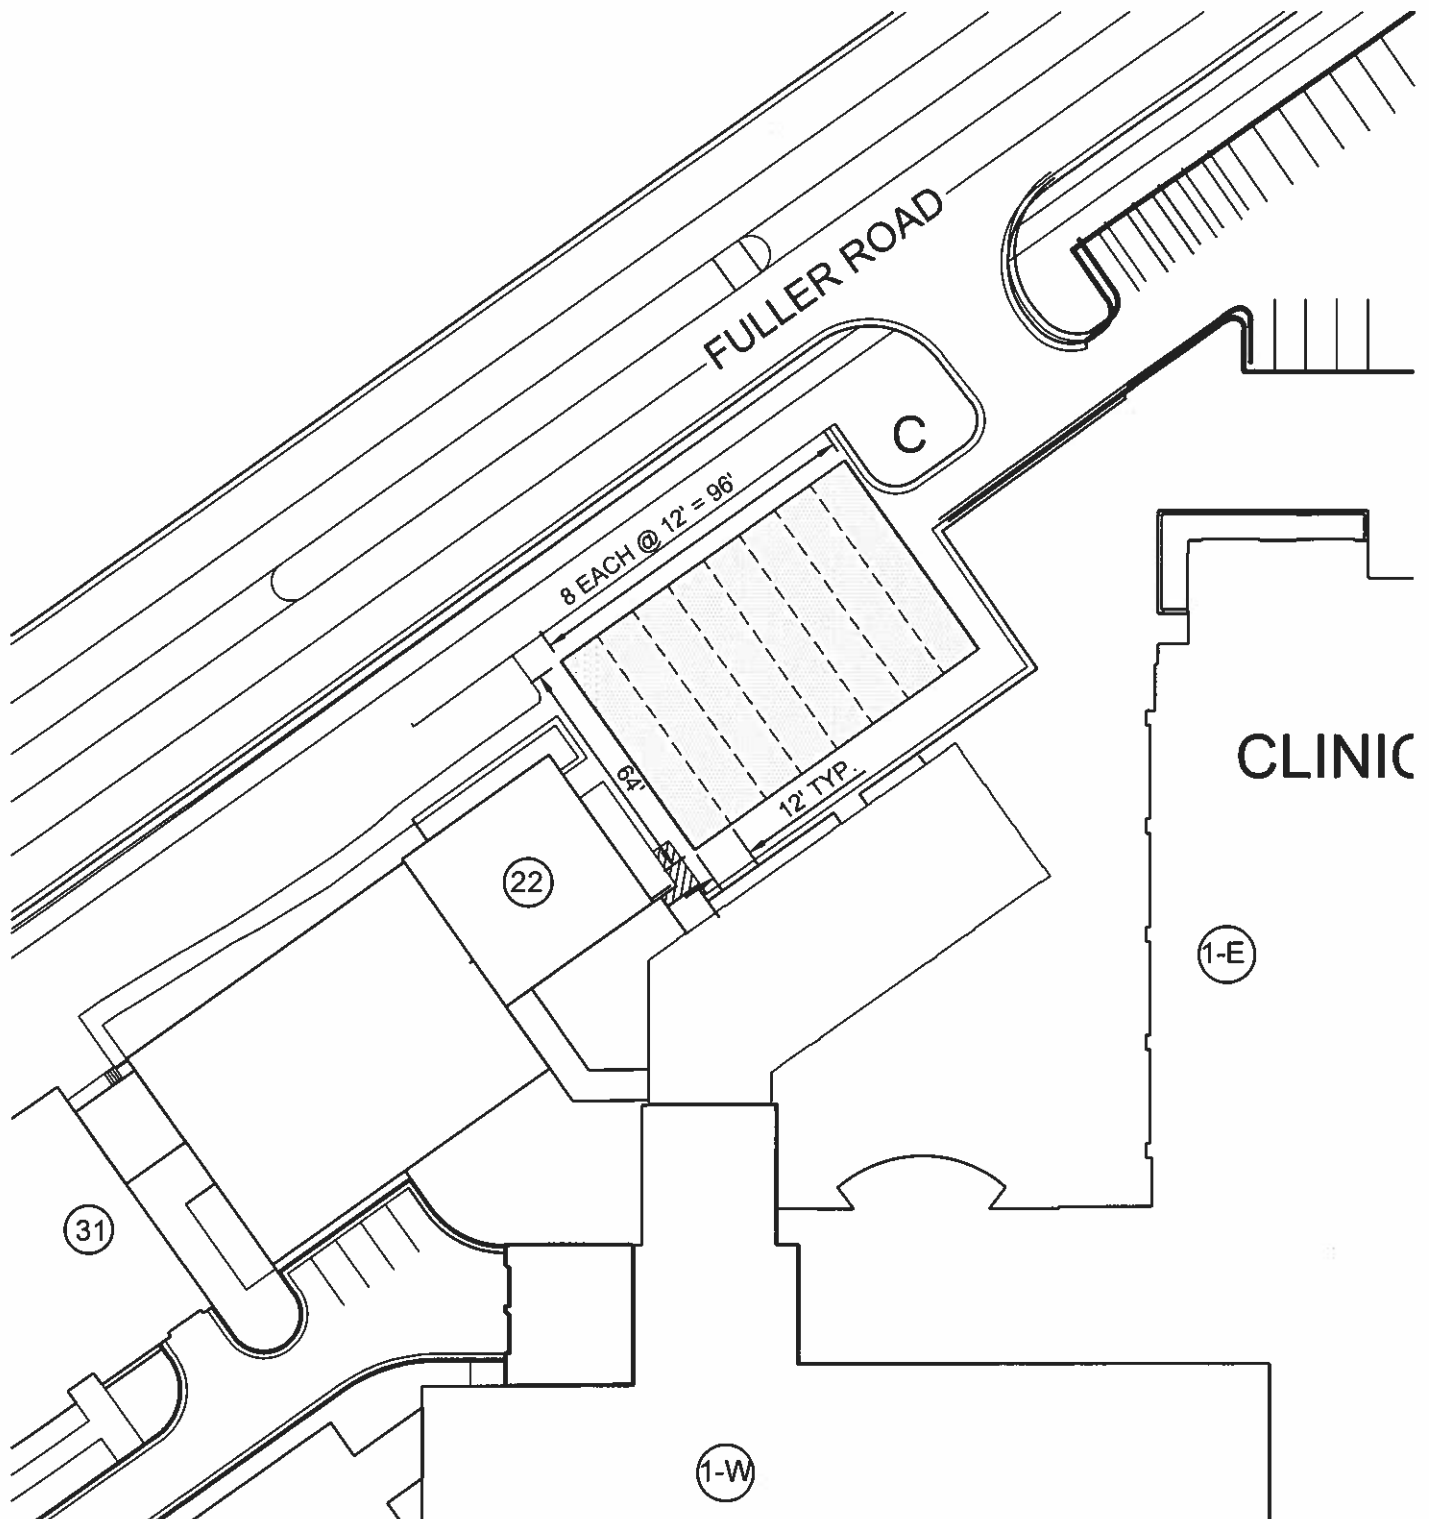

SITE PLAN : NORTH 
SCALE: 1" = 50'

PROJECT NO.
506-15-121
 DATE: **09-30-2014**
 SCALE: **1" = 50'**
 BY: kv DWG:


North Temporary
 Modular Office Unit
 Site Plan
Jeff Miller FMS



VA Ann Arbor HealthCare System
 Office of Construction and
 Facilities Management

REVISIONS		DATE
1	Name Change	11/12/14
2		
3		
4		

Central Rail Station
 1800 West Main Street
 Ann Arbor, MI 48106
 Phone: 313.763.1000
 Fax: 313.763.1001
 Website: www.annarbor.org

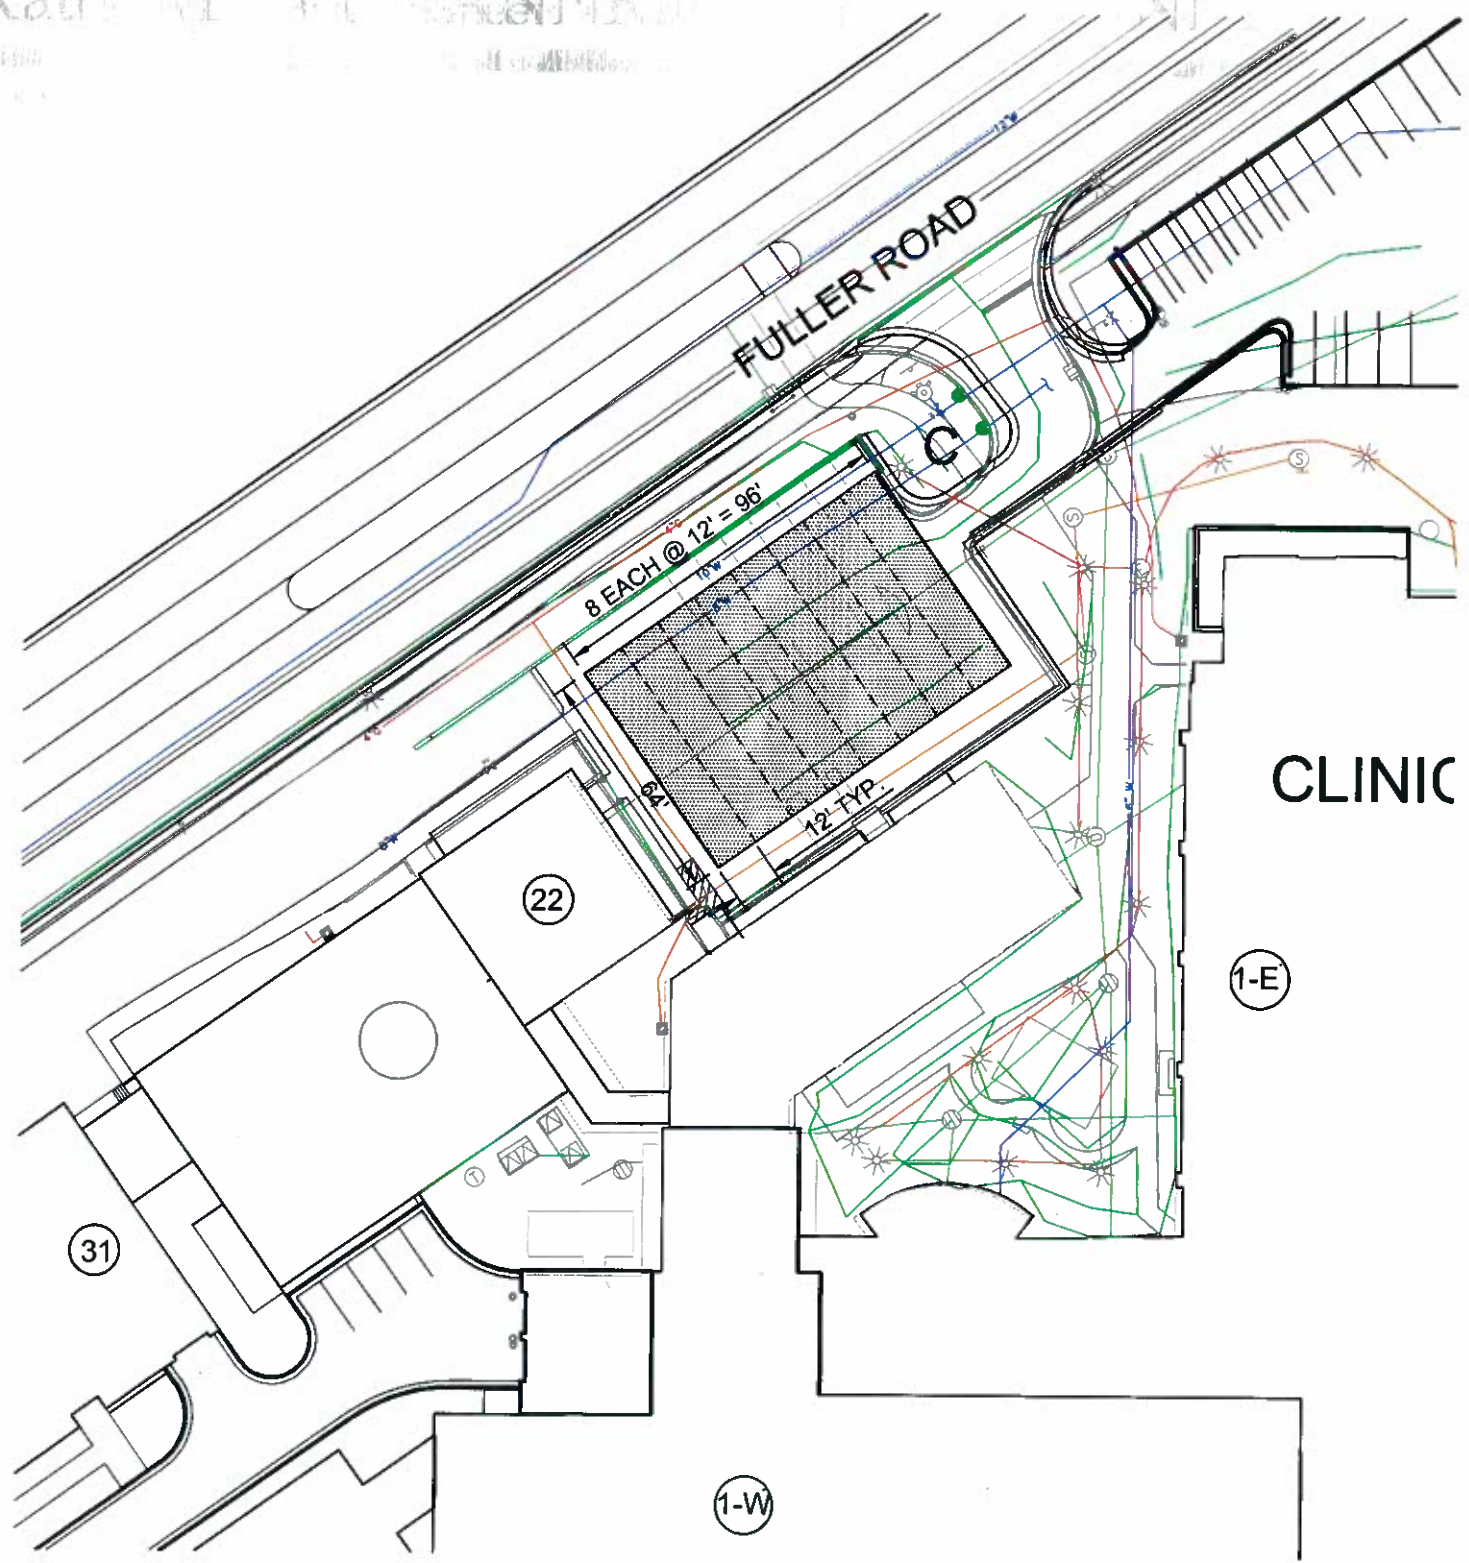

SITE PLAN : NORTH 
 SCALE: 1" = 50'

PROJECT NO.
 506-15-121
 DATE: 09-30-2014
 SCALE: 1" = 50'
 BY: kv DWG:


North Temporary
 Modular Office Unit
 Site Plan
Jeff Miller FMS




Department of
 Veterans Affairs


VA Ann Arbor HealthCare System
 Office of Construction and
 Facilities Management

REVISIONS		DATE
1	Name Change	11/12/14
2	Add Utilities	3/19/15
3		
4		

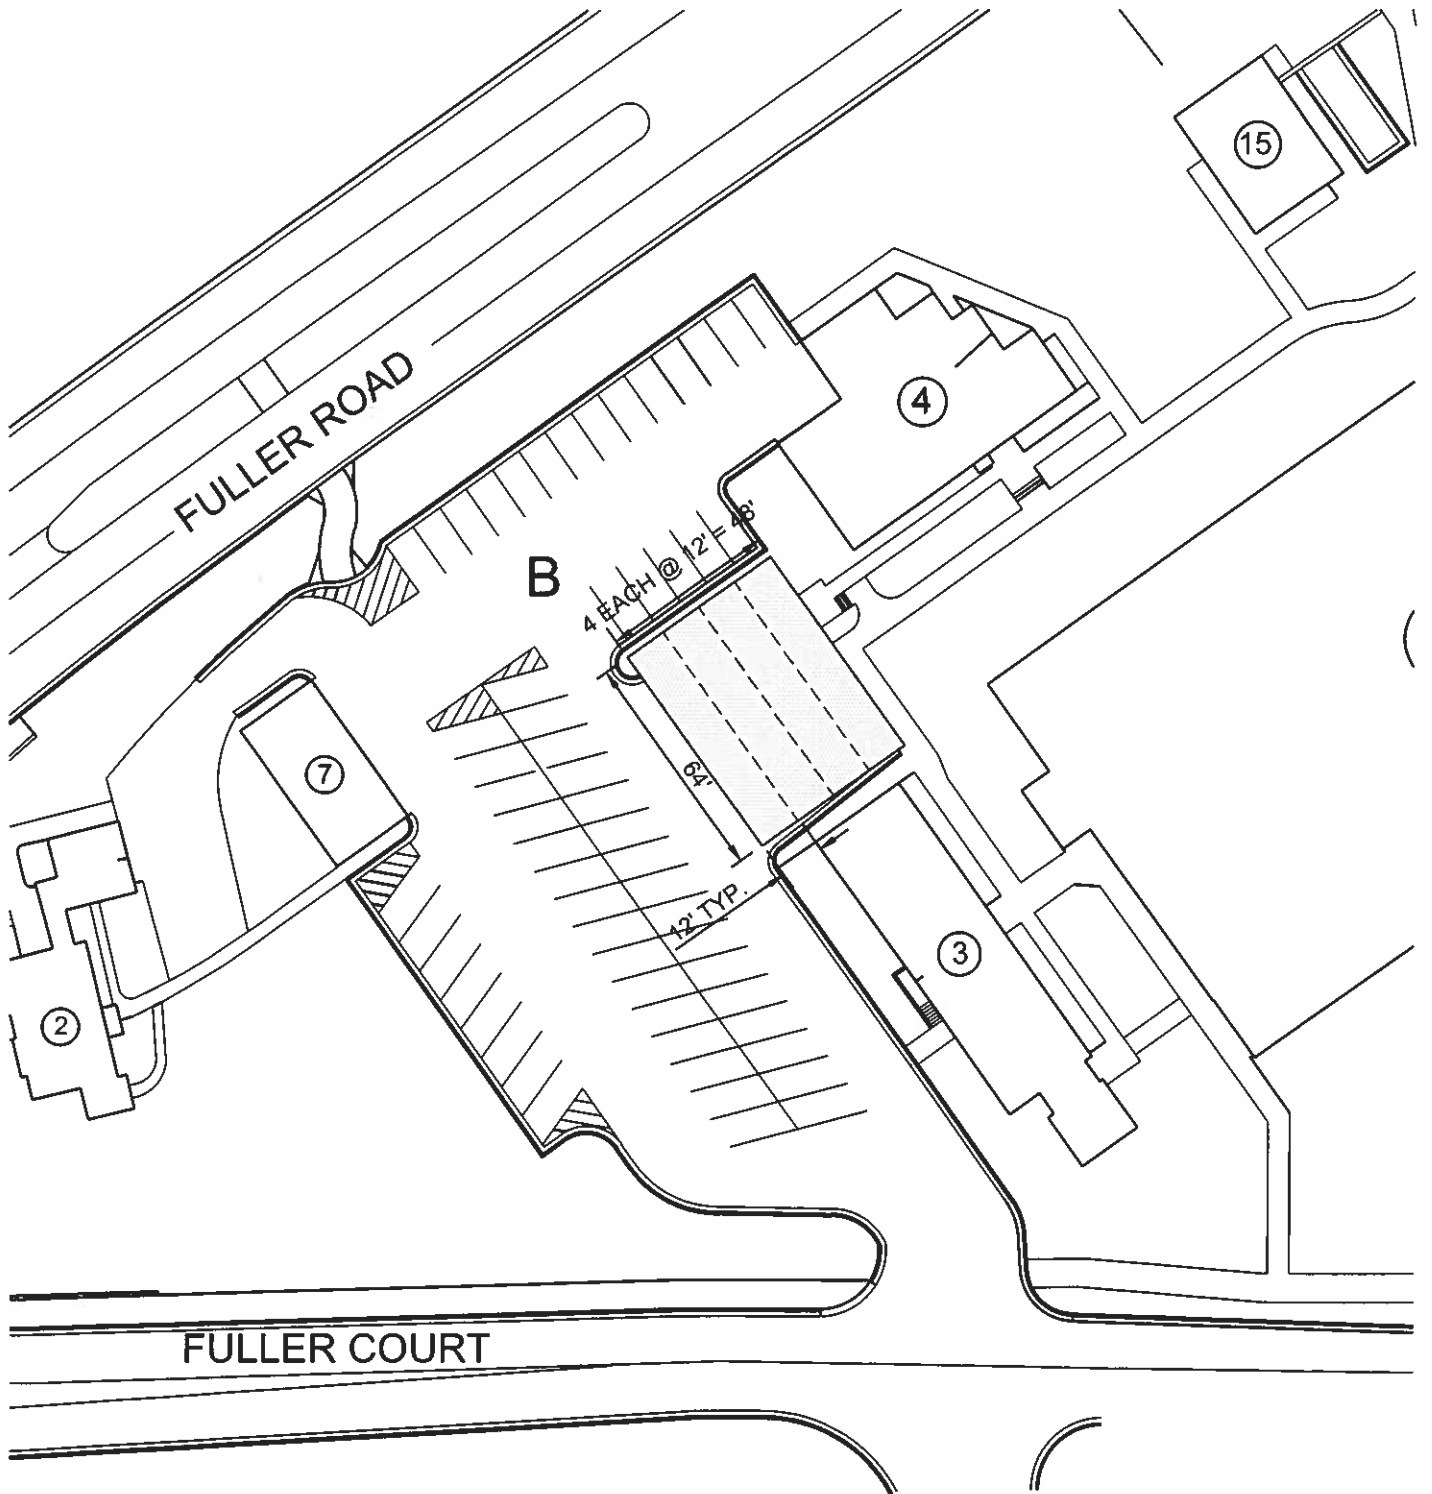

SITE PLAN : NORTH 
SCALE: 1" = 50'

PROJECT NO. 506-15-121	
DATE: 10-27-2014	
SCALE: 1" = 50'	
BY: kv	DWG:

 
West Temporary Modular Office Unit Site Plan	
	FMS



VA Ann Arbor HealthCare System
Office of Construction and
Facilities Management

REVISIONS	DATE
1 Name Change	11/12/14
2	
3	
4	

Dr. Wagon
10/25/2014
1/14/2015

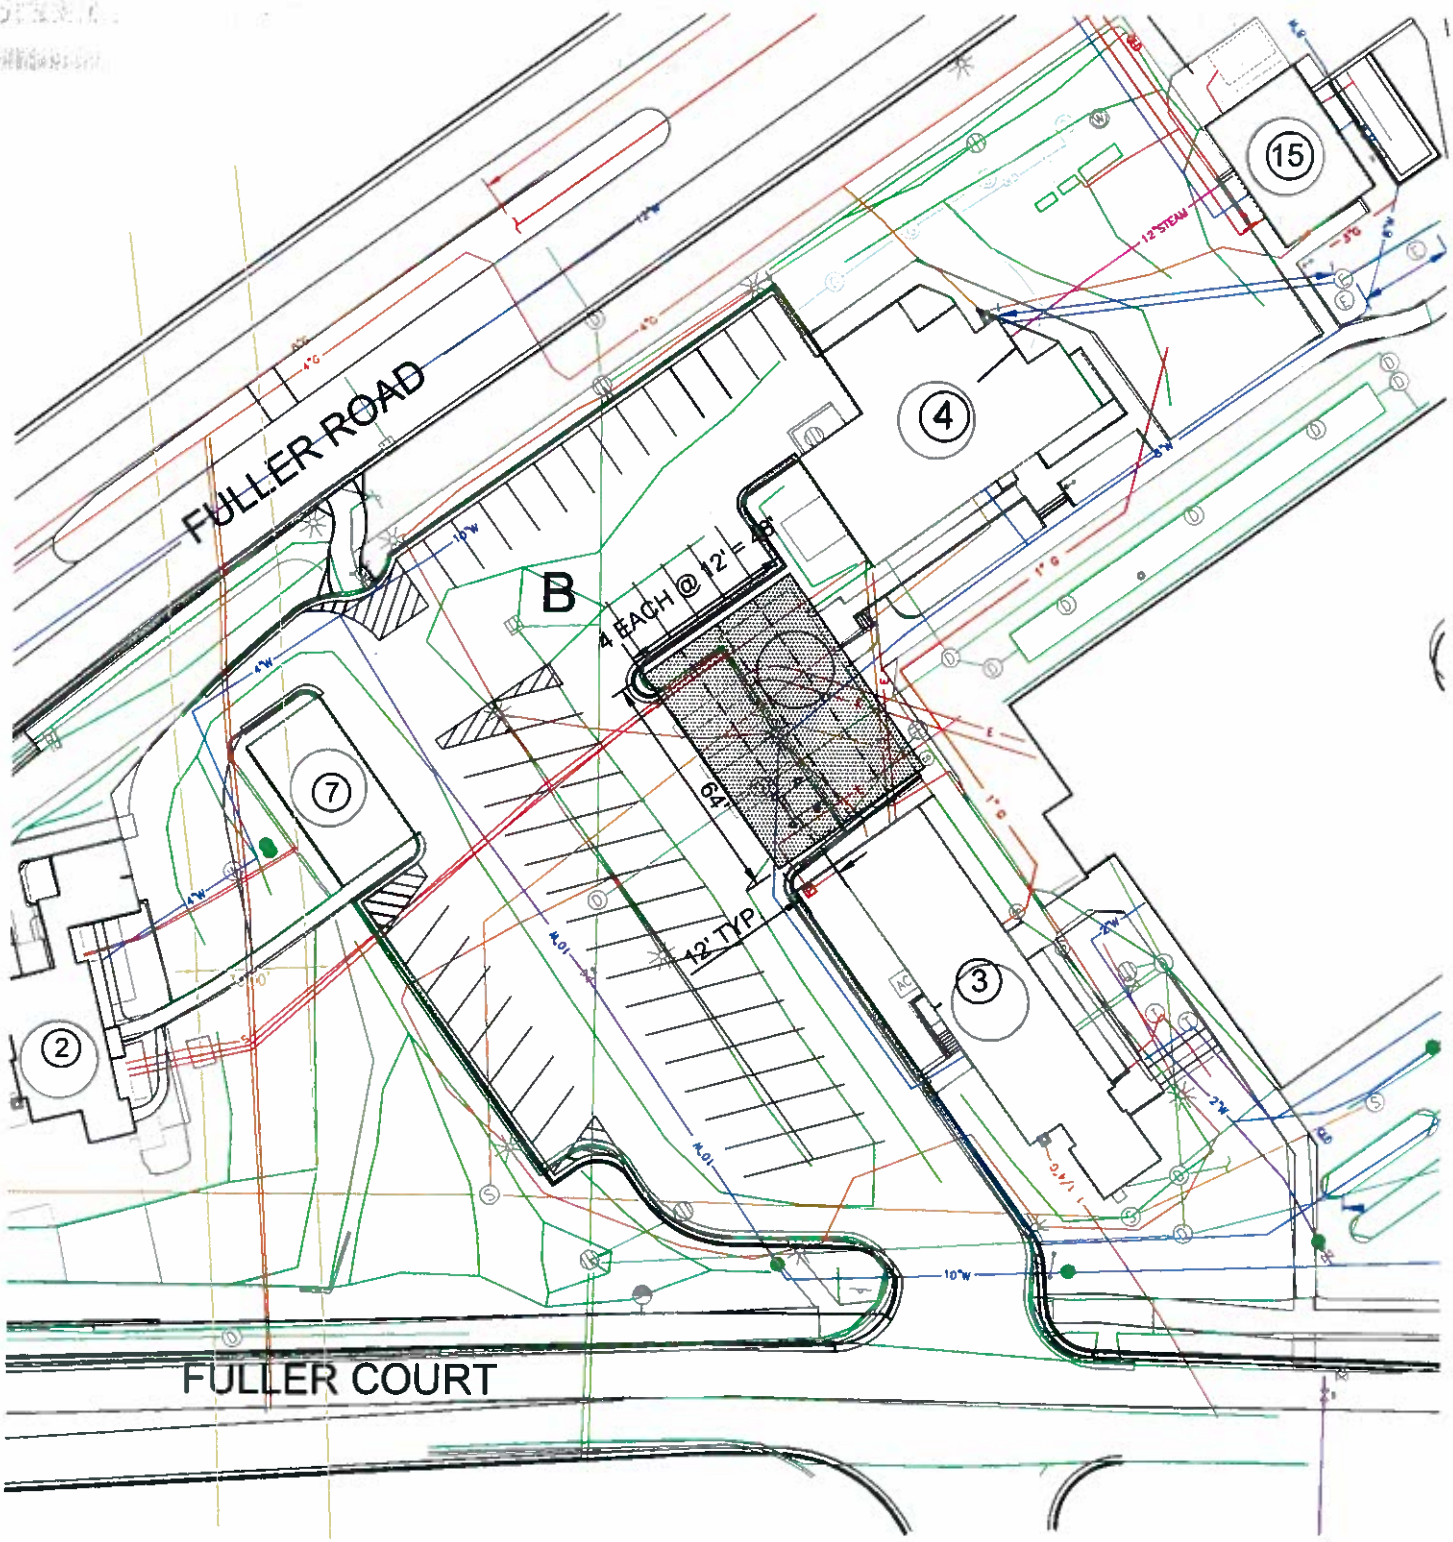

SITE PLAN : **NORTH** 

SCALE: 1" = 50'

PROJECT NO. 506-15-121 DATE: 10-27-2014 SCALE: 1" = 50' BY: kv DWG:	West Temporary Modular Office Unit Site Plan  FMS	 Department of Veterans Affairs	VA Ann Arbor HealthCare System Office of Construction and Facilities Management	<table border="1" style="width: 100%; border-collapse: collapse;"> <thead> <tr> <th style="width: 80%;">REVISIONS</th> <th style="width: 20%;">DATE</th> </tr> </thead> <tbody> <tr> <td>1 Name Change</td> <td>11/12/14</td> </tr> <tr> <td>2 Added Utilities</td> <td>3/19/15</td> </tr> <tr> <td>3</td> <td></td> </tr> <tr> <td>4</td> <td></td> </tr> </tbody> </table>	REVISIONS	DATE	1 Name Change	11/12/14	2 Added Utilities	3/19/15	3		4	
REVISIONS	DATE													
1 Name Change	11/12/14													
2 Added Utilities	3/19/15													
3														
4														